



MATCH LINE "A" SEE SHEET E-5

BUILDING 200

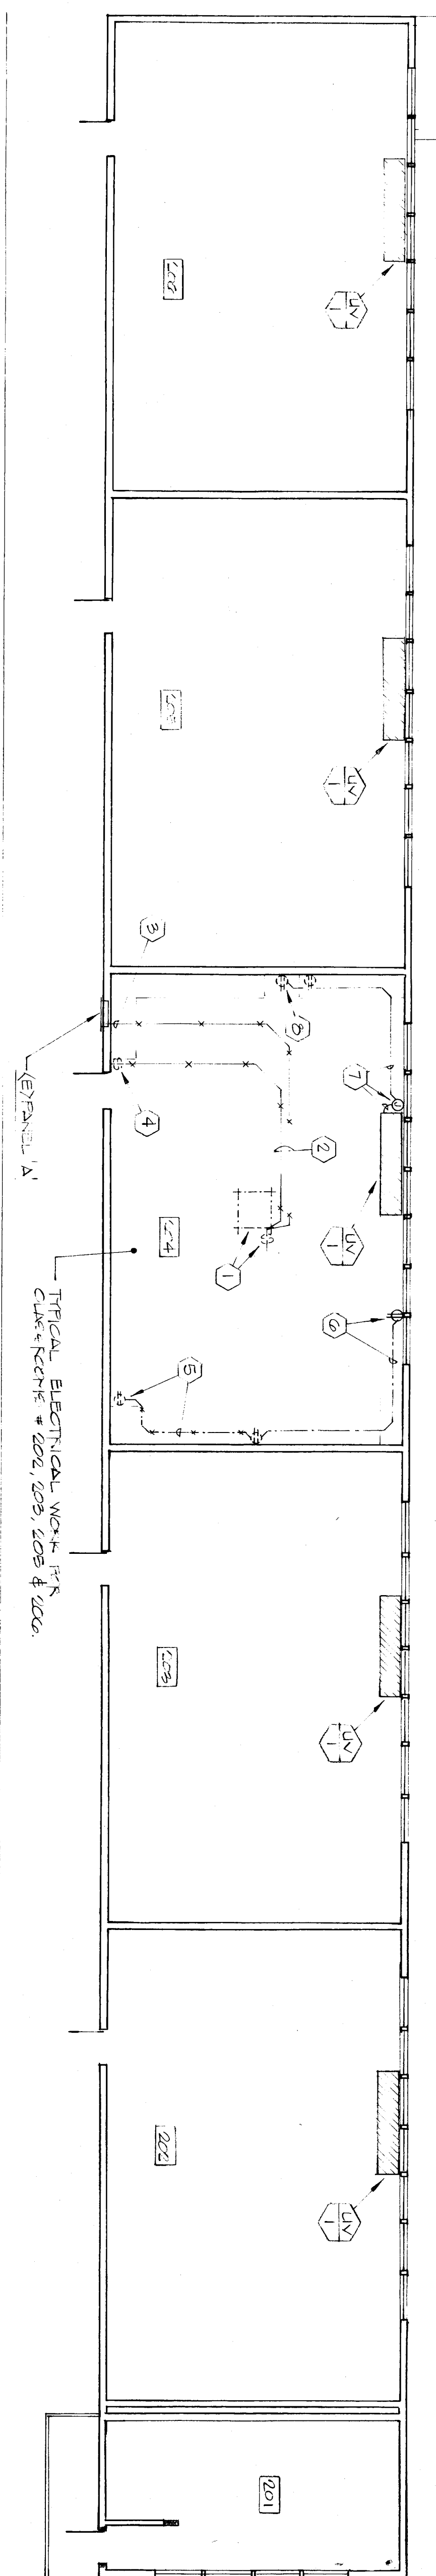

BUILDING 300

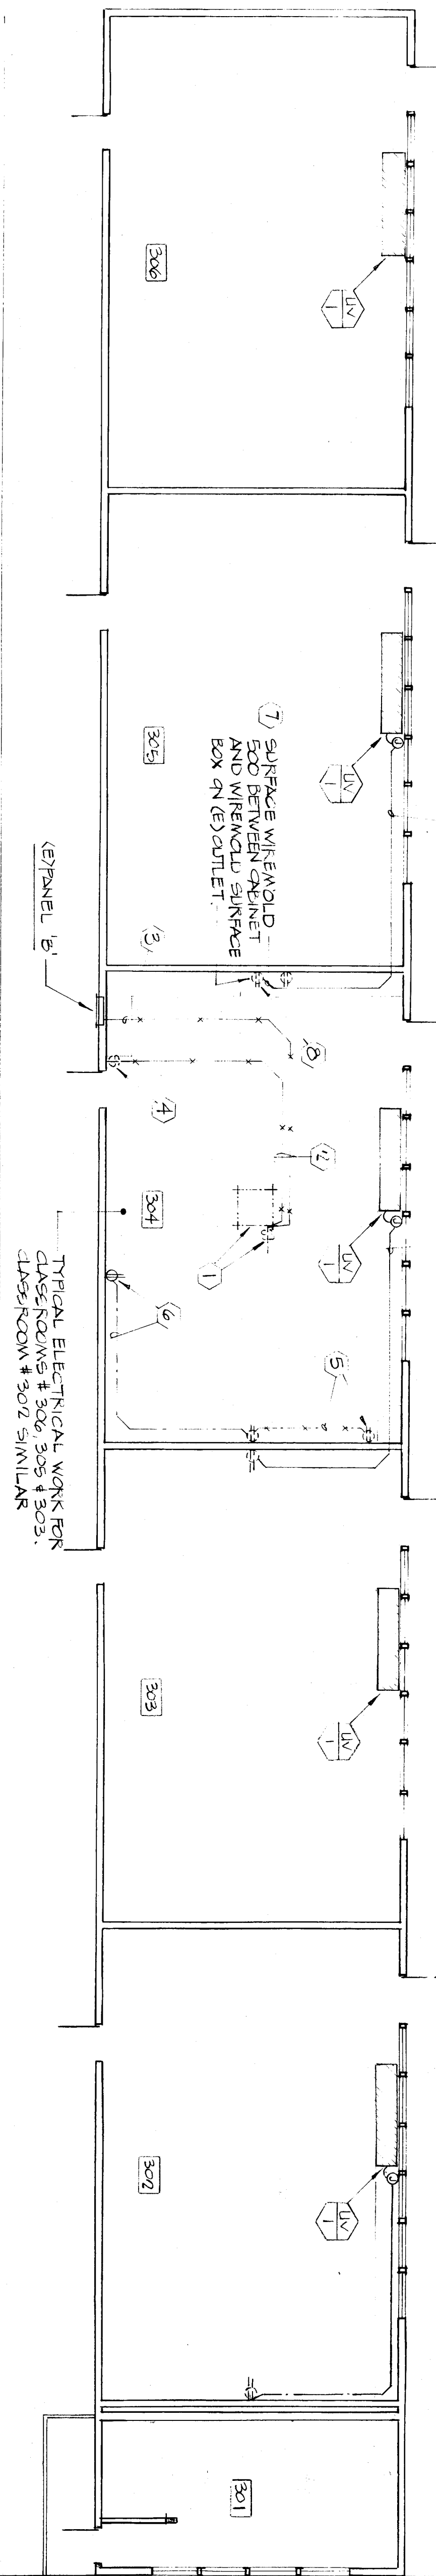

MATCH LINE "B" SEE SHEET E-7
POWER FLOOR PLANS

1/8" = 1'-0"

- REFERENCE NOTES (THIS SHEET ONLY):
- 1) REMOVE EXISTING EVAP. COOLER THERO-SWITCH.
 - 2) REMOVE EXISTING RACEWAY.
 - 3) DISCONNECT EXISTING CIRCUIT AND CAP CONDUIT.
 - 4) REMOVE EXISTING SWITCH AND SURFACE WIREMOLD.
 - 5) EXISTING WIREMOLD TO REMAIN.
 - 6) SURFACE WIREMOLD BOX AND 500 RACEWAY.
 - 7) SURFACE WIREMOLD BOX AND 500 RACEWAY WITH 400 #12 FROM UNIT RENTILATED RACEWAY WIREMOLD AND CONNECT TO EXISTING EVAPORATIVE COOLER BREAKER.
 - 8) DISCONNECT EXISTING POWER TO FURNACE.

DATE: 1 FEB. 89

PROJECT: MT. VERNON MODERNIZATION

ARCHITECTS: bfgc inc.

PLANNERS: MT. VERNON MODERNIZATION

ENGINEER: INTERSTATE ENGINEERING, INC.

SCALE: 1/8" = 1'-0"

