



**KLASSEN CORPORATION**  
 Architecture  
 Construction  
 2021 Westwind Drive  
 Bakersfield, CA 93301  
 (805) 327-0875  
 (805) 327-0875 Fax

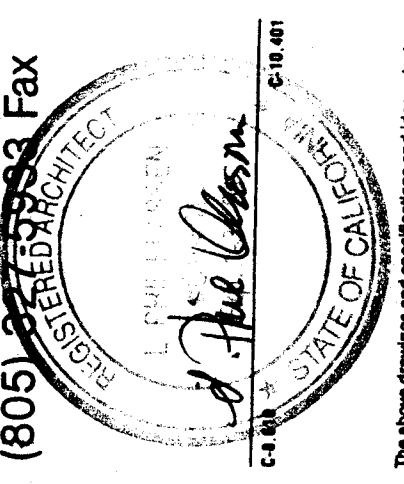



I am a duly Licensed Professional Engineer in the State of California and I hereby certify that the design and construction of the plumbing system described herein conforms to the requirements of the California Plumbing Code and the rules and regulations of the State Board of Plumbing Examiners. I am not responsible for the design and construction of any other plumbing system shown on this plan.

**BAKERSFIELD CITY SCHOOL DISTRICT  
 COLONEL HOWARD NICHOLS ELEMENTARY SCHOOL  
 MODERNIZATION PROJECT**  
 Sheet Title: **SITE PLAN (PLUMBING)**  
 COLONEL HOWARD NICHOLS ELEMENTARY SCHOOL  
 3401 RENEGADE AVENUE  
 BAKERSFIELD, CALIFORNIA

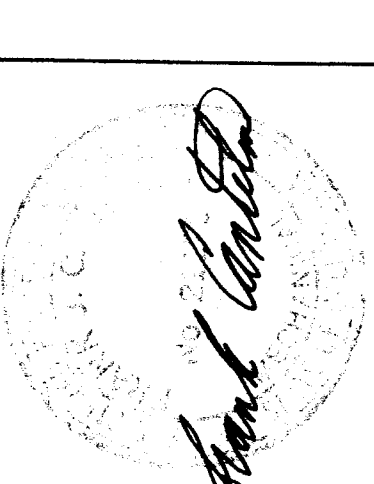

|       |         |            |                  |
|-------|---------|------------|------------------|
| Date: | 7/11/91 | Issue for: | O.S.A. Submittal |
| Date: | 4/4/91  | Issue for: | O.S.A. Recheck   |
| Date: |         | Issue for: |                  |
| Date: |         | Issue for: |                  |
| Date: |         | Issue for: |                  |
| Date: |         | Issue for: |                  |
| Date: |         | Issue for: |                  |
| Date: |         | Issue for: |                  |

|             |               |
|-------------|---------------|
| Drawn by:   |               |
| Checked by: |               |
| Job No.:    | 1912          |
| Sheet:      | <b>MP.2</b>   |
| Sheet of:   | 7             |
| Date:       | APRIL 4, 1991 |

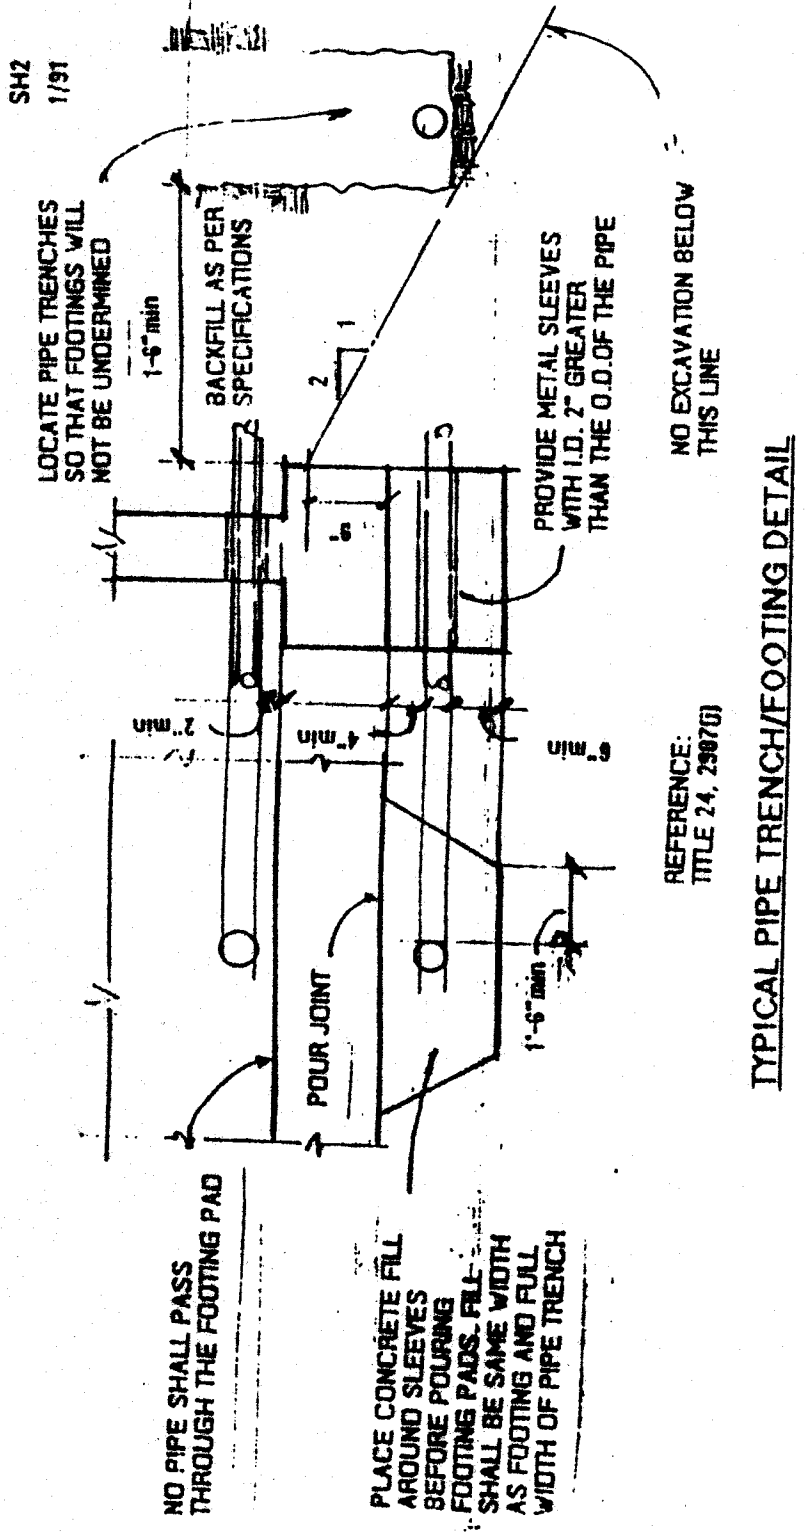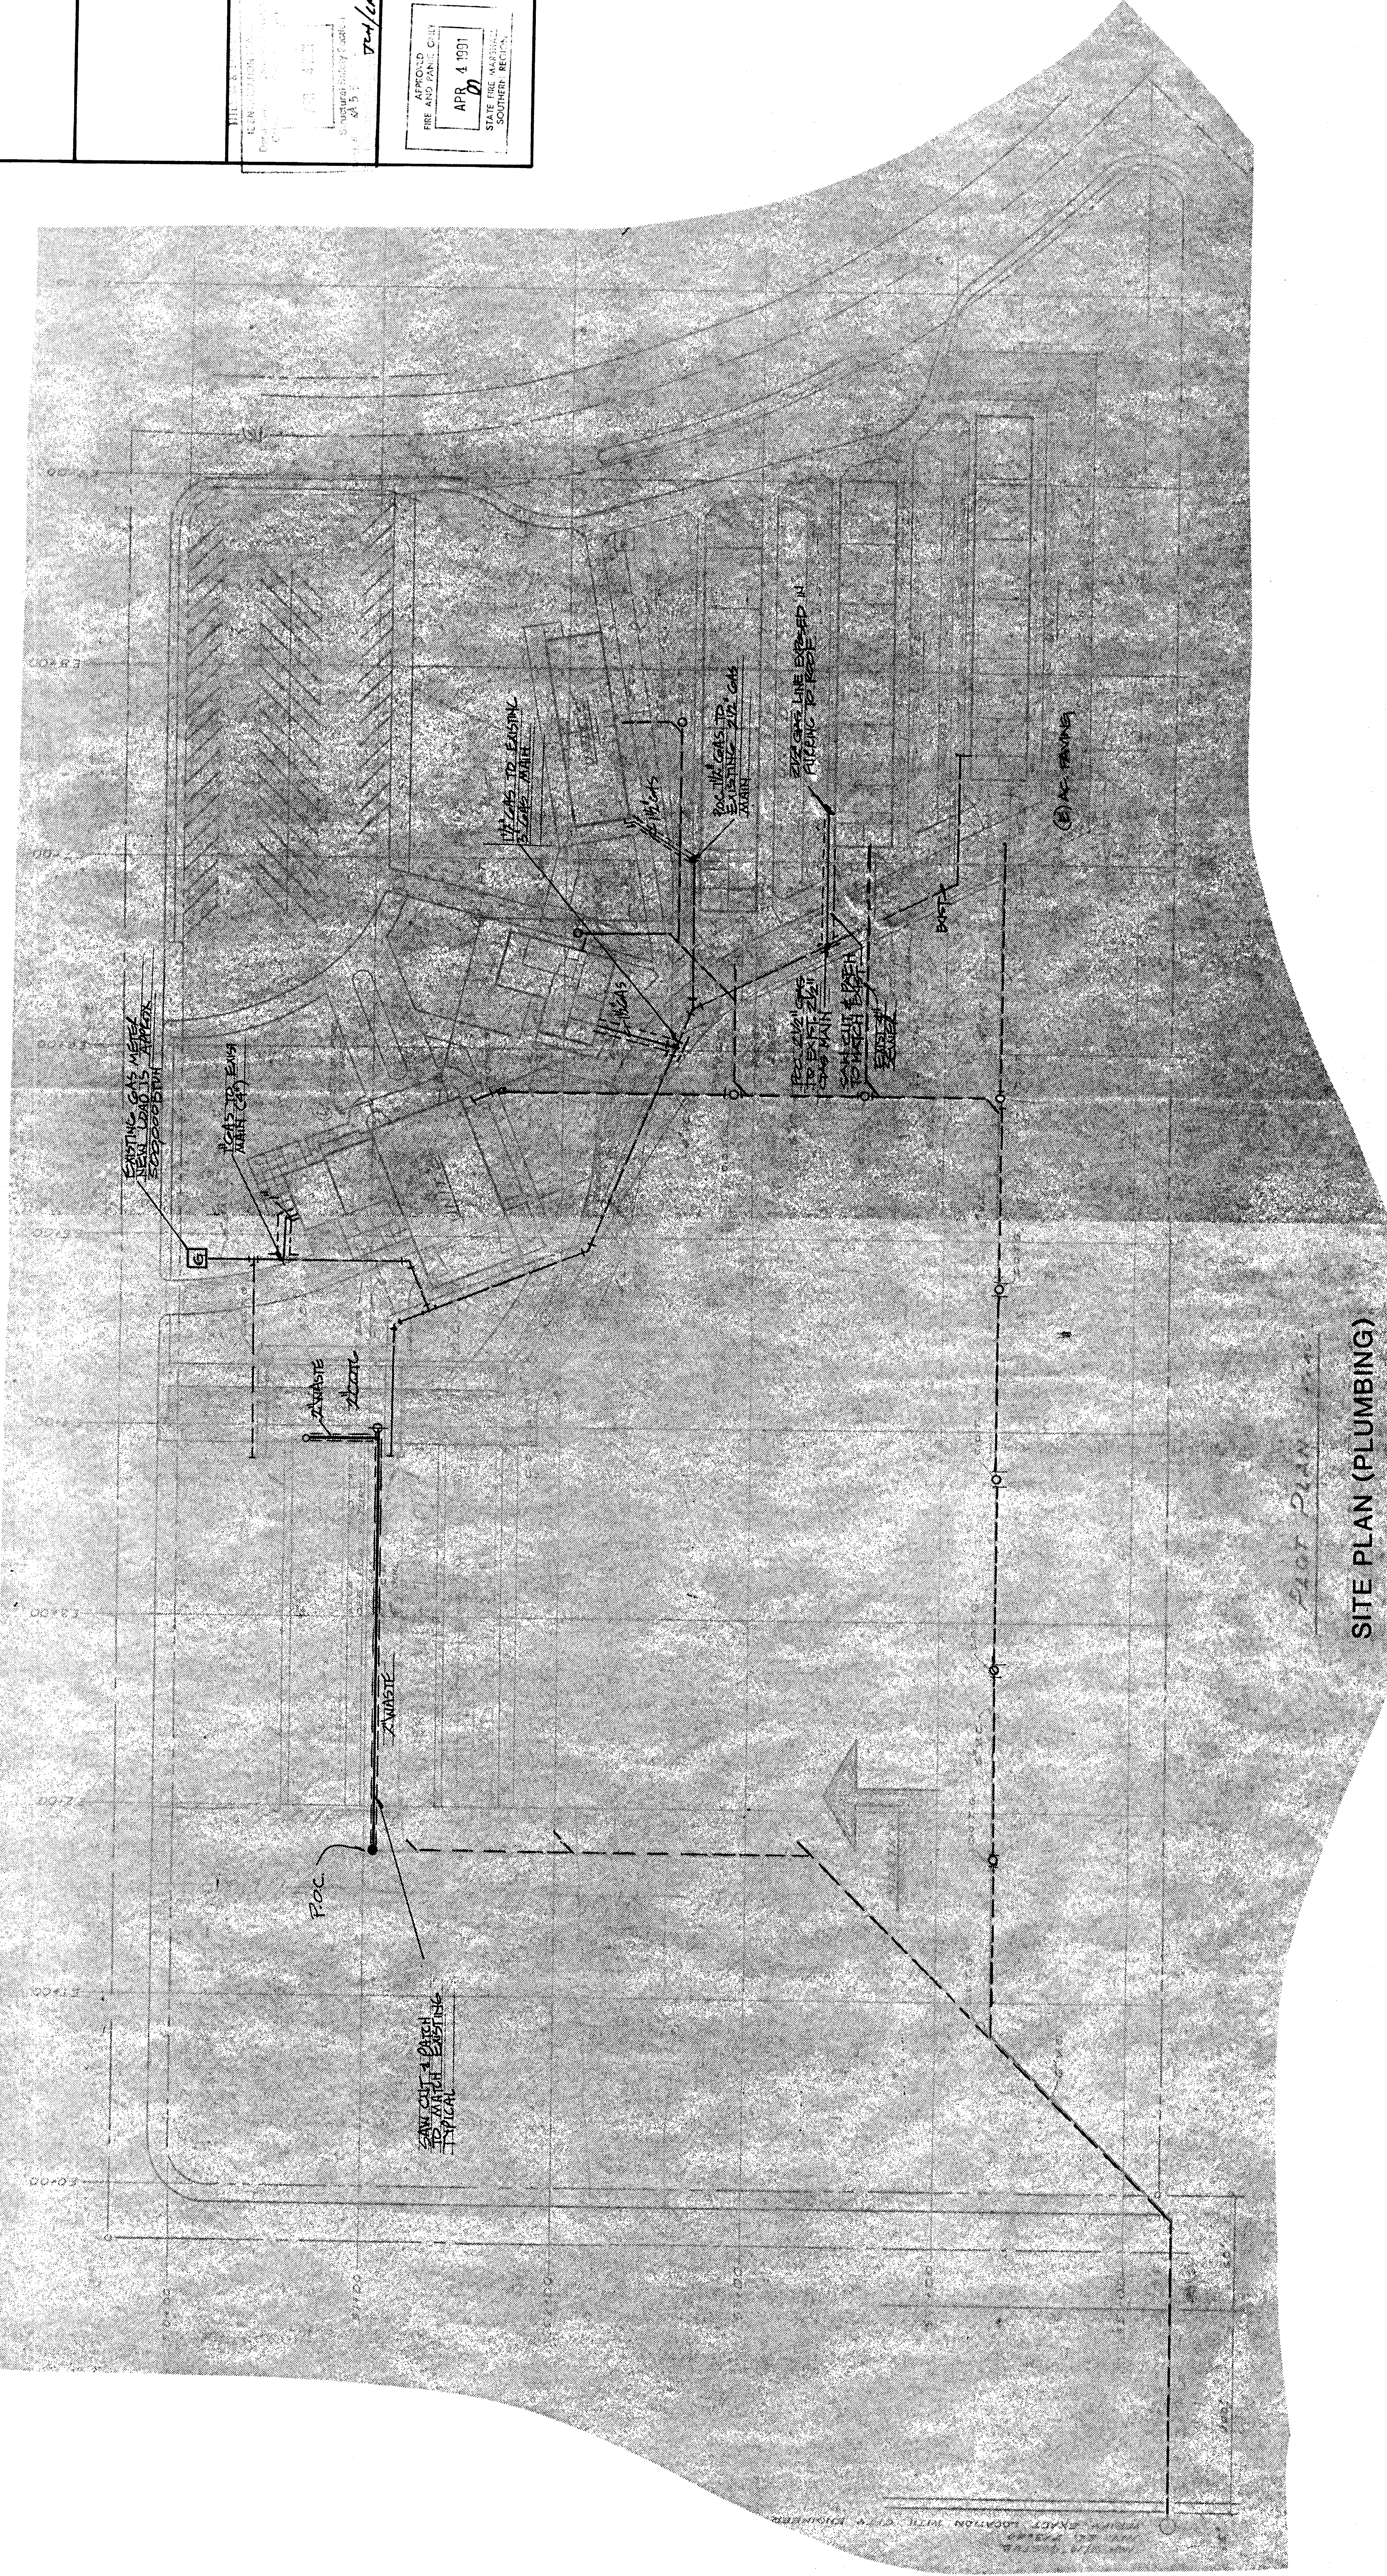

**APPROVALS**

|           |                                  |
|-----------|----------------------------------|
| DATE:     | APR 4 1991                       |
| TIME:     | 10:50 AM                         |
| PROJECT:  | MODERNIZATION PROJECT            |
| CLIENT:   | BAKERSFIELD CITY SCHOOL DISTRICT |
| DESIGNER: | FRANK CARLETON                   |
| CHECKED:  |                                  |
| DATE:     |                                  |

SITE PLAN (PLUMBING)