

MODERNIZATION
FOR
COLONEL HOWARD NICHOLS
SCHOOL
3401 RENEGADE AVE.
BAKERSFIELD, CA. 93306
BAKERSFIELD CITY
SCHOOL DISTRICT

FILE NO: 15-6
IDENTIFICATION STAMP
DW. OF THE STATE ARCHITECT
APPR. NO. 03-1-06864
DATE 8-26-03

BUILDING 500
FLOOR PLAN AND
REFLECTED CEILING
PLAN

Version Date: 02-1-17
date: 8-26-03
drawn by: DESAL
chk'd by: R. TROST
©copyright 2002

Version Time: 2:51

KEYNOTES

- NOTE: KEYNOTES IN THIS LIST MAY NOT NECESSARILY OCCUR ON THIS SHEET.
- 201 PROVIDE PLUMBING FIXTURE. REFER TO PLUMBING DRAWINGS.
 - 202 (E) FENCE TO REMAIN.
 - 203 LINE OF (E) ROOF ABOVE.
 - 204 REMOVE PORTION OF (E) CASEWORK. REFER TO INTERIOR ELEVATIONS.
 - 205 PROVIDE CASEWORK. REFER TO INTERIOR ELEVATIONS.
 - 206 REMOVE COUNTERTOP SHOWN HATCHED. REFER TO INTERIOR ELEVATIONS.
 - 207 REMOVE CASEWORK SHOWN HATCHED.
 - 208 REPLACE WHEELCHAIR LIFT.
 - 209 REPLACE HANDBAR. REFER TO 17/A10.02 FOR DETAIL.
 - 210 (E) CONCRETE RAMP TO REMAIN.
 - 211 REPAIR ALL (E) WINDOWS.
 - 212 REMOVE AND REPLACE EXISTING WITH OBTURATE GLAZING NOT USED.
 - 213 (E) FIRE EXTINGUISHER/CABINET TO REMAIN.
 - 214 REMOVE (E) OBSERVATION WINDOW AND INFILL THE OPENING.
 - 215 REMOVE AND REPLACE (E) OPERER TRACK. WALL.
 - 216 REFER TO DET. 23/A10.01.
 - 217 REMOVE 2" COMBUSTIBLE COLORSTRIP AT TOP AND BOTTOM TREAD.
 - 218 PROVIDE 2" COBALT RESIN. NO. 1000. REFER TO DET. 23/A10.01.
 - 219 PROVIDE 2'-0" OF (E) CABINET. PROVIDE CLOSURE PANEL W/ FINISH TO MATCH (E) ADJACENT CABINET.
 - 220 REMOVE 2'-0" OF (E) CABINET. PROVIDE CLOSURE PANEL W/ FINISH TO MATCH (E) ADJACENT CABINET.
 - 221 REMOVE 2'-0" OF (E) CABINET. PROVIDE CLOSURE PANEL W/ FINISH TO MATCH (E) ADJACENT CABINET. REFER TO DOOR SCHEDULE.

CEILING LEGEND

NOTE: ALL ITEMS INDICATED ON THIS LIST MAY NOT NECESSARILY OCCUR ON THIS SHEET.

RM #	ROOM NAME	CEILING HEIGHT
X-2	(E) CEILING FINISH TO REMAIN (GYP/SUM FINISH AND PAINT TYP. U.O.N.)	CEILING HEIGHT
X-2	"HEAVY DUTY" 2X4 SUSPENDED ACOUSTICAL CEILING SYSTEM	CEILING HEIGHT
X-2	GYP/SUM BOARD CEILING / SOFT ACOUSTICAL CEILING TILE	CEILING HEIGHT
X-2	RECESSED LIGHT FIXTURE. SEE ELECTRICAL DRAWINGS FOR ADDITIONAL INFORMATION.	CEILING HEIGHT
X-2	SURFACE MOUNTED LIGHT FIXTURE. SEE ELECTRICAL DRAWINGS FOR ADDITIONAL INFORMATION.	CEILING HEIGHT
X-2	AIR TERMINAL. SEE MECHANICAL DRAWINGS FOR ADDITIONAL INFORMATION.	CEILING HEIGHT

DASHED LINE INDICATES CEILING GRID IS NOT ATTACHED TO WALL. REFER TO REFLECTED CEILING PLAN FOR LOCATION. SEE DETAILS 14/A10.01.

MAJOR RUNNERS AT 4'-0" O.C. TYP.

GROSS TEES AT 2'-0" O.C. TYP.

PROVIDE 12 GA. SLACK WIRES AT DIAG. CORNERS LESS THAN 45 DEGREES. PROVIDE ENDS W/ BUSHINGS AT ALL CORNERS OF LIGHT FIXTURES AND AIR TERMINALS. WELDING 36 LBS. OR MORE. DRAWINGS TYPICAL.

SPLY WIRES PER DETAIL 15/A10.01.



SEE REFLECTED CEILING PLAN FOR LOCATION. ATTACH TO STRUCTURE PER DETAIL 17/A10.01.

ATTACH CEILING GRID TO TWO ADJACENT WALLS WHERE NO DASHED LINES ARE SHOWN ON REFLECTED CEILING PLAN. SEE DETAIL 13/A10.01.

1/2" GAUGE HANGERS 8" FROM WALLS.

4'-0" O.C. THEREAFTER ON MAJOR RUNNERS. REFLECTED CEILING PLAN. SEE DETAIL 17/A10.01.


KEY PLAN

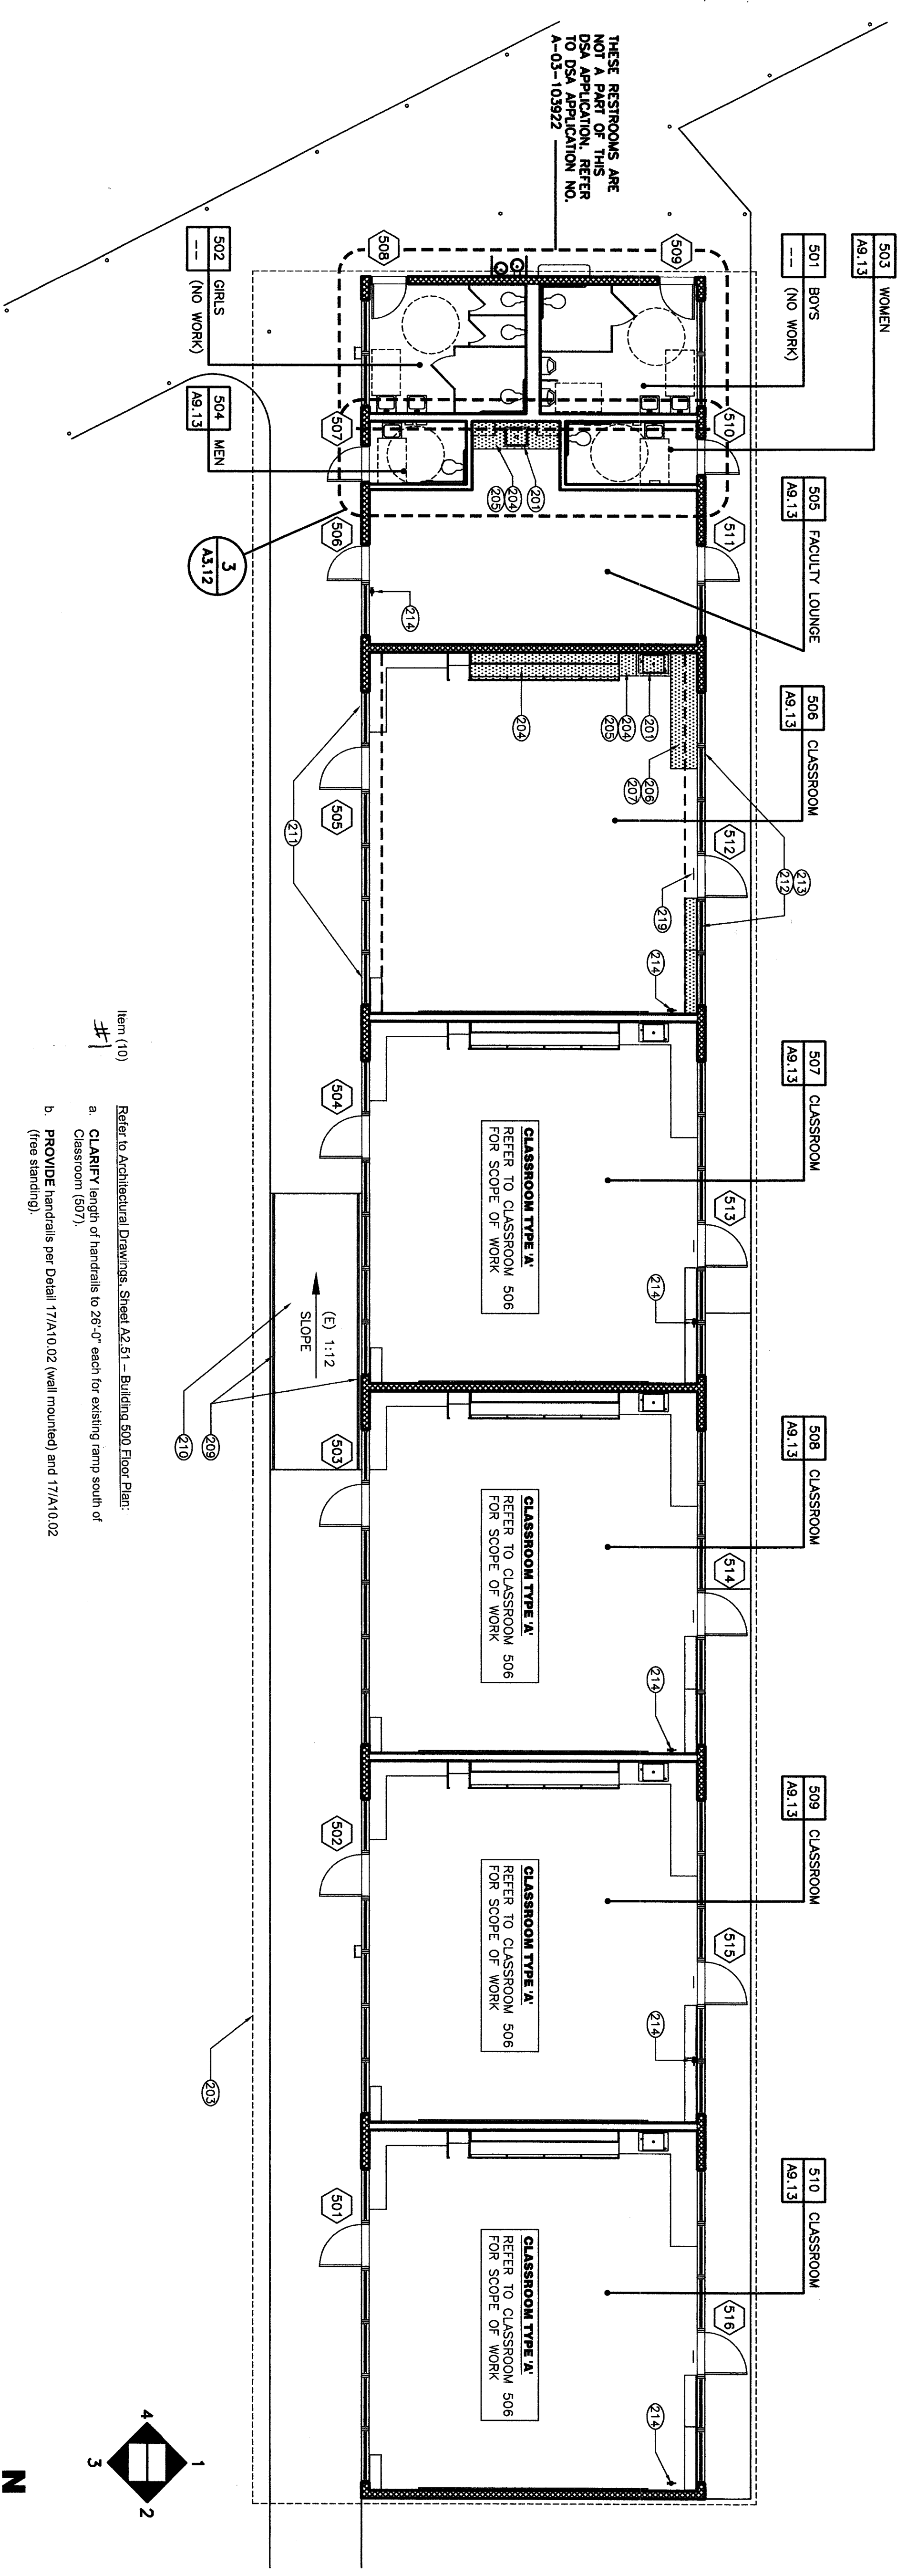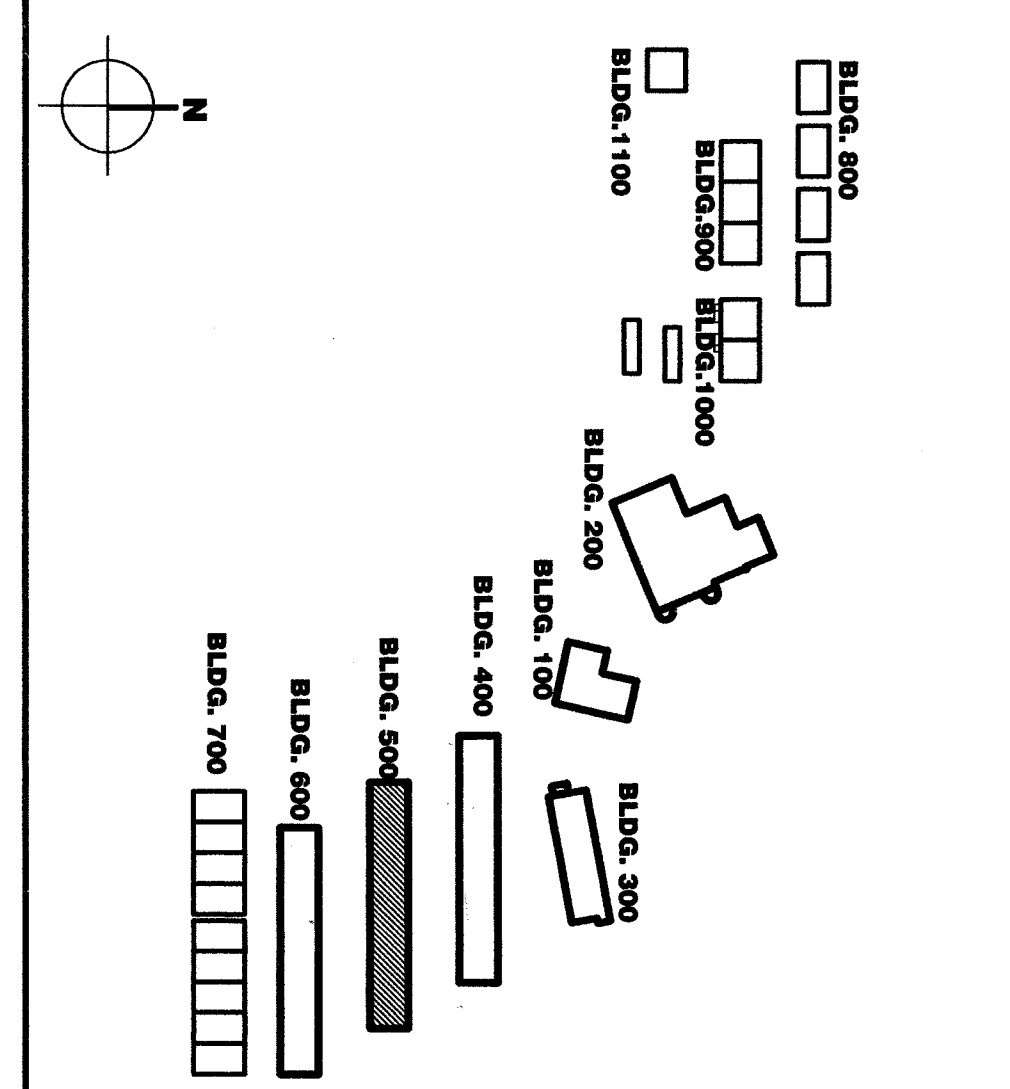

Item (10) Refer to Architectural Drawings, Sheet A-5.1 - Building 500 Floor Plan:

- a. CLARIFY length of handrails to 26'-0" each for existing ramp south of Classroom (507)
- b. PROVIDE handrails per Detail 17/A10.02 (wall mounted) and 17/A10.02 (free standing).

BUILDING 500 FLOOR PLAN

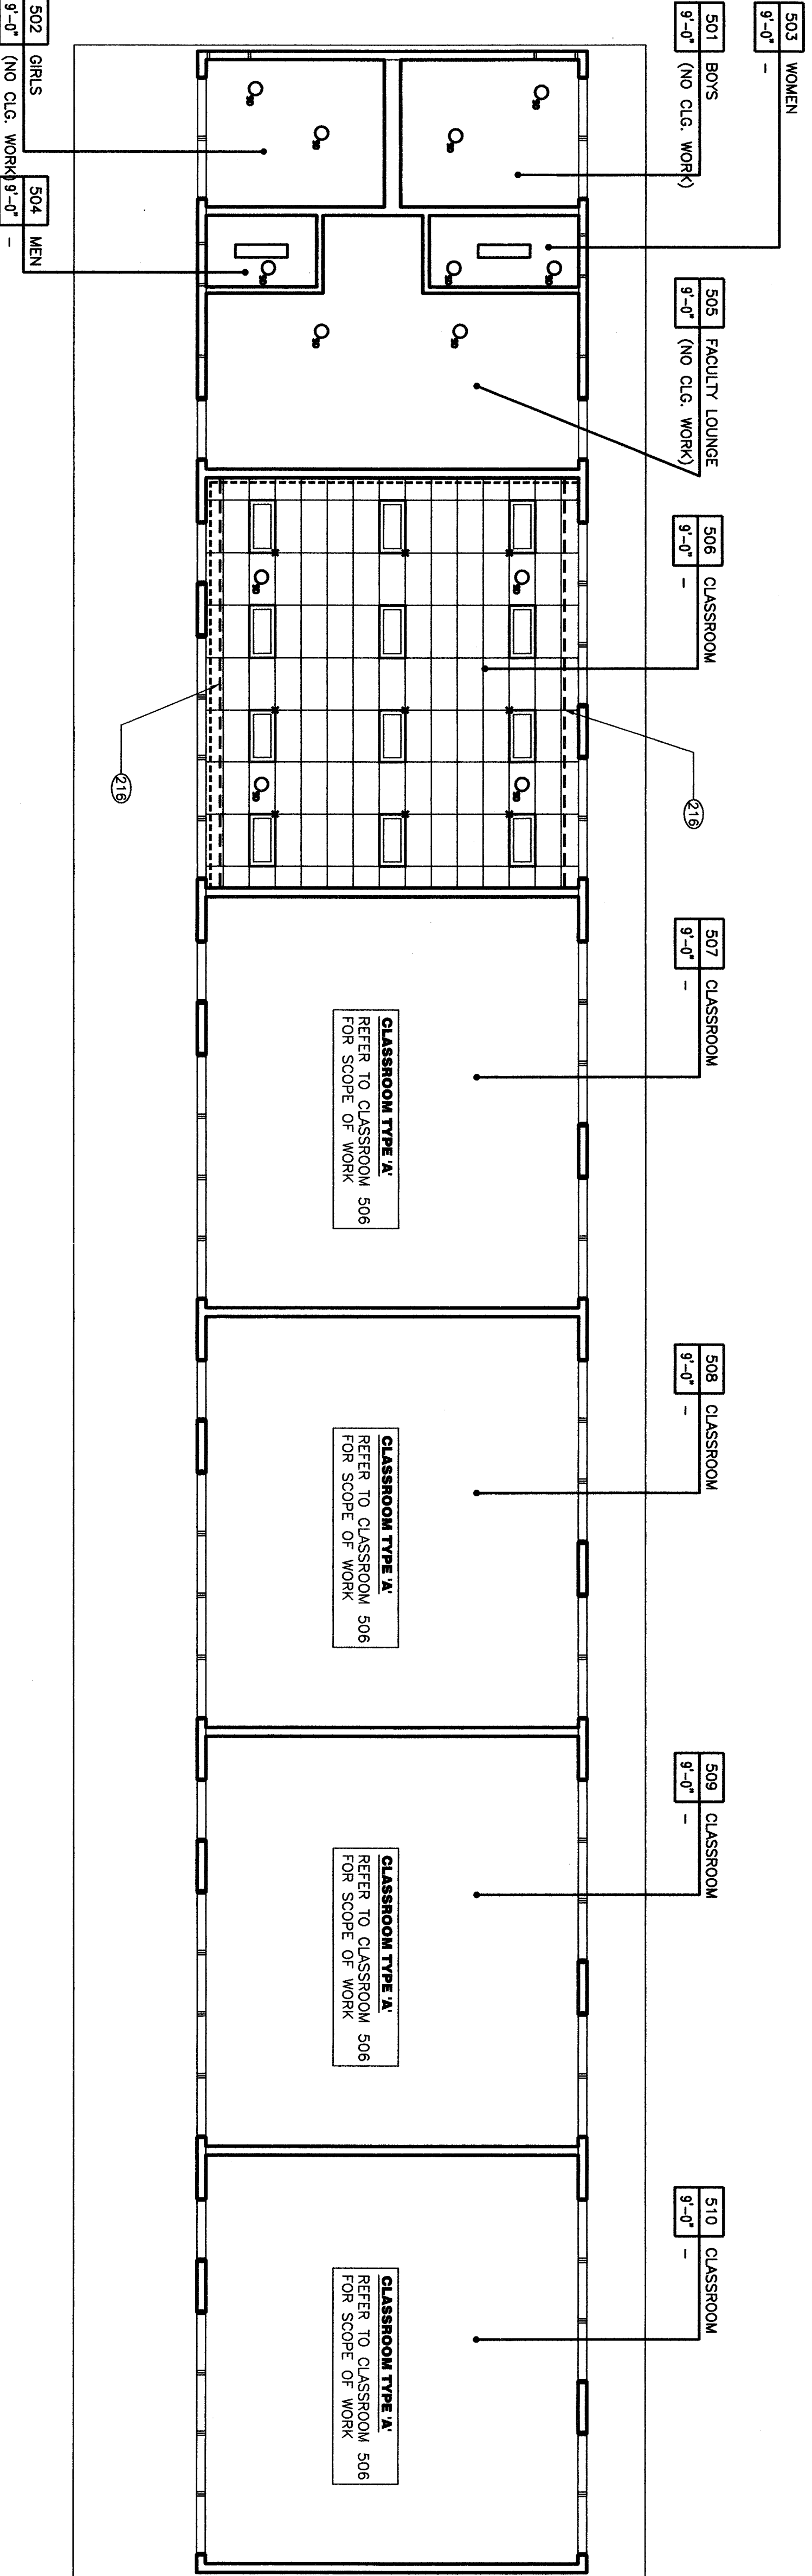

BUILDING 500 REFLECTED CEILING PLAN

