



Sheet (6)
2
Refer to Electrical Drawings, Sheet E2.1, Building 200 - Lighting Floor Plans
CLARIFY existing light fixture in Cold Storage (217) steel remain.

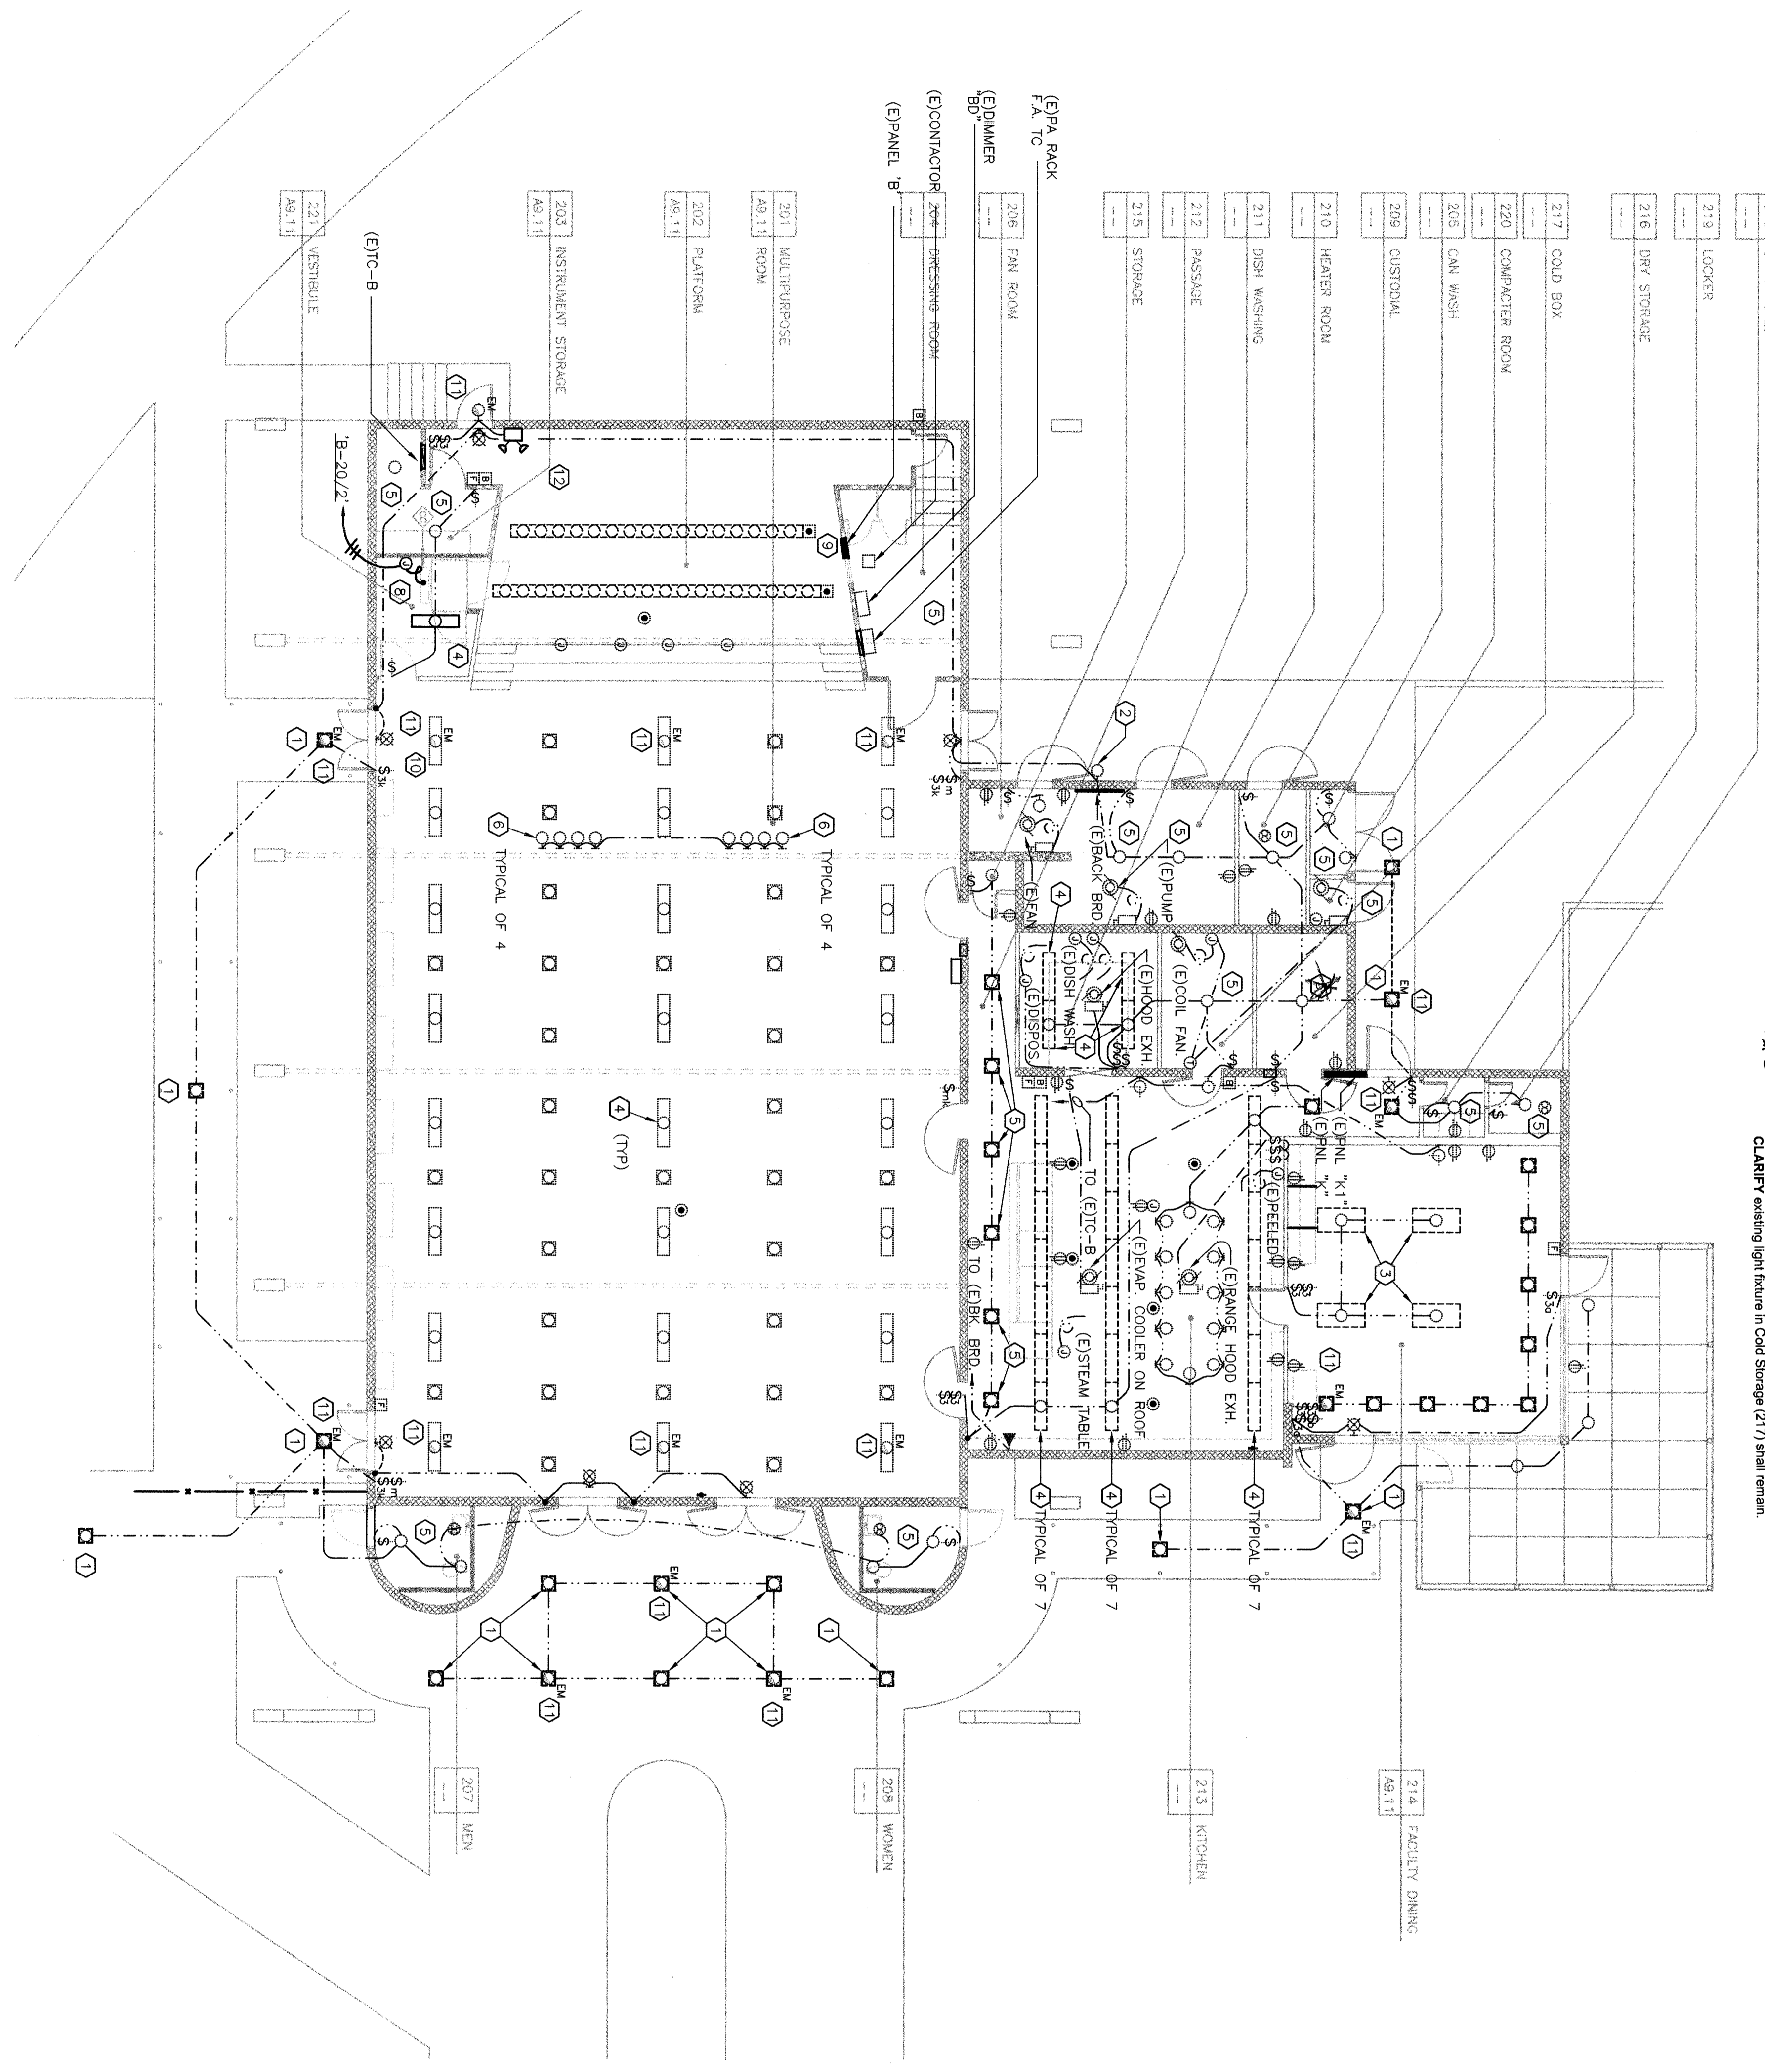


LIGHTING AND POWER/SIGNAL FLOOR PLAN BLDG. 200

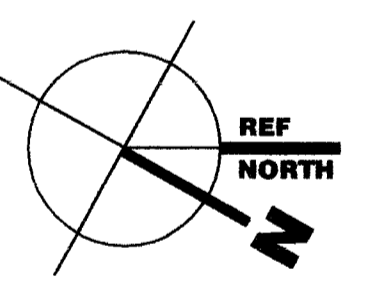

KEYNOTES

- NOTE: KEYNOTES IN THIS LIST MAY NOT NECESSARILY OCCUR ON THIS SHEET.
- 1 REPLACE EXISTING EXTERIOR DOWNLIGHT. USE RETROFIT KIT FIXTURE TYPE "F".
 - 2 REPLACE EXISTING WALL BRACKET FIXTURE. USE FIXTURE TYPE "G".
 - 3 EXISTING 2x4 SURFACE MOUNTED FIXTURES WITH (4) REPLACE BALLAST WITH RAPID START LOW BAY LAMP. REPLACE EXISTING BALLAST. REPLACE LENS WITH KSH K12125 ACRYLIC LENS.
 - 4 EXISTING WRAPOROUND FIXTURES WITH (2) 40W T-12 LAMPS. REPLACE EXISTING BALLAST WITH RAPID START LOW BAY LAMP. REPLACE EXISTING BALLAST. REPLACE LENS WITH KSH K12125 ACRYLIC LENS.
 - 5 REPLACE EXISTING DOWNLIGHTS. USE RETROFIT KIT FIXTURE TYPE "E".
 - 6 CLEAN AND RELAMP EXISTING FIXTURES. USE MATCHING HALOGEN LAMP.
 - 7 EXISTING FIXTURE TO REMAIN.
 - 8 PROVIDE CONNECTION TO HAND-CAP LIFT. COORDINATE WITH MECHANICAL CONTRACTOR. PROVIDE HARDWARE IN EXISTING PANEL AS REQUIRED.
 - 9 EXISTING PANEL "8" PROVIDE NEW BREAKER FOR CONTRACTOR. PROVIDE HARDWARE IN EXISTING PANEL AS REQUIRED.
 - 10 PROVIDE NEW SWITCH AND SWITCH LEG FOR LIGHT.
 - 11 PROVIDE EMERGENCY BATTERY PACK. PROVIDE UNSWITCHED HOT CONDUCTOR.
 - 12 PROVIDE EMERGENCY BATTERY BACK UP FIXTURE.

KEY PLAN

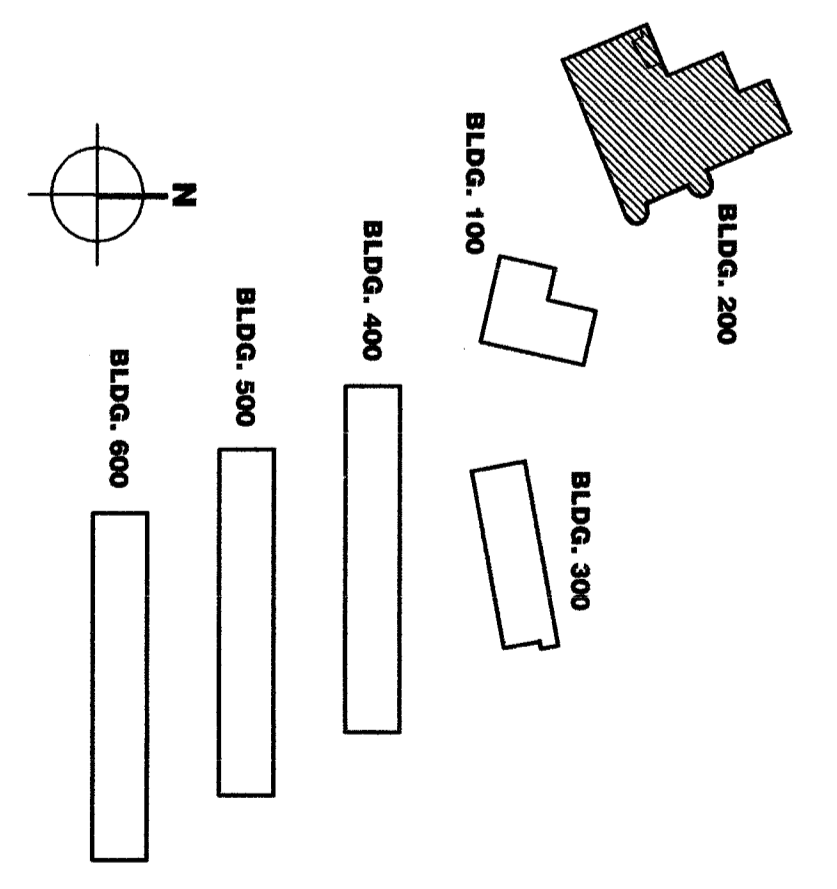

Bakersfield
5500 Ming Avenue, Suite 450, Bakersfield, CA 93309
661.836.4300
fax 661.836.4311

San Jose
5000 N. First Street, Suite 200
San Jose, California 95113
408.924.0841
408.924.0844

San Luis Obispo
5115 Broad Street, Suite B-5
San Luis Obispo, CA 93401
for 805.540.0094

Oakland
500 Frank Street, Suite 300
Oakland, CA 94612
510.891.0570

Principal Architects
4044 1st Street East, Suite 200
Fremont, CA 94538
William V. Nichols, AIA, C-1154
Robert I. Smith, AIA, C-16793

REGISTERED PROFESSIONAL ENGINEER
No. 5101
09/20/06
1665 W. Fairbank Ave., Suite 106
Fremont, California 94711
(510) 432-4490 / (510) 432-4494 fax
James W. Gorman, Electrical Engineer
E.E. 95101
ESTABLISHED 1988

FILE NO. 15-6
REGISTERED PROFESSIONAL ENGINEER
DIV. OF THE STATE CONTRACTORS BOARD
FOR THE STATE OF CALIFORNIA
No. 03-106664
DATE: 01/12/06

MODERNIZATION
FOR
COLONEL HOWARD NICHOLS
SCHOOL
3401 RENEGADE AVE.
BAKERSFIELD, CA 93306
BAKERSFIELD CITY
SCHOOL DISTRICT

BUILDING 200
LIGHTING AND POWER
/SIGNAL FLOOR PLANS

Version Date: 02-1-17
Job No.: 02-1-17
date: 06/24/03
drawn by: T.A.
checked by: D.G.
©copyright 2003

Version: 2.21