

**Bakersfield**

5500 ring avenue, suite 450, bakersfield, ca 93309  
661.836.4300 fax 661.836.4311


**San Jose**  
150 north main street, suite 200  
san jose, california 95113  
408.924.0944  
fax 408.283.0844

**San Luis Obispo**  
4115 wood street, suite b-5  
san luis obispo, ca 93401  
805.546.6594  
fax 805.546.6594

**Oakland**  
300 frank square plaza, suite 300  
oakland, california 94612  
510.881.0570  
fax 510.881.0574

**Principal Architects**

donald r. carroll, f.a.s.c. - c-8190  
diane m. wilson, a.i.a. - c-1080  
mark w. wilson, a.i.a. - c-1080  
robert l. webb, a.i.a. - c-18078  
andrew f. woodell, a.i.a. - c-8702

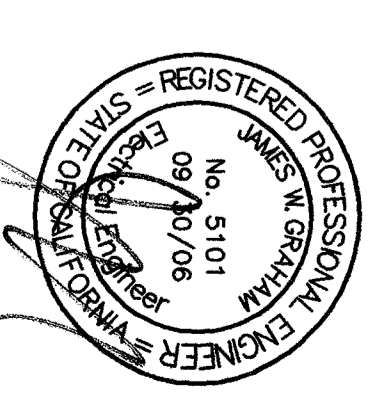

**INTERSTATE ENGINEERING**  
465 W. Fairbrook Ave., Suite 116  
Fremont, California 93711  
408.743.2490 / (569) 432.4844 fax  
James W. Carlson, Electrical Engineer  
E.E. #9101

FILE NO. 15-6  
INDUSTRIAL STAND  
DIV. OF THE STATE ARCHITECT  
ISSR NO.  
03-106664  
DATE: APR 27 2003




**MODERNIZATION**  
FOR  
COLONEL HOWARD NICHOLS  
SCHOOL  
3401 RENEGADE AVE.  
BAKERSFIELD, CA 93306  
BAKERSFIELD CITY  
SCHOOL DISTRICT

**BUILDING 300  
FIRE ALARM  
FLOOR PLAN**

Version Date:	Version Name:
Job no. 02-127	
date 06/24/03	
drawn by T.A.	
chkd by D.G.	
© copyright 2003	

**FULLY AUTOMATIC SYSTEM  
FIRE ALARM COMPLETE  
PLAN SUBMITTAL**

**KEY PLAN**

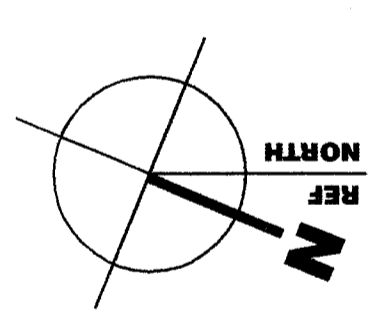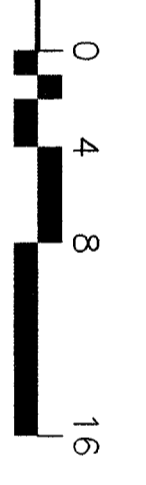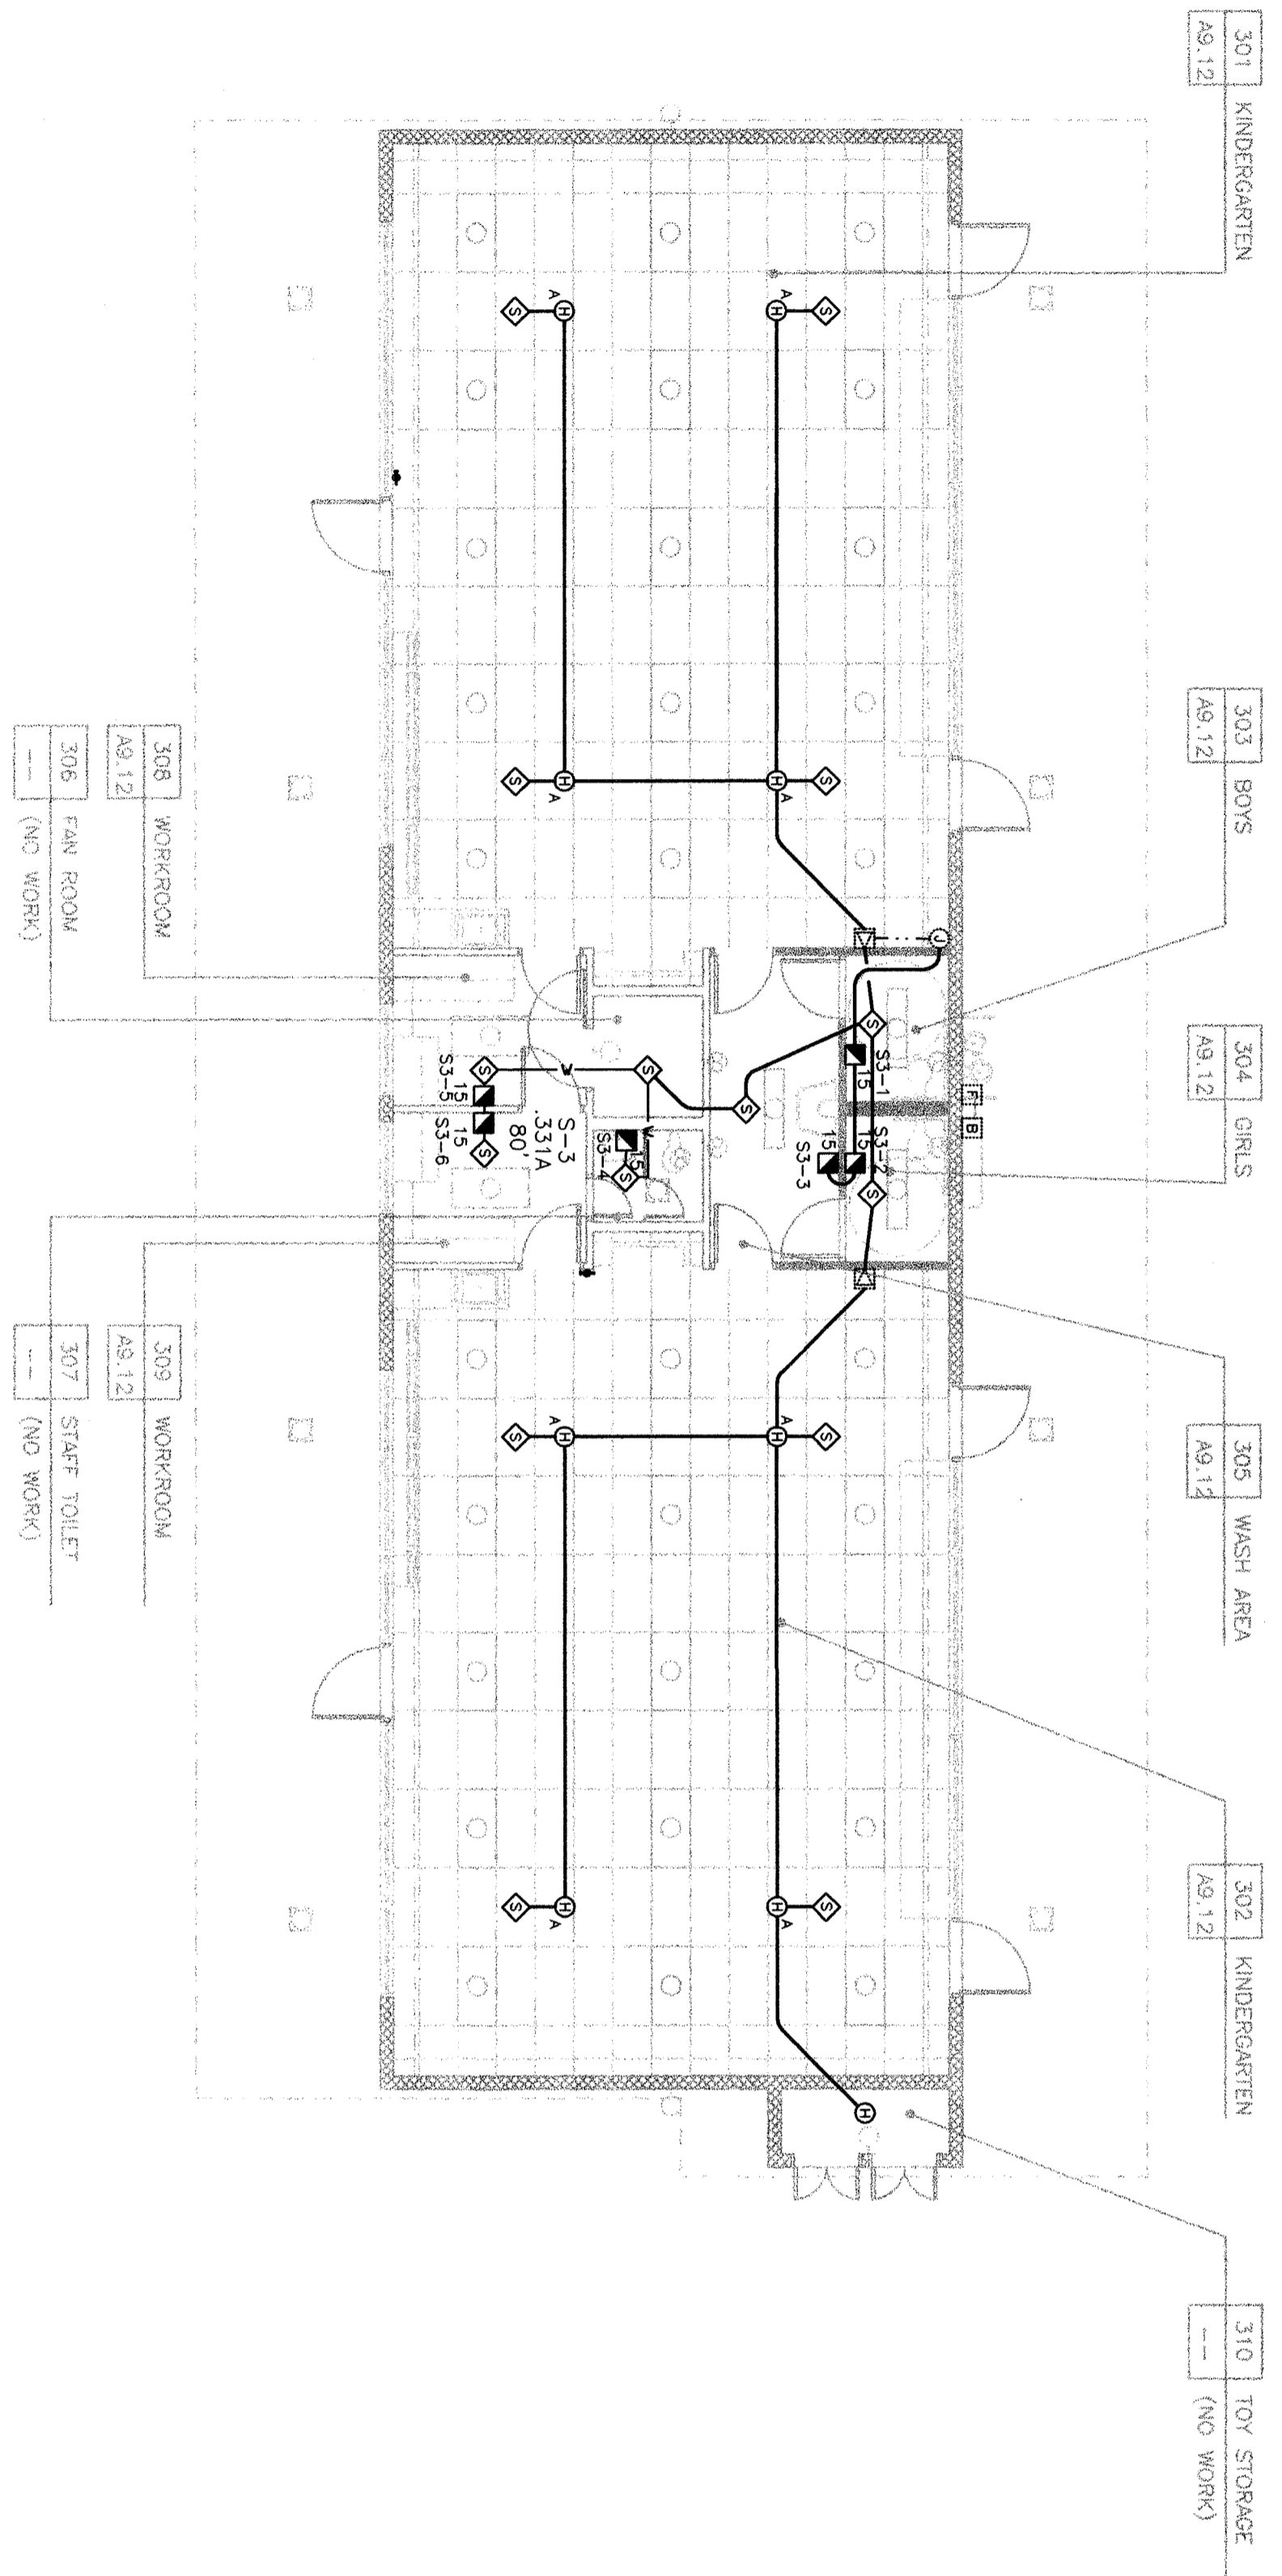

**FIRE ALARM FLOOR PLAN BLDG. 300**