



Bakersfield
 5207 California Avenue, Suite 400, Bakersfield, CA 93309
 661.836.4326 or 661.836.4371

San Jose
 150 South First St., Suite 200
 San Jose, California 95113
 408.924.0844

San Luis Obispo
 4115 Grand Street, Suite 3-8
 San Luis Obispo, CA 93401
 805.546.0433 or 805.546.0504
 805.546.0504

Oakland
 300 Lakeside Plaza, Suite 300
 Oakland, California 94612
 510.881.0070
 510.881.0074

Principal Architects
 James W. Gicham, E.E. #9101
 James W. Gicham, E.E. #9101
 James W. Gicham, E.E. #9101
 James W. Gicham, E.E. #9101

REGISTERED PROFESSIONAL ENGINEER
 No. 5101
 K. KRUMHOLTZ
 REGISTERED PROFESSIONAL ENGINEER
 ELECTRICAL
 State of California
 License No. 5101
 Expires 12/31/2004



PREPARE FOR SUBMITTAL
 James W. Gicham, Electrical Engineer
 E.E. #9101
 440 W. Fernock Ave., Suite 100
 Fresno, California 93711
 (559) 526-4000 / (559) 526-4444 fax

FILE NO. 15-6
 IDENTIFICATION STAMP
 DIV. OF THE STATE ARCHITECT
 APR. NO. 03-106864
 4081 R.S. # 2003
 DATE: AUG 2 2003


MODERNIZATION
 FOR
 COLONEL HOWARD NICHOLS
 SCHOOL
 3401 RENEGADE AVE.
 BAKERSFIELD, CA 93306
 BAKERSFIELD CITY
 SCHOOL DISTRICT

**FULLY AUTOMATIC SYSTEM
 FIRE ALARM COMPLETE
 PLAN SUBMITTAL**

KEY PLAN

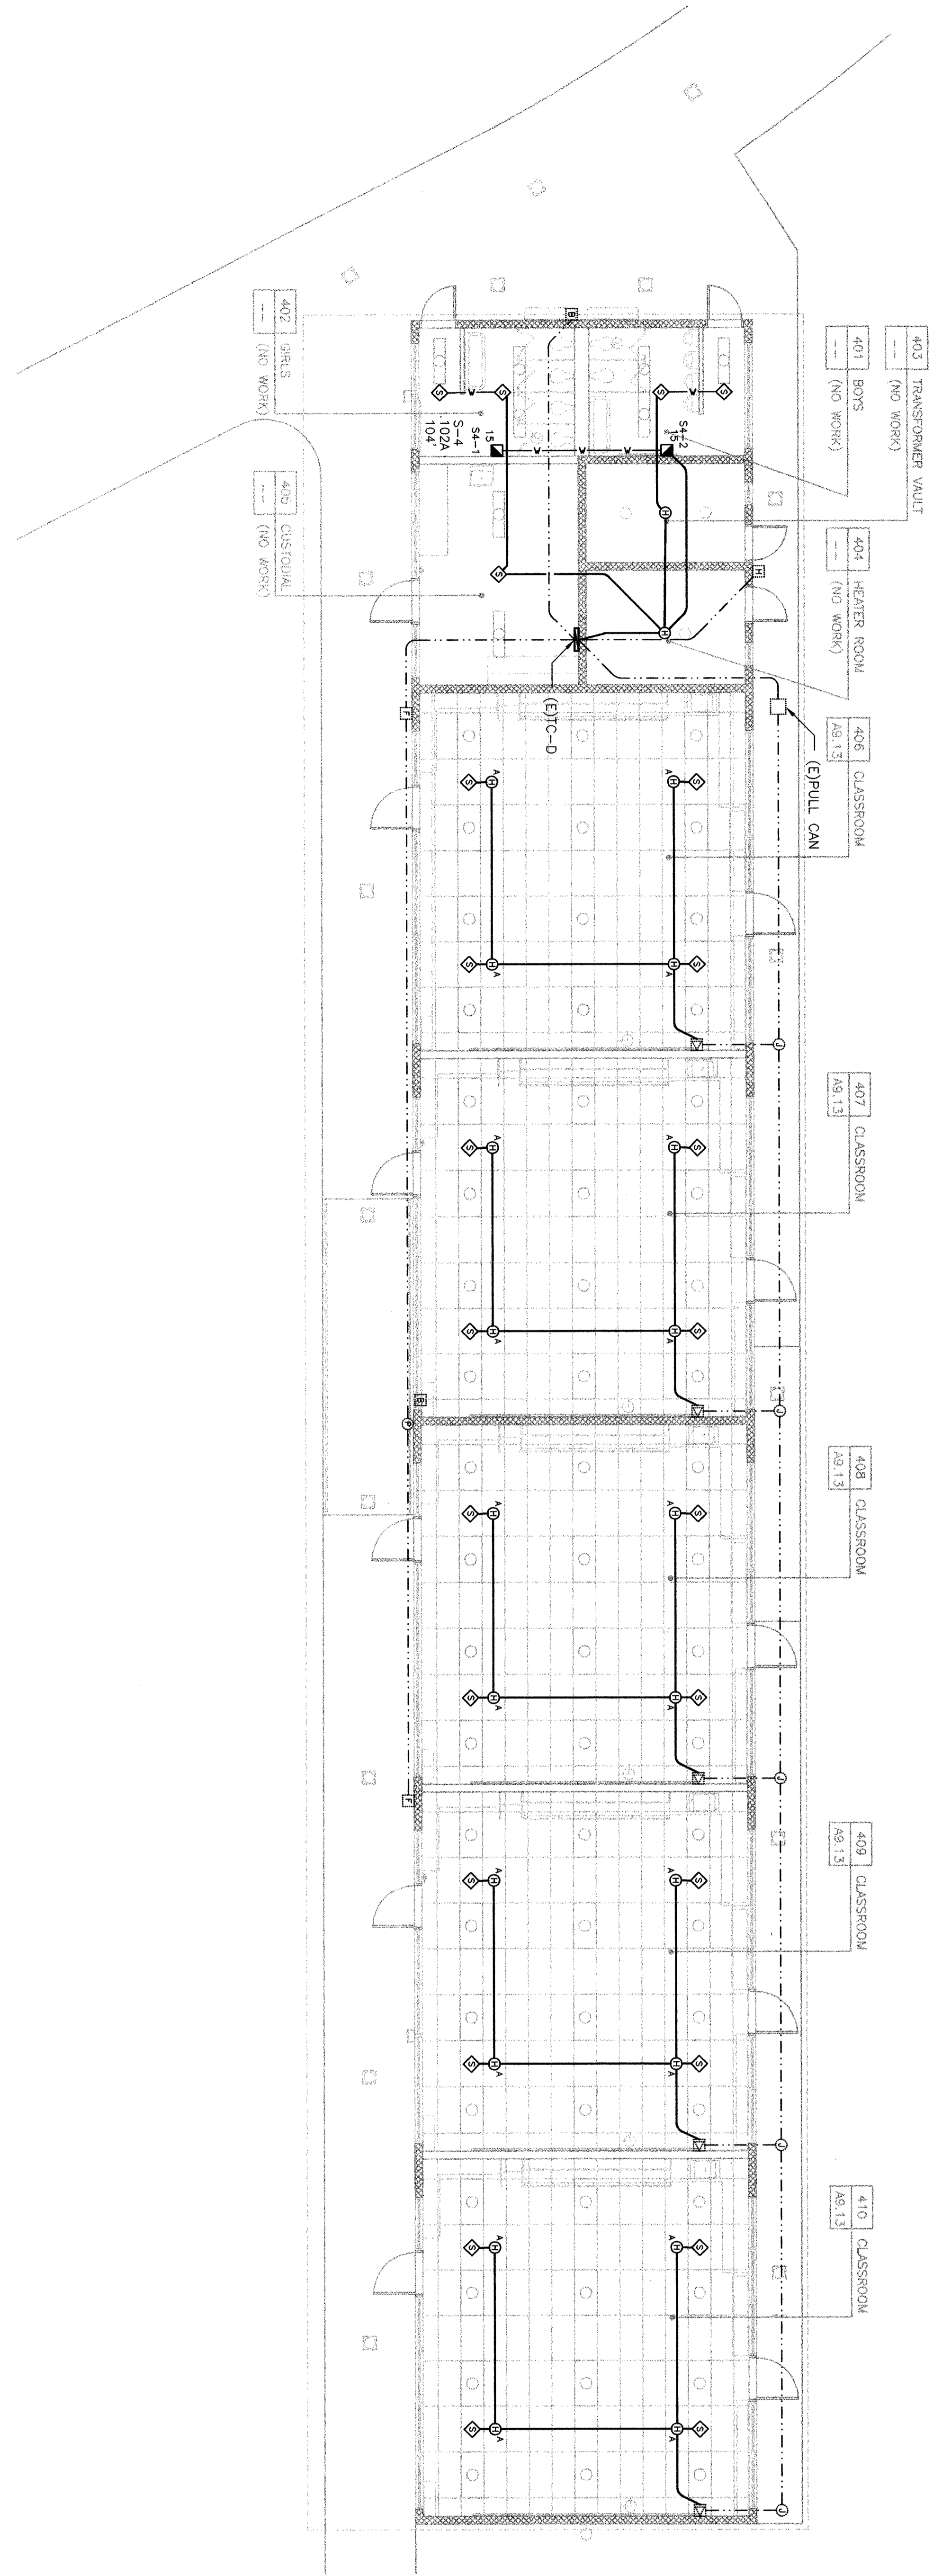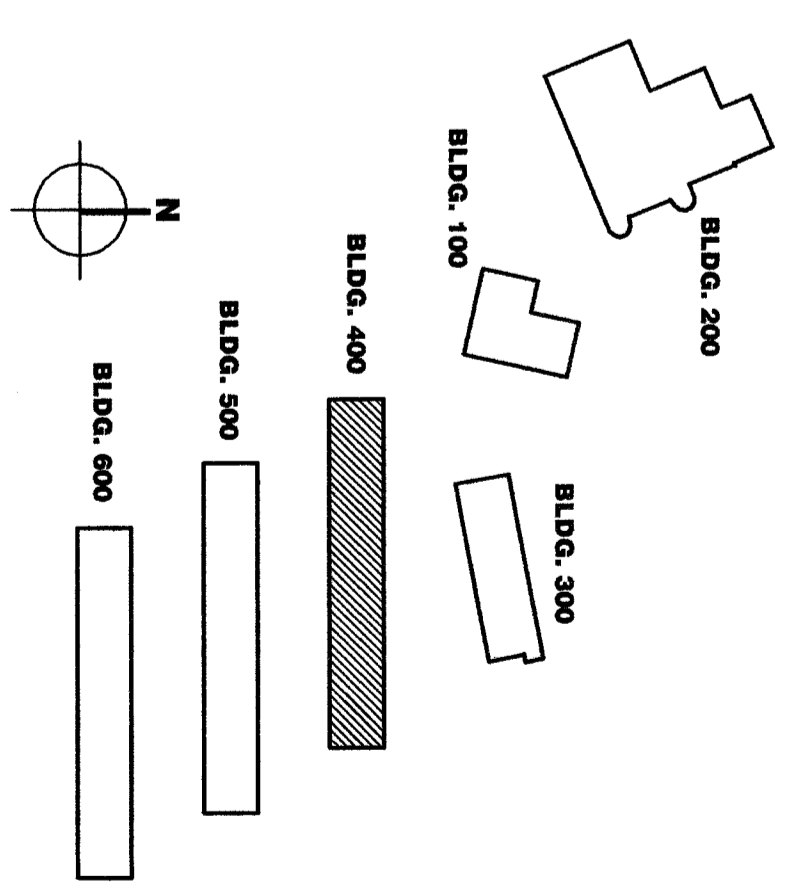

FIRE ALARM FLOOR PLAN BLDG. 400

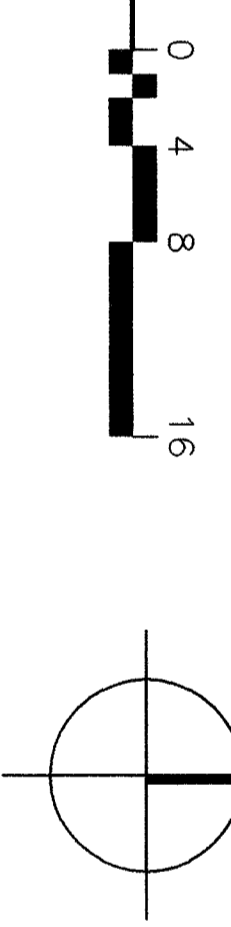

**BUILDING 400
 FIRE ALARM
 FLOOR PLAN**

Version Date:	02-127	Version Error:	
Job No.:			
date:	06/24/03		
drawn by:	T.A.		
chkd by:	D.G.		
© copyright:	2003		

2-42