



Bakersfield
 2501 W. 7th, Suite 450, Bakersfield, CA 93309
 805.835.9300
 Fax: 805.835.9311

San Jose
 150 South First St., Suite 200
 San Jose, California 95113
 Tel: 408.524.9844

San Luis Obispo
 4115 Broad Street, Suite 3-6
 San Luis Obispo, CA 93401
 Tel: 805.546.0054
 Fax: 805.546.0054

Oakland
 3500 Broadway, Suite 300
 Oakland, California 94612
 Tel: 510.891.0274

Principal Architects
 David F. Gorman, P.E., C-3584
 Robert J. Gorman, P.E., C-3584
 Mark J. Gorman, P.E., C-3584
 Robert J. Gorman, P.E., C-3584
 Robert J. Gorman, P.E., C-3584

REGISTERED PROFESSIONAL ENGINEER
 No. 1101
 No. 03/108
 CIVIL ENGINEER
 ESTABLISHED 1988

404 W. Fairbrook Ave., Suite 106
 Fresno, California 93711
 (559) 432-4400 / (559) 432-4894 fax
 James W. Gadsden, Electrical Engineer
 ESTABLISHED 1988

FILE NO. 15-6
 IMPRESSION STAMP
 DIV. OF THE STATE ARCHITECT
 SPRL NO. 03-108664
 DATE AUG 26 2003

MODERNIZATION
 FOR
 COLONEL HOWARD NICHOLS
 SCHOOL
 3401 RENEGADE AVE.
 BAKERSFIELD, CA 93306
 BAKERSFIELD CITY
 SCHOOL DISTRICT


**BUILDING 500
 FIRE ALARM
 FLOOR PLAN**

Version Date: 02-1-27
 Job No. 02-127
 date 02/24/03
 drawn by T.A.
 checked by D.G.
 ©copyright 2003

2.52

**FULLY AUTOMATIC SYSTEM
 FIRE ALARM COMPLETE
 PLAN SUBMITTAL**

KEY PLAN

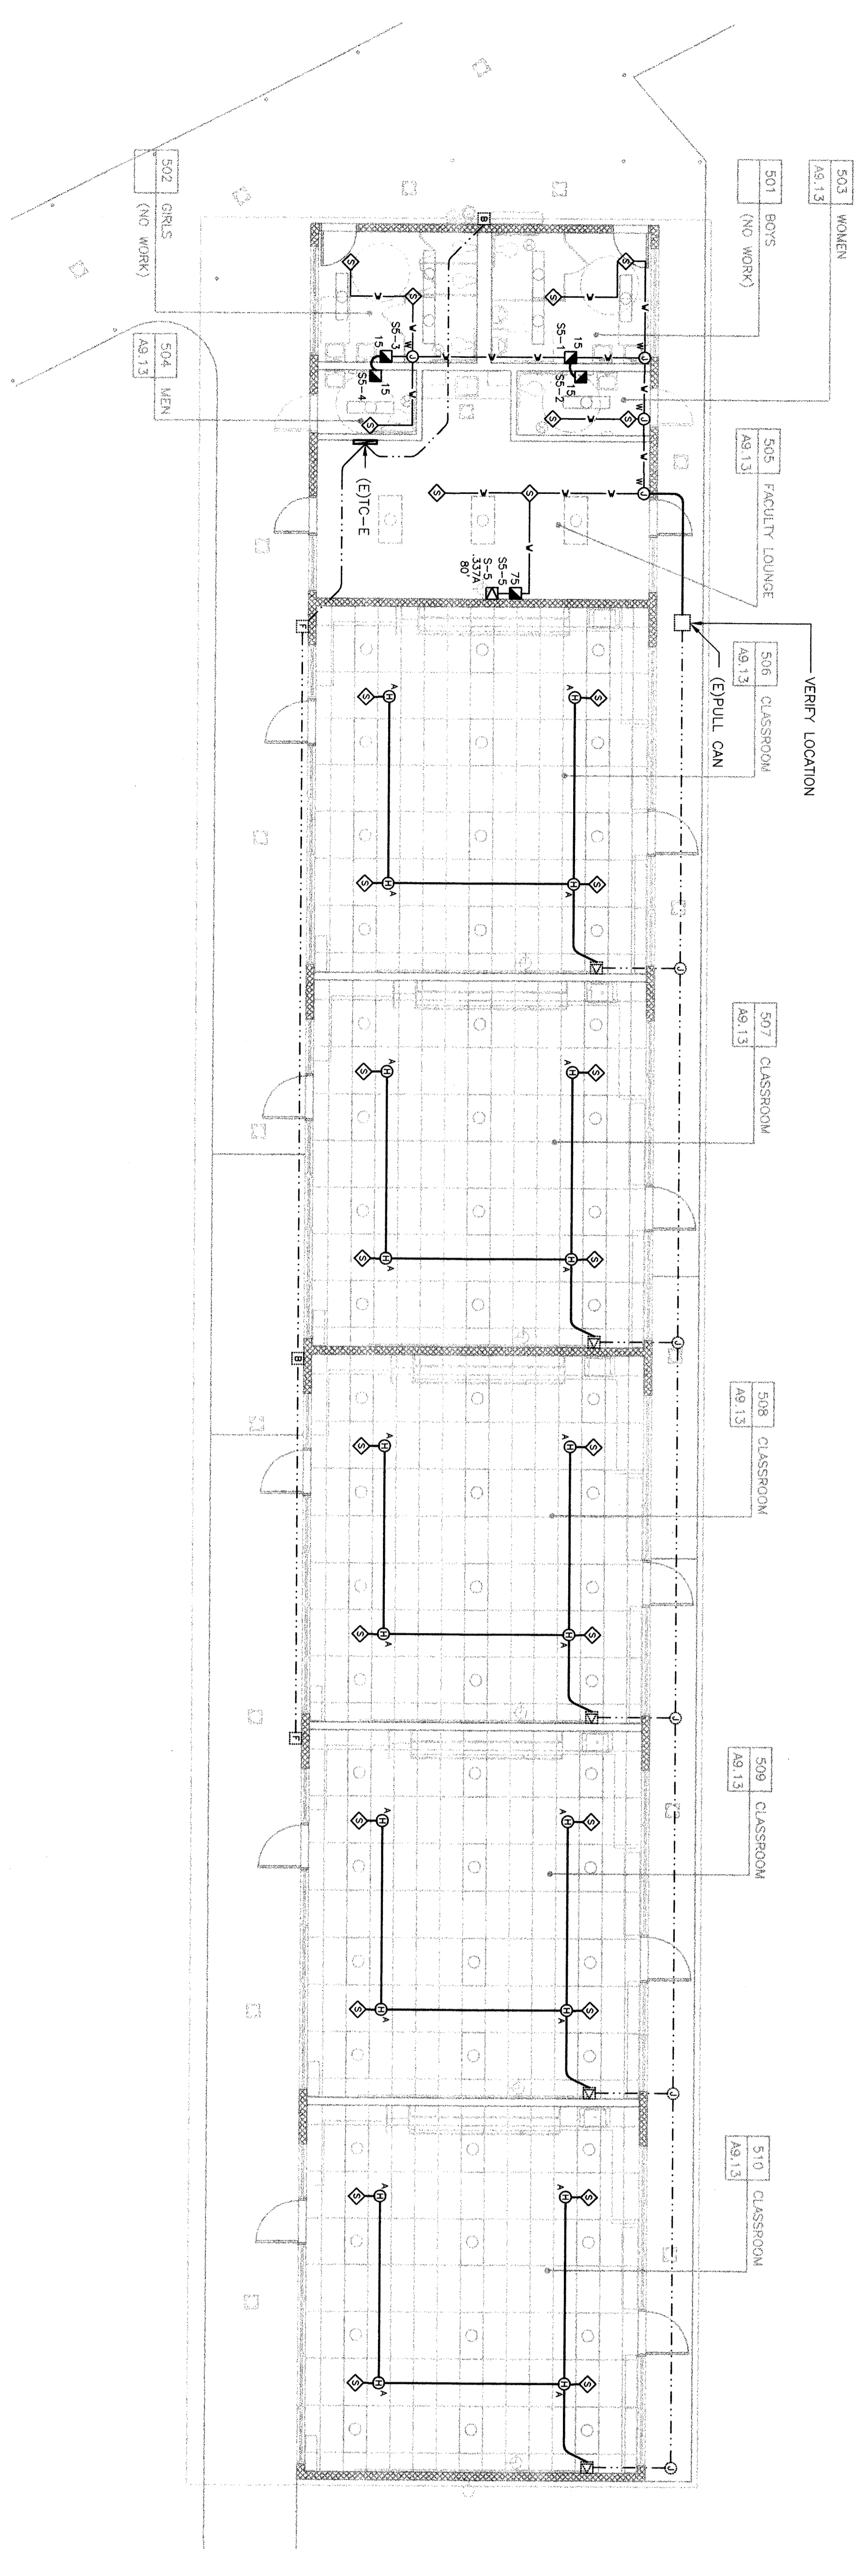

FIRE ALARM FLOOR PLAN BLDG. 500