



DEMOLITION LIGHTING FLOOR PLAN BLDG. 600

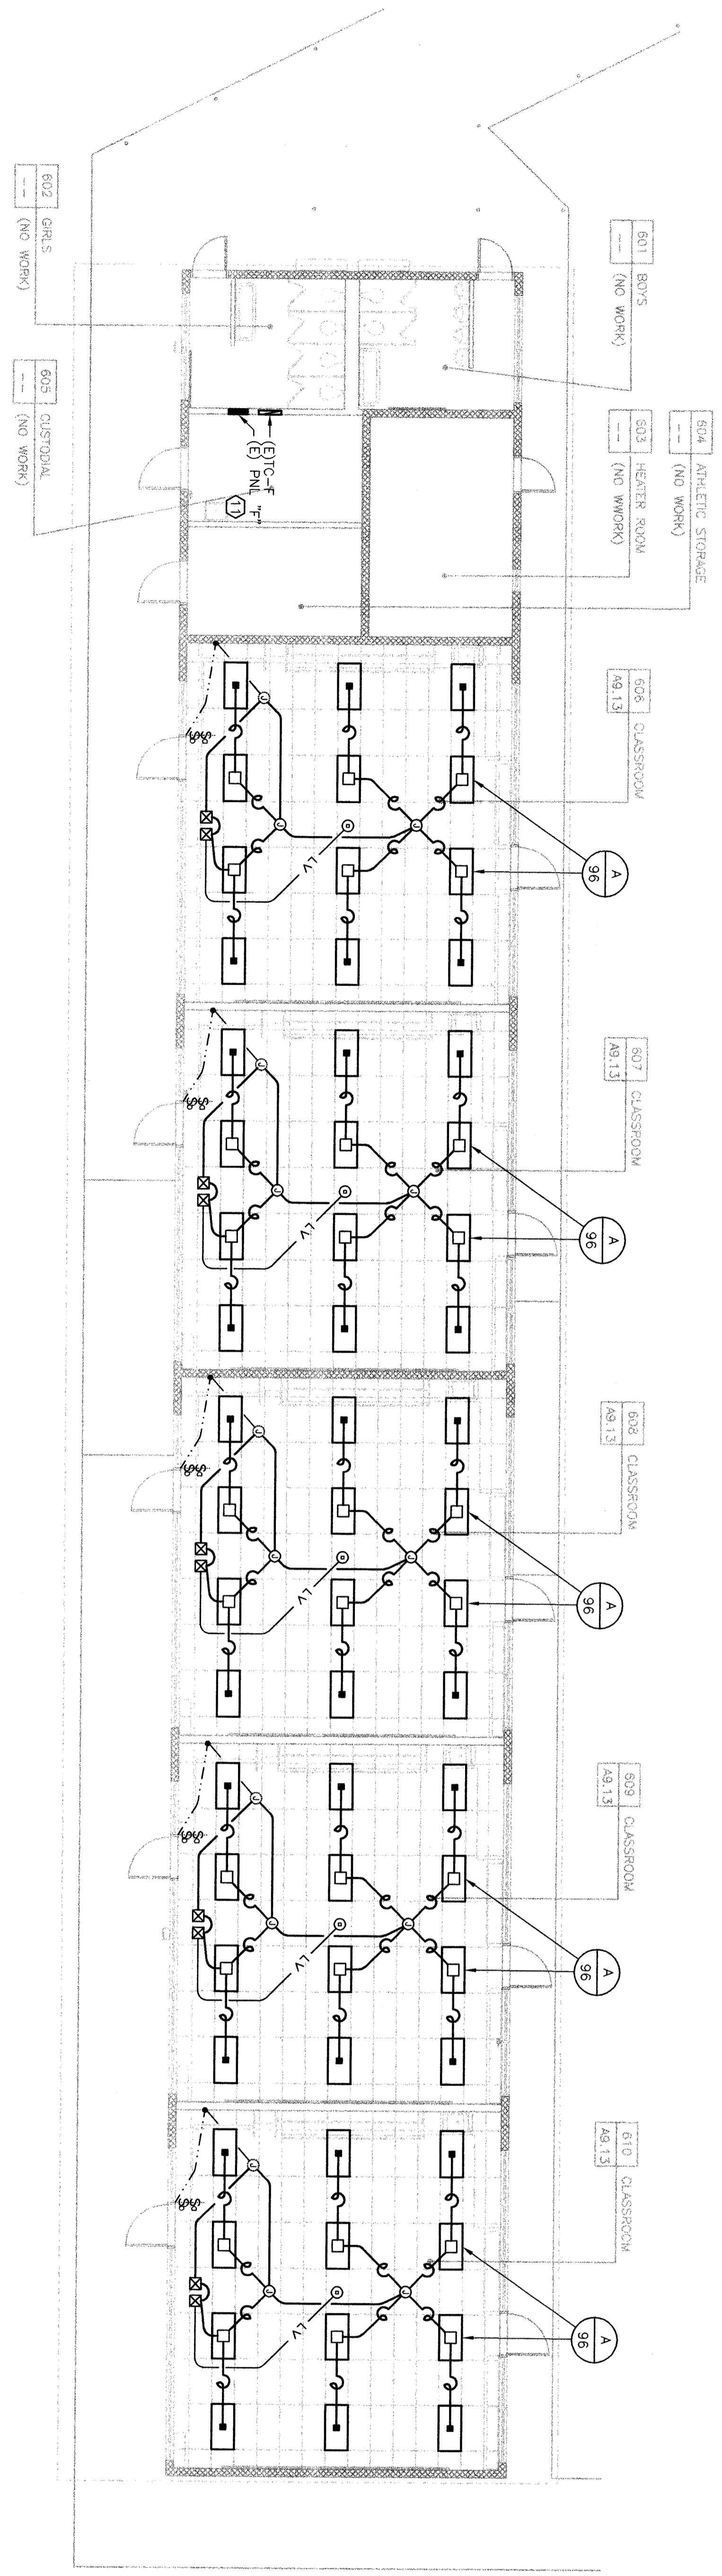

LIGHTING FLOOR PLAN BLDG. 600

KEYNOTES

- NOTE: KEYNOTES IN THIS LIST MAY NOT NECESSARILY OCCUR ON THIS SHEET.
- 1 INSTALL WIREMOLD # 5400 WITH OUTLETS AT 30" O.C. COORDINATE W/IG. HEIGHT WITH ARCHITECT'S ELEVATIONS.
 - 2 REPLACE EXISTING EXTERIOR DOWNLIGHT. USE REIMPOUT KIT FIXTURE TYPE "F".
 - 3 REPLACE EXISTING WALL BRACKET FIXTURE. USE FIXTURE TYPE "C".
 - 4 REPLACE EXISTING FIXTURES. USE FIXTURES TYPE "C".
 - 5 DISCONNECT AND REMOVE EXISTING 2x4 SURFACE METAL SPOOD FIXTURES. REUSE (E) HOME RUN AS APPLICABLE.
 - 6 REPLACE EXISTING FIXTURE WITH NEW FIXTURE TYPE "D". EXISTING FIXTURE TO REMAIN.
 - 7 EXISTING 2x4 SURFACE METAL SPOOD FIXTURES WITH (2) REPLACE EXISTING WITH (2) 18 LUMENS. REPLACE BALUST. REPLACE LENS WITH KSH K12.125 ACRYLIC LENS.
 - 8 DISCONNECT AND REMOVE EXISTING FIXTURES.
 - 9 WIREMOLD # 5400 RISER UP TO CEILING.
 - 10 REPLACE (E) PANEL, "T", NEW PANEL SHALL HAVE (42) 20/1 BREAKERS, 100A BUS. USE SQUARE "D" WOOD(B) OR EQUAL. RECONNECT (E) CIRCUITS AND FEEDER.

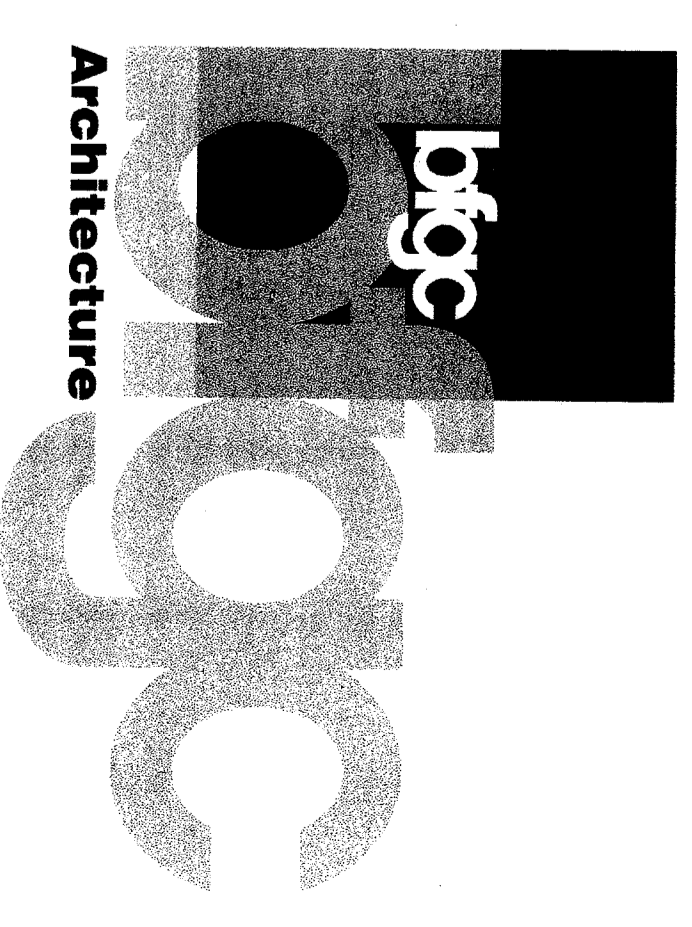

Bakersfield
5500 miwg. ovrnht, suite 450, Bakersfield, ca 93309
661.836.4300 fax 661.836.4311

San Jose
1000 mca, callenue 95113
408.242.8444

San Luis Obispo
4115 bond street, suite 10-5
san luis obispo, ca 93401
for 805.546.6004

Oakland
350 oak street, suite 300
oakland, ca 94612
510.881.0074

Principal Architects
400 W. Fairbank Ave., Suite 100
Fresno, California 93711
(559) 432-4500 / (559) 432-4544 fax
400 W. Fairbank Ave., Suite 100
Fresno, CA 93711
C-5134
E.E. #9101

REGISTERED PROFESSIONAL ENGINEER
James W. Gordon, Electrical Engineer
ESTABLISHED 1958

FILE NO. 15-6
DEMOLITION STAMP
DATE: AUG 28 2003
DRAWN BY: T.A.
CHECKED BY: D.G.
DATE: AUG 28 2003

MODERNIZATION
FOR
COLONEL HOWARD NICHOLS
SCHOOL
3401 RENEGADE AVE.
BAKERSFIELD, CA 93306
BAKERSFIELD CITY
SCHOOL DISTRICT

BUILDING 600
DEMOLITION AND
LIGHTING
FLOOR PLANS

Version Date: 02-127
Job no.: 06/24/03
drawn by: T.A.
date: 06/24/03
checked by: D.G.
© copyright 2003