




BUILDING 500 PLUMBING DEMO FLOOR PLAN
SCALE: 1/8"=1'-0"

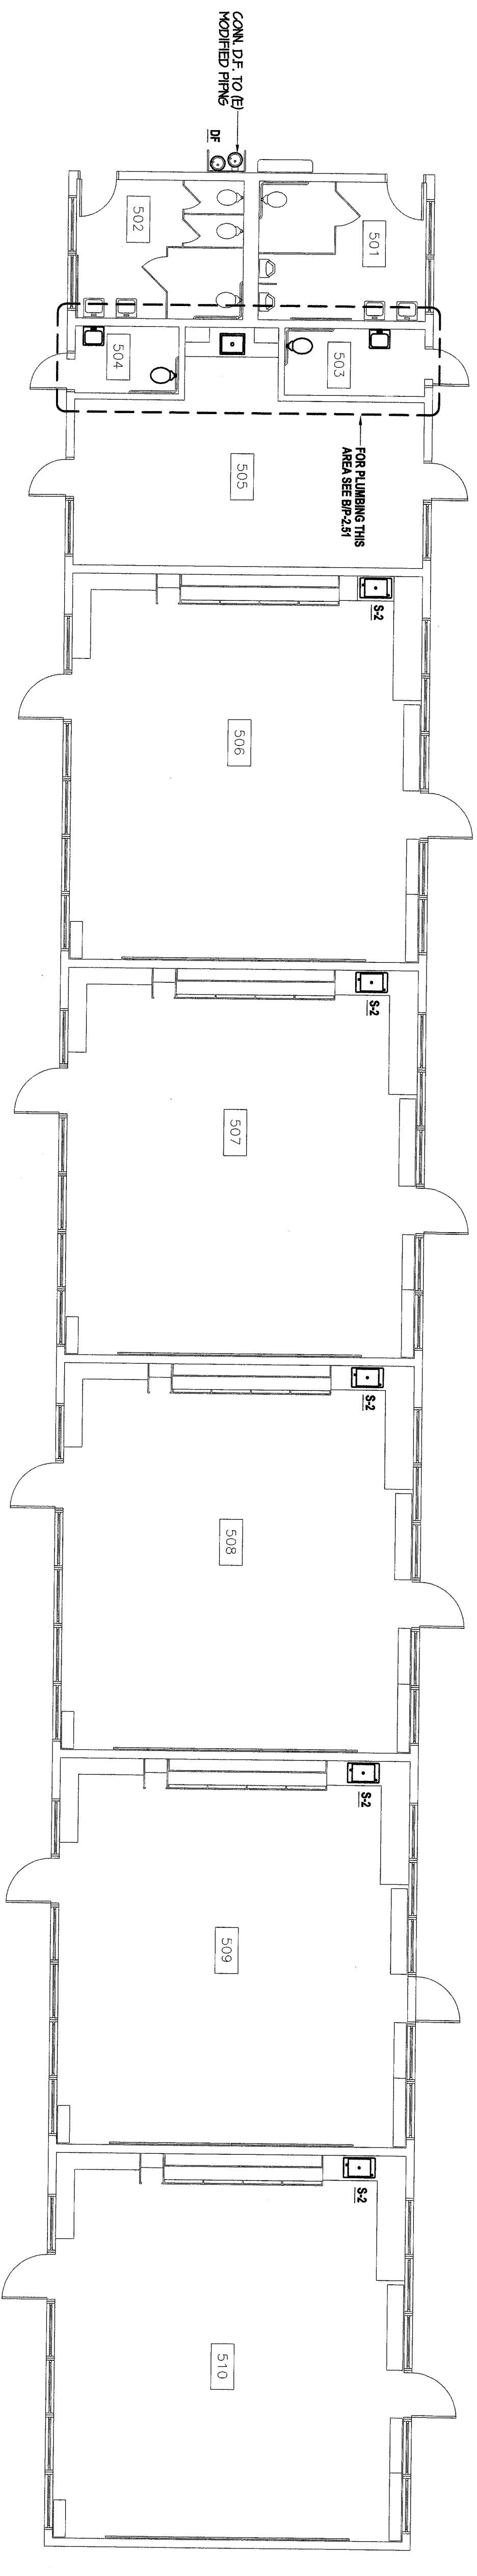


BUILDING 500 PLUMBING FLOOR PLAN
SCALE: 1/8"=1'-0"

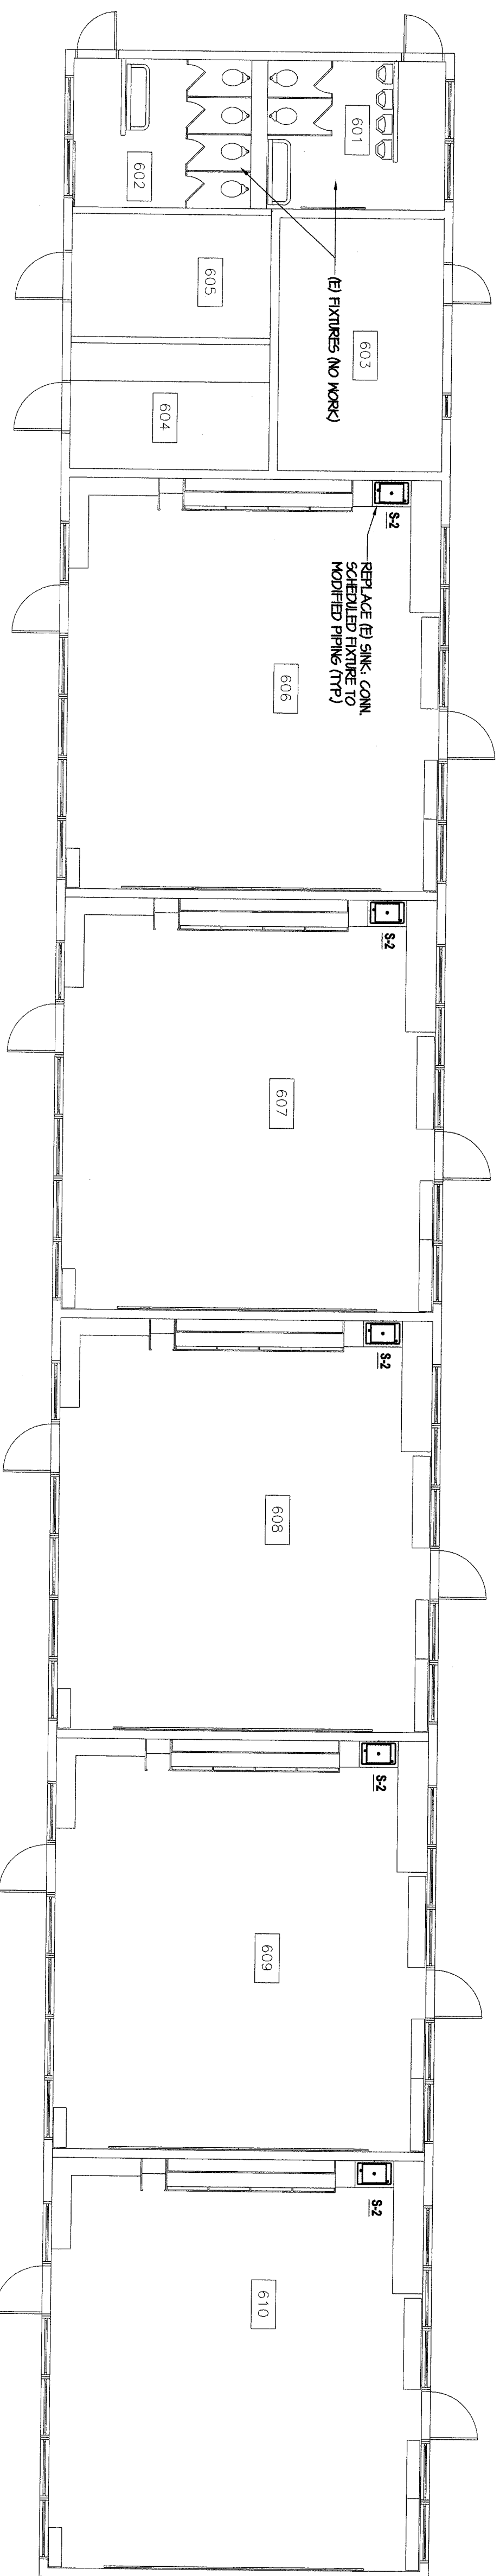

BUILDING 600 PLUMBING FLOOR PLAN
SCALE: 1/8"=1'-0"

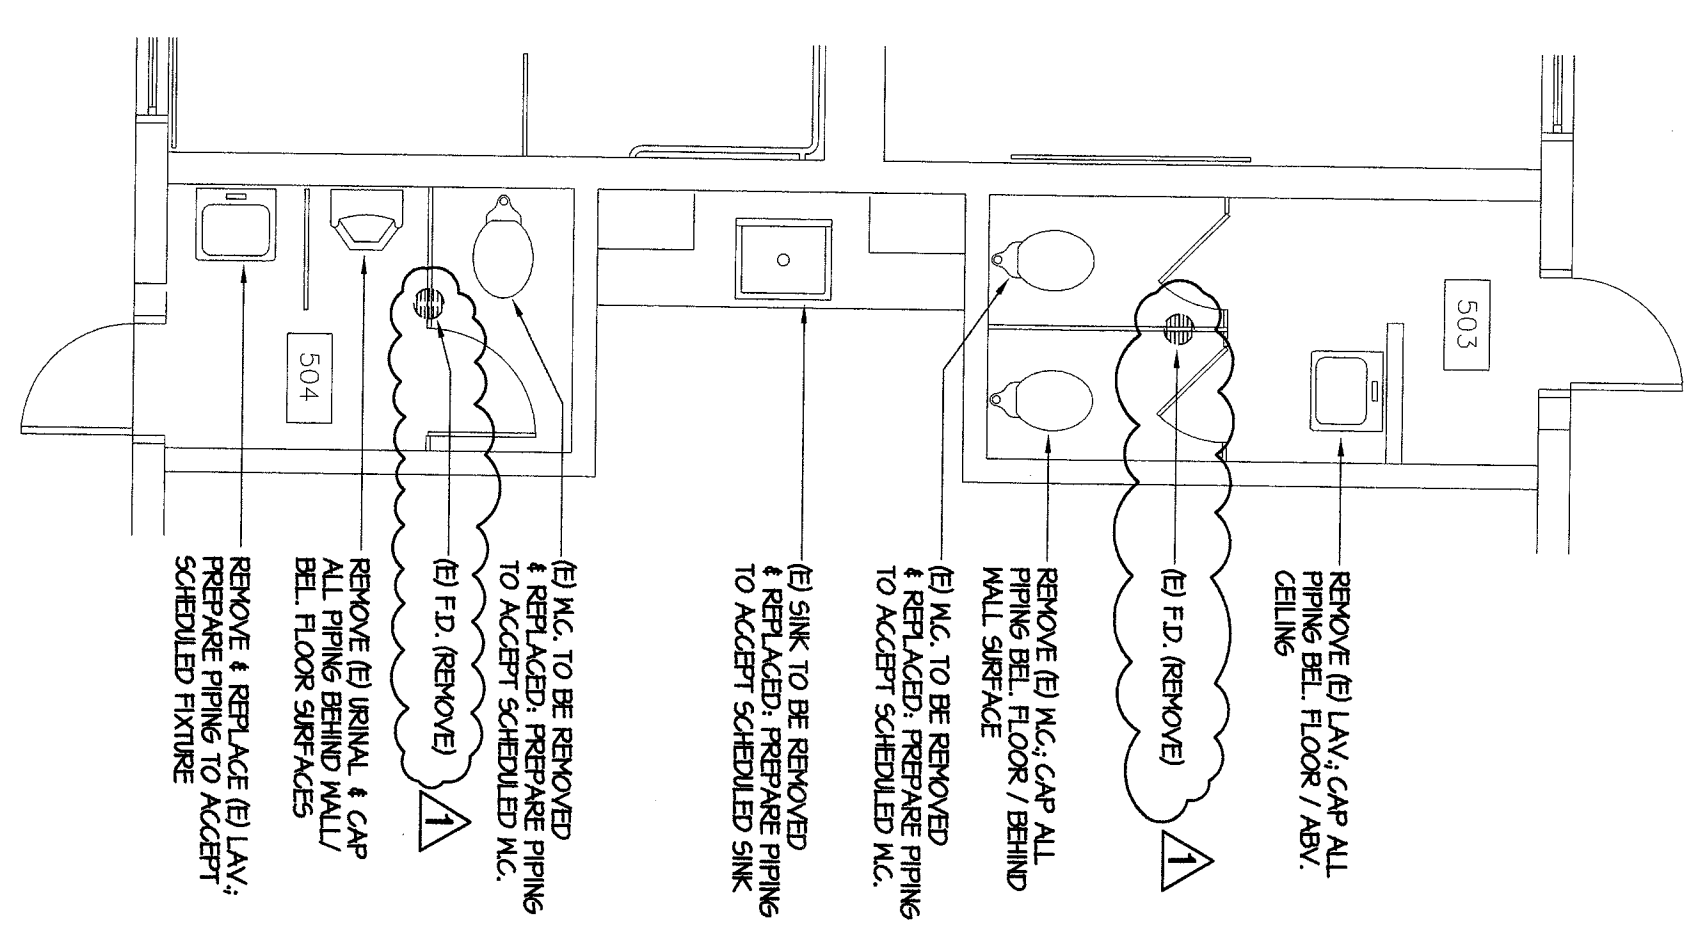

PARTIAL PLB.G. DEMO FLOOR PLAN (A)
SCALE: 1/4"=1'-0"

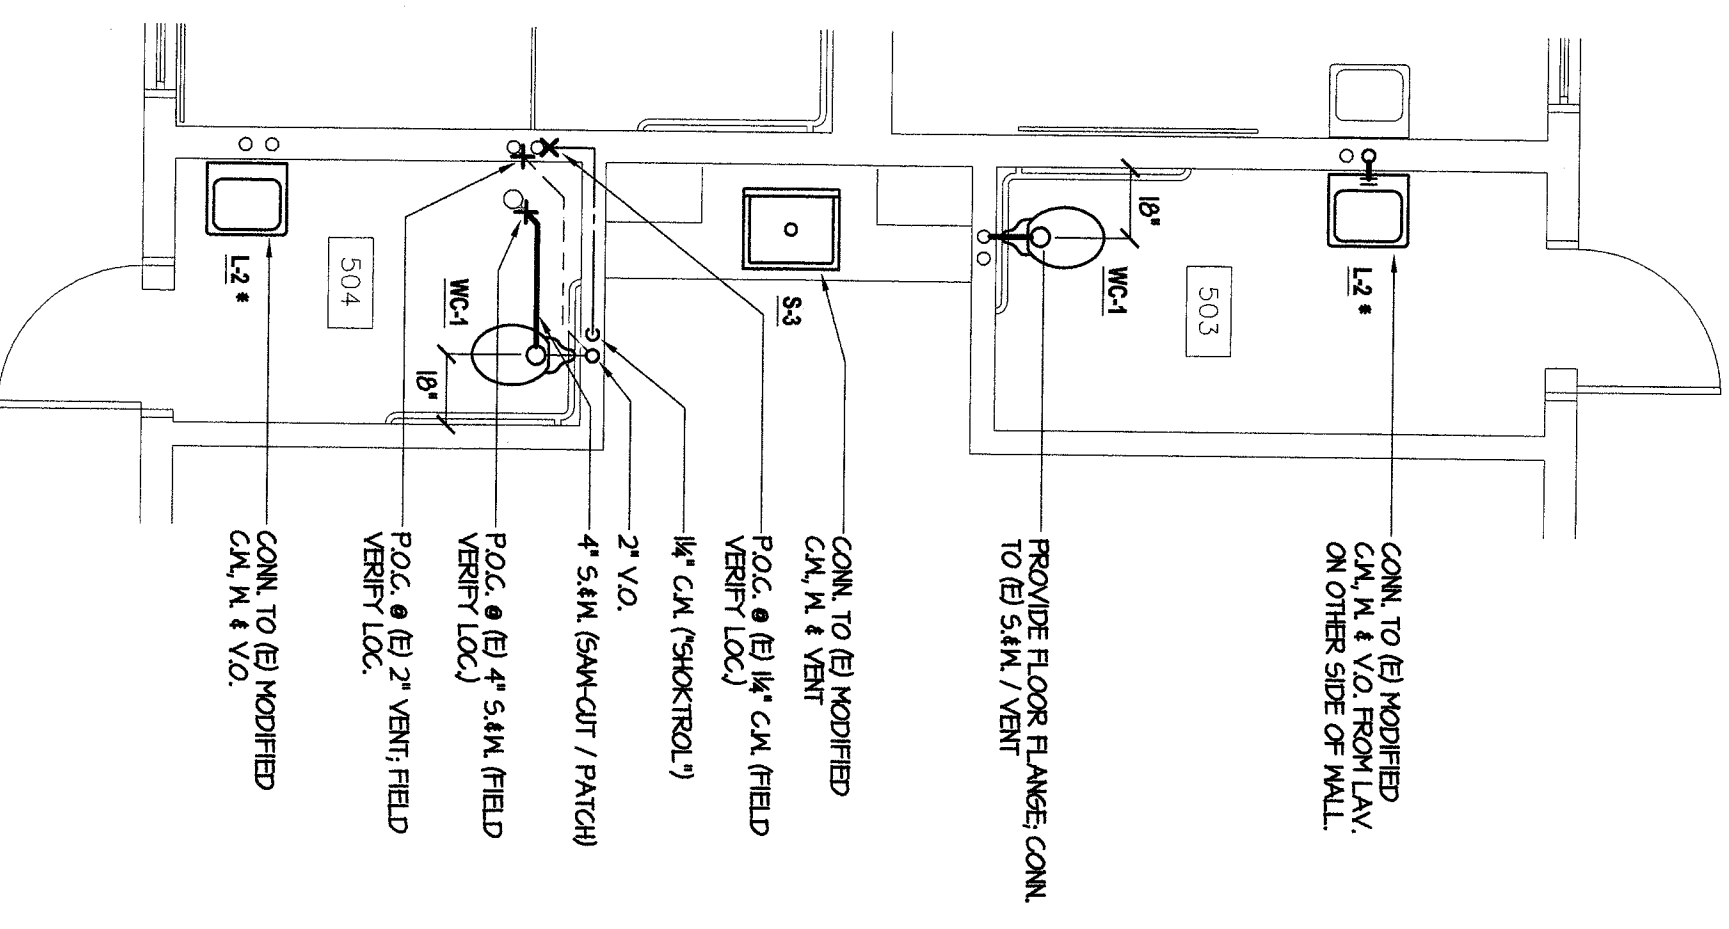

PARTIAL PLUMBING FLOOR PLAN (B)
SCALE: 1/4"=1'-0"




Bakersfield
5500 ring avenue, suite 450, bakersfield, ca 93309
661.836.4300
661.836.4311

San Jose
150 south first st., suite 200
san jose, ca 95113
408.924.0841
408.924.0844

San Luis Obispo
4111 hwy 101, suite 100
san luis obispo, ca 93401
805.546.4133
805.546.4134

Oakland
350 frank ogawa plaza, suite 300
oakland, california 94612
510.881.0571

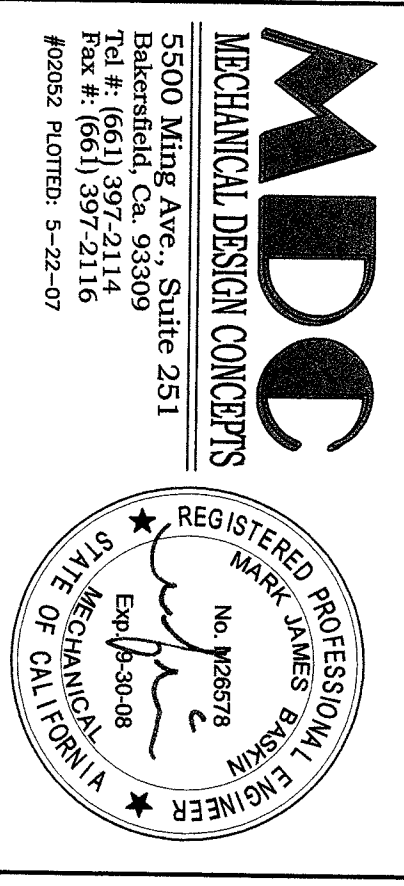

rev. no.	rev. date	revision
△		
△		
△		
△	5-25-07	OWNER REVISION

PROJECT TRACKING NO. 63321-10
FILE NO. 15-6
REGISTRATION STAMP
DIV. OF THE STATE ARCHITECT
APP. NO. 03-106647
AC FLS SS
DATE

MODERNIZATION
FOR
COL. HOWARD
NICHOLS SCHOOL
3401 RENEGADE AVE.
BAKERSFIELD, CA 93306
BAKERSFIELD CITY
SCHOOL DISTRICT

PLUMBING FLOOR PLAN & DEMO - BUILDING 500 & 600

Version Date:	Version Time:
Job no. 500	
date 10/23/02	
drawn by M. ANDERSON	
chk'd by R. BANKS	
©copyright 2002	

