


UNIT "B" FLOOR PLAN - ELECTRICAL LAYOUT
 SCALE 1/8" = 1'-0"



DETAIL: DAVIS DIVANER - "MODEL" # 120W. - 120V. 50/60 Hz. AC
 NO. SCALE

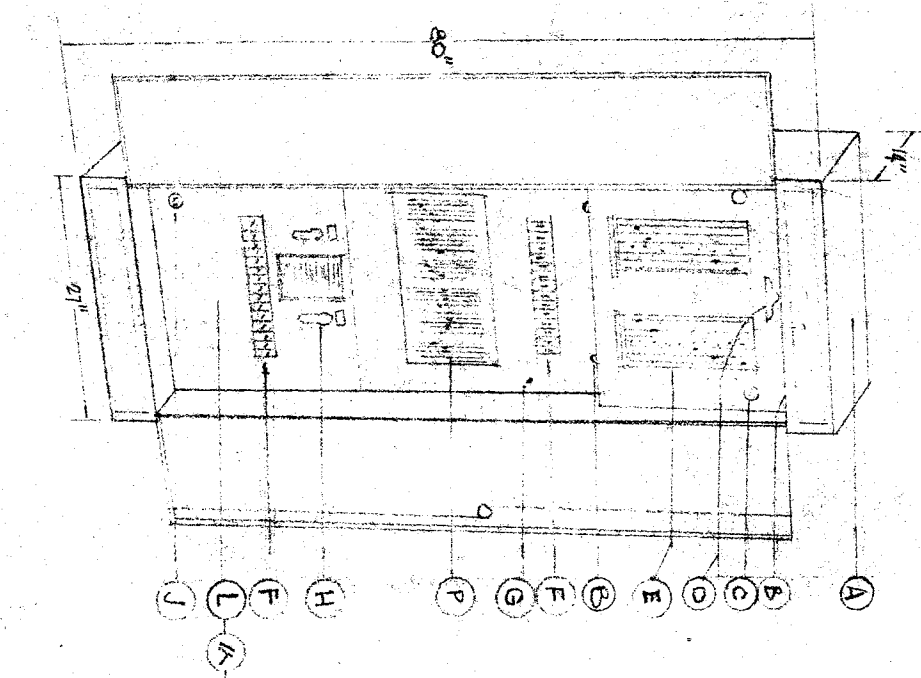


- A. 1 CABINET
- B. 4 OPERATOR LIGHTS (Globe Type)
- C. 1 OPERATOR LIGHT (Globe Type)
- D. 1 OPERATOR LIGHT (Globe Type)
- E. 1 OPERATOR LIGHT (Globe Type)
- F. 1 OPERATOR LIGHT (Globe Type)
- G. 1 OPERATOR LIGHT (Globe Type)
- H. 1 OPERATOR LIGHT (Globe Type)
- I. 1 OPERATOR LIGHT (Globe Type)
- J. 1 OPERATOR LIGHT (Globe Type)
- K. 1 OPERATOR LIGHT (Globe Type)
- L. 1 OPERATOR LIGHT (Globe Type)
- M. 1 OPERATOR LIGHT (Globe Type)
- N. 1 OPERATOR LIGHT (Globe Type)
- O. 1 OPERATOR LIGHT (Globe Type)
- P. 1 OPERATOR LIGHT (Globe Type)
- Q. 1 OPERATOR LIGHT (Globe Type)
- R. 1 OPERATOR LIGHT (Globe Type)
- S. 1 OPERATOR LIGHT (Globe Type)
- T. 1 OPERATOR LIGHT (Globe Type)
- U. 1 OPERATOR LIGHT (Globe Type)
- V. 1 OPERATOR LIGHT (Globe Type)
- W. 1 OPERATOR LIGHT (Globe Type)
- X. 1 OPERATOR LIGHT (Globe Type)
- Y. 1 OPERATOR LIGHT (Globe Type)
- Z. 1 OPERATOR LIGHT (Globe Type)

NOTE:
 1. ALL ELECTRICAL CONTRACTORS SHALL FURNISH
 2. ALL MATERIALS, INCLUDING NECESSARY SUPPLIES,
 3. ALL LABOR AND EXPENSES FOR THIS UNIT.
 4. ALL MATERIALS SHALL BE APPROVED BY THE ARCHITECT.

DETAIL DISAPPEARING FOOTLIGHTS - REMOVABLE
 SCALE 1/4" = 1'-0"

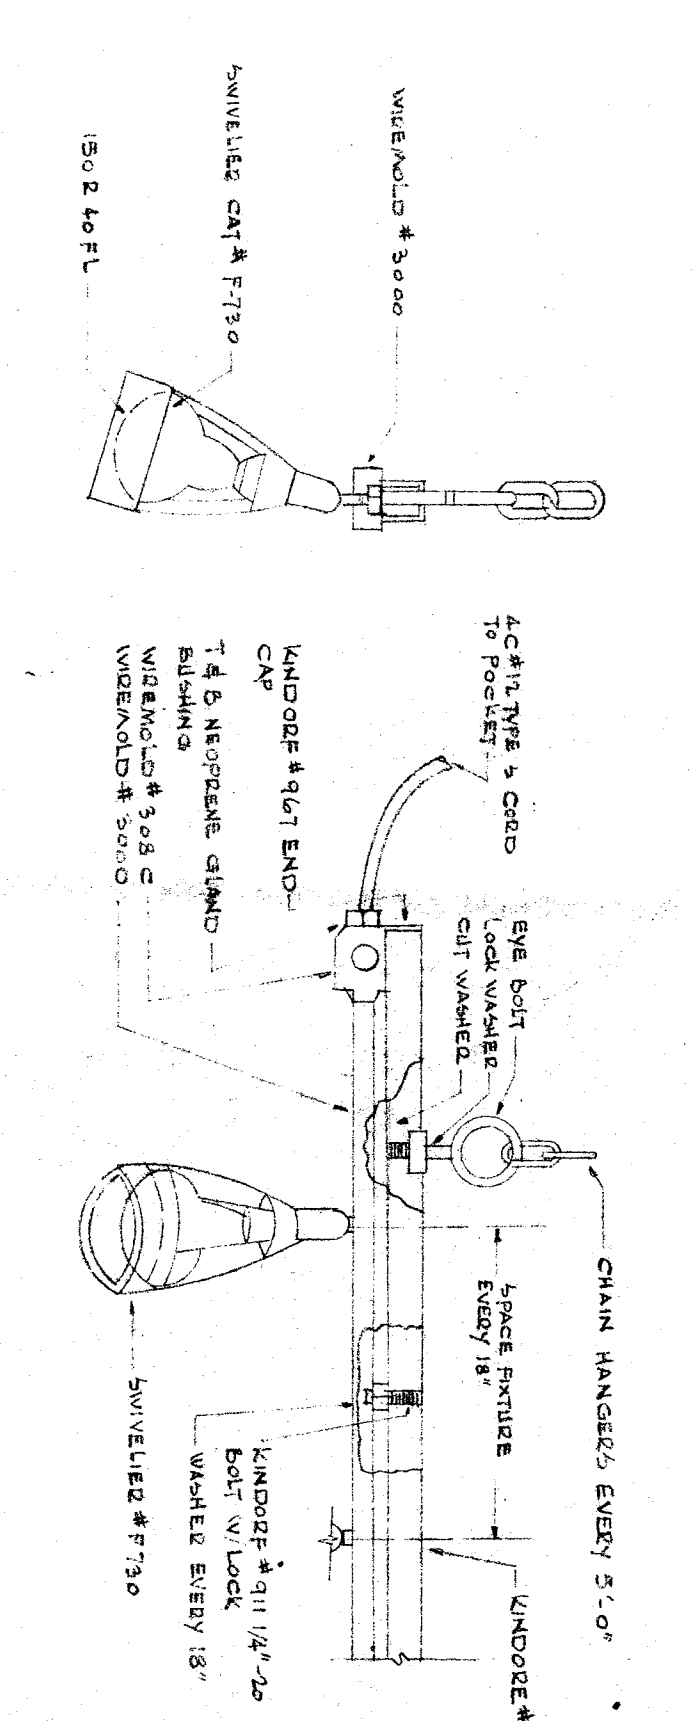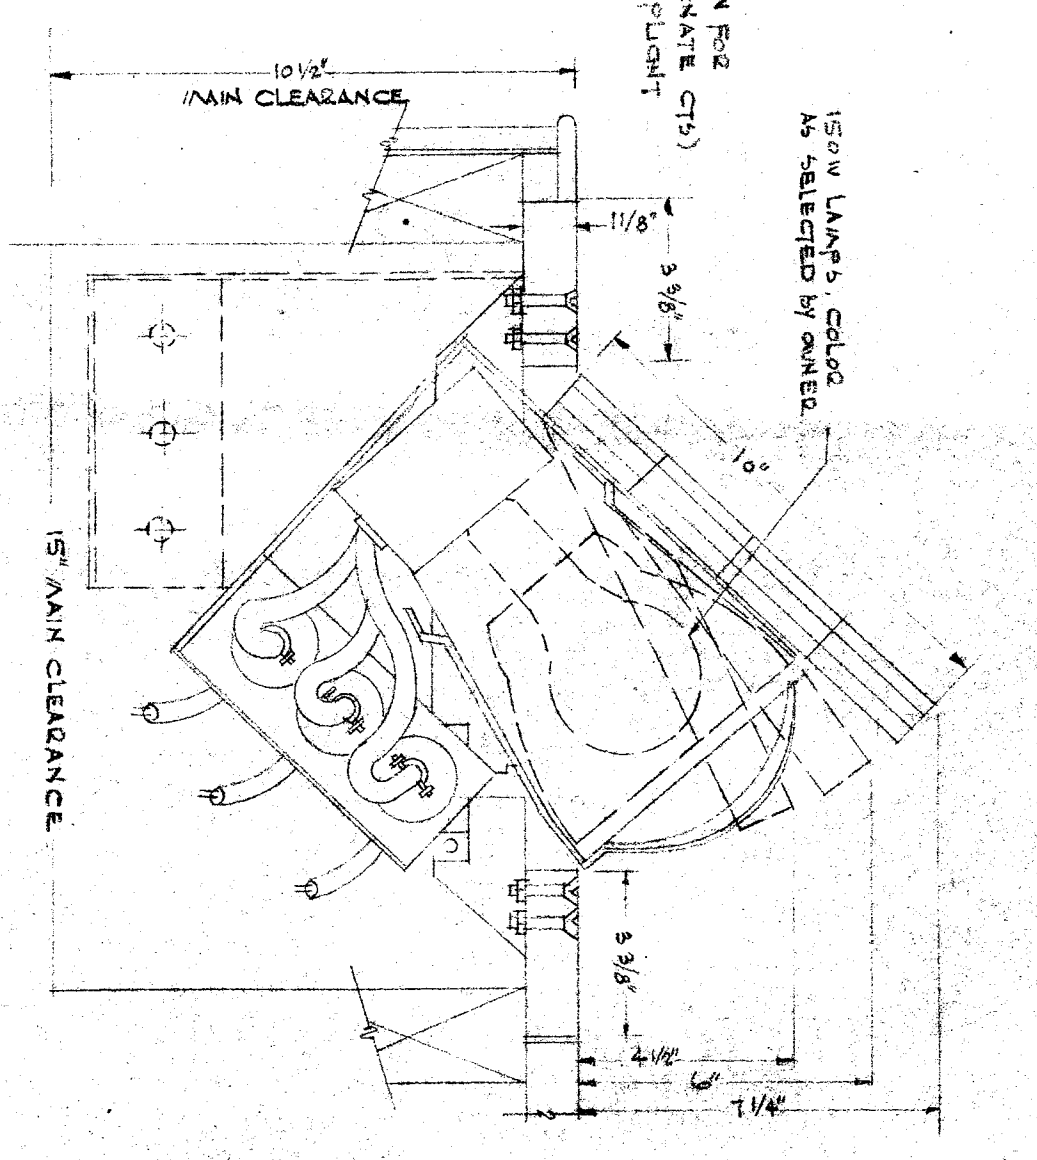

DETAIL SPECIAL BORDER
 SCALE 1/8" = 1'-0"

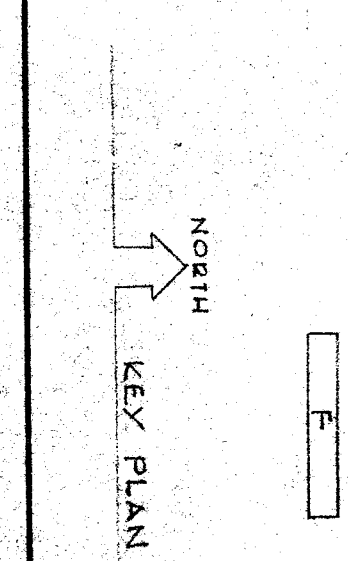

OFFICE OF SUPERINTENDENT OF SCHOOLS
 DEPARTMENT OF PUBLIC WORKS
 DIVISION OF ARCHITECTURE

APPROVED
 DATE

CHECK AND VERIFY ALL DIMENSIONS AND CONDITIONS AT JOB SITE BEFORE PROCEEDING WITH THE WORK. REPORT ANY DISCREPANCIES TO THE ARCHITECT.

DATE	REVISIONS

SECTION 15 SCHOOL
 PASADENA ST. & GARDEN ST. AND
 BAYERSFIELD, CALIFORNIA

ERNEST L. MCCOY A.I.A. ARCHITECT
 2811 N. STREET
 PASADENA, CALIFORNIA