


HEATING		UNIT		SCHEDULE	
SYMBOL	MAKE & TYPE	MODEL	OPERATIONAL CAPACITY	INPUT	OUTPUT
A	SCHEMUNNUEB DIV 1250	1250	60 MIN.	1/2	1/2
B	AMERICAN BLOWER	4-1/2	1/5 MIN.	1/2	1/2
C	AMERICAN BLOWER	4-1/2	1/5 MIN.	1/2	1/2
D	AMERICAN BLOWER	4-1/2	1/5 MIN.	1/2	1/2
E	AMERICAN BLOWER	4-1/2	1/5 MIN.	1/2	1/2

D.U.P. SCHEDULE		MAKE AND TYPE	
SYMBOL	PIA	WATT	HP
A	20	40	1
B	30	60	2
C	30	100	2
D	50	60	2

EXHAUST FAN SCHEDULE		MAKE AND TYPE	
SYMBOL	CFM	S.P.	HP
A	3000	3/8	1/2
B	600	1/2	1/2
C	200	1/2	1/2
D	130	1/2	1/2

SCHEDULE OF BOILERS					
BLDG.	USE	LOCATION	SYN.	MODEL	INPUT
UNIT 5		UNIT 5	PERFECS	750	600 MBH
UNIT A-C-D		UNIT A-C-D	PERFECS	750	900 MBH
UNIT E-F		UNIT E-F	PERFECS	750	900 MBH

NOTE: REFER TO MECHANICAL PLAN OF MECH. ROOMS FOR CONNECTIONS AND DIMENSIONS.

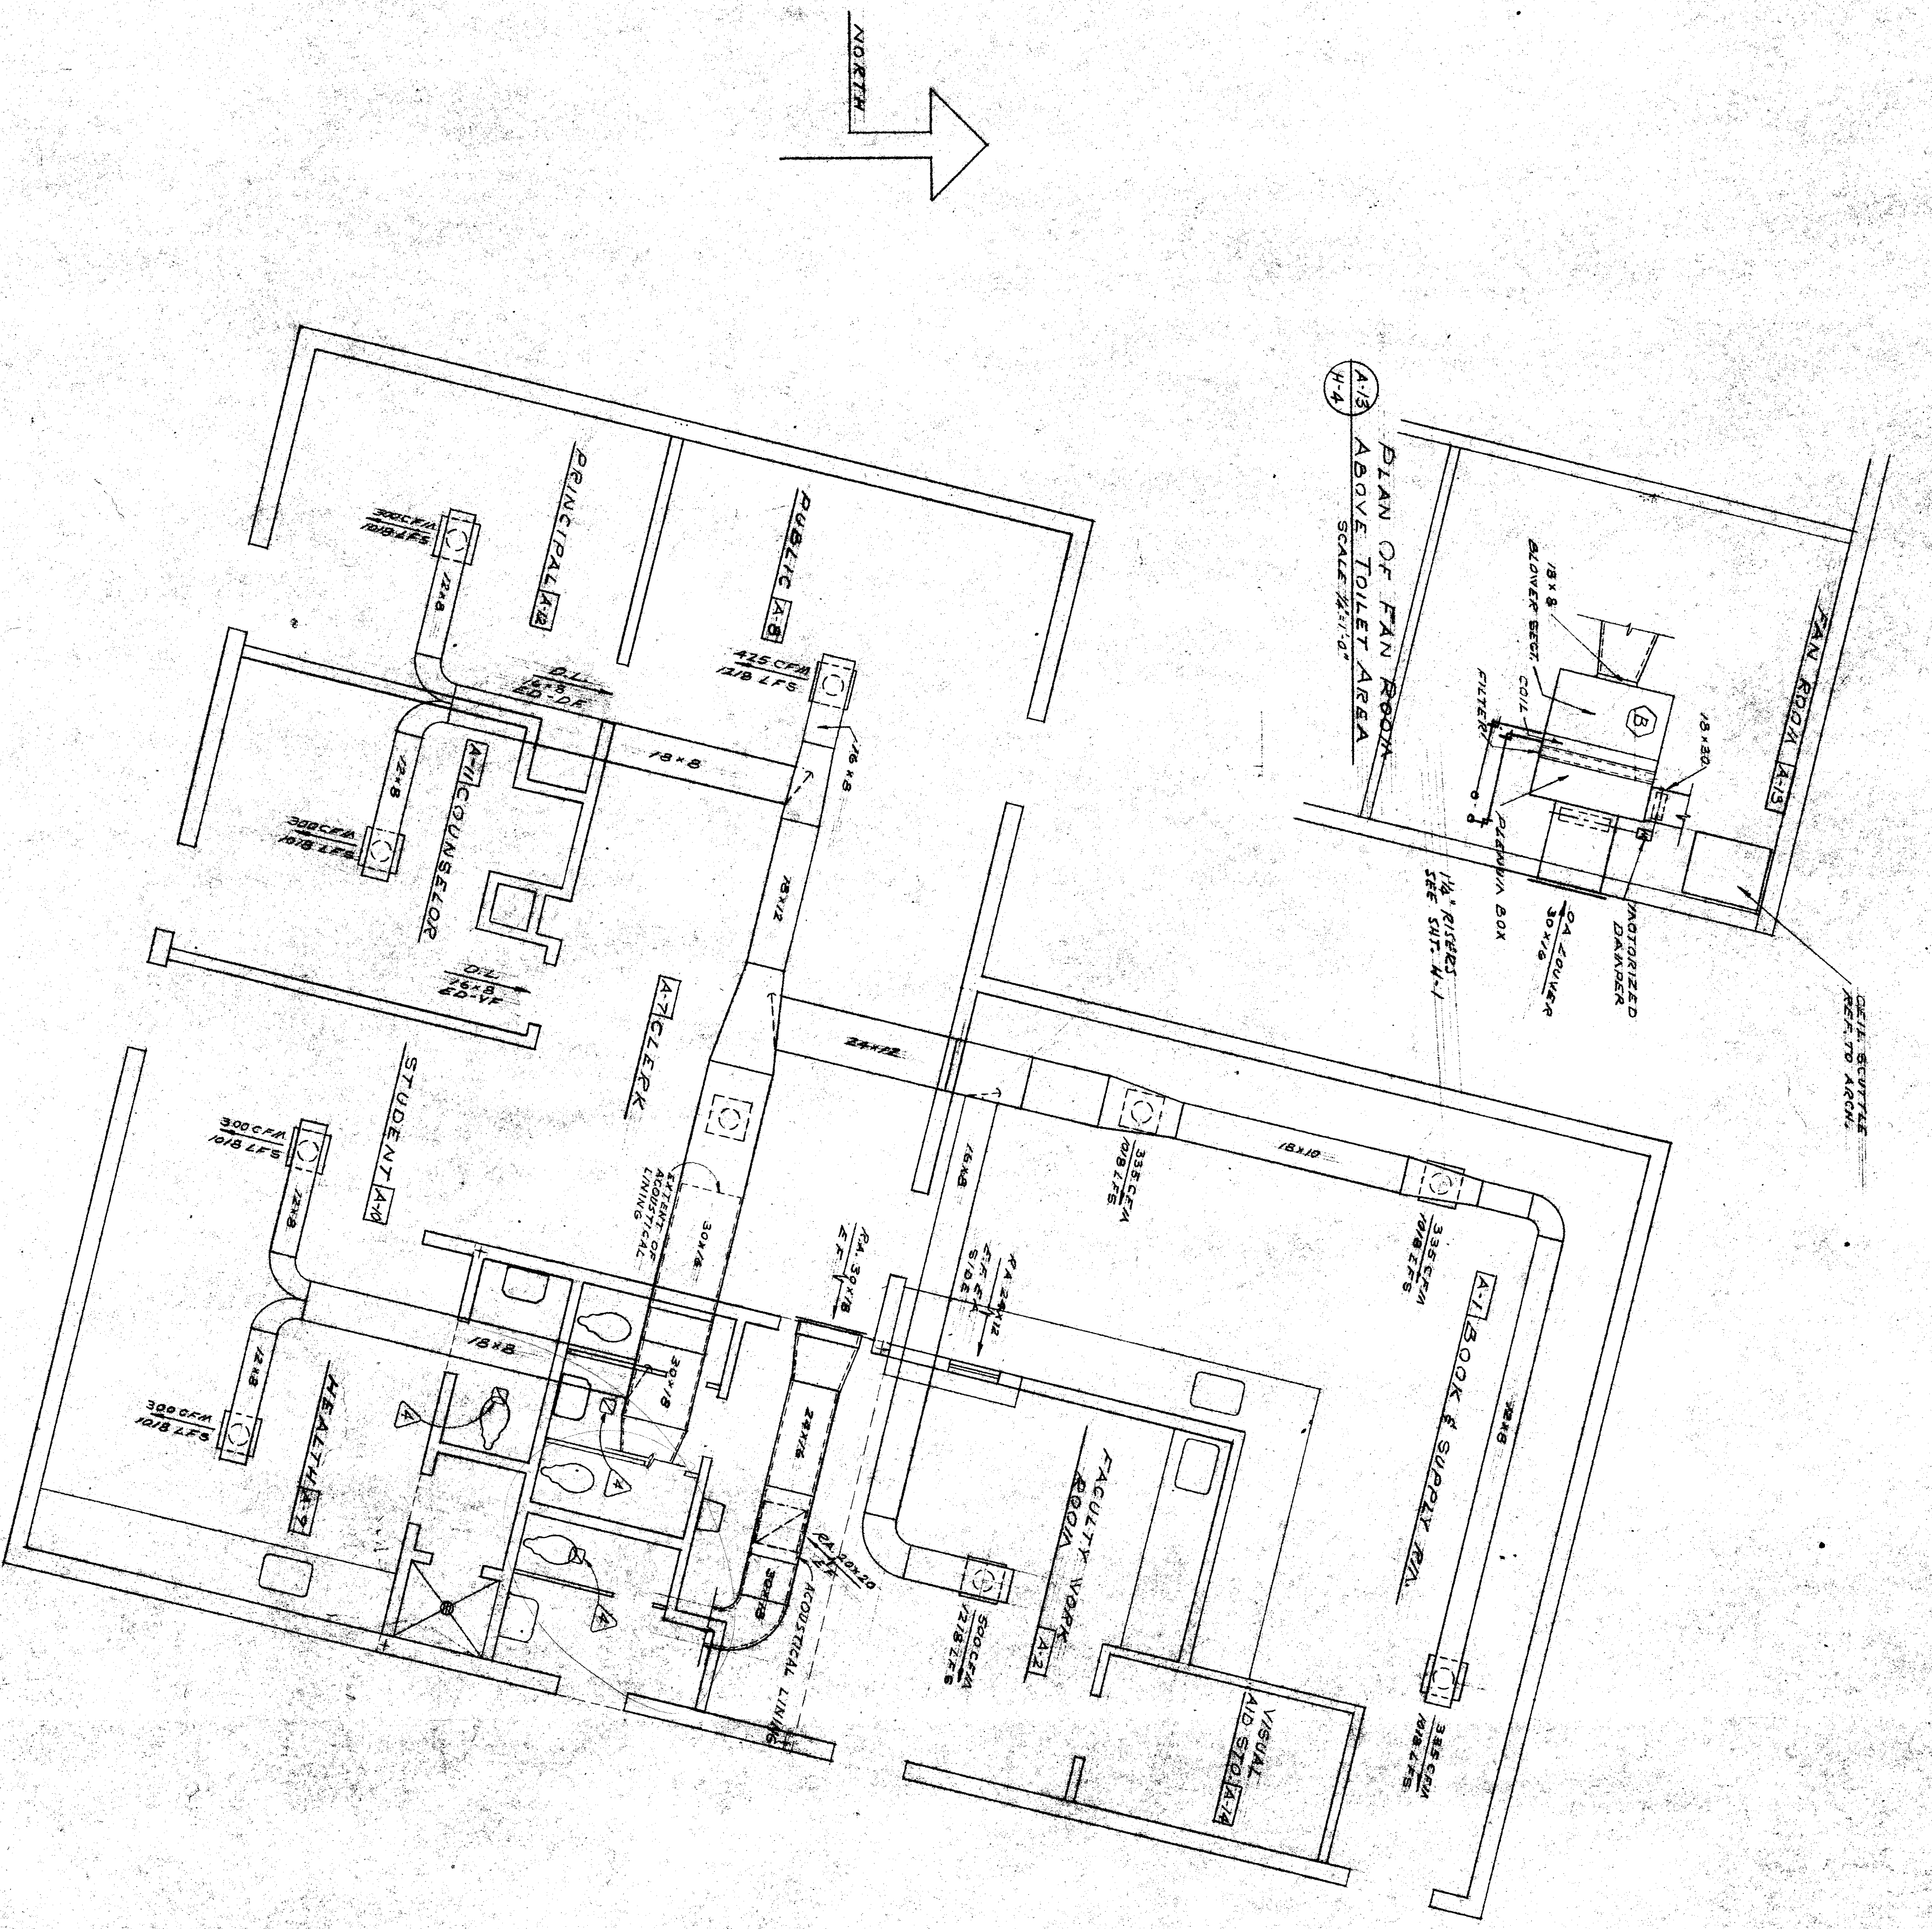

A FLOOR PLAN OF UNIT A

OFFICE OF SUPERINTENDENT OF SCHOOLS
 STATE OF CALIFORNIA
 DEPARTMENT OF PUBLIC WORKS
 DIVISION OF ARCHITECTURE

DATE: 2-13-1960
 PROJECT NO. 20571
 DRAWN BY: S. M. ...

SECTION 15 SCHEDULE
 PASADENA SR & KENNEDY AVE.
 PASADENA, CALIFORNIA