



**ORDIZ MELBY**  
ARCHITECTS, INC.

5500 MING AVENUE SUITE 280  
BAKERSFIELD, CALIFORNIA 93309  
TELEPHONE (805) 832-5258  
FACSIMILE (805) 832-4291

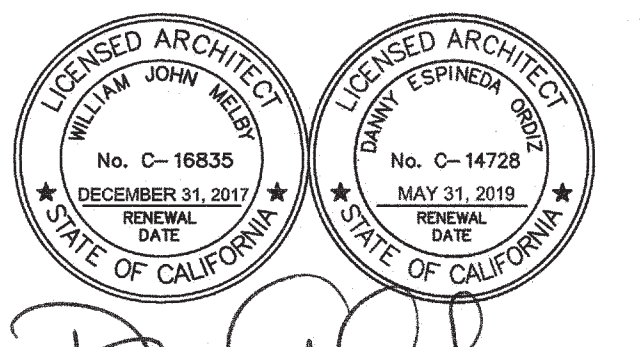

DANNY E. ORDIZ, AIA  
ARCHITECT C-14728  
WILLIAM J. MELBY, AIA  
ARCHITECT C-16635


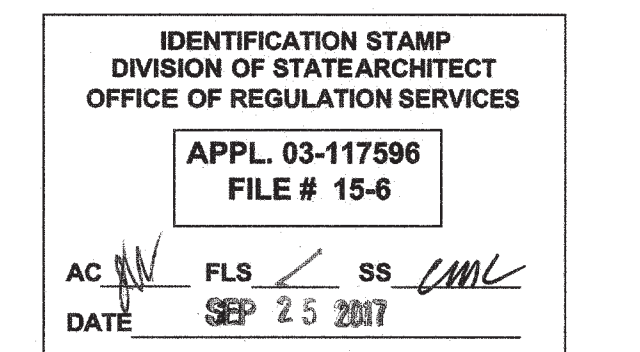


**DEMOLITION KEYNOTES**


- 1 REMOVE (E) SURFACE MOUNTED WIRE MOLD AND ASSOCIATED WIRING
- 2 REMOVE (E) INTERIOR WALL FINISHES DOWN TO WOOD FRAMING/SHEATHING
- 3 REMOVE (E) SMART BOARD AND SHORT THROW PROJECTOR. STORE, PROTECT, AND COORDINATE W/BCSD I.T. STAFF.
- 4 REMOVE (E) SURFACE MOUNTED JUNCTION BOXES. REPLACE WITH RECESSED DEVICE AS REQUIRED.
- 5 REMOVE (E) CLOCK
- 6 REMOVE (E) SURFACE MOUNTED SPEAKERS AND ASSOCIATED WIRING
- 7 REMOVE (E) SINK AND ASSOCIATED PLUMBING. SEE PLUMBING PLANS.
- 8 REMOVE (E) CASEWORK, UPPER AND LOWER CABINETS
- 9 REMOVE (E) DOOR AND DOOR FRAME. STRUCTURAL FRAMING TO REMAIN IN PLACE.
- 10 REMOVE (E) CHALKBOARD, LIQUID MARKER BOARD, AND/OR CORK BOARDS
- 11 REMOVE AND STORE UNITED STATES FLAG. INSTALL AS DIRECTED BY SCHOOL DISTRICT.
- 12 SALVAGE (E) SURFACE MOUNTED FIRE EXTINGUISHERS
- 13 REMOVE (E) WATER HEATER AND ASSOCIATED PLUMBING. SEE PLUMBING DRAWINGS.
- 14 REMOVE AND STORE (E) CLOTHES WASHER AND CLOTHES DRYER AND ASSOCIATED PLUMBING. REINSTALL PER MODERNIZATION PLANS.
- 15 REMOVE (E) BOOKSHELVES AND/OR SHELVES
- 16 REMOVE (E) TOILET PARTITIONS
- 17 REMOVE (E) PLUMBING FIXTURES (TOILETS, URINALS, LAVATORIES, ETC)
- 18 REMOVE (E) PLUMBING ACCESSORIES (GRAB BARS, SOAP DISPENSERS, MIRRORS, HAND DRYERS, TOILET PAPER DISPENSERS, ETC)
- 19 REMOVE (E) FLOOR COVERING
- 20 SAW CUT AND REMOVE (E) CONCRETE FLOOR SLAB. SEE FLOOR PLAN FOR NEW LAYOUT.
- 21 REMOVE (E) TV MONITOR AND ASSOCIATED HARDWARE TO SUPPORT IT
- 22 SALVAGE (E) ELECTRIC, POWERED MOVIE SCREEN. COORDINATE WITH BCSD STAFF.
- 23 REMOVE (E) SECURITY EQUIPMENT/CAMERAS. COORDINATE WITH BCSD STAFF.
- 24 REMOVE (E) COMPUTER DEVICE. COORDINATE WITH BCSD STAFF.
- 25 REMOVE (E) TELEPHONE. COORDINATE WITH BCSD STAFF.
- 26 (E) PLUMBING LINE. SEE PLUMBING DRAWINGS TO DETERMINE STATUS
- 27 REMOVE (E) WOOD FRAMED PLATFORM APPROXIMATELY 7'-0" A.F.F.
- 28 REMOVE AND DISPOSE OF (E) STEEL COVER PLATES AND (E) VERTICAL CONDUIT (REFER TO EXTERIOR ELEVATIONS). (E) CONDUIT IN UTILITY TRENCH TO REMAIN IN PLACE.
- 29 REMOVE (E) DOOR AND FRAME IN WALL

**WALL LEGEND**

	EXISTING WALL TO REMAIN
	EXISTING WINDOWS AND DOORS TO REMAIN
	EXISTING WALL TO BE REMOVED
	EXISTING DOOR TO BE REMOVED
	EXISTING WINDOWS TO BE REMOVED

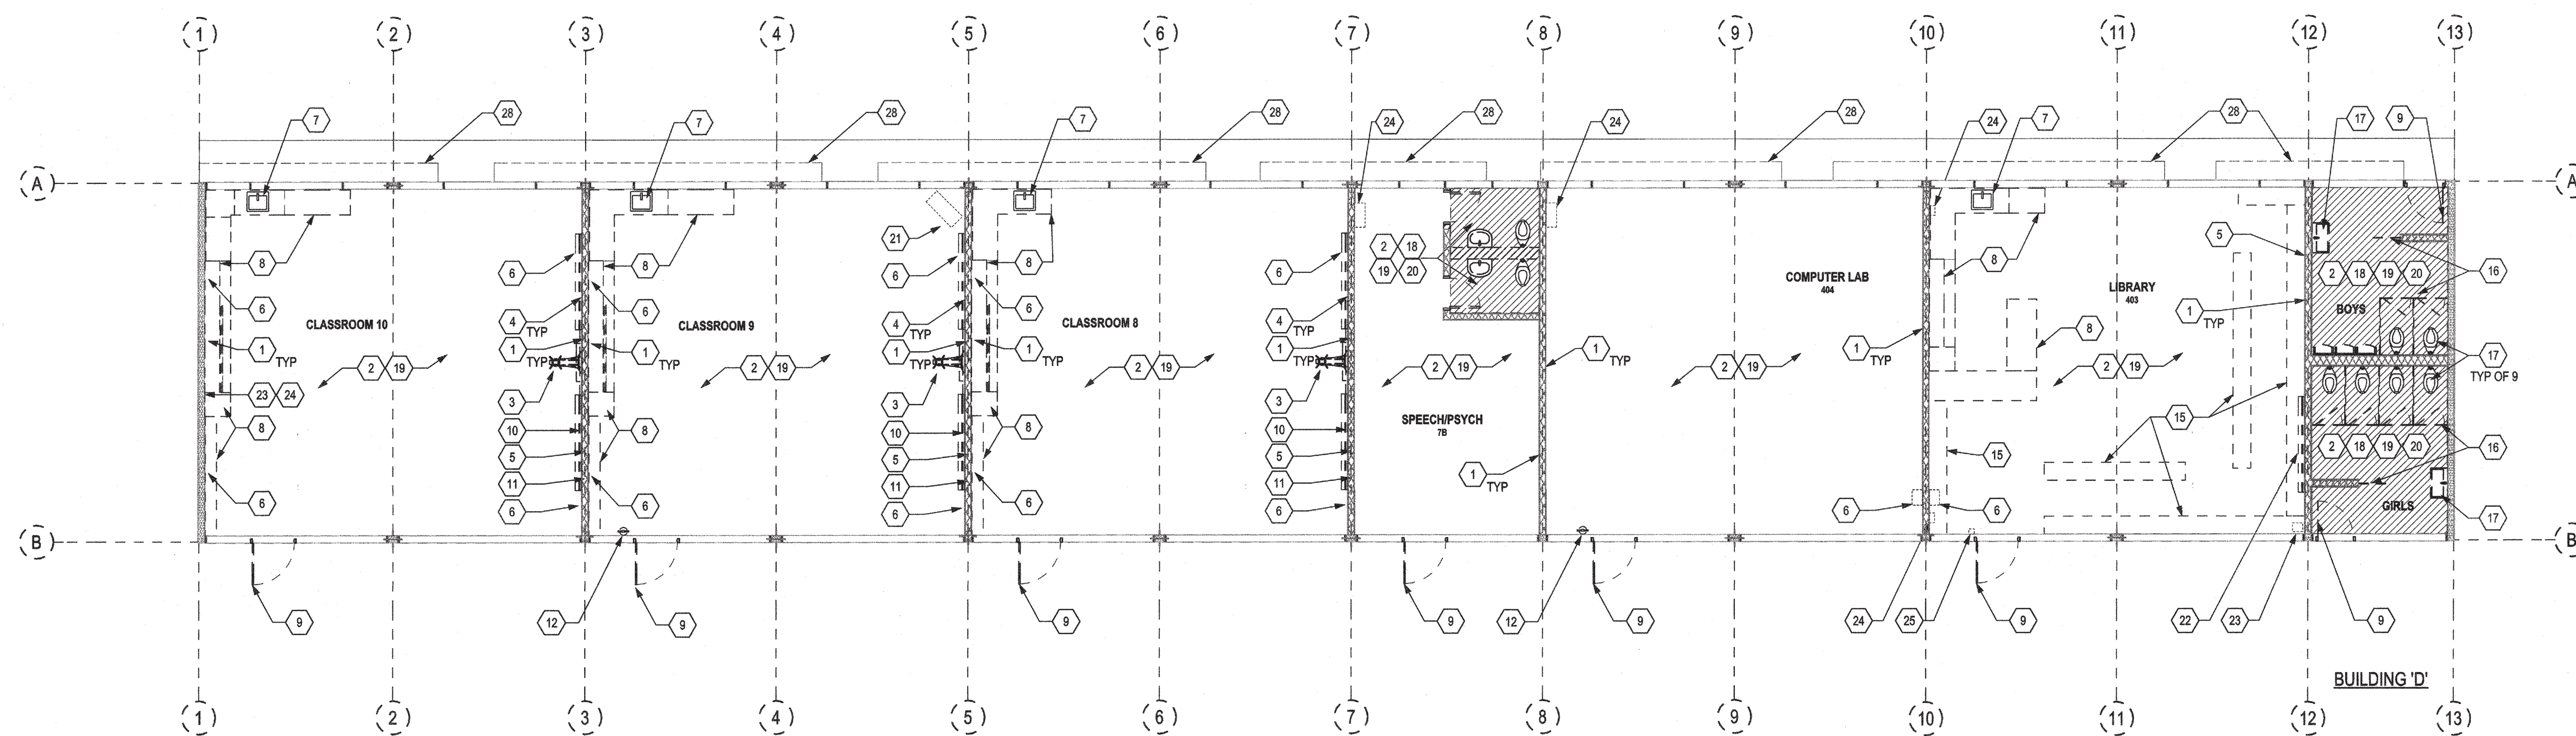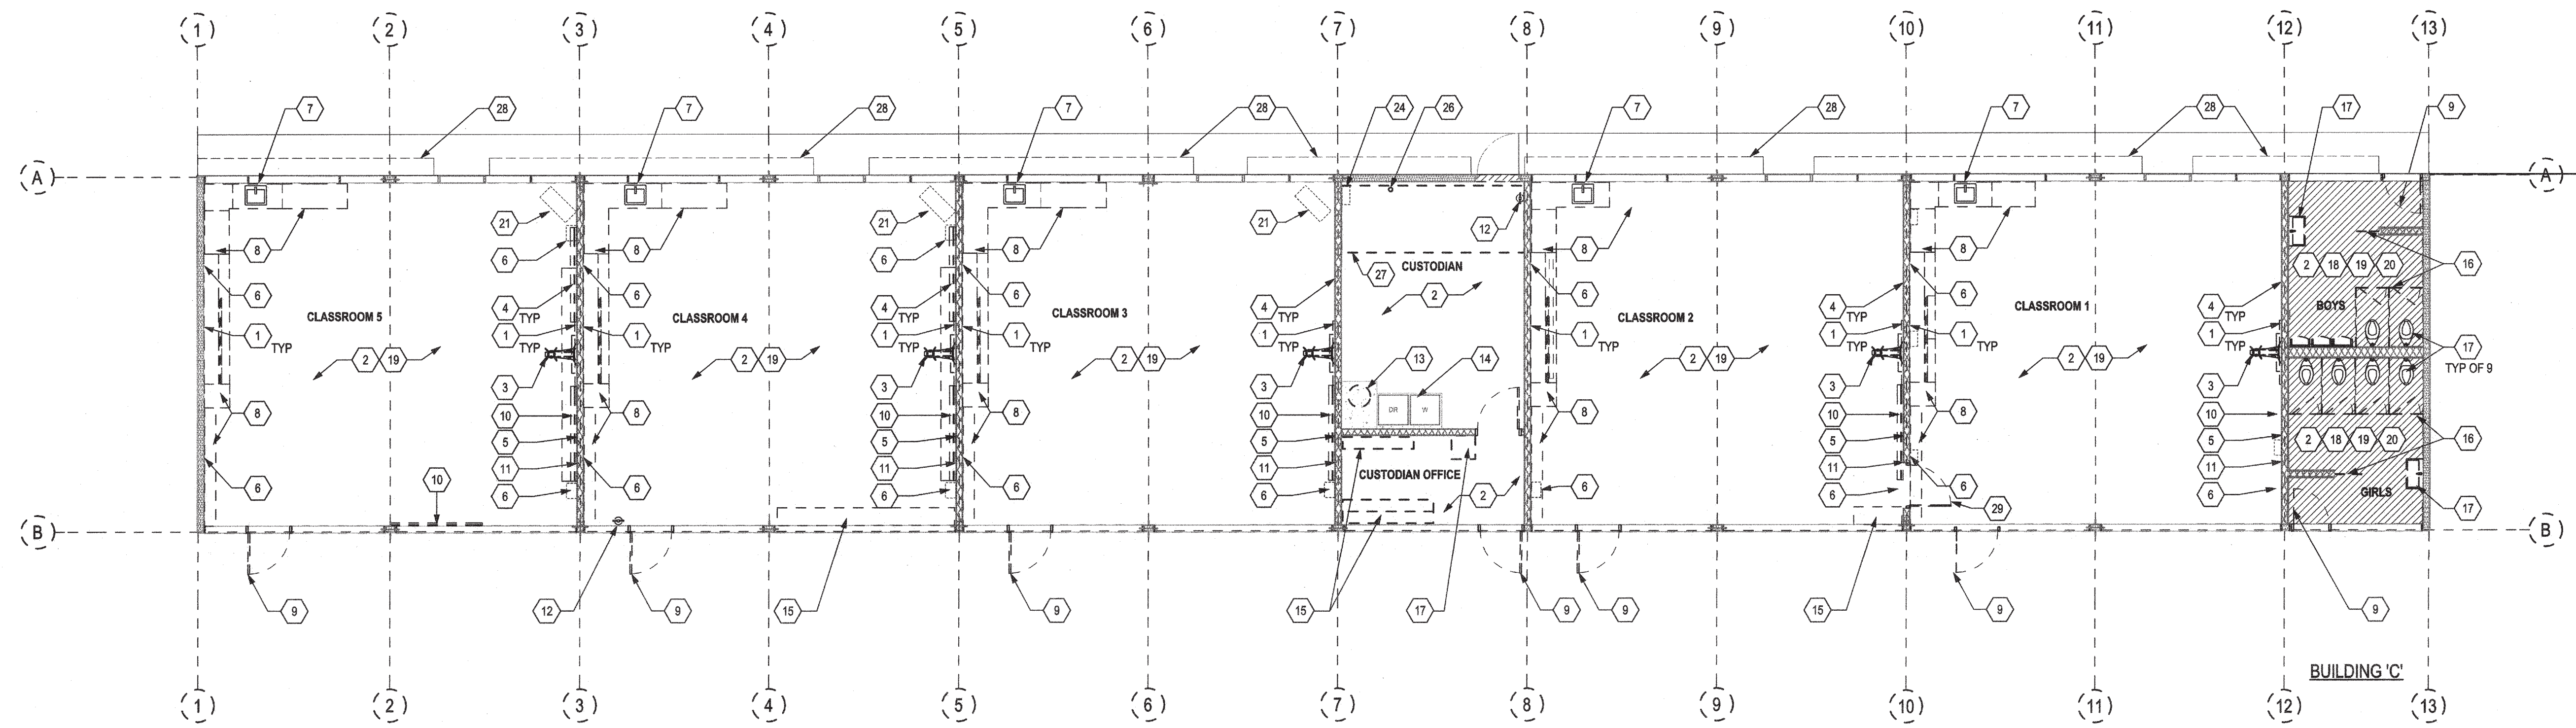

**1 DEMOLITION PLAN**  
SCALE: 1/8" = 1'-0"

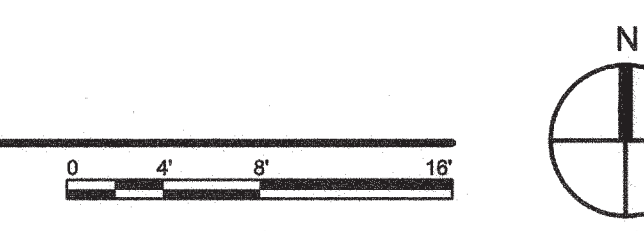

**MODERNIZATION AT MARSA VOORHIES ELEMENTARY SCHOOL FOR:**

**BAKERSFIELD CITY SCHOOL DISTRICT**

**1300 BAKER STREET  
BAKERSFIELD CA 93305**

PTN: 63321-186

MARK	DATE	DESCRIPTION
	11/01/16	DSA SUBMITTAL
△		
△		
△		

JOB NUMBER:  
**2015-1663**  
CAD DRAWING FILE

1663 VOORHIES MOD-304 & 400 Classroom Wings-C216.pln

DRAWN BY:  
**MT**  
CHECKED BY:

CHECK AND VERIFY ALL DIMENSIONS BEFORE PROCEEDING WITH THE WORK. REPORT DISCREPANCIES TO THE ARCHITECT.  
THE DRAWINGS, IDEAS, AND DESIGNS REPRESENTED ON THIS SHEET ARE THE PROPERTY OF THE ARCHITECT.

COPYRIGHT  
ORDIZ-MELBY ARCHITECTS, INC. 2014

SHEET TITLE  
**DEMOLITION PLANS**

SHEET IDENTIFICATION NUMBER  
**A-112CD**

C:\Users\165177001\OneDrive\Drawings\2015\1663 VOORHIES MOD-304 & 400 Classroom Wings-C216.pln  
 PLOT TIME: 4:30 PM  
 PLOT DATE: 8/20/17