



DANNY E. ORDIZ, AIA
ARCHITECT C-14,728
WILLIAM J. MELBY, AIA
ARCHITECT C-16,835

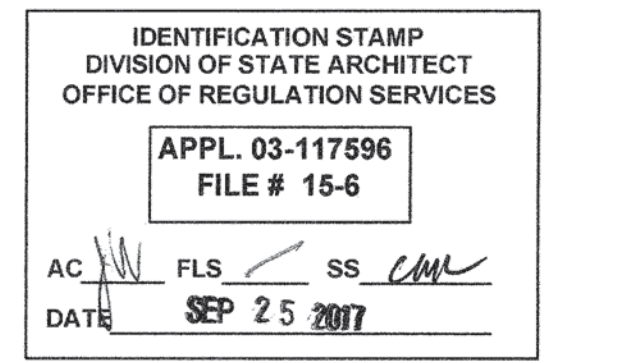


LIGHTING PLAN NOTES


- ① ¾"C.W(2)#10, (1)#10 GND
- ② HOMERUN VIA PHOTOCELL, A1-16
- ③ HOMERUN VIA PHOTOCELL+W.P KEY SWITCH
- ④ (E) LIGHTING TO REMAIN

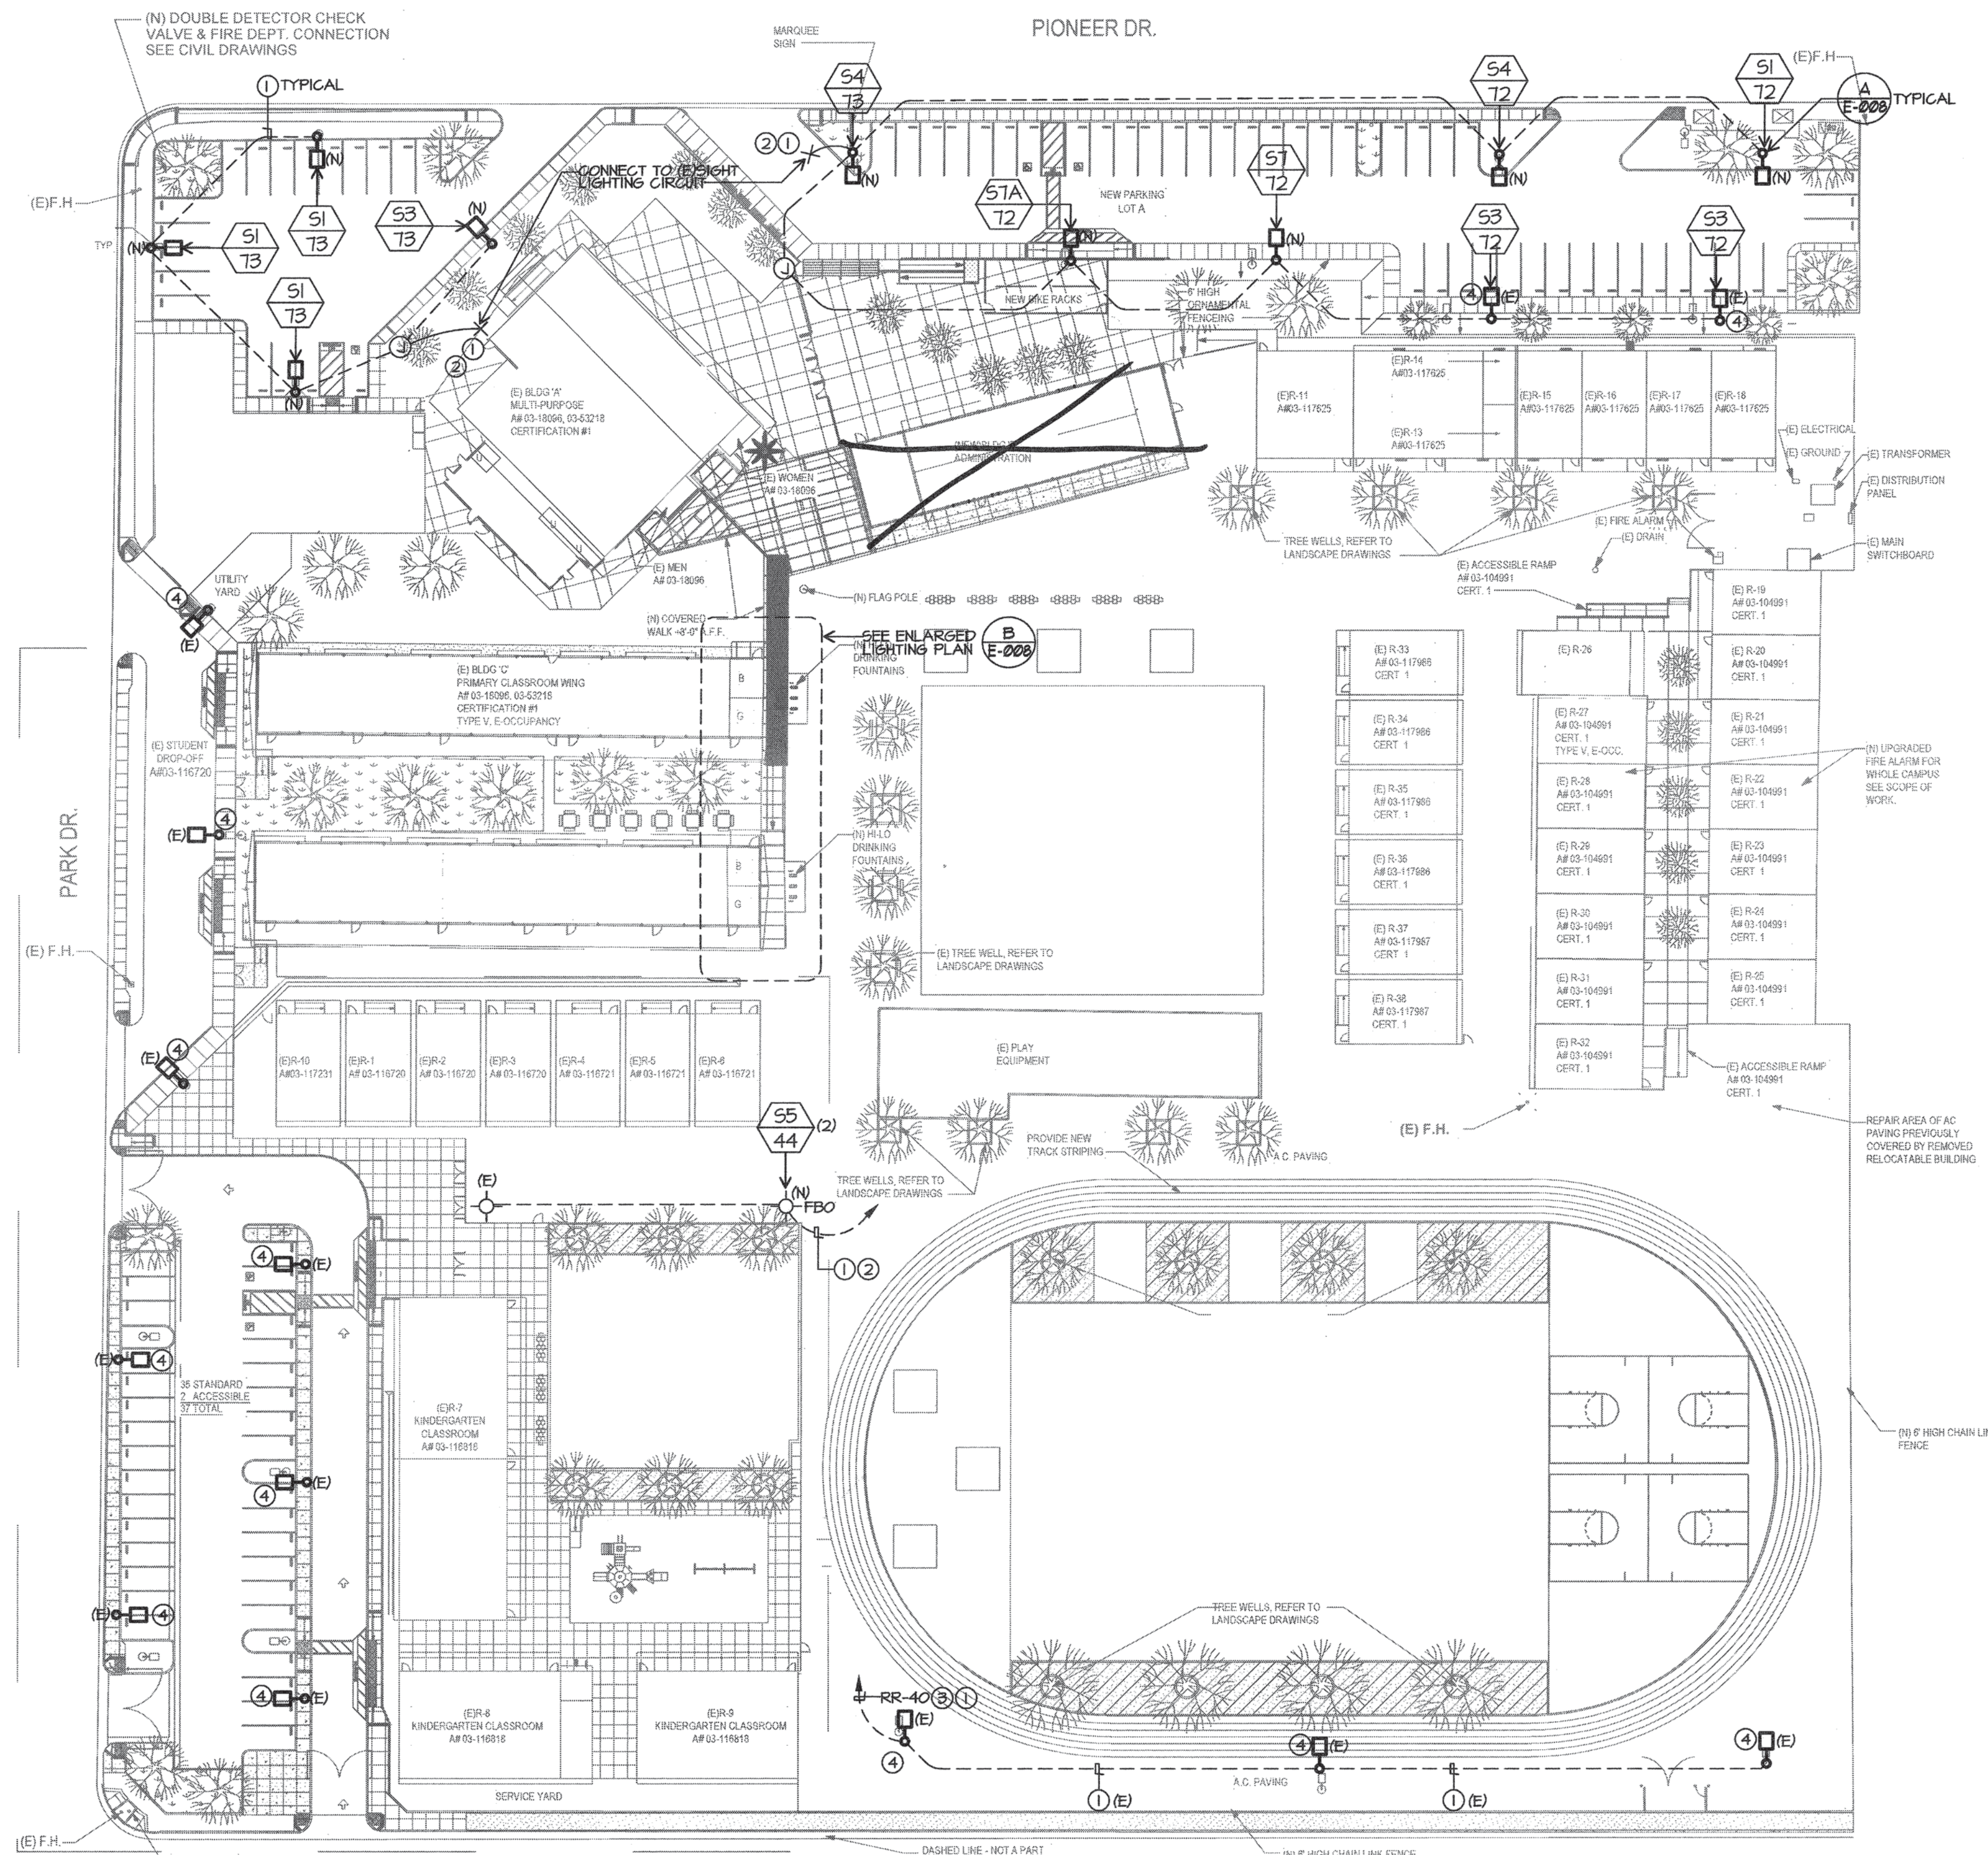

SITE LIGHTING PLAN
SCALE: 1"=40'-0"

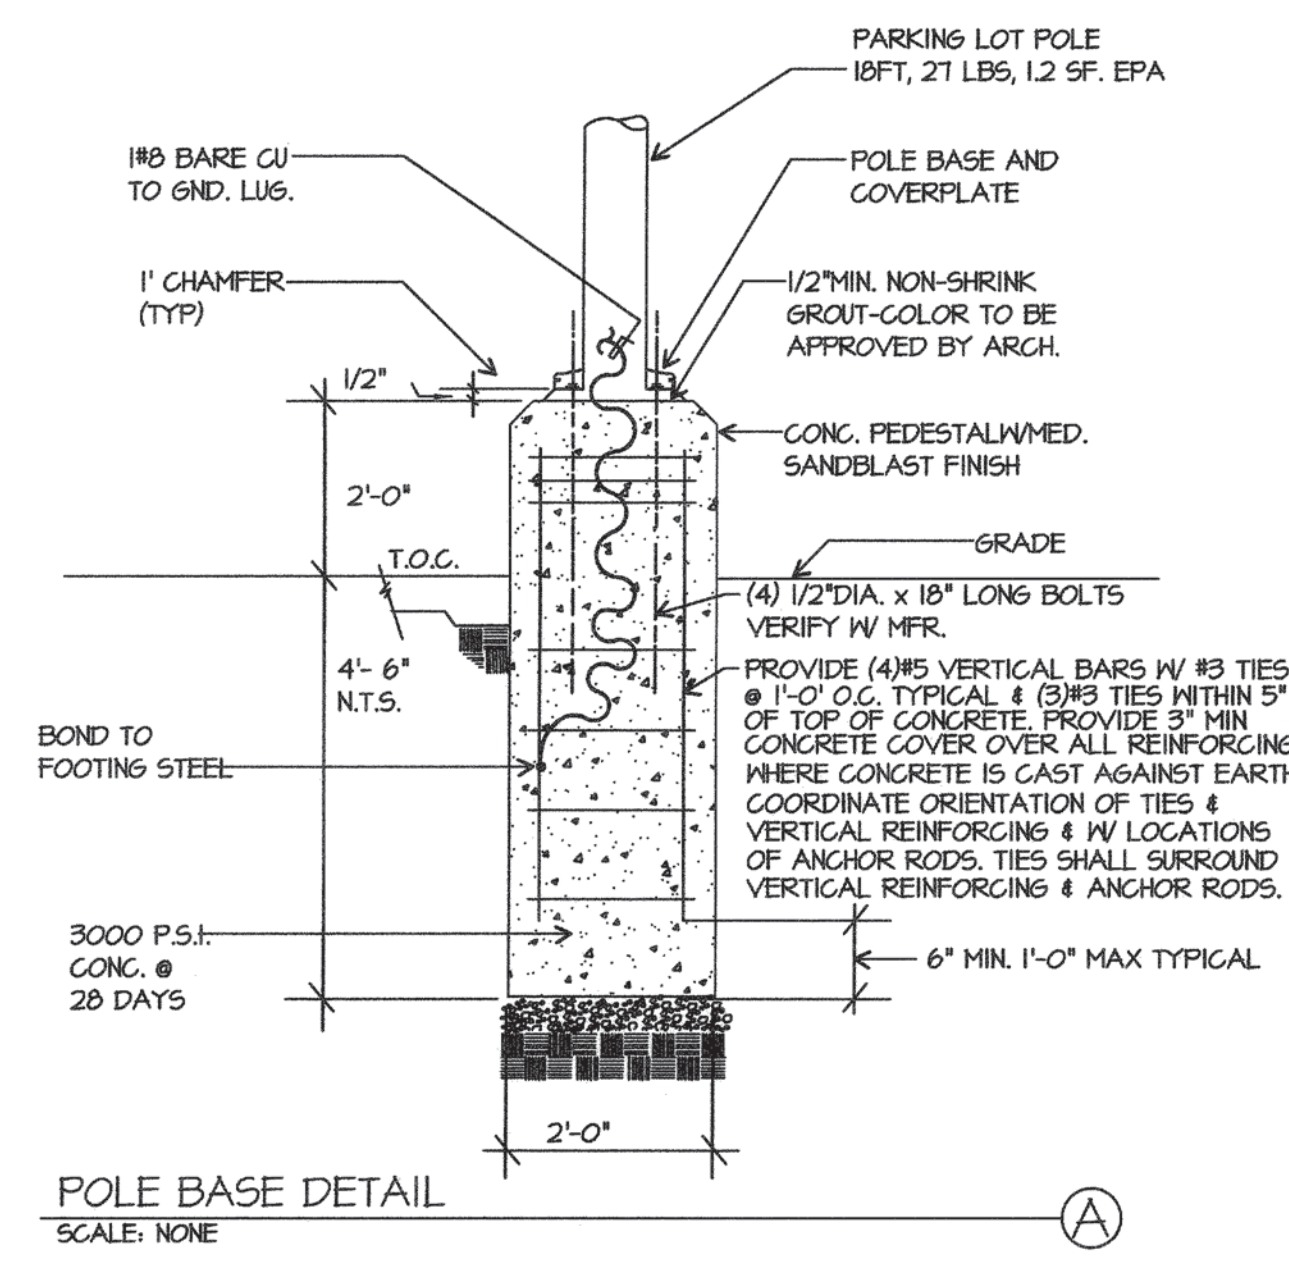

POLE BASE DETAIL
SCALE: NONE

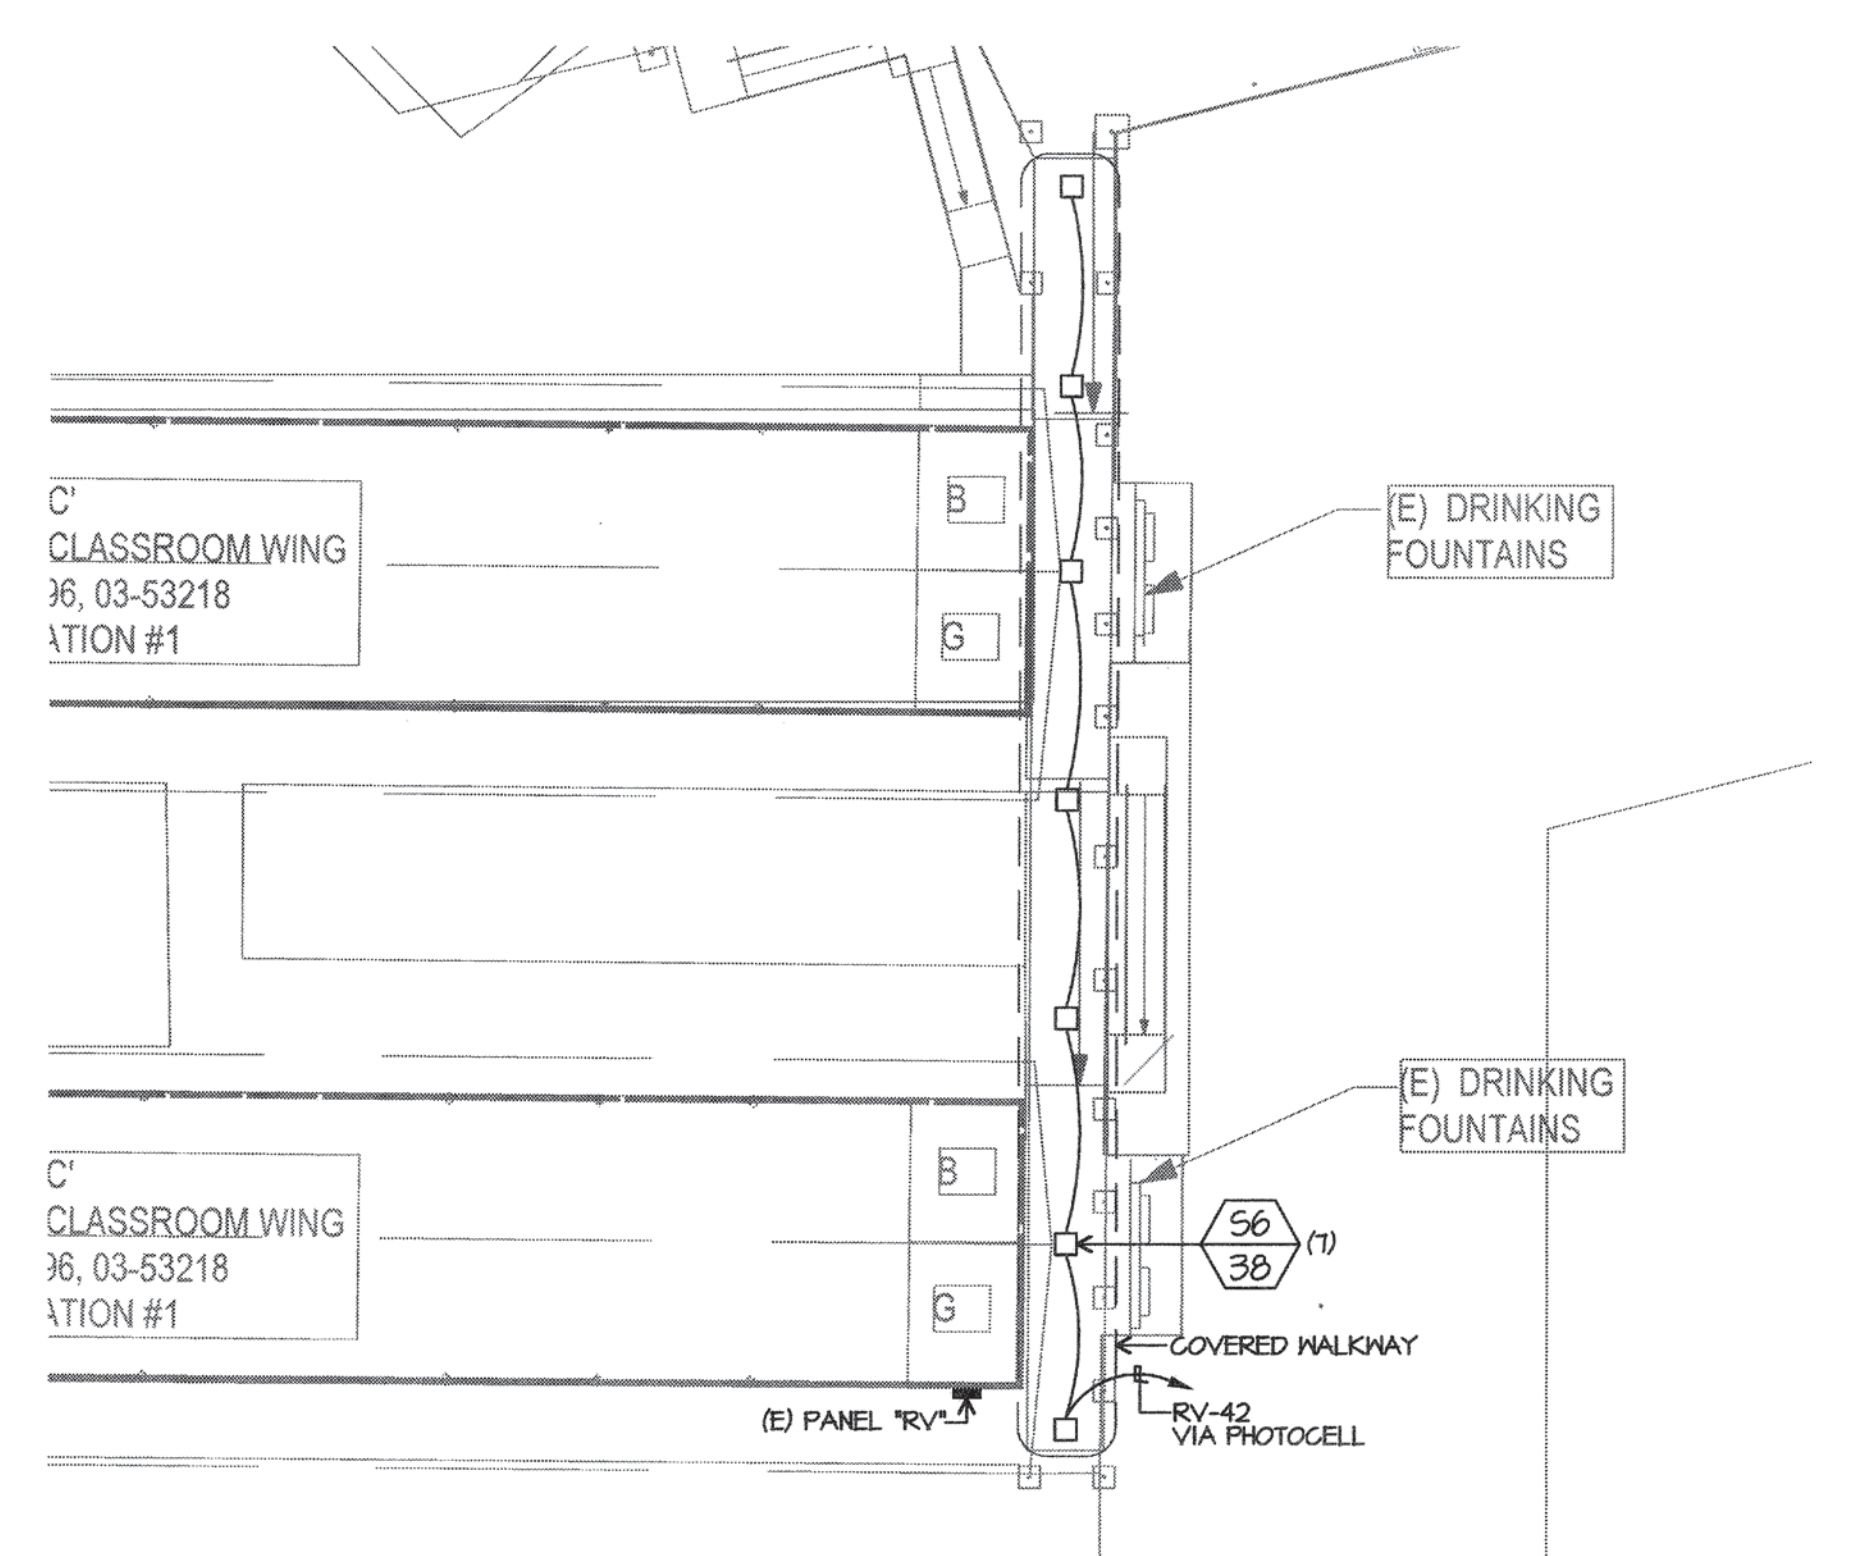



ENLARGED LIGHTING PLAN
SCALE: 1"=20'-0"

MODERNIZATION AT MARSA VOORHIES ELEMENTARY SCHOOL FOR: BAKERSFIELD CITY SCHOOL DISTRICT

1300 BAKER STREET
BAKERSFIELD CA 93305

MARK	DATE	DESCRIPTION
	11/01/16	DSA SUBMITTAL

2015-1663
CAD DRAWING FILE
1663 VOORHIES MOD-300 & 400 Classroom Wings-CD18.pln
DRAWN BY: AC
CHECKED BY: JM
CHECK AND VERIFY ALL DIMENSIONS BEFORE PROCEEDING WITH THE WORK. REPORT DISCREPANCIES TO THE ARCHITECT.
THE DRAWINGS, IDEAS, AND DESIGNS REPRESENTED ON THIS SHEET ARE THE PROPERTY OF THE ARCHITECT.
COPYRIGHT: ORDIZ MELBY ARCHITECTS, INC. 2014
SHEET TITLE

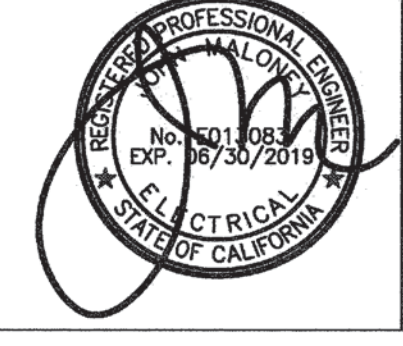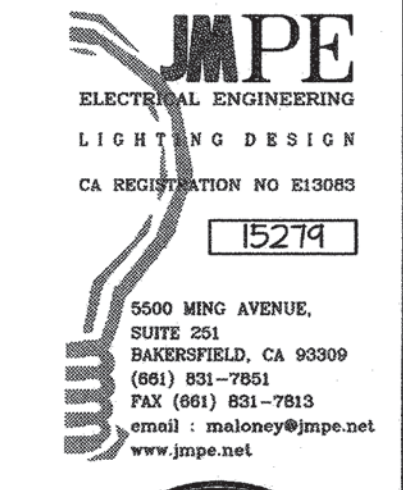

SITE LIGHTING PLAN
SHEET IDENTIFICATION NUMBER
E-008
SHEET OF