
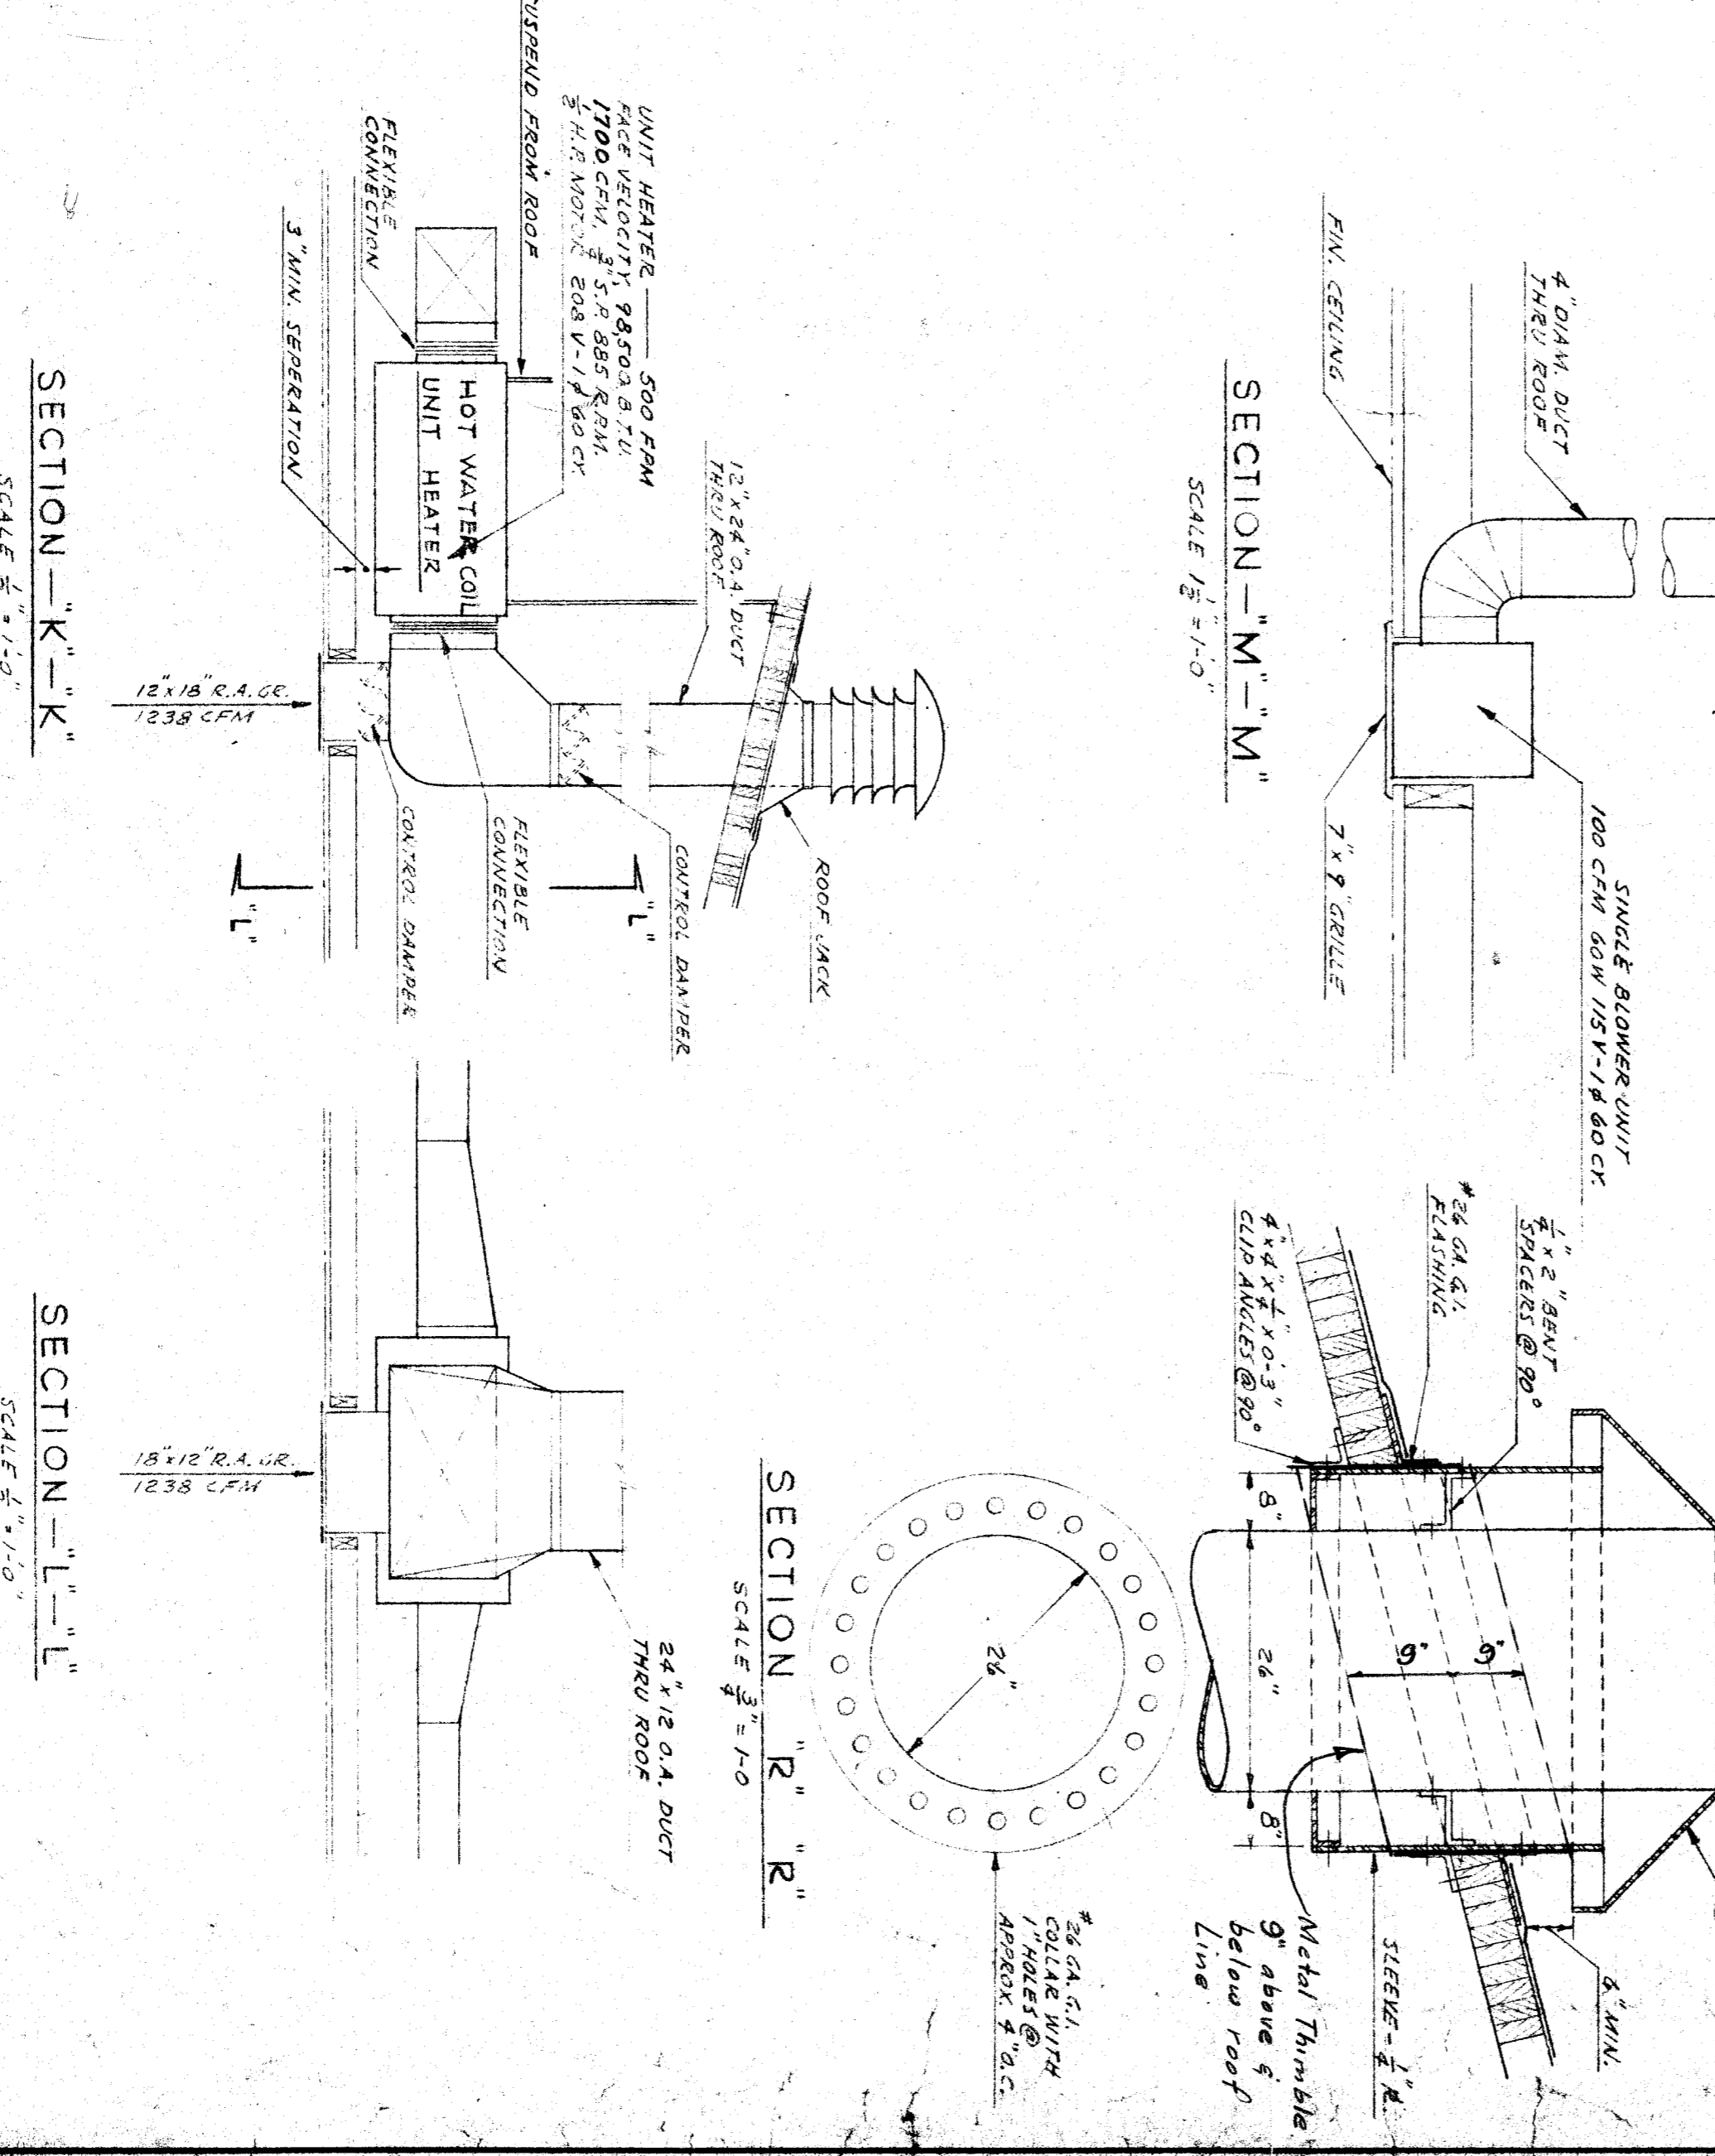
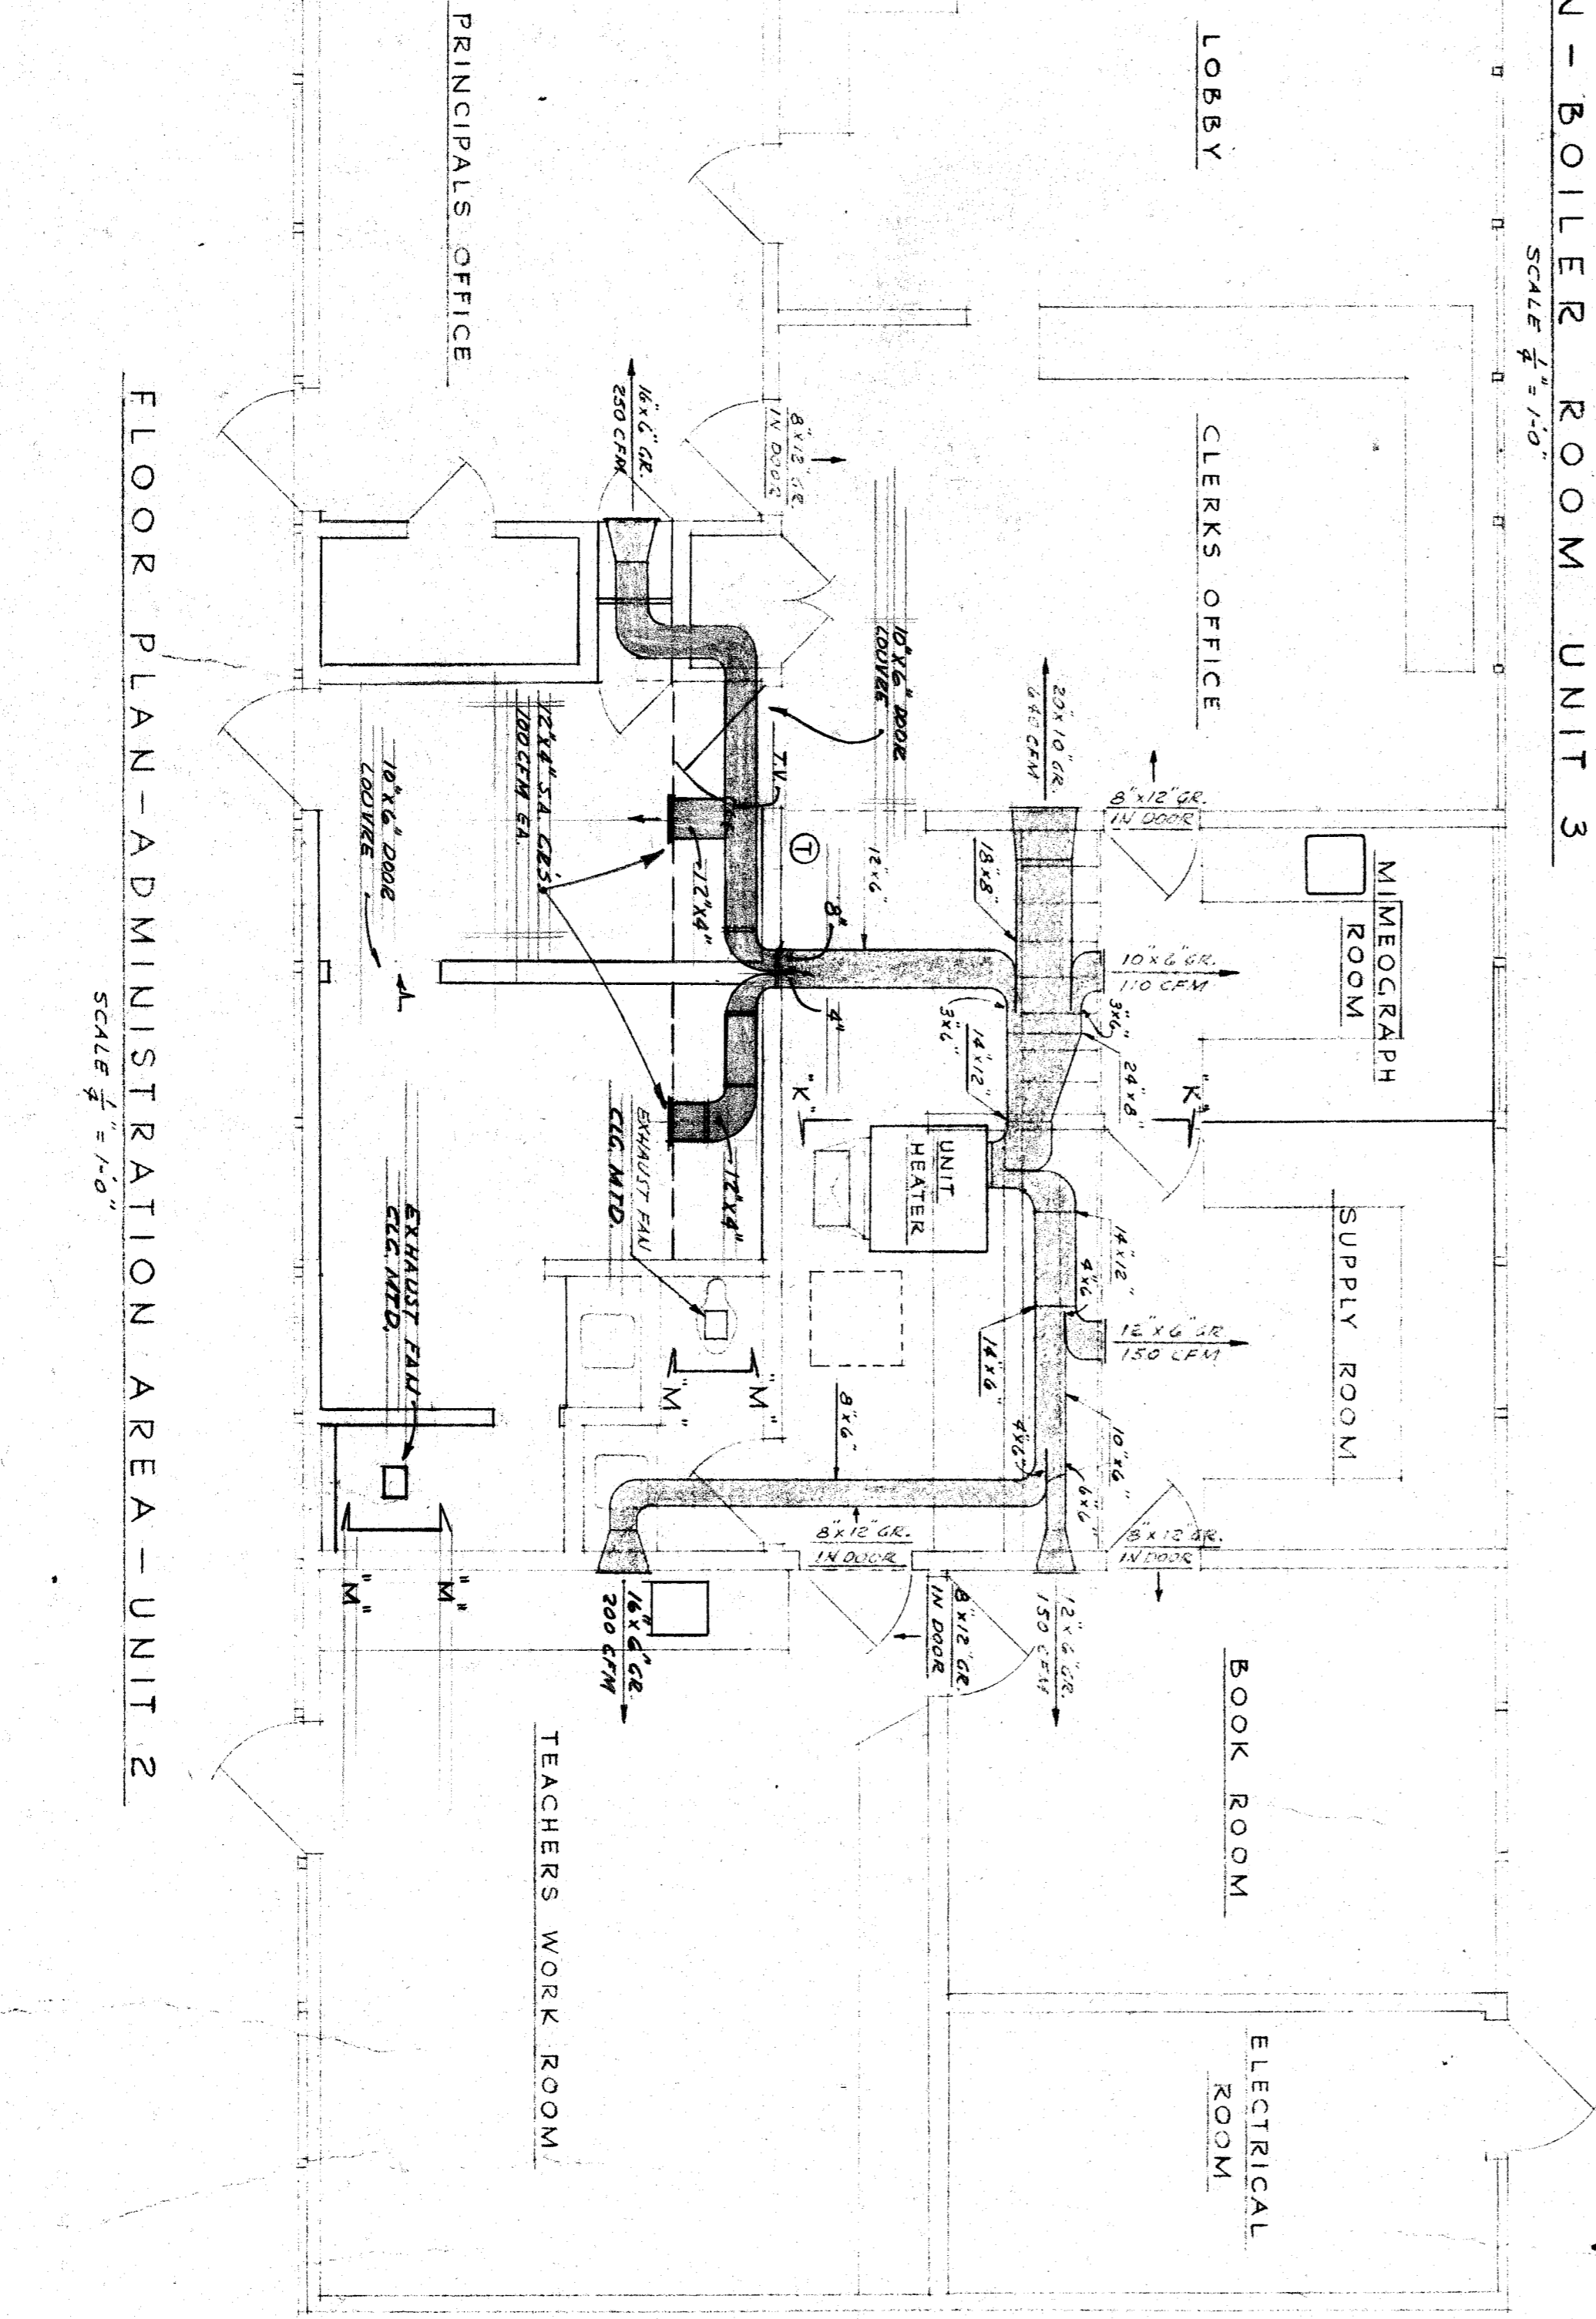
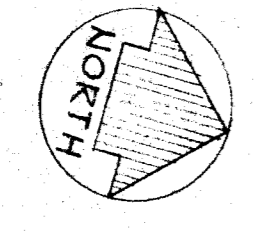
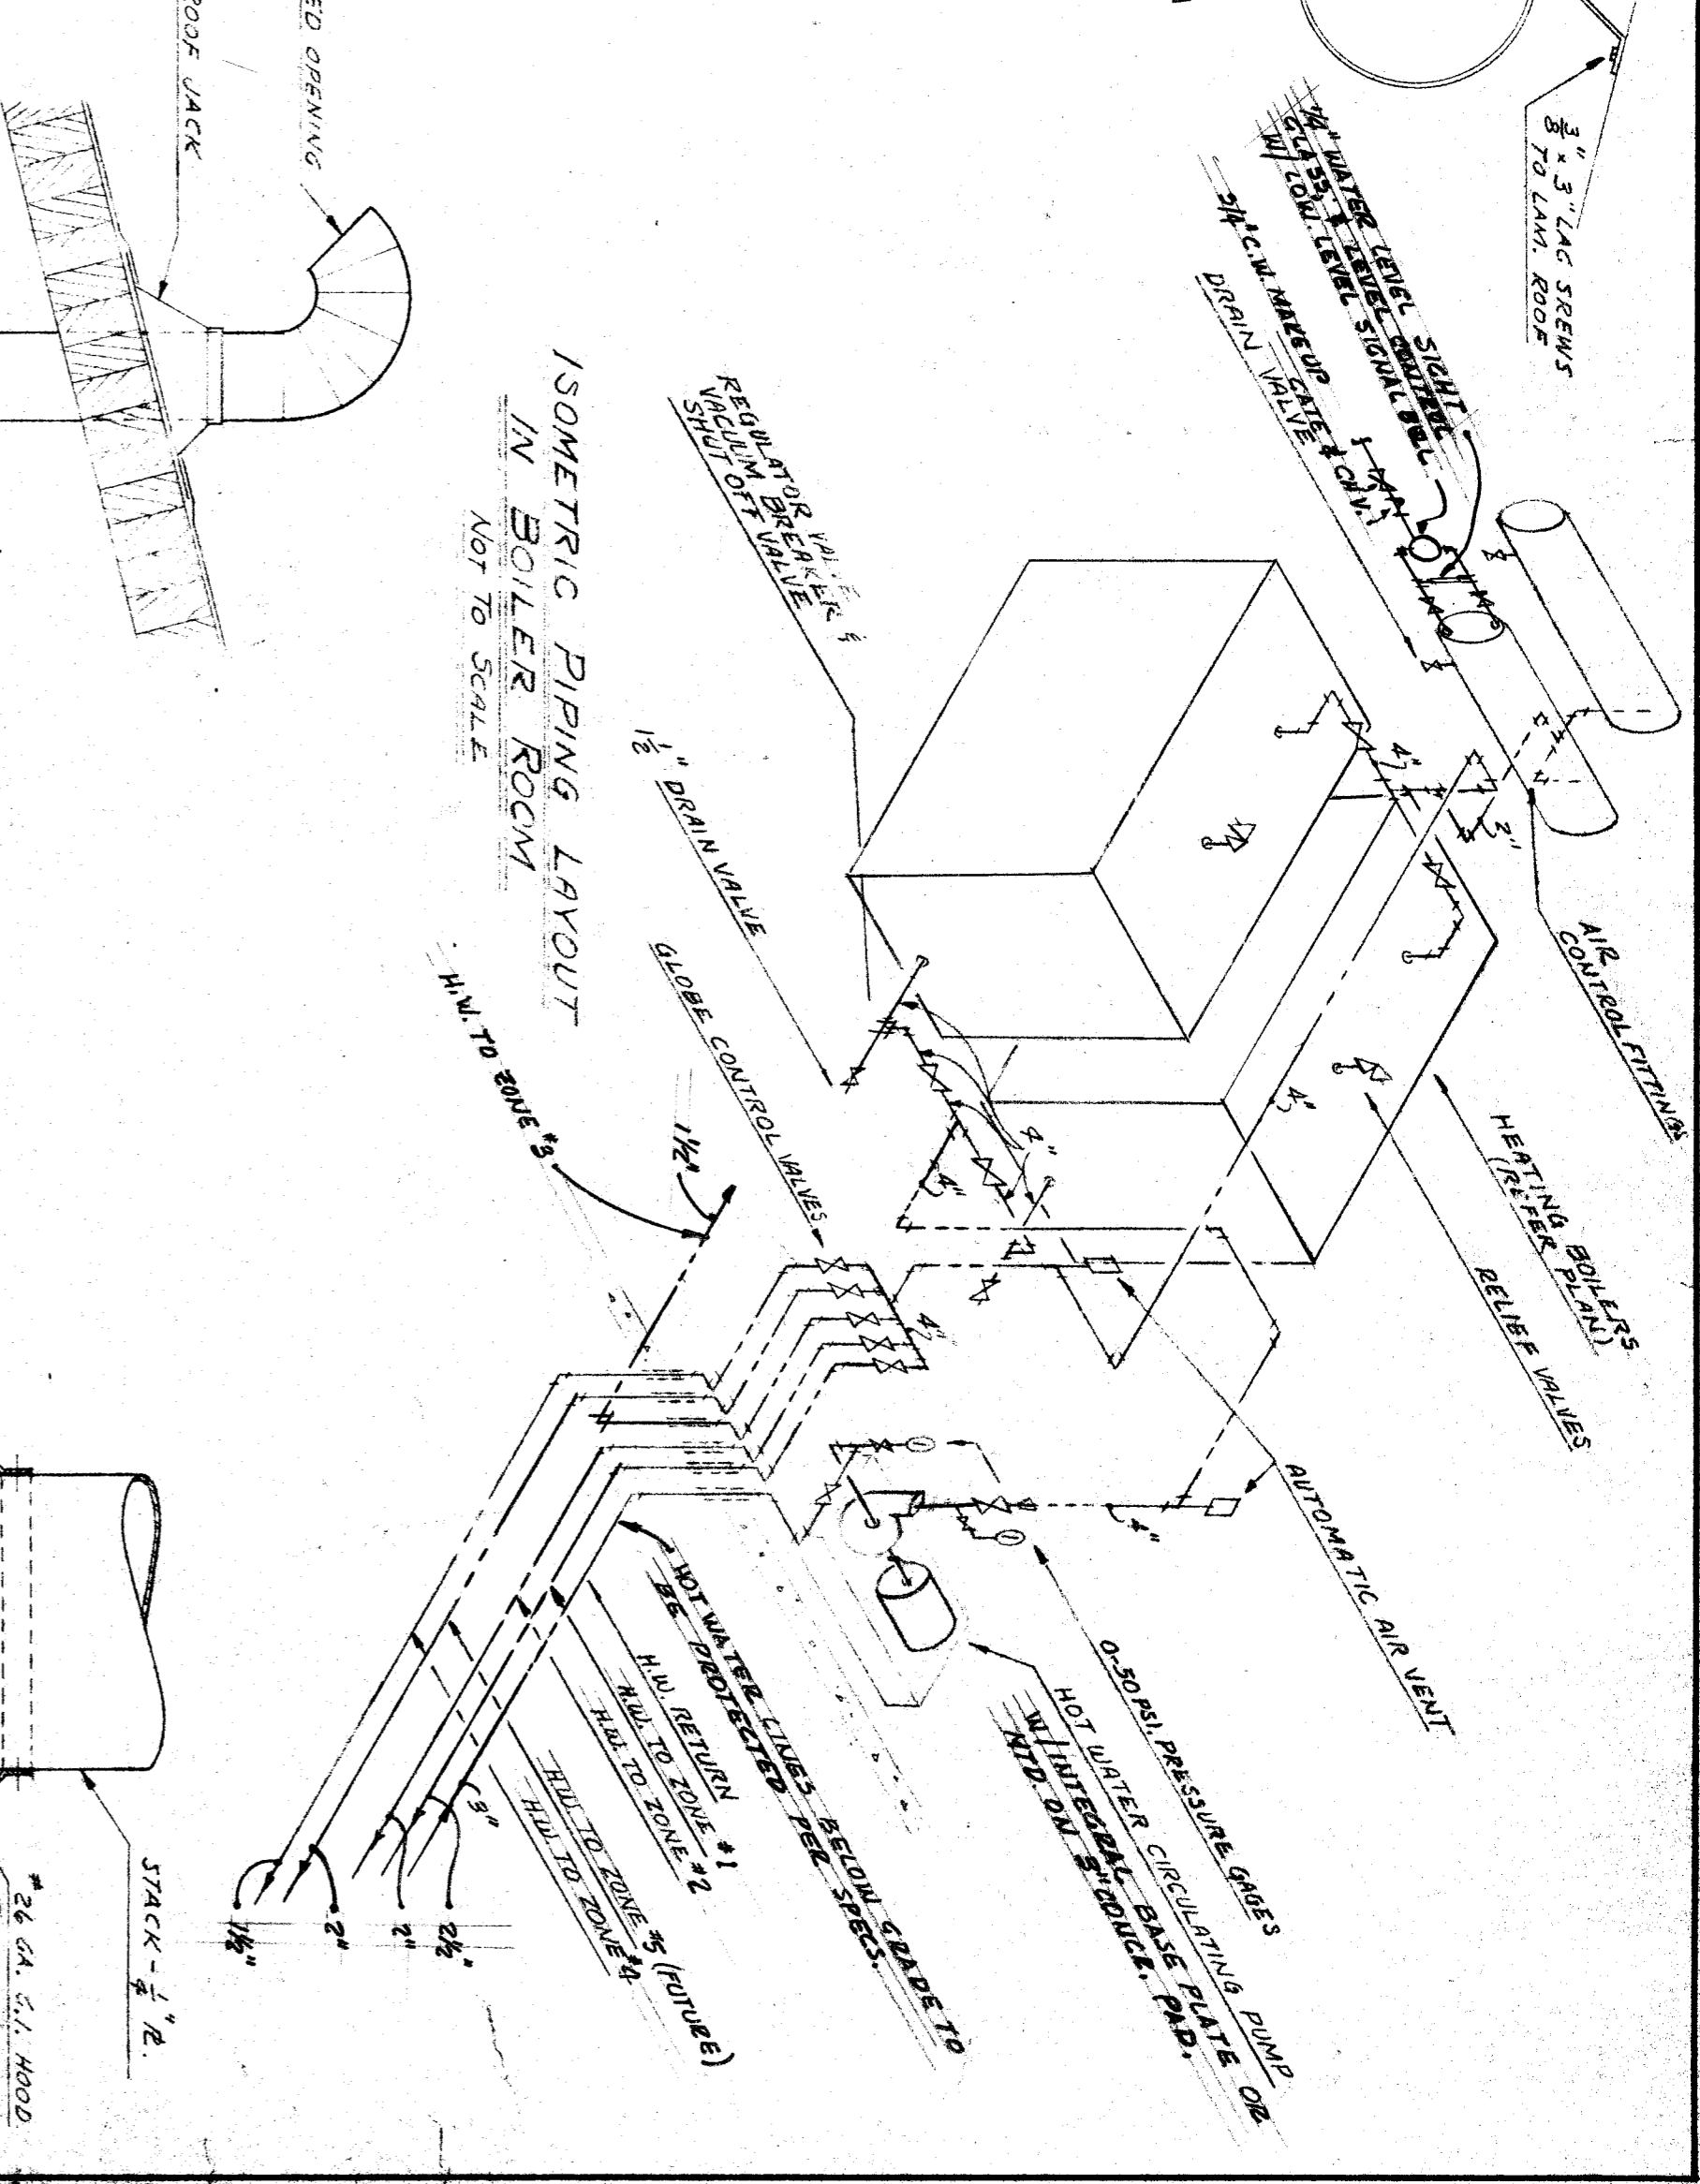
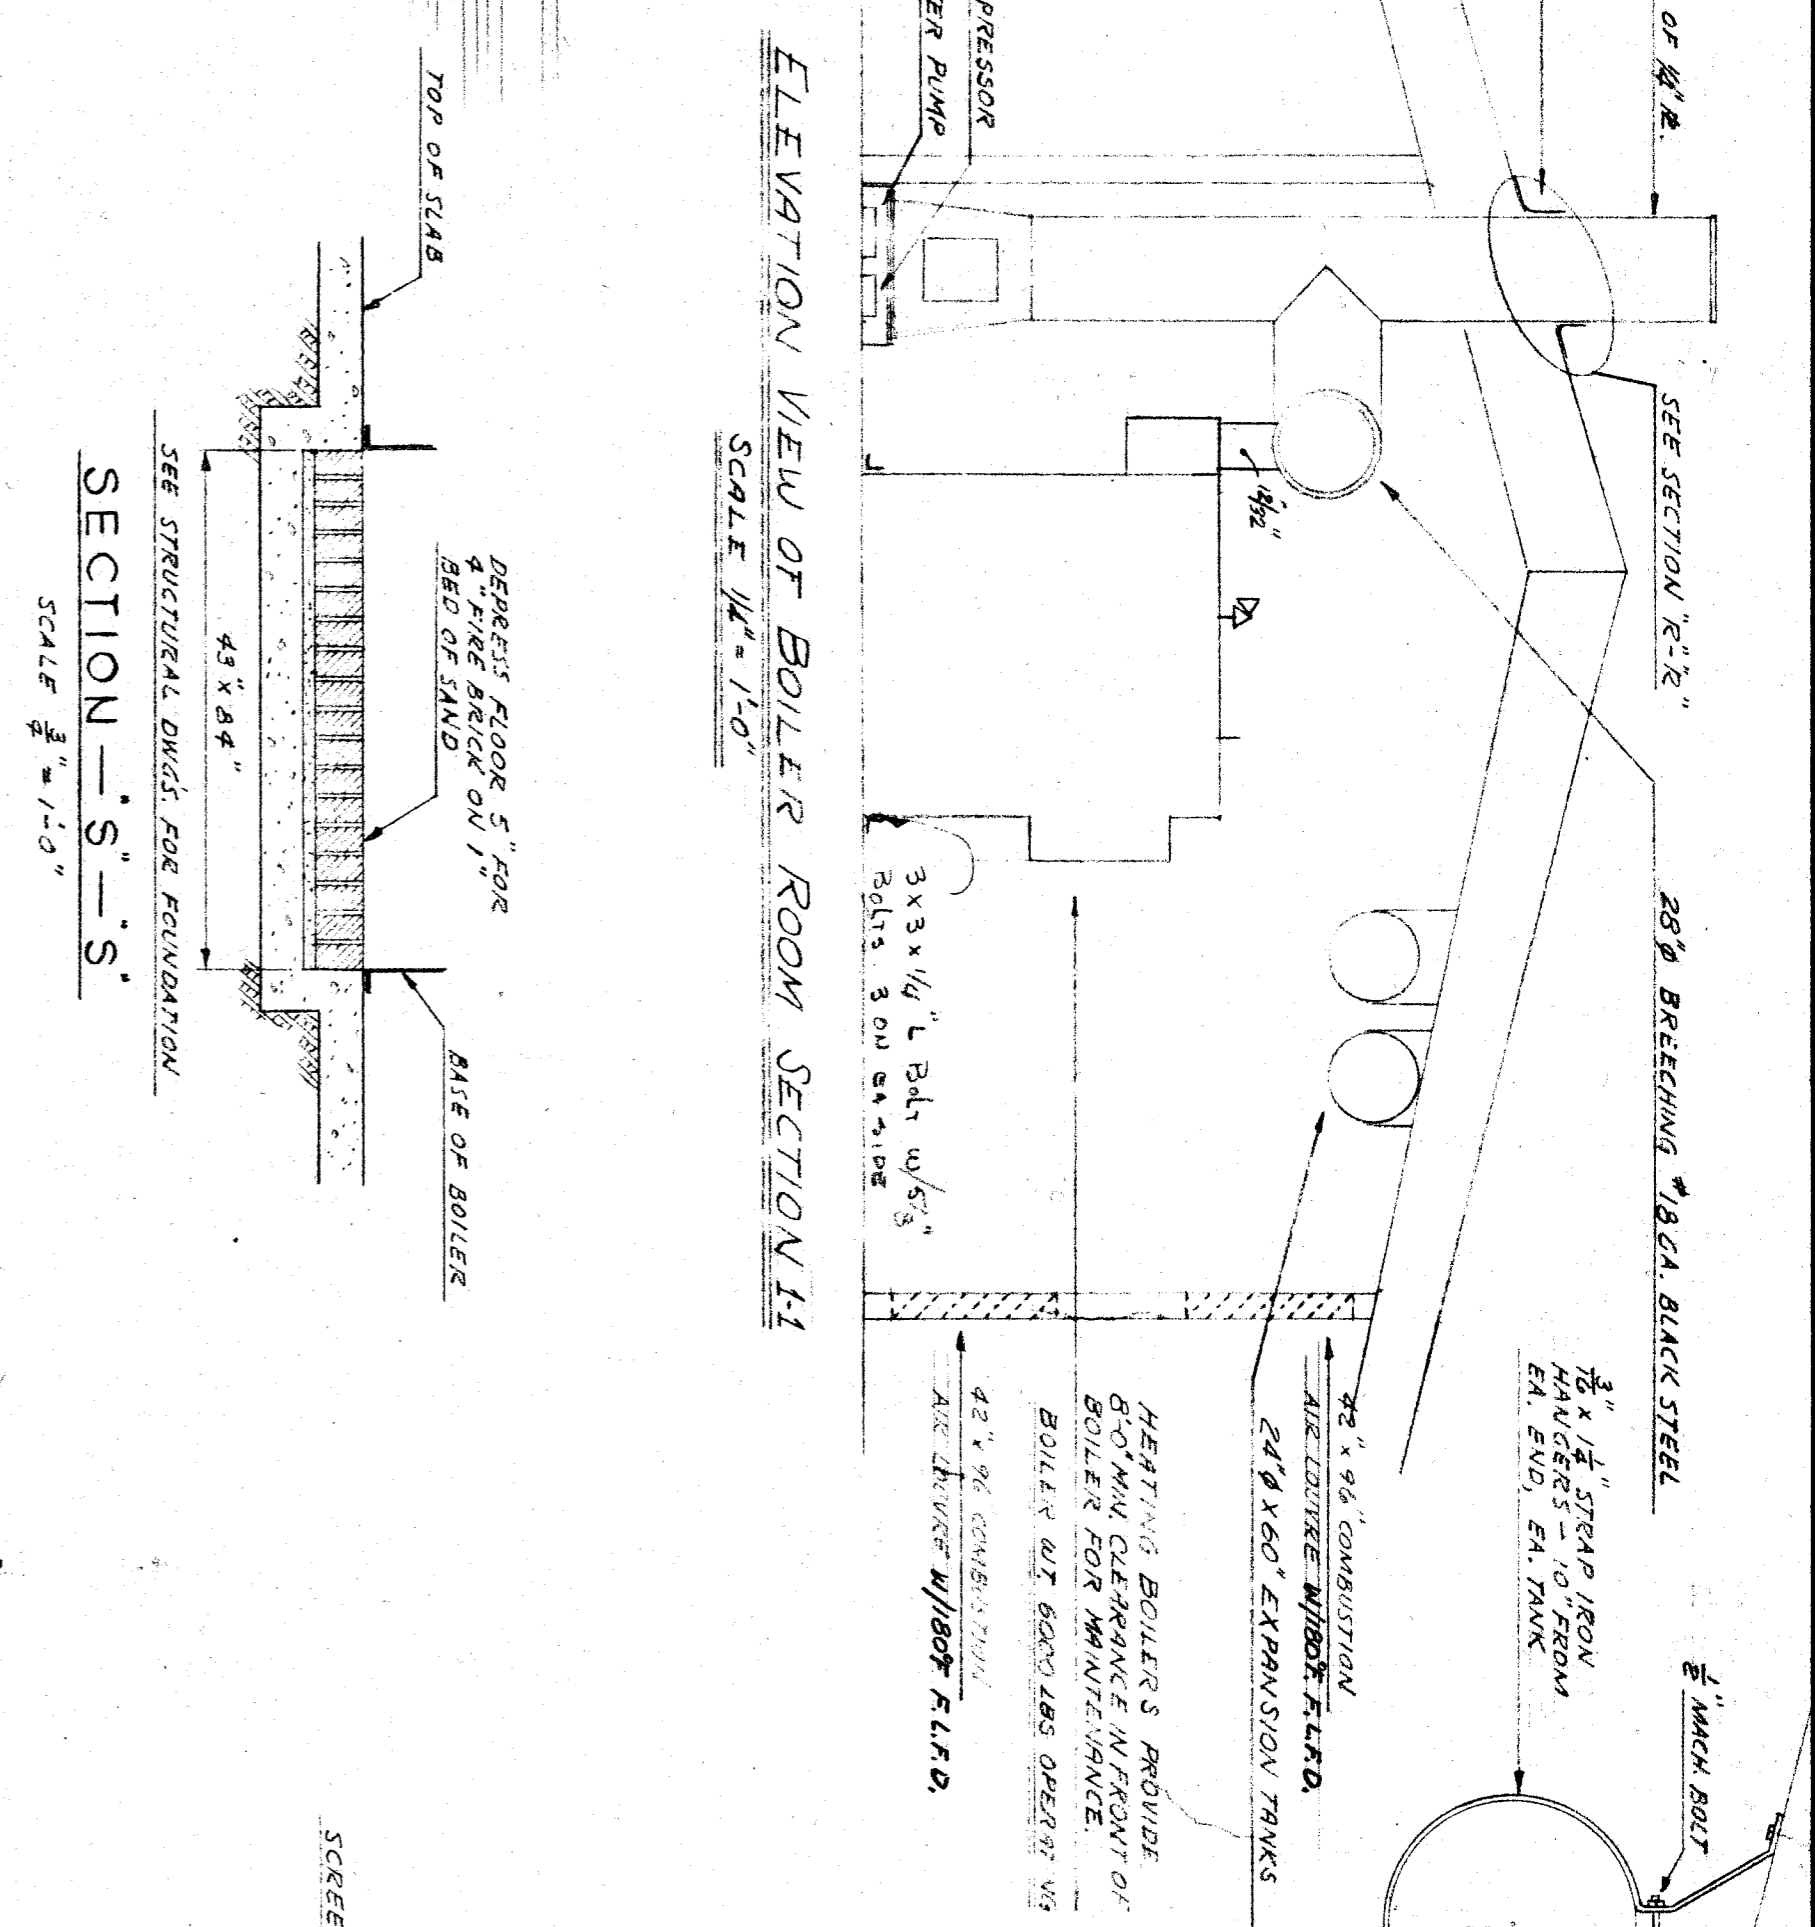


Provide the piping system shown on drawings.

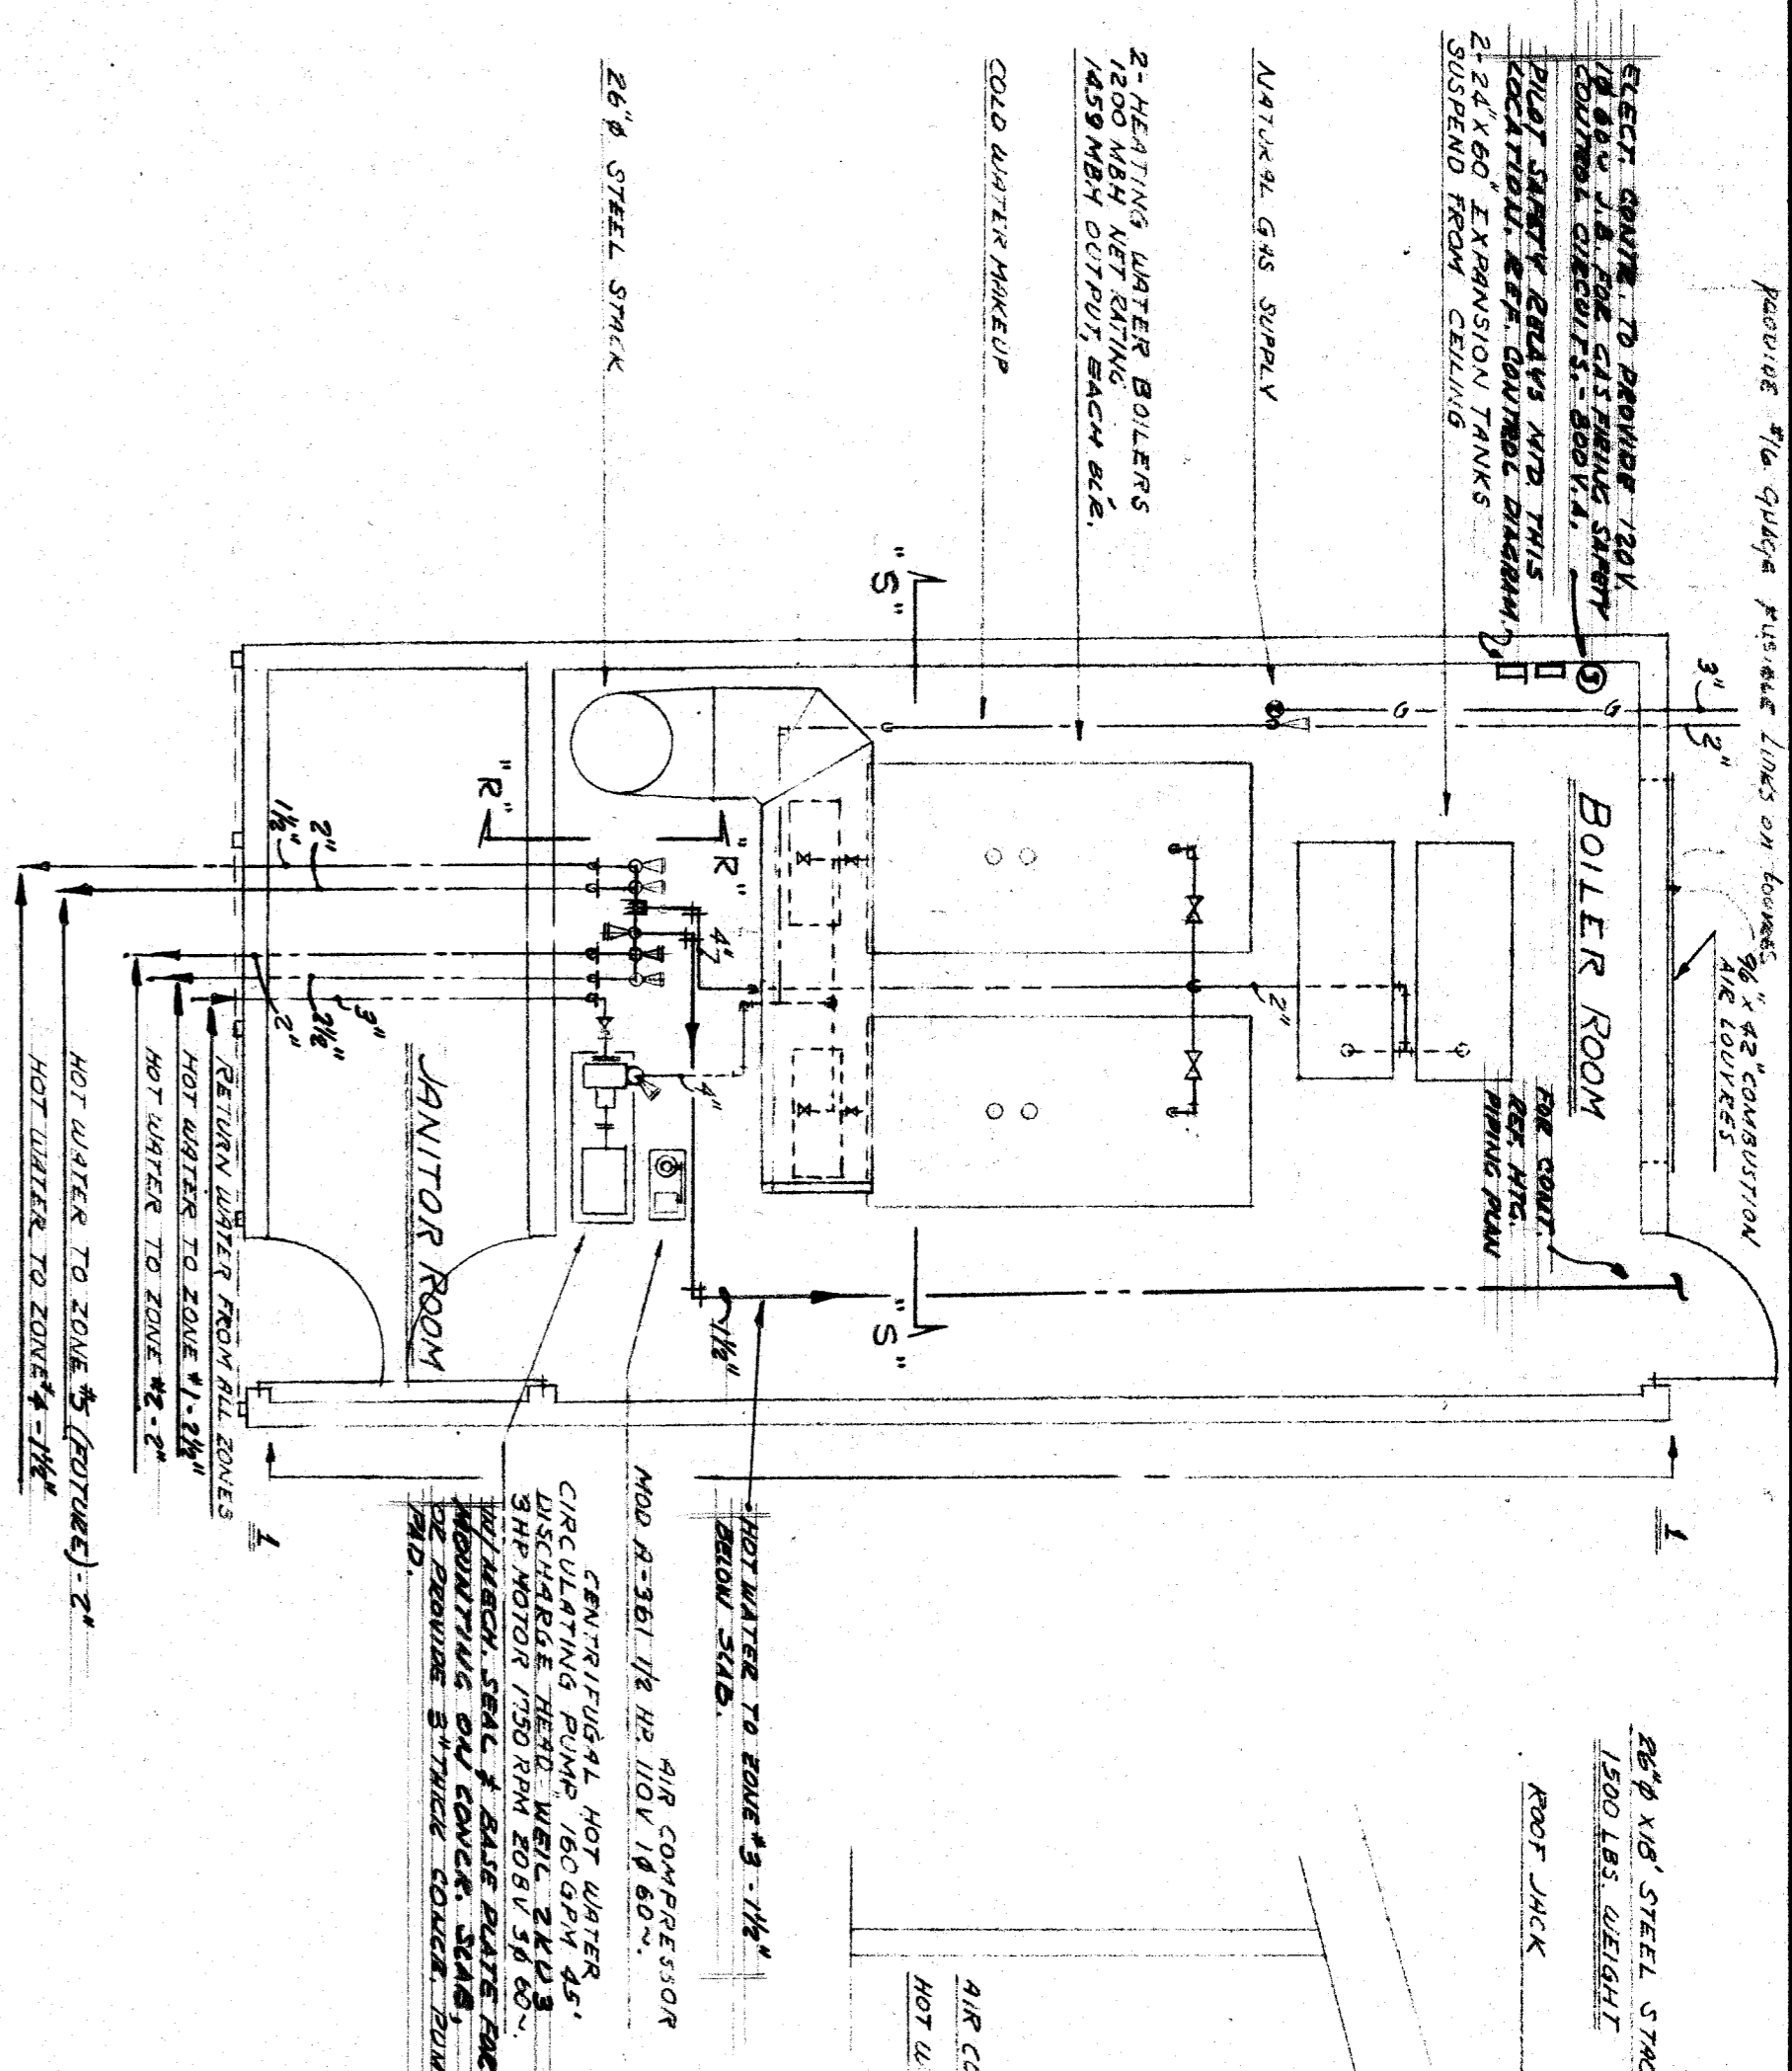

DIVISION OF ARCHITECTURE

BOARD OF EDUCATION

HEATING & VENTILATING
FLOOR PLAN - ADMINISTRATION AREA
UNIT 2110
7128 DANE SCHOOL
BAKERSFIELD CALIFORNIA

WHITNEY BIGGAR ARCHITECT
MEMBER AMERICAN INSTITUTE OF ARCHITECTS
3601 STOCKDALE HIGHWAY
BAKERSFIELD, CALIFORNIA
29285 REGISTRATION C-1128

STATE OF CALIFORNIA, DEPARTMENT OF PUBLIC WORKS
DIVISION OF ARCHITECTURE
18096 APPROVED DEC 22 1958
APPROVED FOR THE ARCHITECT
JAMES W. SALINGER

DESIGNED BY
JAMES W. SALINGER

PROJECT NO. 8175
DRAWN BY: [Signature]
CHECKED BY: [Signature]
DATE: 11/24/58
SHEET M-10 OF 58