


TABLE V  
TYPE: ULAD, FLUSH MOUNTED  
30 AMP, 150/250V


CT. NO.	REARER. SIZE PANEL	LOAD IN WATTS	# B.	# C.	DESCRIPTION
1	20	1500	1500	1500	LITE-R-V. H-11
2	20	1500	1500	1500	H-4
3	20	1500	1500	1500	H-4
4	20	1500	1500	1500	H-4
5	20	1500	1500	1500	H-4
6	20	1500	1500	1500	H-4
7	20	1500	1500	1500	H-4
8	20	1500	1500	1500	H-4
9	20	1500	1500	1500	H-4
10	20	1500	1500	1500	H-4
11	20	1500	1500	1500	H-4
12	20	1500	1500	1500	H-4
13	20	1500	1500	1500	H-4
14	20	1500	1500	1500	H-4
15	20	1500	1500	1500	H-4
16	20	1500	1500	1500	H-4
17	20	1500	1500	1500	H-4
18	20	1500	1500	1500	H-4
19	20	1500	1500	1500	H-4
20	20	1500	1500	1500	H-4
21	20	1500	1500	1500	H-4
22	20	1500	1500	1500	H-4
23	20	1500	1500	1500	H-4
24	20	1500	1500	1500	H-4
25	20	1500	1500	1500	H-4
26	20	1500	1500	1500	H-4
27	20	1500	1500	1500	H-4
28	20	1500	1500	1500	H-4
29	20	1500	1500	1500	H-4
30	20	1500	1500	1500	H-4
31	20	1500	1500	1500	H-4
32	20	1500	1500	1500	H-4
33	20	1500	1500	1500	H-4
TOTAL		35000	25000	25000	FEDER: 41350 ACA

TABLE X  
TYPE: ULAD, FLUSH MOUNTED  
30 AMP, 150/250V

CT. NO.	REARER. SIZE PANEL	LOAD IN WATTS	# B.	# C.	DESCRIPTION
1	20	2250	2250	2250	LITE-R-V. H-11
2	20	2250	2250	2250	H-4
3	20	2250	2250	2250	H-4
4	20	2250	2250	2250	H-4
5	20	2250	2250	2250	H-4
6	20	2250	2250	2250	H-4
7	20	2250	2250	2250	H-4
8	20	2250	2250	2250	H-4
9	20	2250	2250	2250	H-4
10	20	2250	2250	2250	H-4
11	20	2250	2250	2250	H-4
12	20	2250	2250	2250	H-4
13	20	2250	2250	2250	H-4
14	20	2250	2250	2250	H-4
15	20	2250	2250	2250	H-4
16	20	2250	2250	2250	H-4
17	20	2250	2250	2250	H-4
18	20	2250	2250	2250	H-4
19	20	2250	2250	2250	H-4
20	20	2250	2250	2250	H-4
21	20	2250	2250	2250	H-4
22	20	2250	2250	2250	H-4
23	20	2250	2250	2250	H-4
24	20	2250	2250	2250	H-4
TOTAL		9110	9300	9300	FEDER: 411 TV

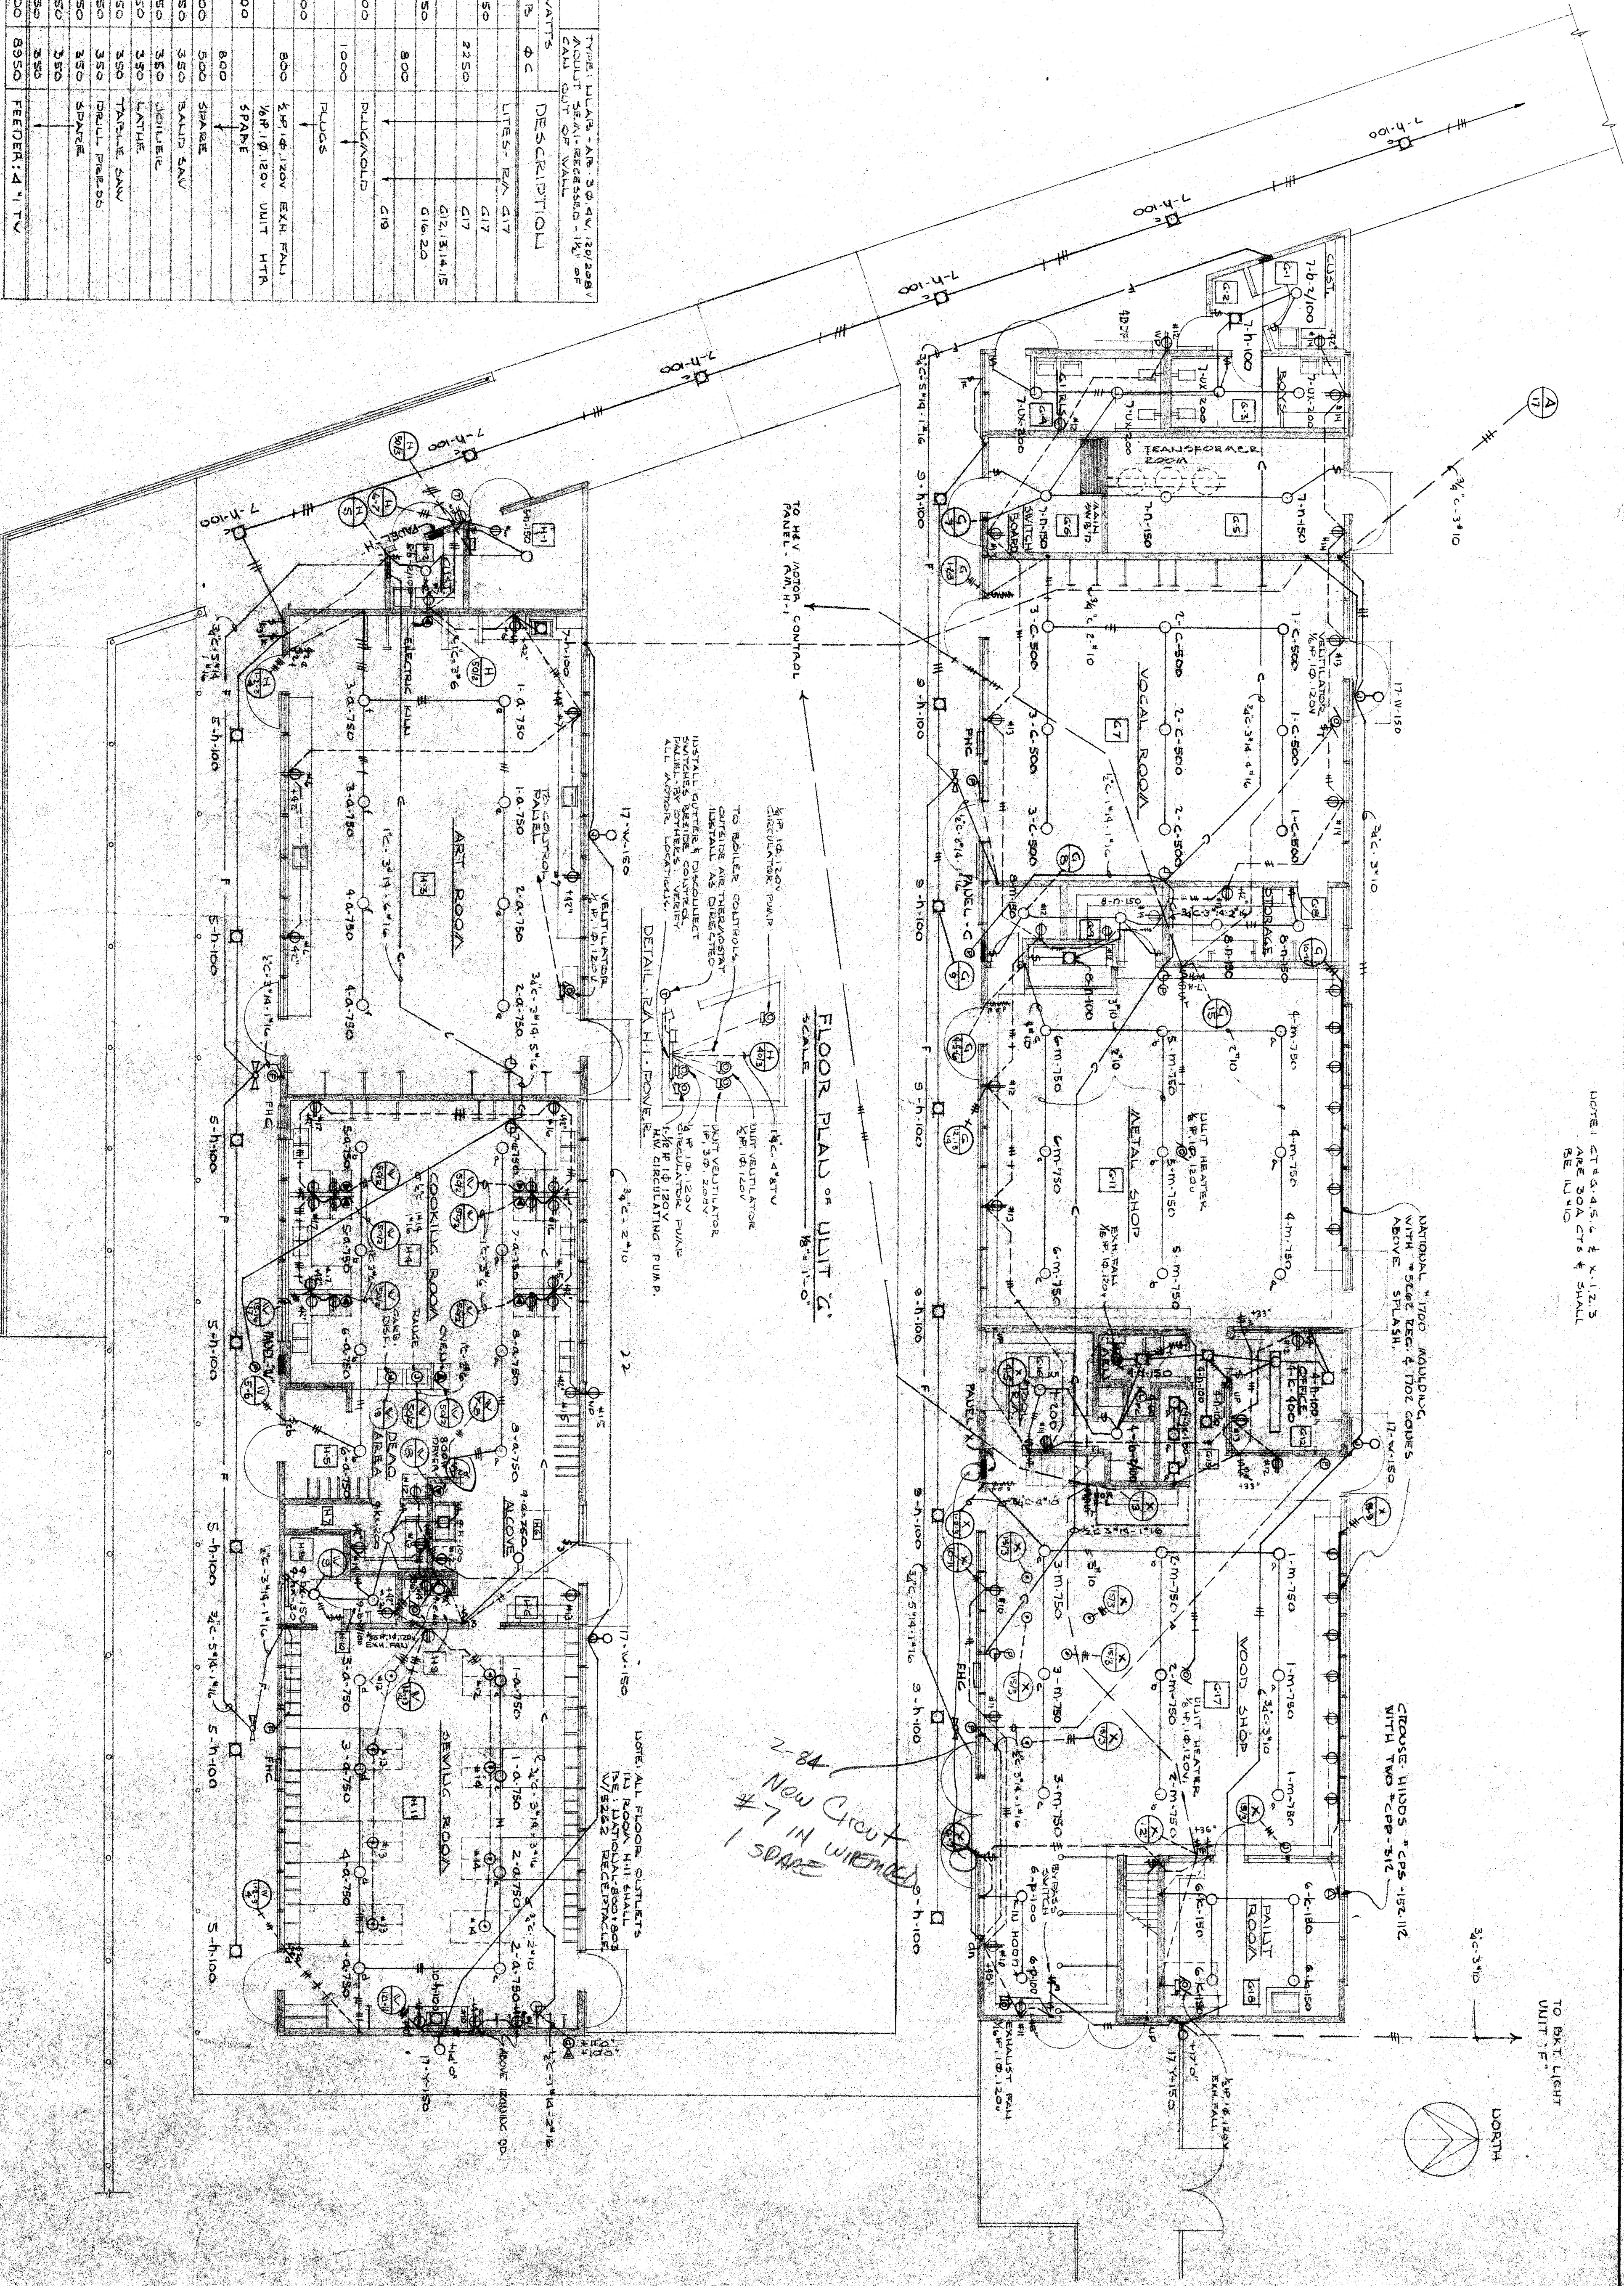

FLOOR PLAN OF UNIT C  
SCALE 1/8" = 1'-0"

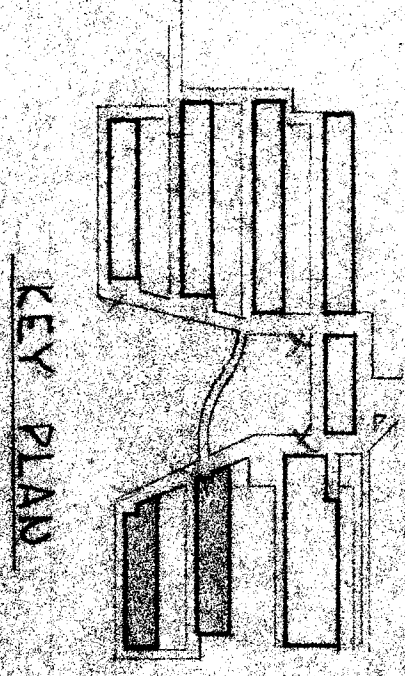

KEY PLAN

30 8/15/24 126  
Edward Lowe  
ELECTRICAL ENGINEER  
3021 FULTON ST.  
PASADENA CALIFORNIA

OFFICE OF SUPERINTENDENT OF SCHOOLS  
STATE OF CALIFORNIA  
DEPARTMENT OF PUBLIC WORKS  
DIVISION OF ARCHITECTURE

STATE OF CALIFORNIA  
DIVISION OF ARCHITECTURE  
APPROVED  
DATE

WASHINGTON JR. HIGH SCHOOL  
BAKERSFIELD CITY SCHOOL DISTRICT  
CALIFORNIA

Ernest L. McCoy A.I.A.  
ARCHITECT  
2811 H STREET  
BAKERSFIELD CALIFORNIA

Ernest L. McCoy A.I.A.  
ARCHITECT  
2811 H STREET  
BAKERSFIELD CALIFORNIA

Ernest L. McCoy A.I.A.  
ARCHITECT  
2811 H STREET  
BAKERSFIELD CALIFORNIA

CHECK AND VERIFY ALL DIMENSIONS AND CONDITIONS AT JOB SITE BEFORE PROCEEDING WITH THE WORK. REPORT ANY DISCREPANCIES TO THE ARCHITECT.