


DETAIL A H-6
SANDING HOOD EXHAUST FAN
SCALE 1/8" = 1'-0"

SOUTH ELEVATION


WEST ELEVATION

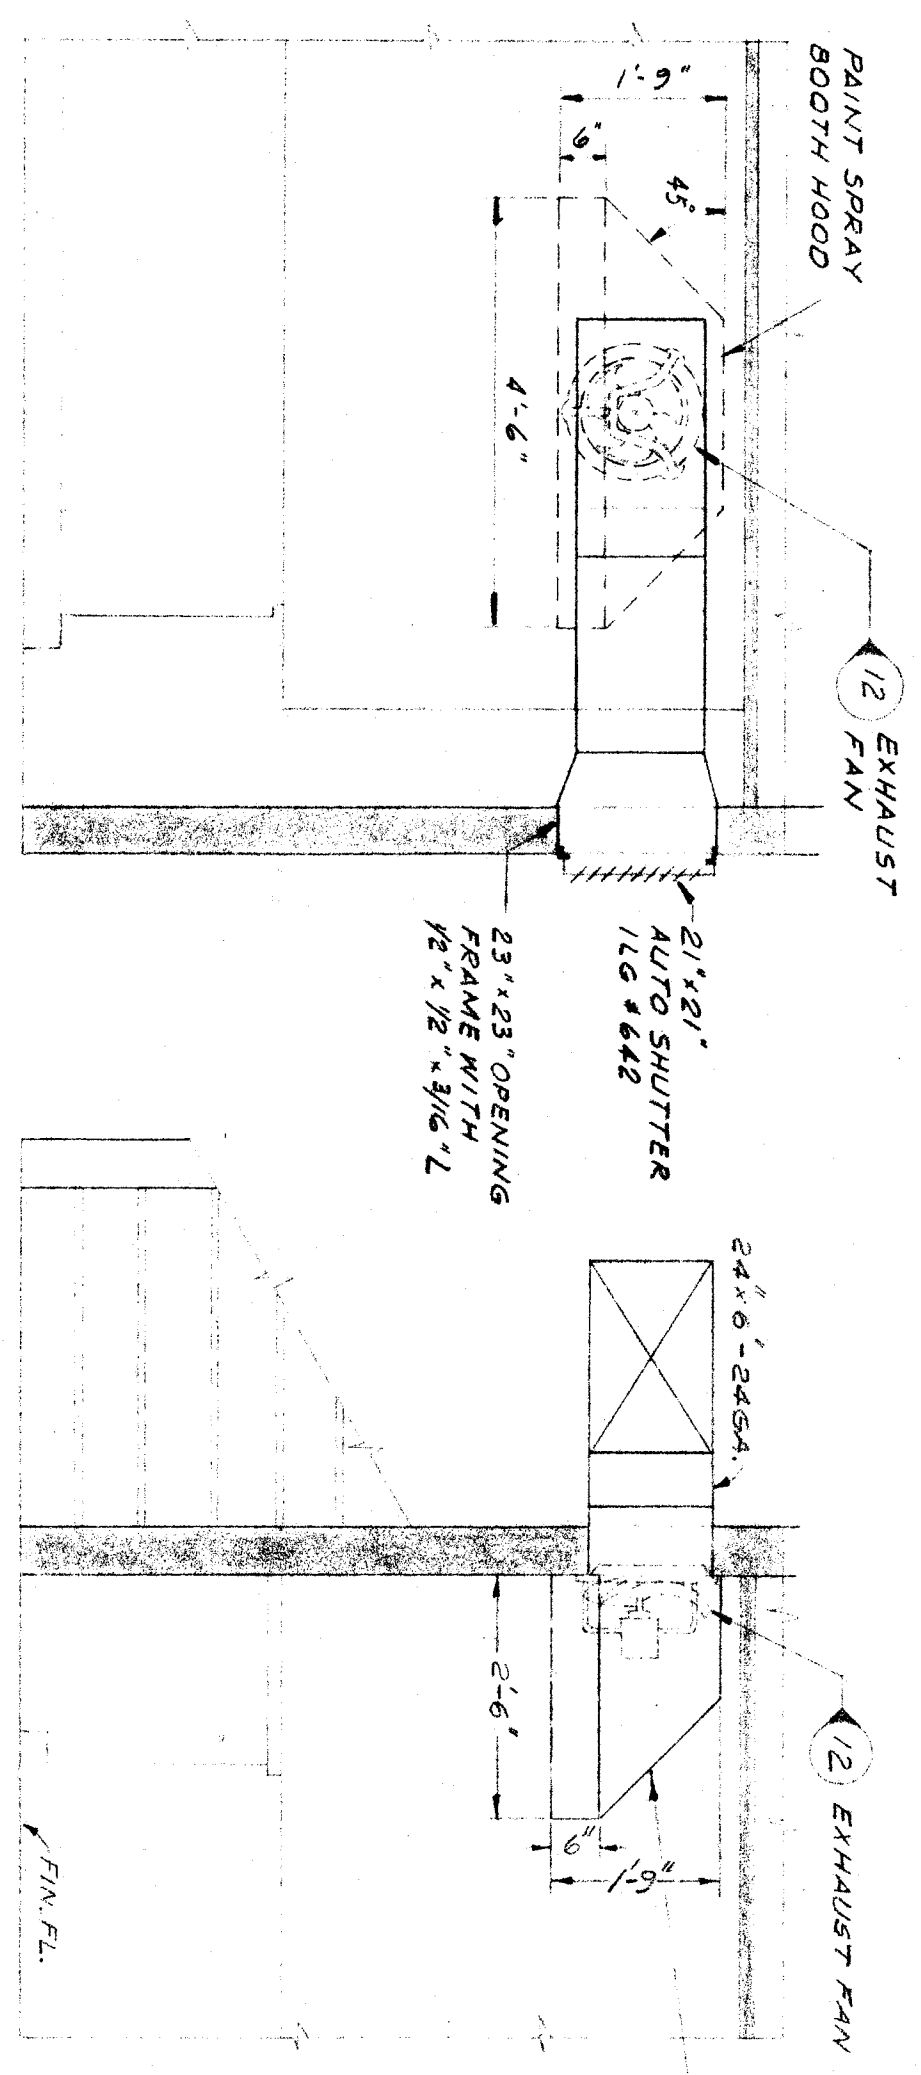


DETAIL E H-6
PAINT SPRAY EXHAUST
SCALE 1/8" = 1'-0"

NORTH ELEVATION


WEST ELEVATION

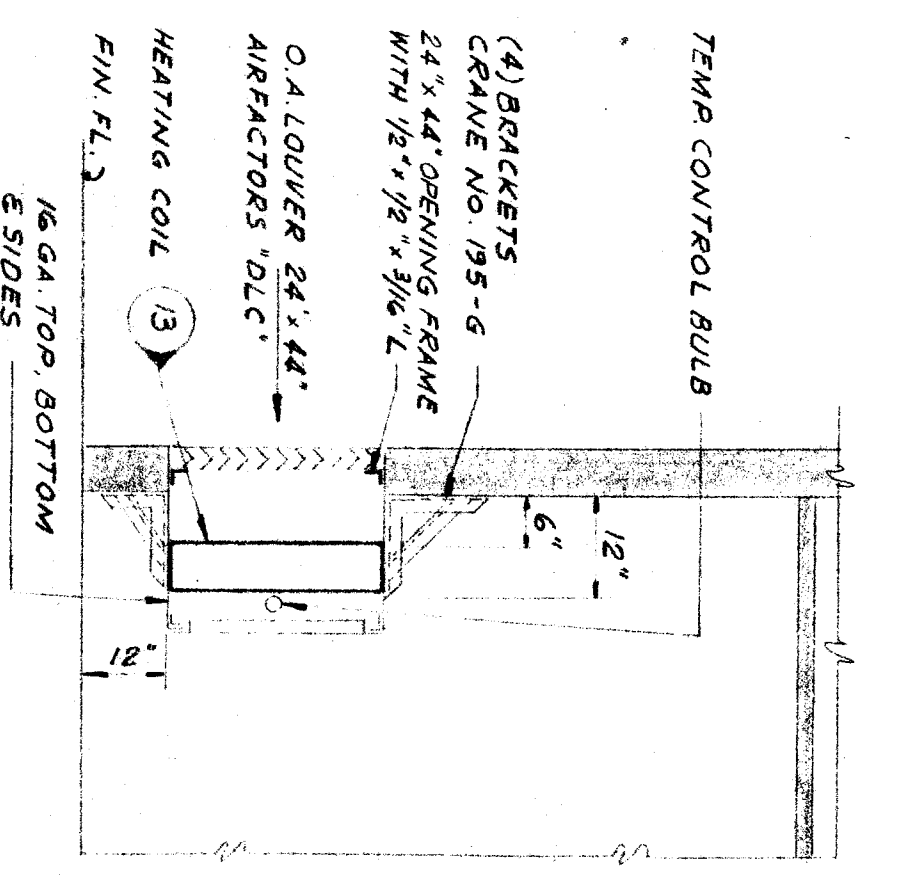


EAST ELEVATION
SCALE 1/8" = 1'-0"

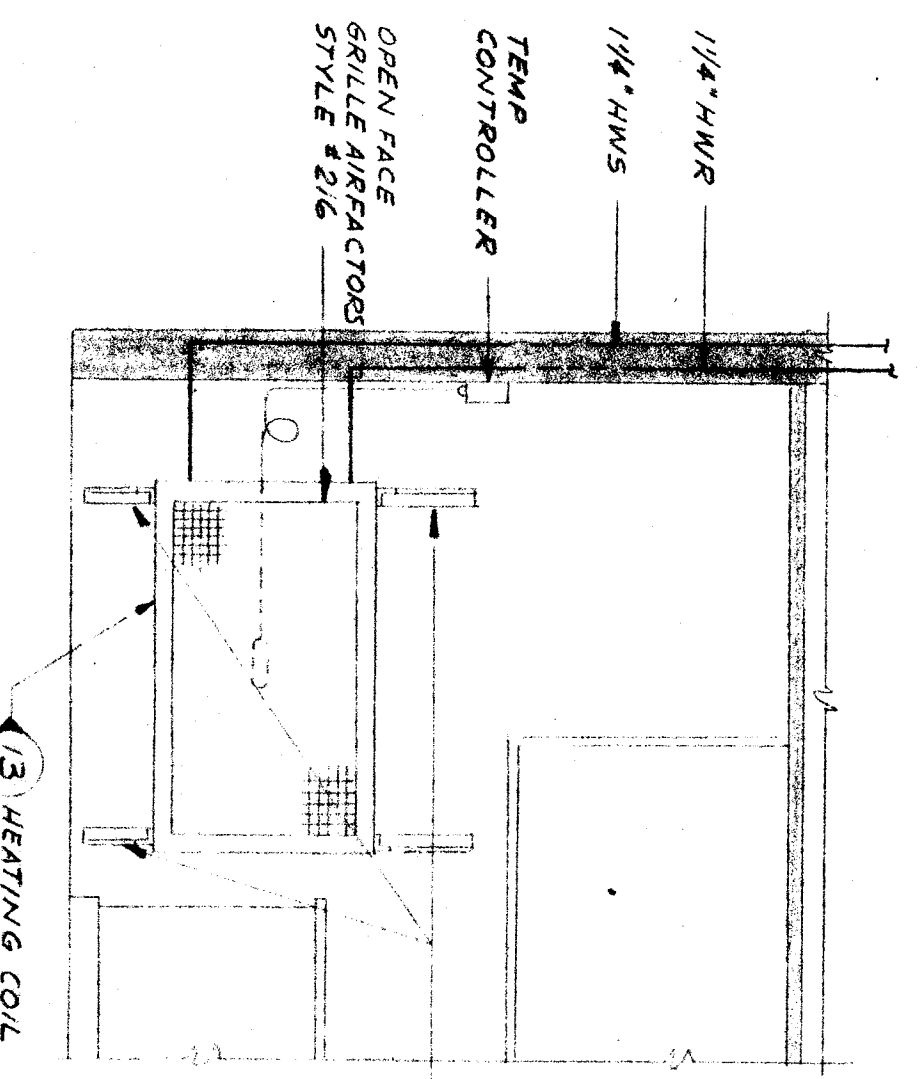


NORTH ELEVATION
SCALE 1/8" = 1'-0"

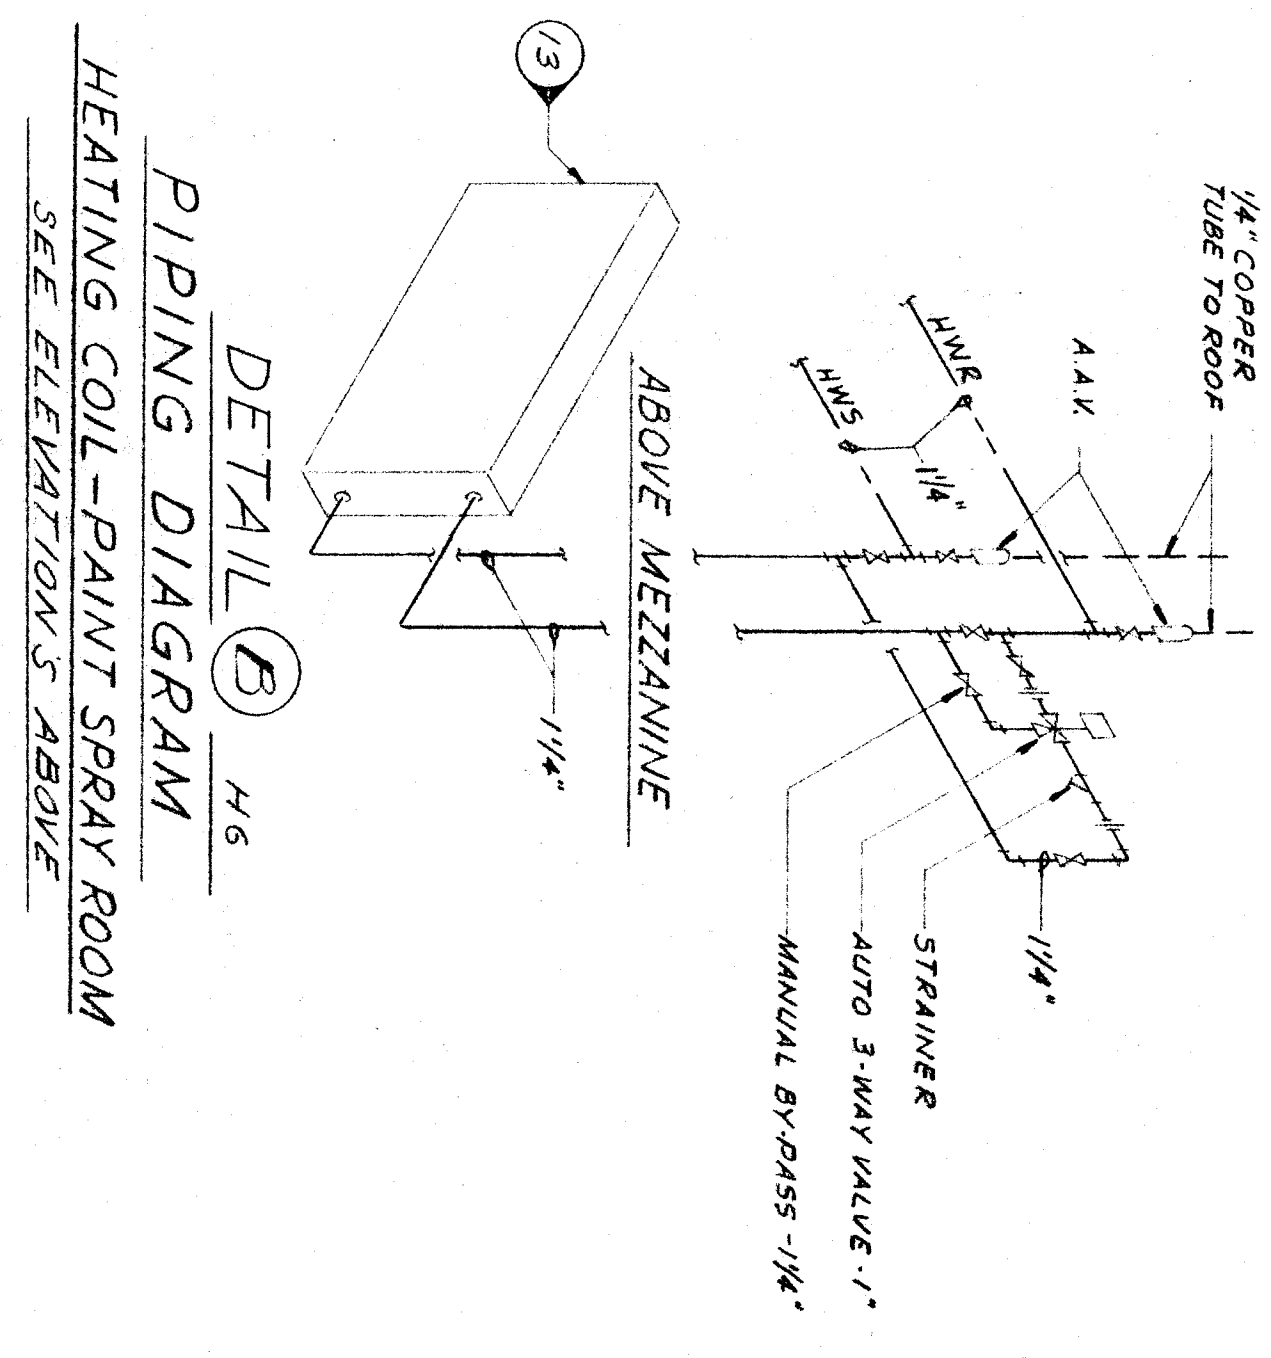


DETAIL B H-6
PIPING DIAGRAM
HEATING COIL-PAINT SPRAY ROOM
SEE ELEVATIONS ABOVE

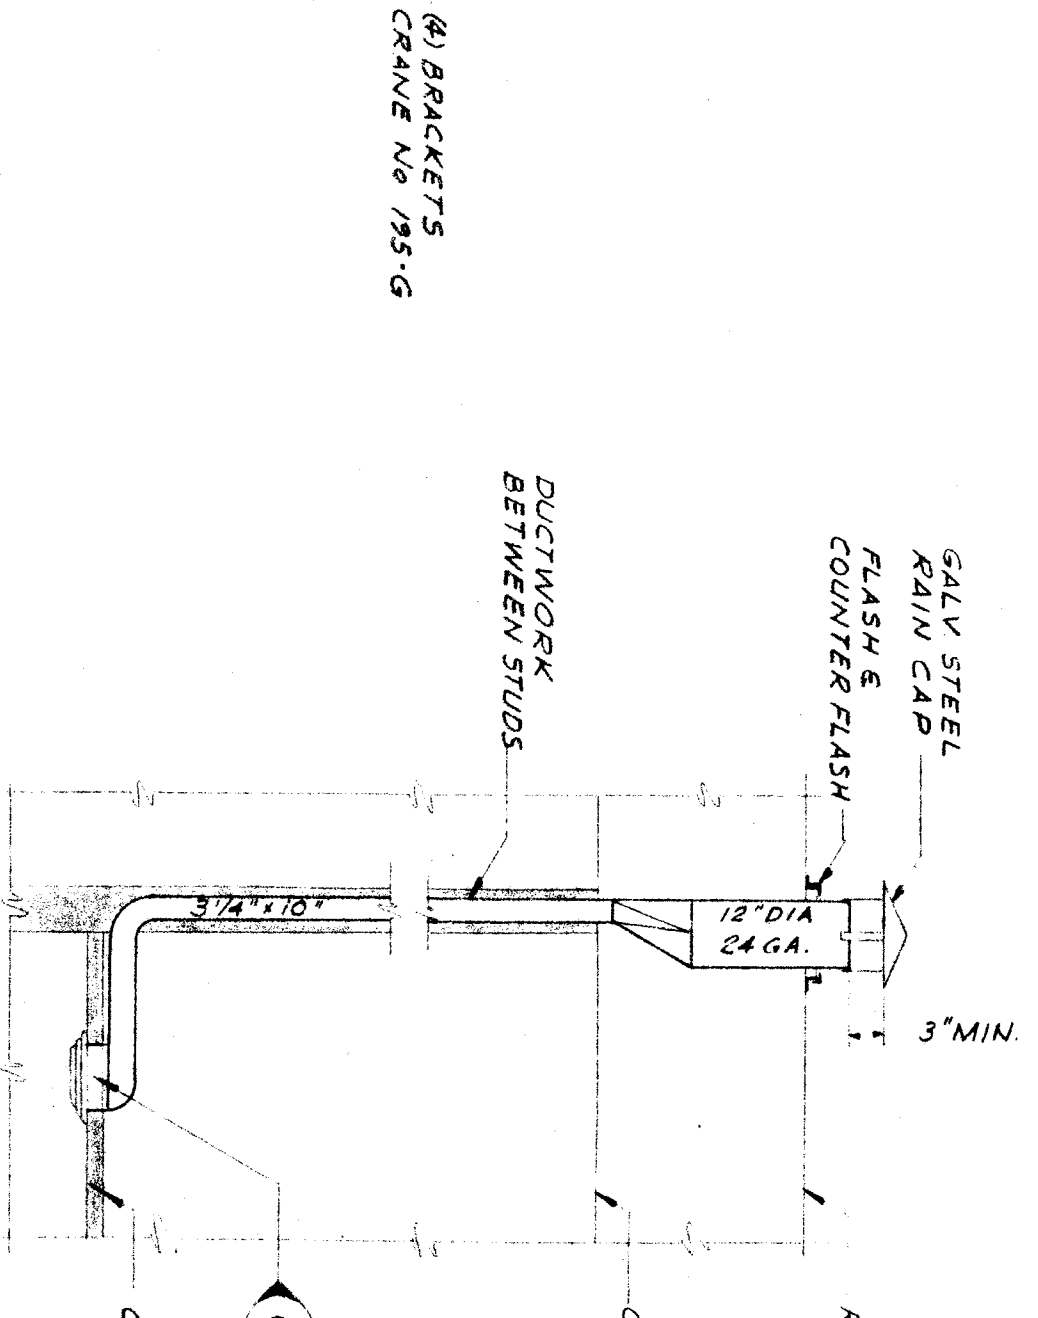


DETAIL C H-6
SCALE 3/8" = 1'-0"

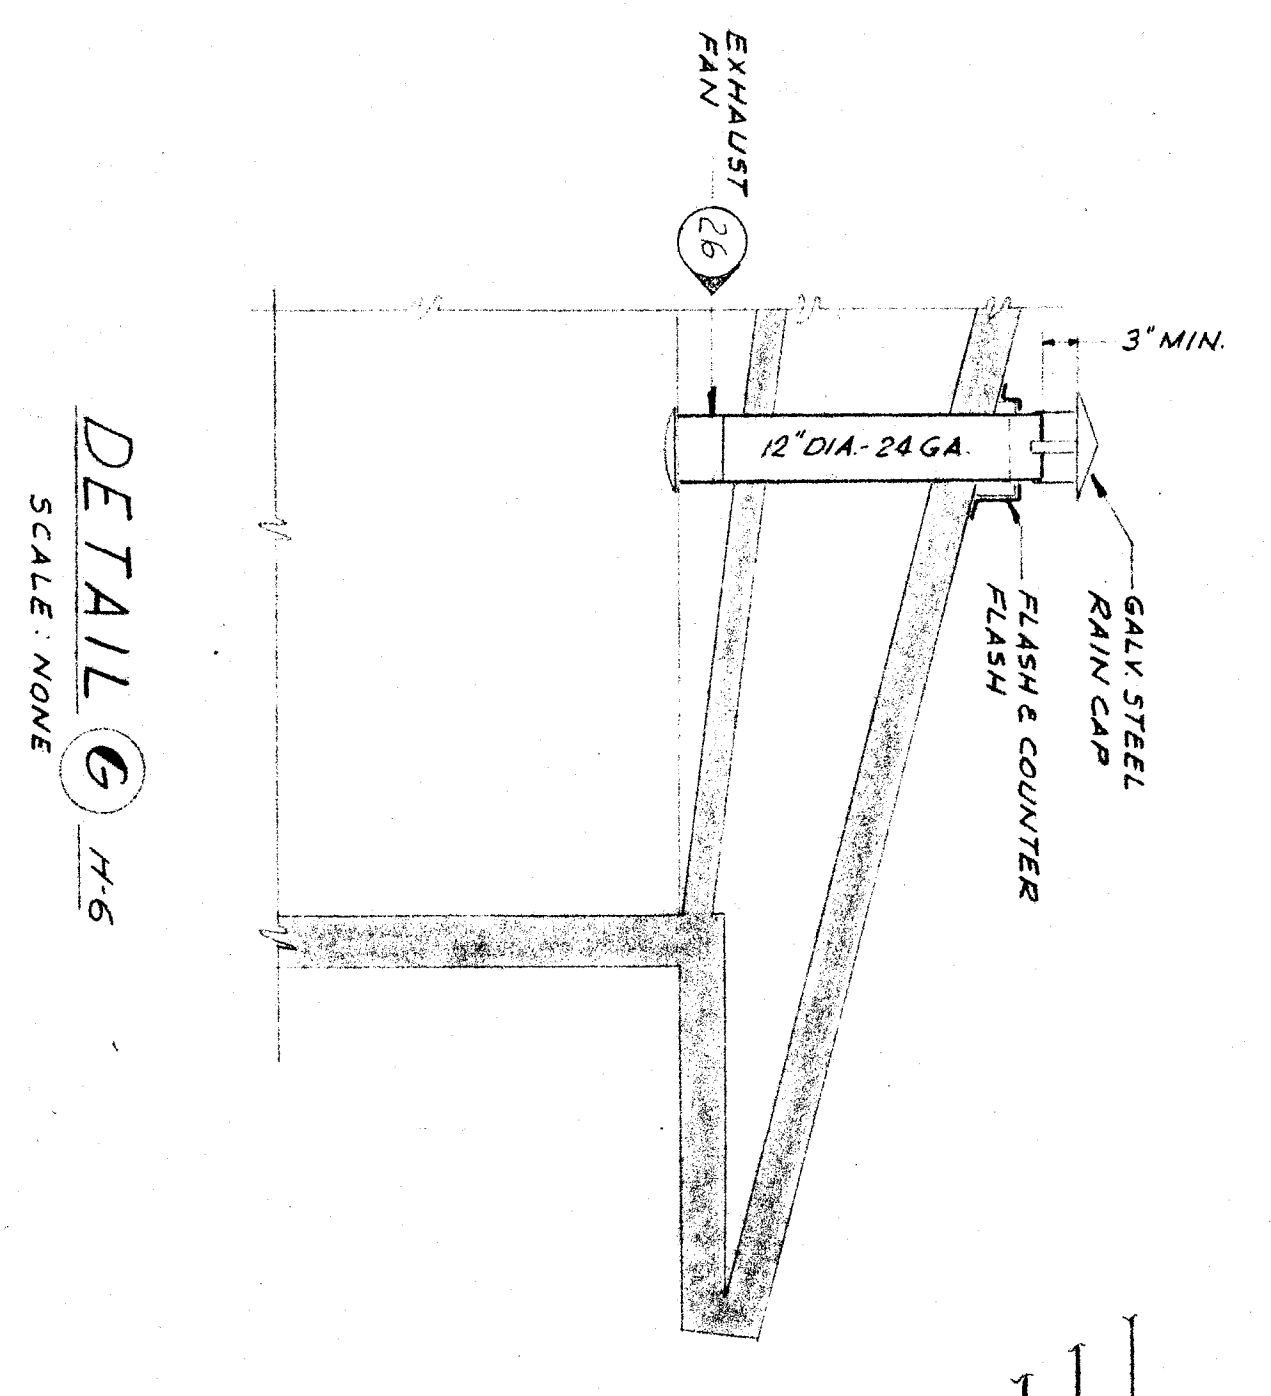


DETAIL D H-6
SCALE: NONE

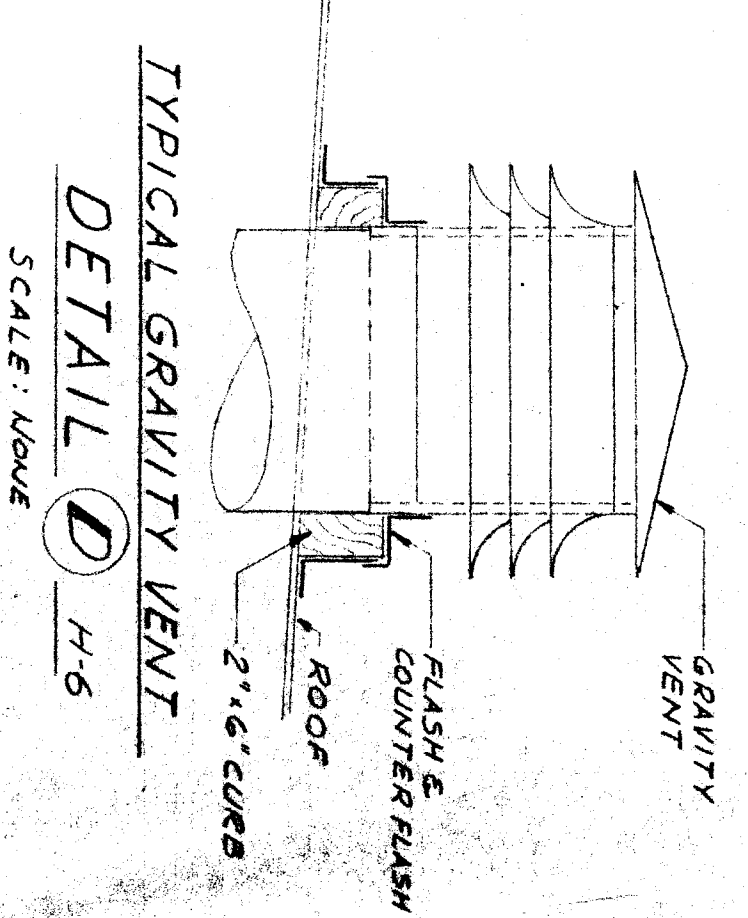


TYPICAL GRAVITY VENT
DETAIL D H-6
SCALE: NONE

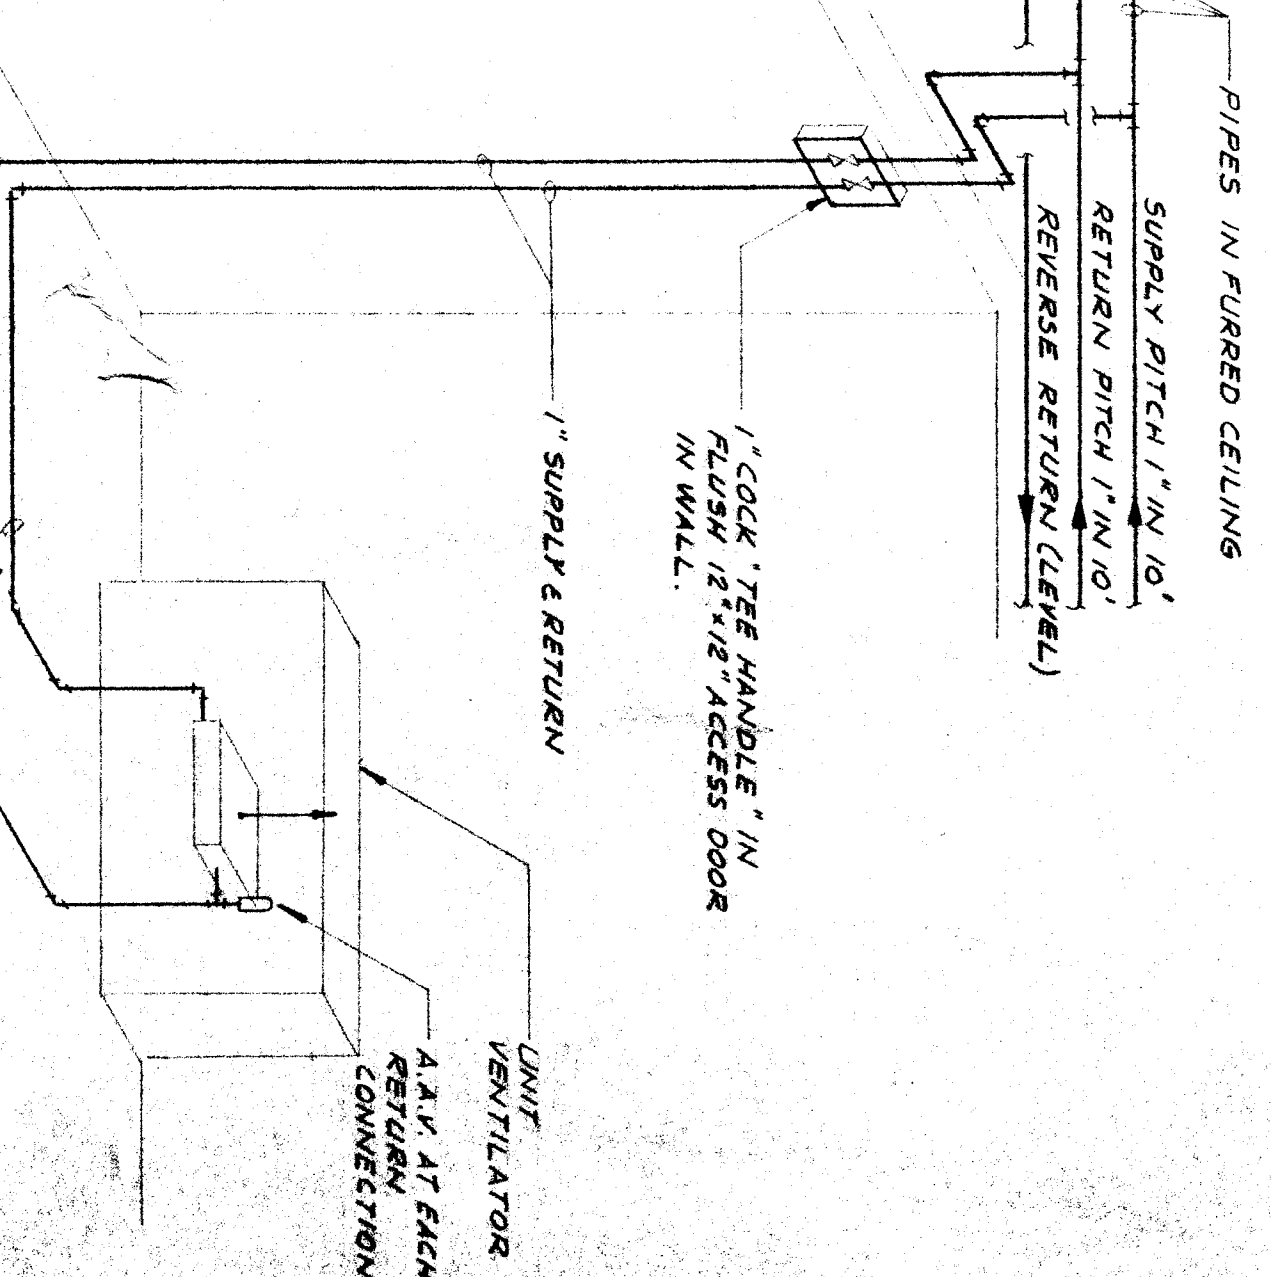


DETAIL H H-6
TYPICAL UNIT VENTILATOR & PIPING
NO SCALE

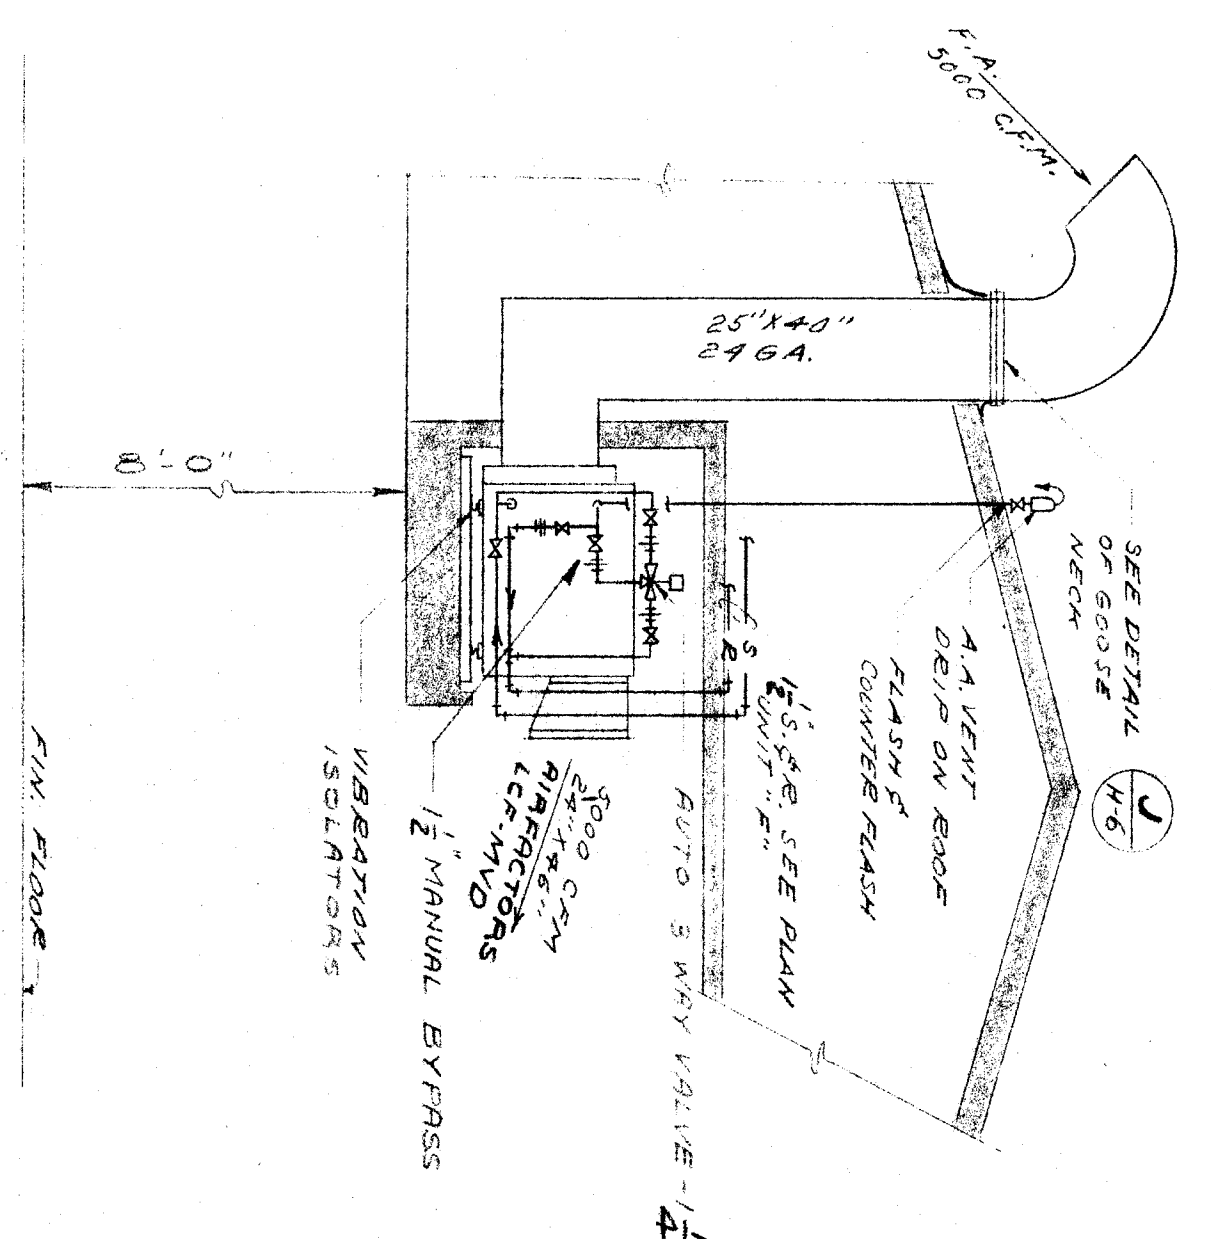

DETAIL I H-6
MITCHEM UNIT VENTILATOR
SCALE 1/8" = 1'-0"

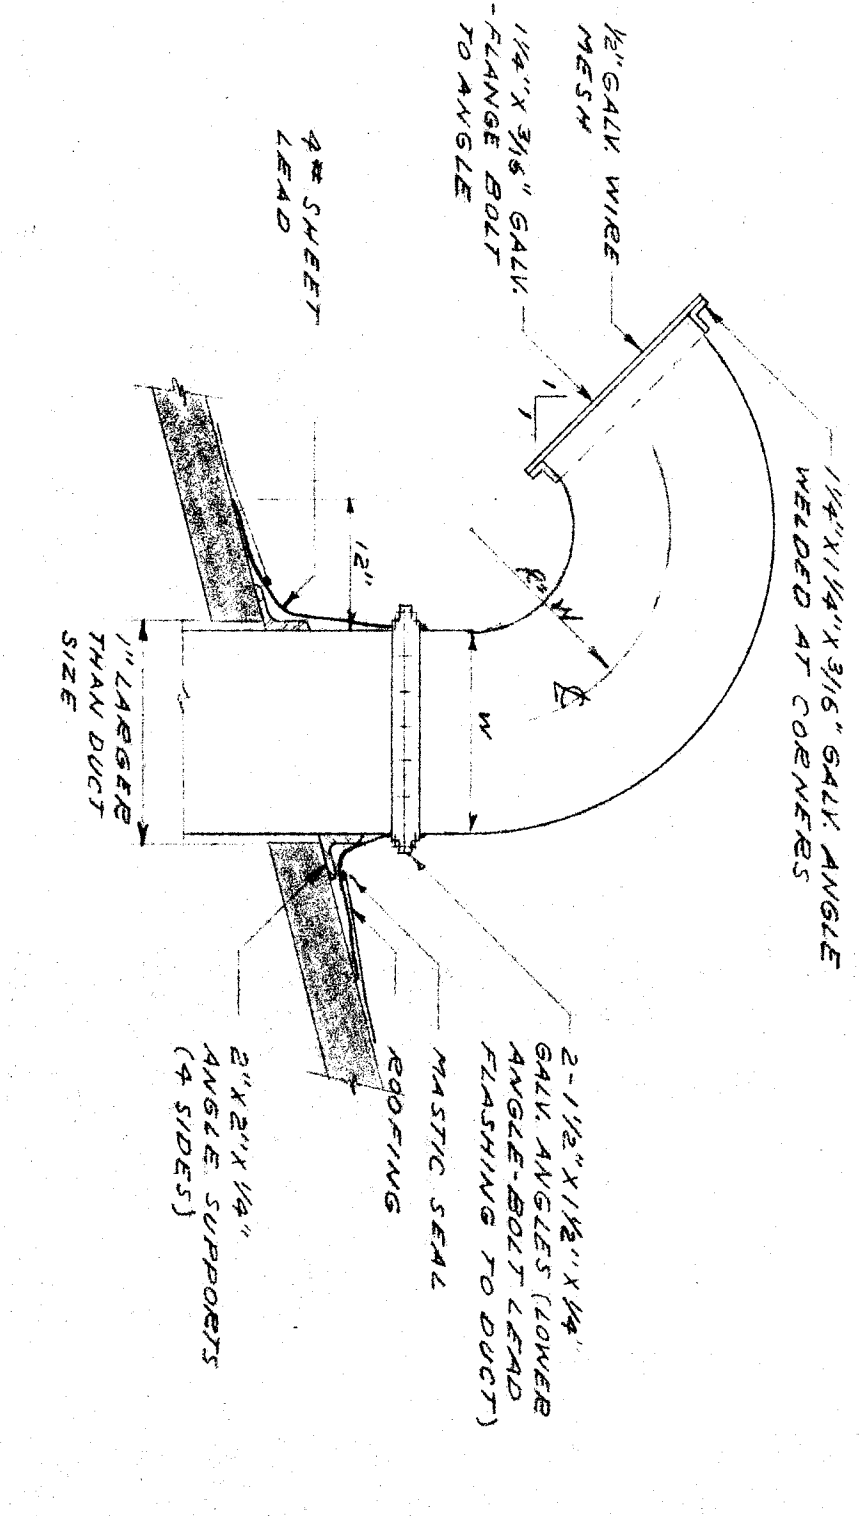

DETAIL J H-6
GOSSELTECH DETAIL
NO SCALE

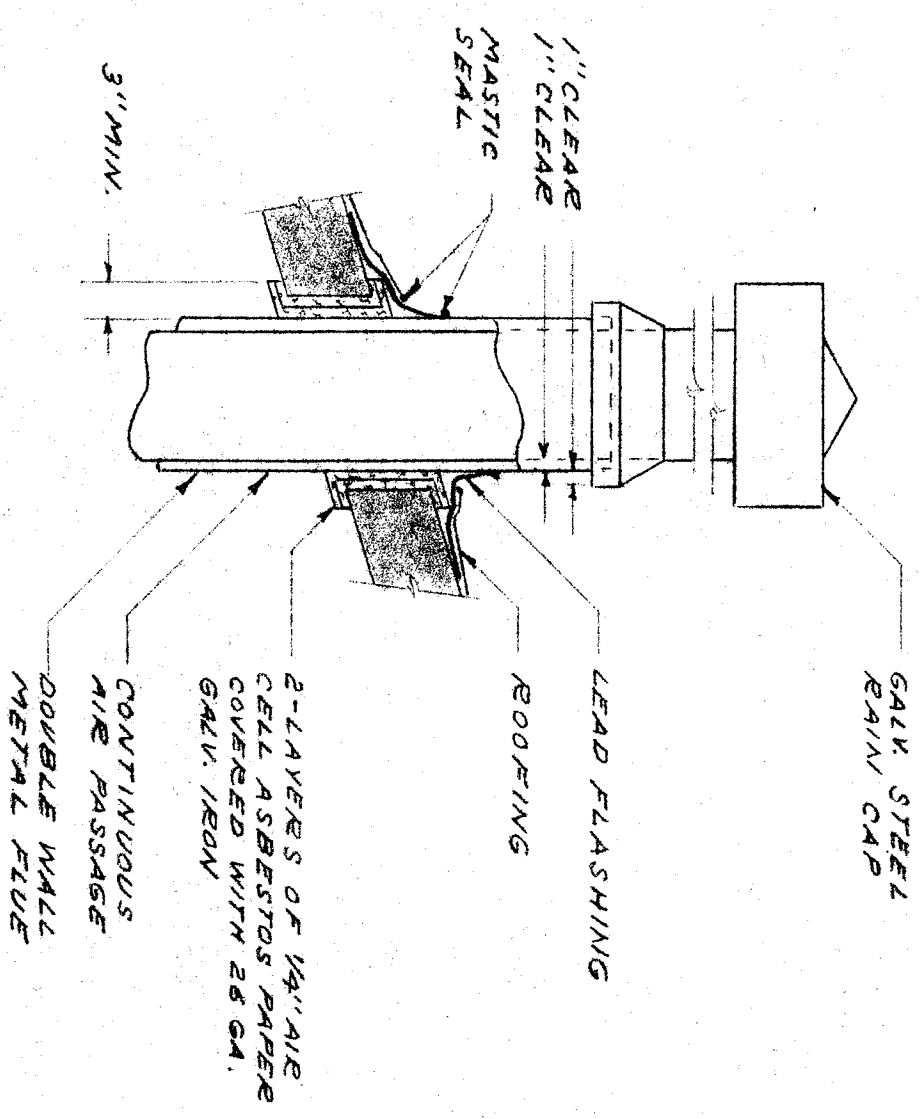

DETAIL K H-6
RAIN PIPE BOOF
NO SCALE

3.0
8/15/54
H-6
DATE
DRAWN
ERNEST L. MCCOY
2311 H STREET
BAKERSFIELD
CALIFORNIA

OFFICE OF SUPERINTENDENT OF SCHOOLS
DATE

STATE OF CALIFORNIA
DEPARTMENT OF PUBLIC WORKS
DIVISION OF ARCHITECTURE

181916
AUG 10 1954

BAKERSFIELD CITY SCHOOLS
1600 K STREET
BAKERSFIELD CALIFORNIA
BOARD OF TRUSTEES

WASHINGTON JR. HIGH SCHOOL
BAKERSFIELD CITY SCHOOL DISTRICT
CALIFORNIA

ERNEST L. MCCOY
2311 H STREET
BAKERSFIELD
CALIFORNIA

DATE
DRAWN
ERNEST L. MCCOY
2311 H STREET
BAKERSFIELD
CALIFORNIA

DATE
DRAWN
ERNEST L. MCCOY
2311 H STREET
BAKERSFIELD
CALIFORNIA

H-6
DATE
DRAWN
ERNEST L. MCCOY
2311 H STREET
BAKERSFIELD
CALIFORNIA

CHECK AND VERIFY ALL DIMENSIONS AND CONDITIONS AT JOB SITE BEFORE PROCEEDING WITH THE WORK. REPORT ANY DISCREPANCIES TO THE ARCHITECT.