



PIPE SUPPORT (FOR BUILT-UP ROOFING)
SCALE: NONE
SM TO DET. 4, SMT M-3

- KEYNOTES
- EXISTING WALL HUNG WATER CLOSET TO BE REMOVED. CAP PIPING BEHIND FINISH SURFACES.
 - EXISTING WALL HUNG WATER CLOSET TO BE REMOVED. SCRUBBED CLEAN AND RELOCATED. ALSO REMOVE TRIM, CAP PIPING BEHIND FINISH SURFACES. SEE REMOVE DETAIL B/P-7 FOR NEW LOCATION.
 - EXISTING WALL HUNG WATER CLOSET TO BE REMOVED. SCRUBBED CLEAN AND RELOCATED. ALSO REMOVE TRIM, SEE REMOVE DETAIL B/P-7.
 - EXISTING FLOOR MOUNTED URINAL TO BE REMOVED. CAP PIPING BEHIND FINISH SURFACES.
 - EXISTING LAVATORY TO BE REMOVED. CAP PIPING BEHIND FINISH SURFACES.
 - EXISTING LAVATORY TO BE REMOVED AND SCRUBBED CLEAN. ALSO REMOVE TRIM. SEE REMOVE DETAIL B/P-7.
 - EXISTING LAVATORY TO BE REMOVED. SCRUBBED CLEAN AND RELOCATED. ALSO REMOVE TRIM. SEE REMOVE DETAIL B/P-7 FOR NEW LOCATION. ON FLOOR BEHIND FINISH SURFACES.

NOTE:
ALL KEY NOTE NUMBERS ON THIS SHEET REFER TO THE NUMBERS SHOWN ELSEWHERE IN THIS SET OF PLANS.

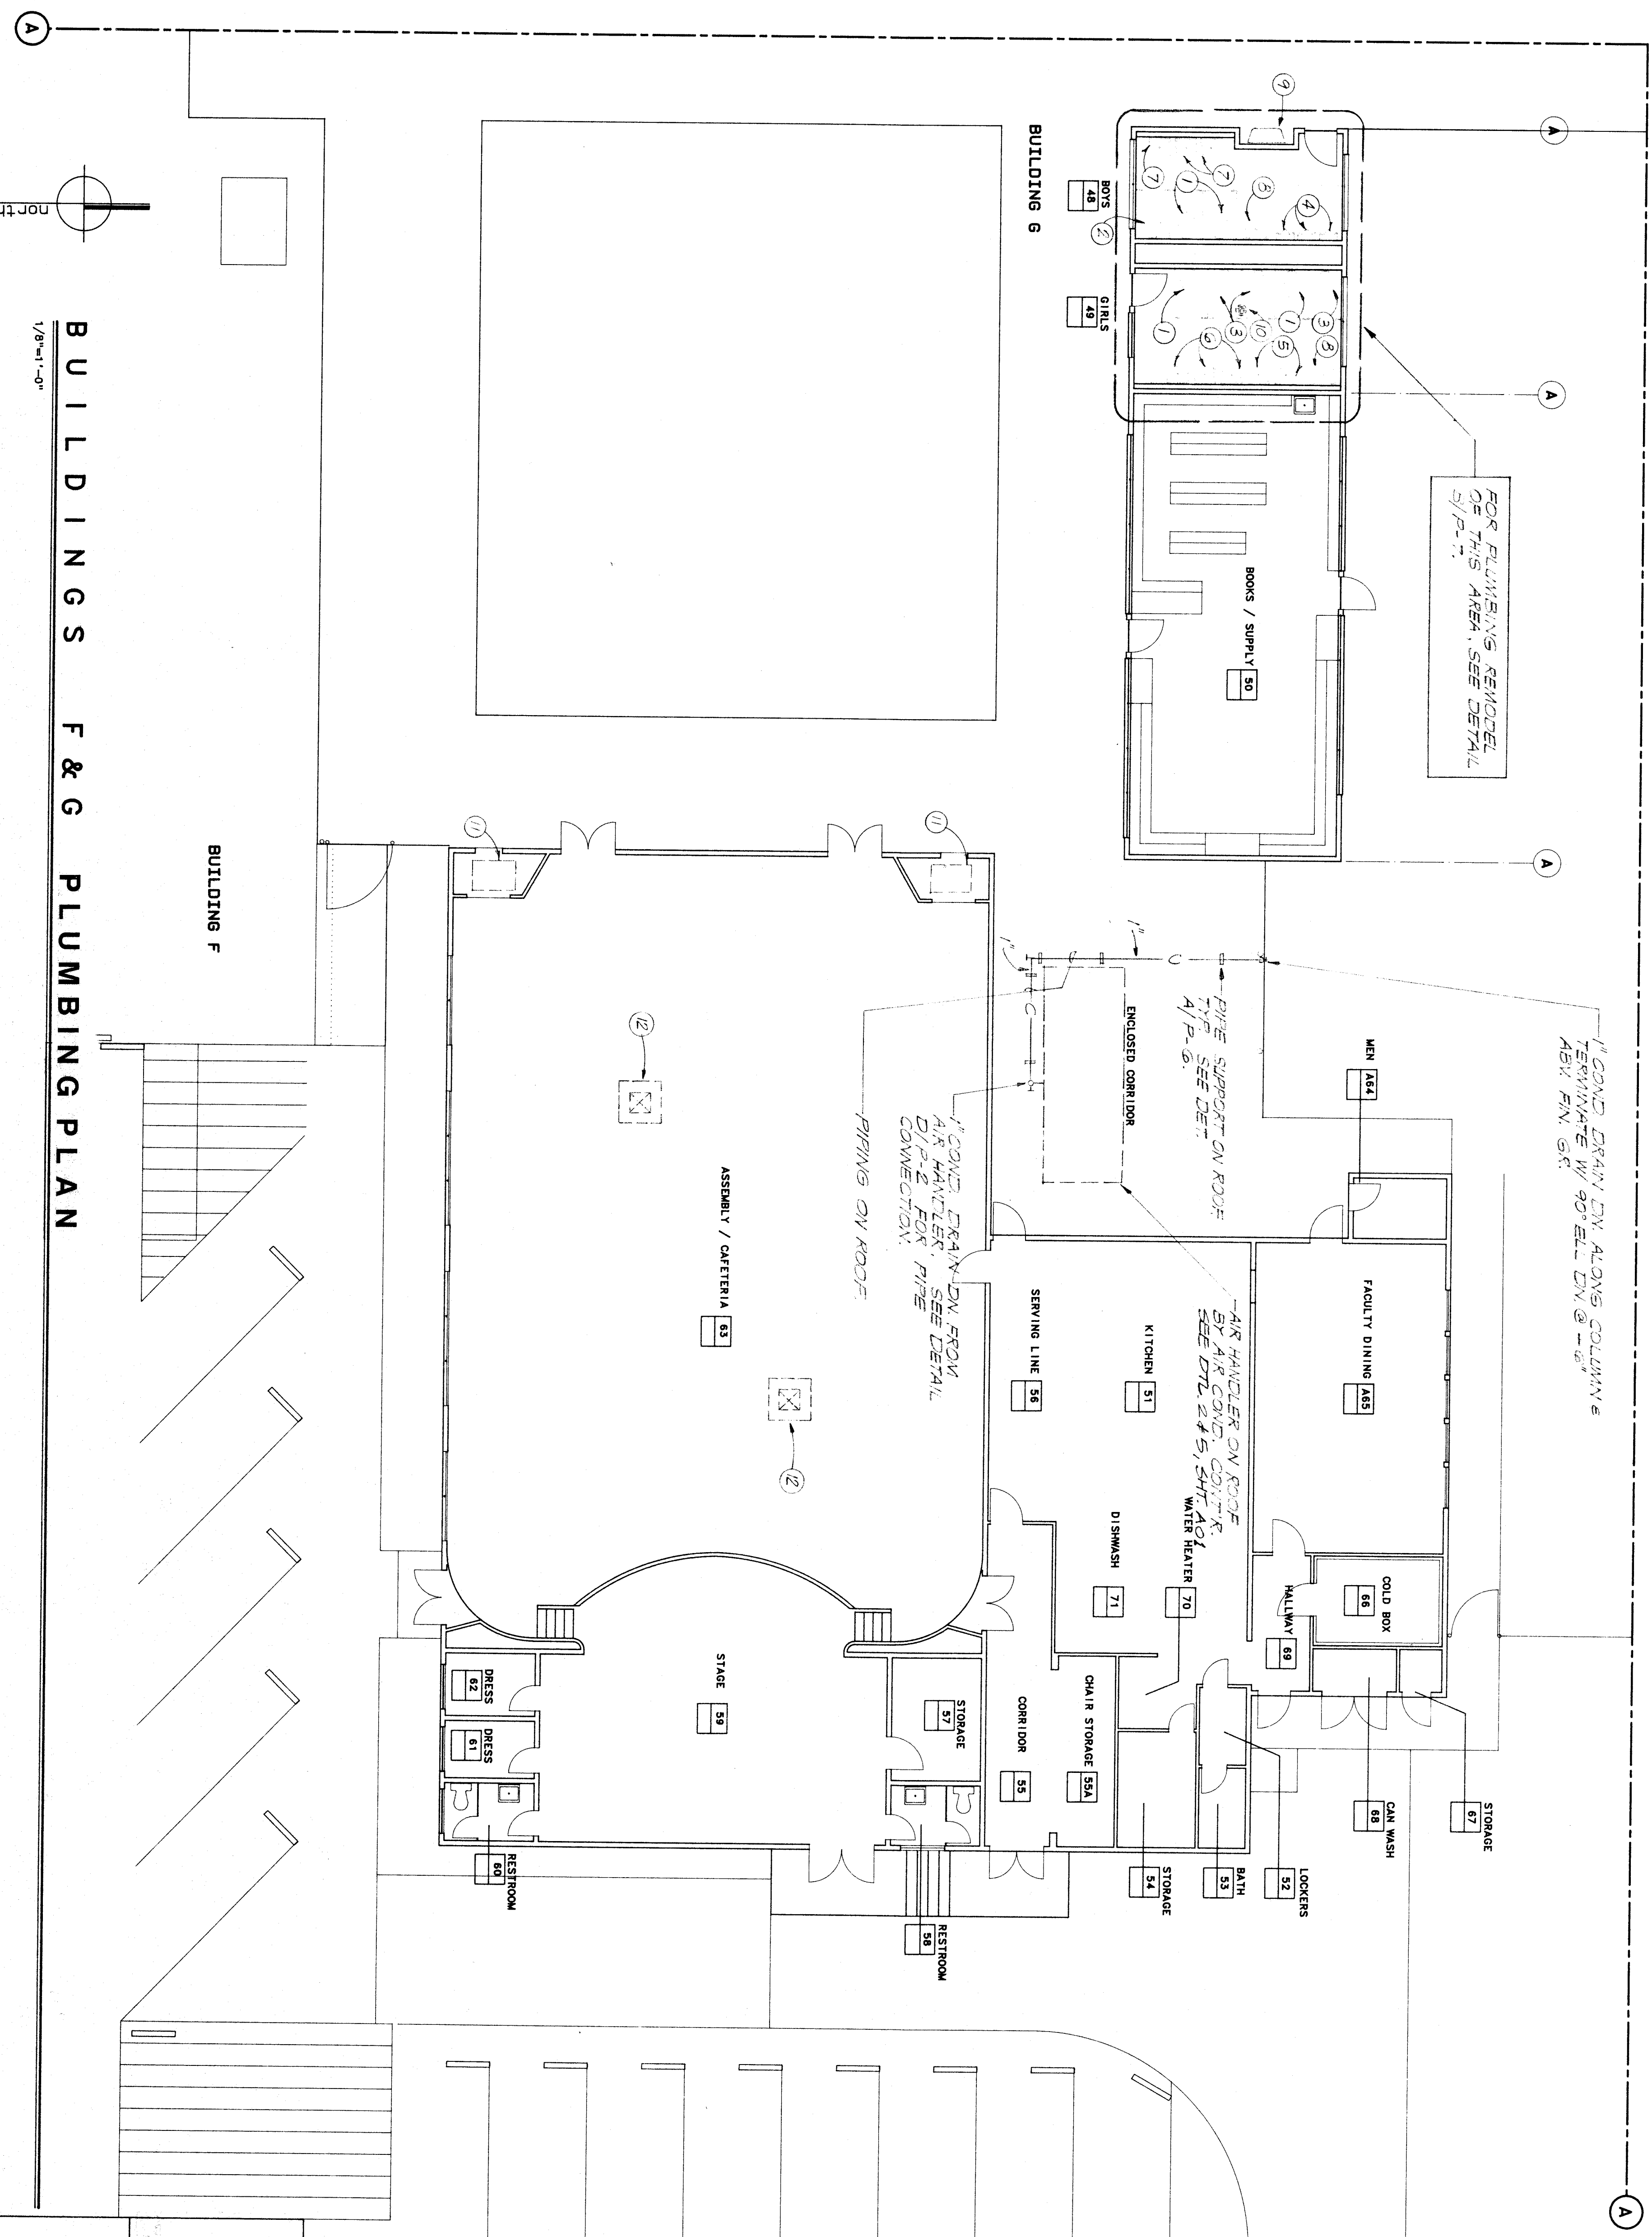

BUILDINGS F & G PLUMBING PLAN

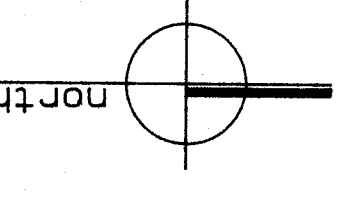

KLASSEN CORPORATION
Architect
Planning
Construction
2021 Westwind Drive
Bakersfield, CA 93301
(805) 327-0875

BAKERSFIELD CITY SCHOOL DISTRICT
WAYSIDE ELEMENTARY SCHOOL MODERNIZATION
BAKERSFIELD, CALIFORNIA

Sheet title: **BUILDINGS F & G PLUMBING PLAN**
WAYSIDE ELEMENTARY SCHOOL
BAKERSFIELD CITY SCHOOL DISTRICT
1000 MING AVENUE
BAKERSFIELD, CALIFORNIA 93301

NO # 11287	Issued for:
DATE	ISSUED FOR:
11/27/2021	DAVID J. BACHMANN
DATE	ISSUED FOR:
11/27/2021	DAVID J. BACHMANN
DATE	ISSUED FOR:
11/27/2021	DAVID J. BACHMANN
DATE	ISSUED FOR:
11/27/2021	DAVID J. BACHMANN
DATE	ISSUED FOR:
11/27/2021	DAVID J. BACHMANN
DATE	ISSUED FOR:
11/27/2021	DAVID J. BACHMANN

Drawn by: **MT**
Checked by: **GM**
Job no.: **1702**
Sheet: **P-6**
Date: