

RECEIVED
4:30 PM
MAR 01 2004
ARCHITECTURAL SERVICES

SCA Architect, Inc.
1501 L Street
Bakersfield, CA 93301
(661) 327-1632

RESTROOM BUILDINGS AND RELOCATABLE CLASSROOMS

AT FREMONT AND MT. VERNON ELEMENTARY SCHOOLS

BAKERSFIELD CITY SCHOOL DISTRICT

BAKERSFIELD, KERN COUNTY, CALIFORNIA

RESTROOM BUILDINGS
AND RELOCATABLE CLASSROOMS

FOR
607 TEXAS ST. AND 2161 POTOMAC AVE
BAKERSFIELD CITY SCHOOL DISTRICT
BAKERSFIELD, KERN COUNTY, CALIFORNIA

REGISTRATION NO. APPL-03-102874
DIV. OF THE STATE ARCHITECT
FILE 15-Z-V
DATE: 11/11/03

TITLE SHEET

REVISIONS

MARK	DATE	REVISIONS
△		
△		
△		
△		
△		

JOB NO. 432
432
432
DRAWN:
CHECKED:
DATE: 02/03/04

OF SHEETS
0

SHEET INDEX

ARCHITECTURAL		MECHANICAL		ELECTRICAL	
A0	TITLE SHEET	E1	ELECTRICAL SITE PLANS - FREMONT	E1	ELECTRICAL SITE PLANS - MT. VERNON
A1	TOPO SITE PLAN - MT. VERNON	E2	ELECTRICAL SITE PLANS - FREMONT	E2	ELECTRICAL SITE PLANS - MT. VERNON
A2	TOPO SITE PLAN - FREMONT	E3	ELECTRICAL SITE/PARTIAL ELECT. PLANS	E3	ELECTRICAL SITE/PARTIAL ELECT. PLANS
A3	SITE PLAN - MT. VERNON	E4	LIGHTING POWER & SIGNAL PLANS	E4	LIGHTING POWER & SIGNAL PLANS
A4	PARTIAL SITE/GRADING PLAN-MT. VERNON	E5	ONE LINE DIAGRAM, DETAILS & CODES	E5	ONE LINE DIAGRAM, DETAILS & CODES
A5	PARTIAL SITE/GRADING PLAN-FREMONT	E6	FA RISER DIAGRAMS, DETAILS & CODES	E6	FA RISER DIAGRAMS, DETAILS & CODES
A6	PARTIAL SITE/GRADING, DETAILS-FREMONT				
A7	PARTIAL SITE/GRADING, DETAILS-MT. VERNON				
A8	PARTIAL SITE/GRADING, DETAILS-MT. VERNON				
A9	PARTIAL SITE/GRADING, DETAILS-MT. VERNON				
A10	PARTIAL SITE/GRADING, DETAILS-MT. VERNON				
A11	PARTIAL SITE/GRADING, DETAILS-MT. VERNON				
A12	PARTIAL SITE/GRADING, DETAILS-MT. VERNON				
A13	PARTIAL SITE/GRADING, DETAILS-MT. VERNON				
A14	PARTIAL SITE/GRADING, DETAILS-MT. VERNON				
A15	PARTIAL SITE/GRADING, DETAILS-MT. VERNON				
A16	PARTIAL SITE/GRADING, DETAILS-MT. VERNON				
A17	PARTIAL SITE/GRADING, DETAILS-MT. VERNON				
A18	PARTIAL SITE/GRADING, DETAILS-MT. VERNON				
A19	PARTIAL SITE/GRADING, DETAILS-MT. VERNON				
A20	PARTIAL SITE/GRADING, DETAILS-MT. VERNON				
A21	PARTIAL SITE/GRADING, DETAILS-MT. VERNON				
A22	PARTIAL SITE/GRADING, DETAILS-MT. VERNON				
A23	PARTIAL SITE/GRADING, DETAILS-MT. VERNON				
A24	PARTIAL SITE/GRADING, DETAILS-MT. VERNON				
A25	PARTIAL SITE/GRADING, DETAILS-MT. VERNON				
A26	PARTIAL SITE/GRADING, DETAILS-MT. VERNON				
A27	PARTIAL SITE/GRADING, DETAILS-MT. VERNON				
A28	PARTIAL SITE/GRADING, DETAILS-MT. VERNON				
A29	PARTIAL SITE/GRADING, DETAILS-MT. VERNON				
A30	PARTIAL SITE/GRADING, DETAILS-MT. VERNON				
A31	PARTIAL SITE/GRADING, DETAILS-MT. VERNON				
A32	PARTIAL SITE/GRADING, DETAILS-MT. VERNON				
A33	PARTIAL SITE/GRADING, DETAILS-MT. VERNON				
A34	PARTIAL SITE/GRADING, DETAILS-MT. VERNON				
A35	PARTIAL SITE/GRADING, DETAILS-MT. VERNON				
A36	PARTIAL SITE/GRADING, DETAILS-MT. VERNON				
A37	PARTIAL SITE/GRADING, DETAILS-MT. VERNON				
A38	PARTIAL SITE/GRADING, DETAILS-MT. VERNON				
A39	PARTIAL SITE/GRADING, DETAILS-MT. VERNON				
A40	PARTIAL SITE/GRADING, DETAILS-MT. VERNON				
A41	PARTIAL SITE/GRADING, DETAILS-MT. VERNON				
A42	PARTIAL SITE/GRADING, DETAILS-MT. VERNON				
A43	PARTIAL SITE/GRADING, DETAILS-MT. VERNON				
A44	PARTIAL SITE/GRADING, DETAILS-MT. VERNON				
A45	PARTIAL SITE/GRADING, DETAILS-MT. VERNON				
A46	PARTIAL SITE/GRADING, DETAILS-MT. VERNON				
A47	PARTIAL SITE/GRADING, DETAILS-MT. VERNON				
A48	PARTIAL SITE/GRADING, DETAILS-MT. VERNON				
A49	PARTIAL SITE/GRADING, DETAILS-MT. VERNON				
A50	PARTIAL SITE/GRADING, DETAILS-MT. VERNON				

GENERAL NOTES

NOTHING IN THE DRAWINGS AND/OR THE SPECIFICATIONS SHALL BE CONSIDERED AS A WAIVER OF THE CONTRACTOR'S OBLIGATION TO OBTAIN ALL NECESSARY PERMITS AND APPROVALS FROM THE APPLICABLE LOCAL, STATE AND FEDERAL AGENCIES. THE CONTRACTOR SHALL BE RESPONSIBLE FOR OBTAINING ALL NECESSARY PERMITS AND APPROVALS FROM THE APPLICABLE LOCAL, STATE AND FEDERAL AGENCIES. THE CONTRACTOR SHALL BE RESPONSIBLE FOR OBTAINING ALL NECESSARY PERMITS AND APPROVALS FROM THE APPLICABLE LOCAL, STATE AND FEDERAL AGENCIES.

ABBREVIATIONS

1	BLDG. GRID LINES
2	DOOR SYMBOL
3	WINDOW SYMBOL
4	LOWER SYMBOL
5	REVISION SYMBOL
6	WORK POINT
7	SECTION NUMBER
8	SHEET NUMBER
9	DETAIL NUMBER
10	ROOM NUMBER / NAME
11	INT. ELEVATION OF ROOM
12	REVISED FINISH GRADE
13	EXISTING GRADE
14	COVERED CORRIDOR LETTER
15	DESIGNATION FOR OFFICE OF ORIGINAL CONSULTANT

DESIGN TEAM

ARCHITECT
SCA Architect, Inc.
1501 L STREET
BAKERSFIELD, CA 93301
(661) 327-1632

STRUCTURAL ENGINEER
JOHN O. FORESTELLE, S.E.
1414 VALHALLA DR.
BAKERSFIELD, CA 93304
(661) 893-4311


MECHANICAL ENGINEER
MECHANICAL DESIGN CONCEPTS
428 TRUXTON AVE.
BAKERSFIELD, CALIFORNIA 93301
(661) 326-1313

ELECTRICAL ENGINEER
CORNELIUS CONSULTING GROUP, INC.
31 S. DUNSMOUTH
VISALIA, CA 93242
(559) 199-2611

LEGEND

1	BLDG. GRID LINES
2	DOOR SYMBOL
3	WINDOW SYMBOL
4	LOWER SYMBOL
5	REVISION SYMBOL
6	WORK POINT
7	SECTION NUMBER
8	SHEET NUMBER
9	DETAIL NUMBER
10	ROOM NUMBER / NAME
11	INT. ELEVATION OF ROOM
12	REVISED FINISH GRADE
13	EXISTING GRADE
14	COVERED CORRIDOR LETTER
15	DESIGNATION FOR OFFICE OF ORIGINAL CONSULTANT

VICINITY MAP

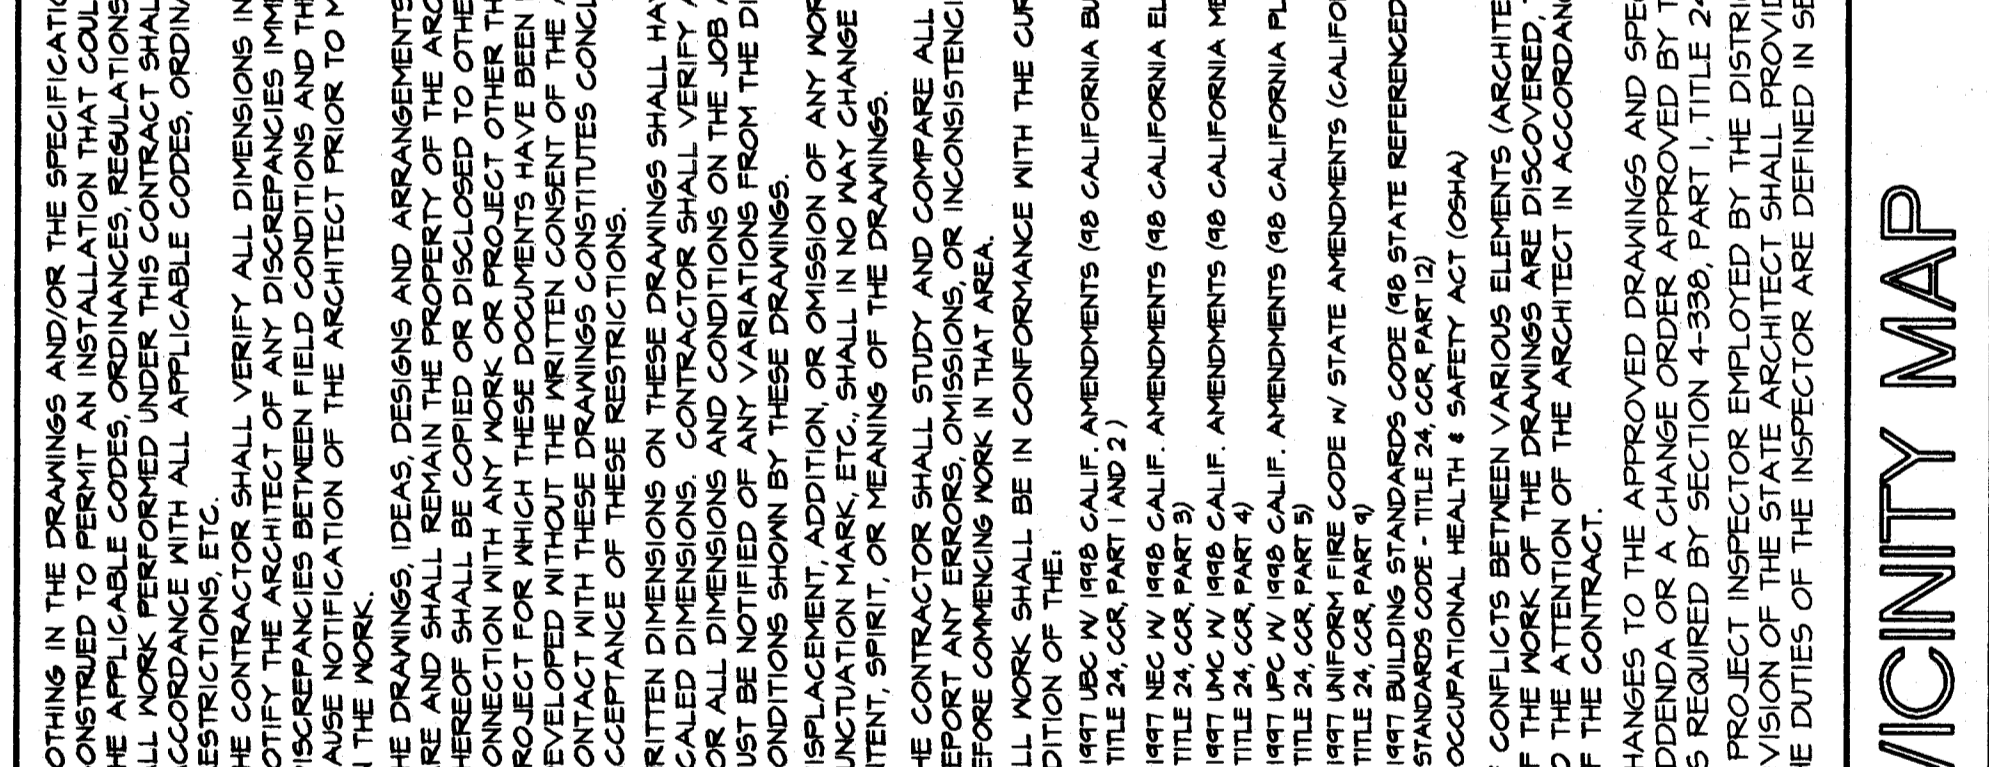

COMPLETE FIRE ALARM SYSTEM SUBMITTAL

THE FIRE ALARM SYSTEM SHALL CONFORM TO CALIFORNIA BUILDING CODE, SECTION 905.4, AND CALIFORNIA FIRE CODE, ARTICLE 160. UPON COMPLETION OF THE INSTALLATION OF THE FIRE PROTECTIVE SIGNALING EQUIPMENT, THE CONTRACTOR SHALL NOTIFY THE FIRE DEPARTMENT AND THE CALIFORNIA FIRE DEPARTMENT INSPECTOR. THE CONTRACTOR SHALL BE RESPONSIBLE FOR OBTAINING ALL NECESSARY PERMITS AND APPROVALS FROM THE APPLICABLE LOCAL, STATE AND FEDERAL AGENCIES.

CAMPUS ANALYSIS

BLDG #	A #S	BLDG USE	SQ FTG	CLASSIFICATION/CONST. TYPE
BLDG A	11902	ADMIN / KIT	6503.26	GROUP A-3 / B TYPE V-N
BLDG B	11902	ADMIN / KINDER	6616.82	GROUP E-1 TYPE V-N
BLDG C	11902	4 CLSRMS	6451.68	GROUP E-1 TYPE V-N
BLDG D	11902	5 CLSRMS	6451.68	GROUP E-1 TYPE V-N
BLDG E	11902	5 CLSRMS	6451.68	GROUP E-1 TYPE V-N
BLDG F	11902	2 CLSRMS / ART	3835.20	GROUP E-1 TYPE V-N
BLDG G	30361	5 CLSRMS / ADJ / LIB	1407.51	GROUP E-1 TYPE V-N
BLDG H	DOH	COUNSELOR	504.00	GROUP E-1 TYPE V-N
BLDG I	1 CLSRM	1 CLSRM	460.00	GROUP E-1 TYPE V-N
BLDG J	1 CLSRM	1 CLSRM	460.00	GROUP E-1 TYPE V-N
BLDG K	1 CLSRM	1 CLSRM	460.00	GROUP E-1 TYPE V-N
BLDG L	28584	KIC	460.00	GROUP E-1 TYPE V-N
BLDG M	MAG. MISC	MAGNET	504.00	GROUP E-1 TYPE V-N
BLDG N	21294	KINDER	1547.70	GROUP E-1 TYPE V-N
BLDG O	4 CLSRMS	4 CLSRMS	3840.00	GROUP E-1 TYPE V-N
BLDG P	6 CLSRMS	6 CLSRMS	5760.00	GROUP E-1 TYPE V-N
BLDG Q	4 CLSRMS	4 CLSRMS	3840.00	GROUP E-1 TYPE V-N
BLDG R	4 CLSRMS	4 CLSRMS	3840.00	GROUP E-1 TYPE V-N

CAMPUS ANALYSIS

BLDG #	A #S	BLDG USE	SQ FTG	CLASSIFICATION/CONST. TYPE
BLDG A	11911	MULTI / KIT	5416.83	GROUP A-3 TYPE V-N
BLDG B	3252	5 CLSRMS	5423.4	GROUP E-1 TYPE V-N
BLDG C	3252	5 CLSRMS	6224.26	GROUP E-1 TYPE V-N
BLDG D	3616	5 CLSRMS / LIB	6106.14	GROUP E-1 TYPE V-N
BLDG E	3616	4 CLSRMS / LIB	6104.94	GROUP E-1 TYPE V-N
BLDG F	3616	PERE ARTS	3616.31	GROUP E-1 TYPE V-N
BLDG G	28594	BLDG 6	1027.50	GROUP E-1 TYPE V-N
BLDG H	3252, 32602	ADMIN	3811.17	GROUP B TYPE V-N
BLDG I	3252, 32602	2 KINDER	3261.42	GROUP E-1 TYPE V-N
BLDG J	21294, 32602	2 KINDER	3609.30	GROUP E-1 TYPE V-N
BLDG K	460.00	460.00	460.00	GROUP E-1 TYPE V-N
BLDG L	460.00	460.00	460.00	GROUP E-1 TYPE V-N
BLDG M	460.00	460.00	460.00	GROUP E-1 TYPE V-N
BLDG N	504.00	504.00	504.00	GROUP E-1 TYPE V-N
BLDG O	1547.70	1547.70	1547.70	GROUP E-1 TYPE V-N
BLDG P	3840.00	3840.00	3840.00	GROUP E-1 TYPE V-N
BLDG Q	5760.00	5760.00	5760.00	GROUP E-1 TYPE V-N
BLDG R	30361	RR	657.800	GROUP E-1 TYPE V-N
BLDG S	32602	RR	300.00	GROUP E-1 TYPE V-N