


THESE DRAWINGS AND ALL MATERIAL CONTAINED HEREIN ARE THE PROPERTY OF SILVERCREEK INDUSTRIES, INC (SCI Inc) AND SHALL NOT BE REPRODUCED, COPIED OR OTHERWISE DISPOSED OF DIRECTLY OR INDIRECTLY AND SHALL NOT BE USED IN WHOLE OR IN PART TO ASSIST IN THE MAKING OF OR FOR THE PURPOSE OF FURNISHING ANY INFORMATION FOR THE MAKING OF DRAWINGS, PRINTS, APPARATUS OR PARTS THEREOF WITHOUT THE FULL KNOWLEDGE AND WRITTEN CONSENT OF SCI Inc.
 ALL PATENTABLE MATERIAL CONTAINED HEREIN AND ORIGINATING WITH SCI Inc SHALL BE THE PROPERTY OF SCI Inc

SILVER CREEK INDUSTRIES, INC.

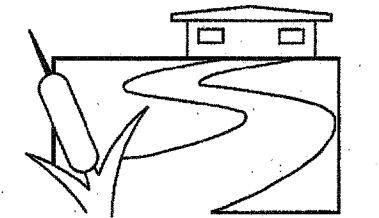

"BUILDING FOR THE NEXT GENERATION"

SILVER CREEK


2830 BARRETT AVE. PERRIS, CALIFORNIA 92571
 PHONE: 951-943-5393 FAX: 951-943-2211

PROJECT NAME:


24x40 STOCKPILE OFFICE BUILDING

SHEET TITLE:

PROJECT SPECIFIC MECHANICAL PLAN

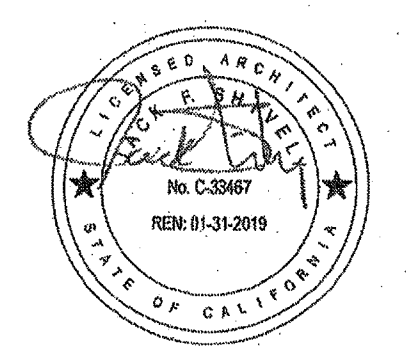

ARCHITECT OF RECORD SUBMISSION DATE

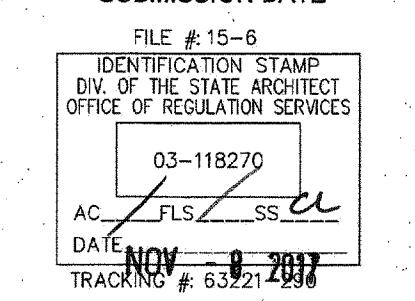

PROJECT SPECIFIC STATE AGENCY APPROVAL

IDENTIFICATION STAMP
 DIV. OF THE STATE ARCHITECT

04 116284
 ACS FLS SS RMP
 DATE MAY 18 2017


ORIGINAL PC STATE AGENCY APPROVAL

REVISIONS

SILVER CREEK INDUSTRIES
 PROJECT NO: 10914
 DRAWN BY:
 SCALE: AS NOTED
 DATE: 04-20-17

SHEET NUMBER
M-1.01N

NOTE:
 PROVIDE ECONOMIZER W/ HVAC UNIT.
 SEE M-1.01 FOR MECHANICAL SCHEDULE

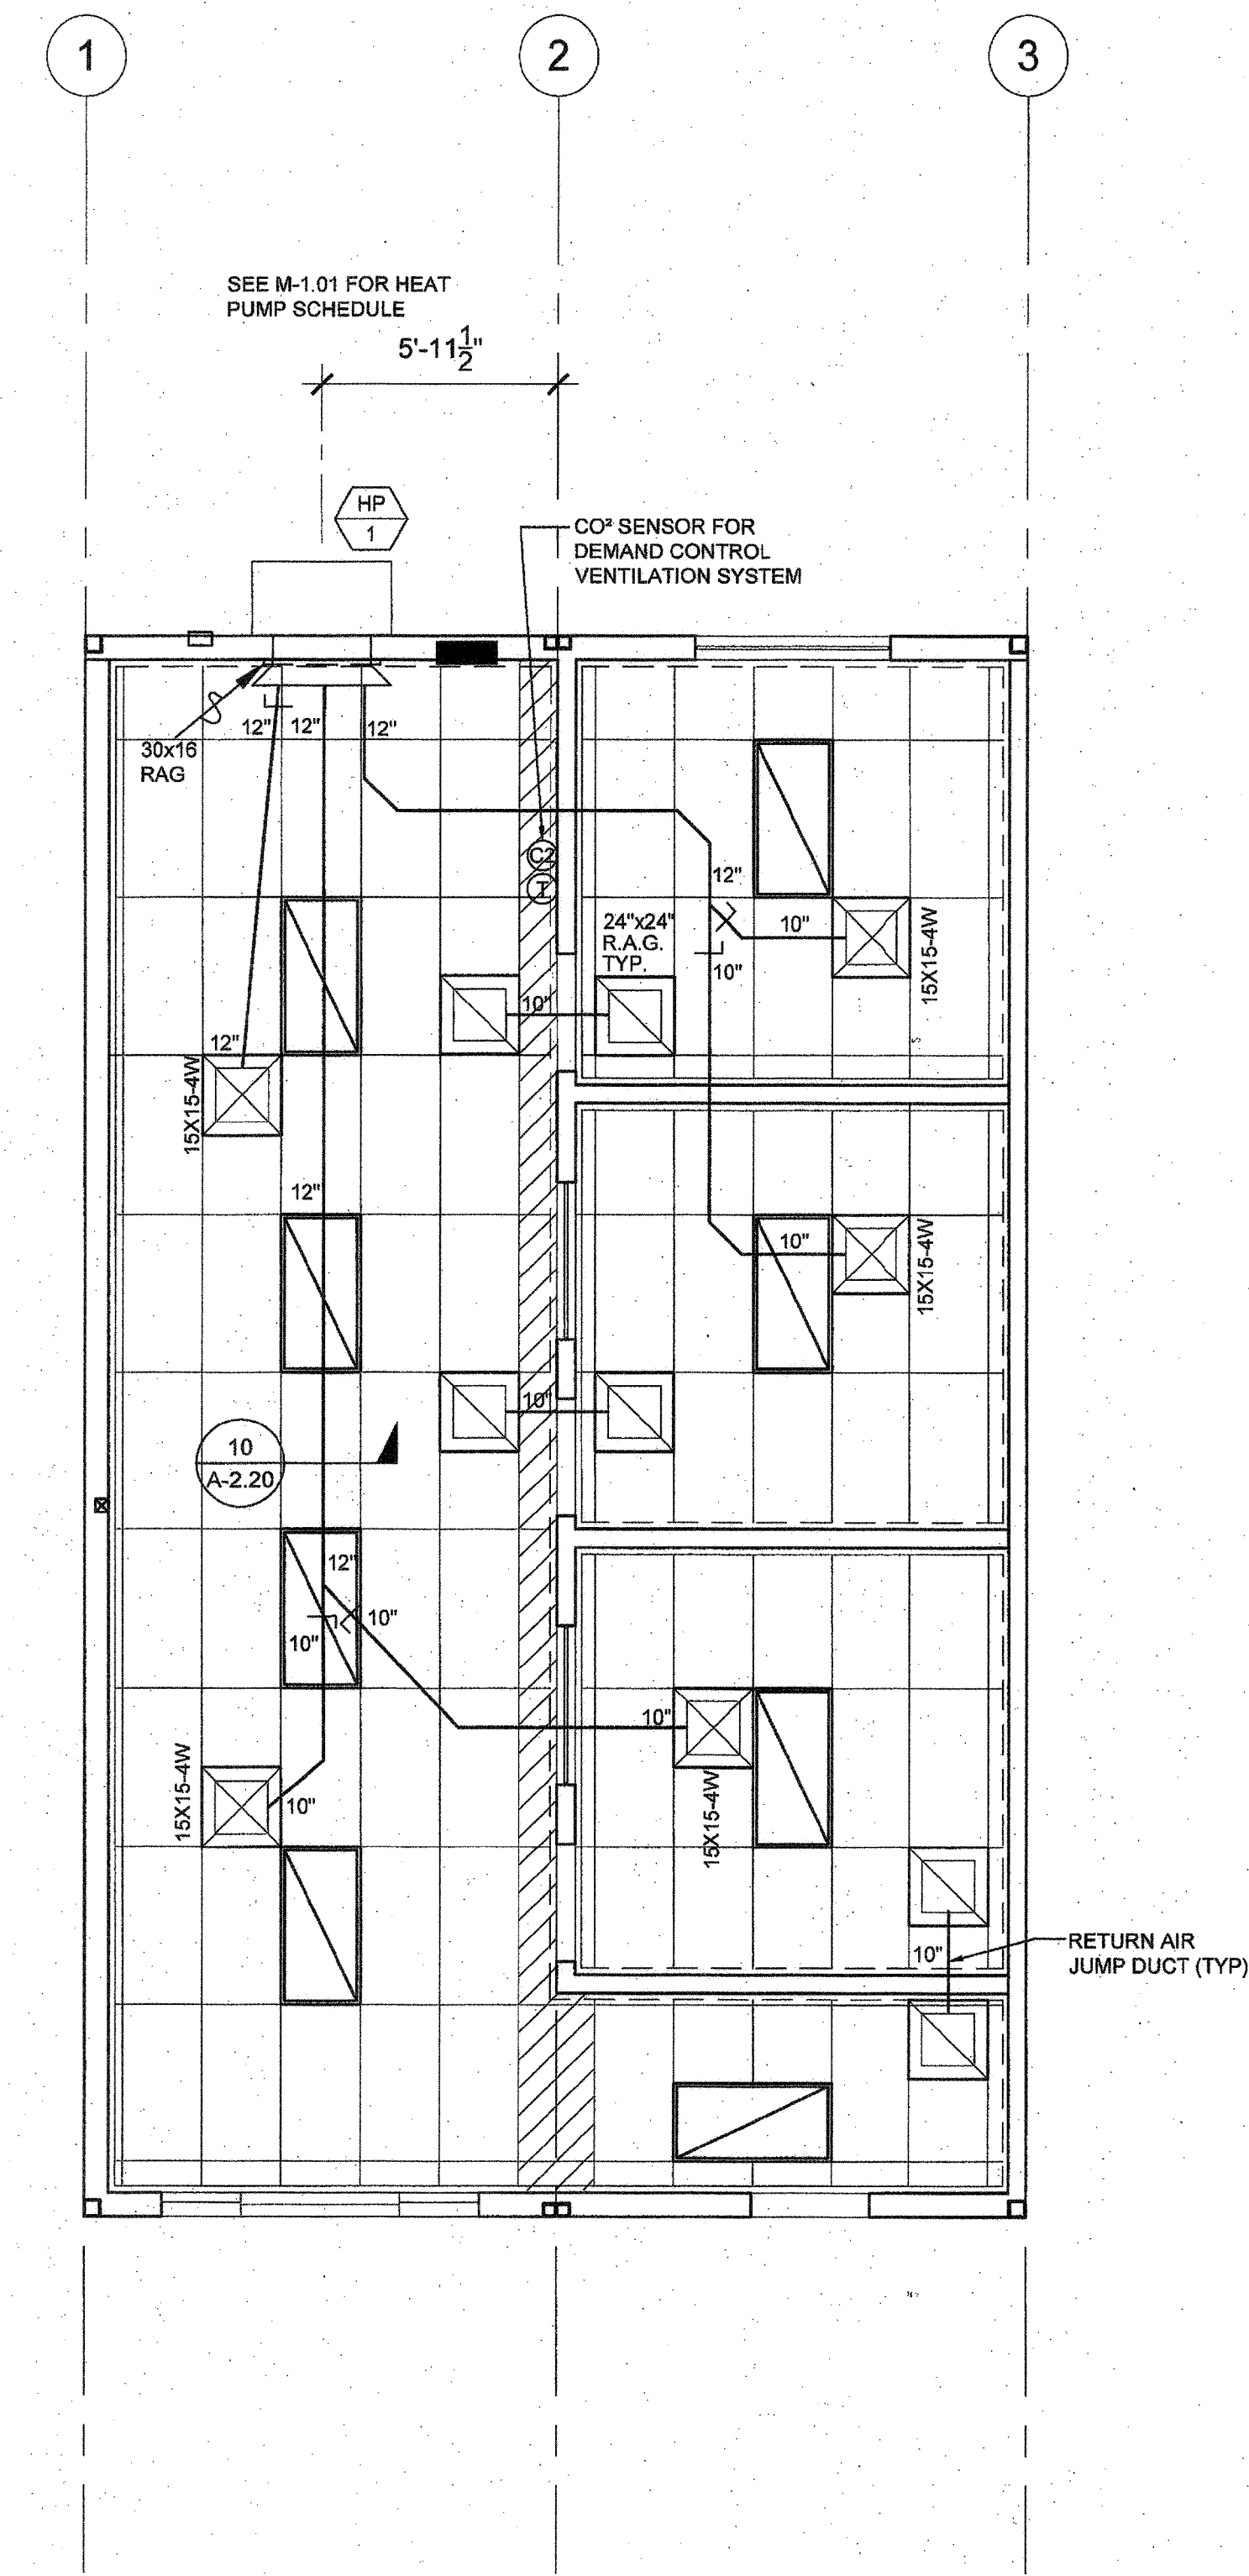

MECHANICAL PLAN

SCALE: 1/4" = 1'-0" 1