


NOT USED

2

NOT USED

3

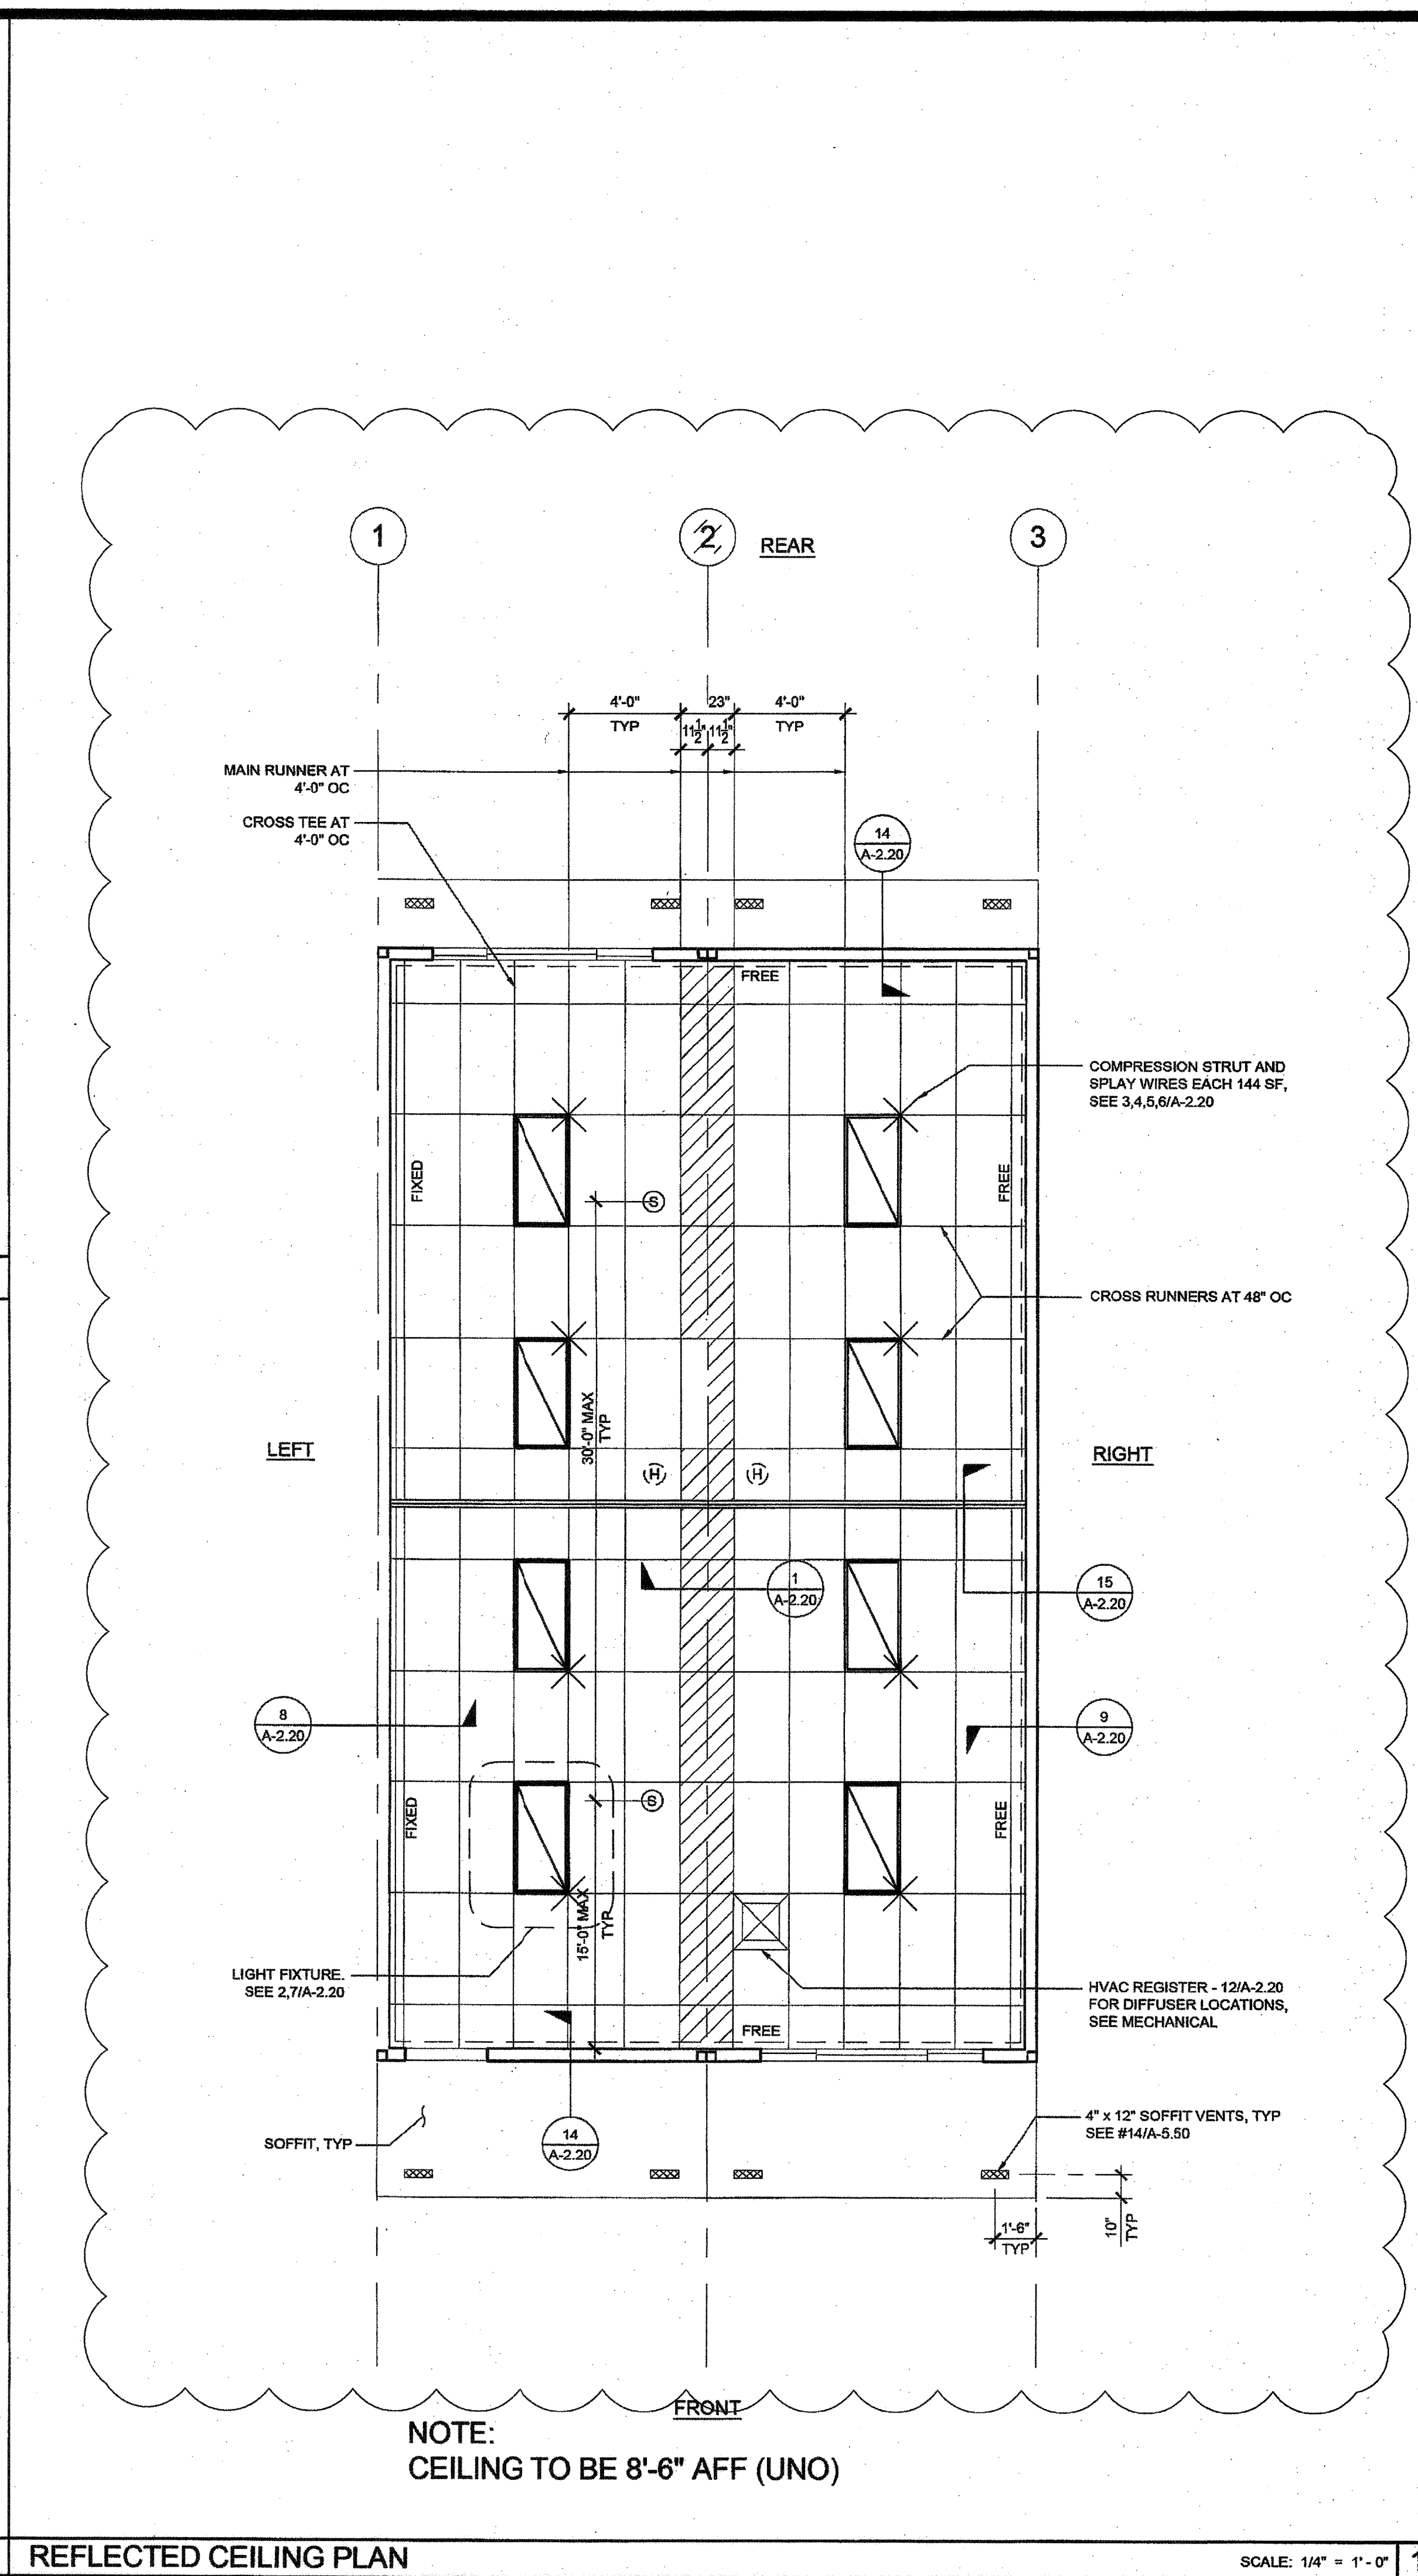

LEGEND

- T-BAR CEILING
- FIELD INSTALLED PANEL AT MODULE LINE
- 2 x 4' RECESSED LIGHT FIXTURE
- "OPTIONAL" 1' x 4' RECESSED LIGHT FIXTURE
- SPLAY WIRE
- CEILING MOUNTED SMOKE DETECTOR
- ATTIC MOUNTED HEAT DETECTOR
- SUPPLY AIR REGISTER
- CEILING EXHAUST FAN

NOTE:
FOR ALL REFLECTED CEILING NOTES SEE SHEET A-0.1.

PROVIDE DRAFT STOP AT AREAS EXCEEDING 3,000 sq/ft. DRAFT STOP TO BE INSTALLED AT MODLINE.

COORDINATE VAULTED CEILING OPTION W/ FIRE SPRINKLER DESIGN.

T-BAR SCHEDULE

ARMSTRONG PART NUMBERS ICC-ES ESR-1308
 MAIN RUNNER: 7301
 4" CROSS TEE: XL7341
 2" CROSS TEE: XL7328

STANDARD 7/8" WALL ANGLE WITH BERC-2 CLIP (ICC #ESR-1308)
 FOR DETAILS SEE 18, 19/A-2.20.
 2" WALL ANGLE: 7810 (OPTIONAL)

THESE DRAWINGS AND ALL MATERIAL CONTAINED HEREIN ARE THE PROPERTY OF SILVERCREEK INDUSTRIES, INC (SCI Inc) AND SHALL NOT BE REPRODUCED, COPIED OR OTHERWISE DISPOSED OF DIRECTLY OR INDIRECTLY AND SHALL NOT BE USED IN WHOLE OR IN PART TO ASSIST IN THE MAKING OF OR FOR THE PURPOSE OF FURNISHING ANY INFORMATION FOR THE MAKING OF DRAWINGS, PRINTS, APPARATUS OR PARTS THEREOF WITHOUT THE FULL KNOWLEDGE AND WRITTEN CONSENT OF SCI Inc. ALL PATENTABLE MATERIAL CONTAINED HEREIN AND ORIGINATING WITH SCI Inc SHALL BE THE PROPERTY OF SCI Inc

SILVER CREEK INDUSTRIES, INC.

"BUILDING FOR THE NEXT GENERATION"

SILVER CREEK

2830 BARRETT AVE PERRIS, CALIFORNIA 92571
 PHONE: 951-943-5393 FAX: 951-943-2211

PROJECT NAME:
24x40 STOCKPILE OFFICE BUILDING

SHEET TITLE:
REFLECTED CEILING PLAN
24' x 40' - VAULTED CEILING

ARCHITECT OF RECORD
SUBMISSION DATE

FILE # 15-6
 IDENTIFICATION STAMP
 DIV. OF THE STATE ARCHITECT
 OFFICE OF REGULATION SERVICES

03-118270
 AC FLS SS RA
 DATE NOV - 8 2017
 TRACKING #: 63221-290

PROJECT SPECIFIC STATE AGENCY APPROVAL

IDENTIFICATION STAMP
 DIV. OF THE STATE ARCHITECT

04 116284
 ACS FLS SS RA
 DATE MAY 18 2017

ORIGINAL PC STATE AGENCY APPROVAL

PRE-CHECK PC DOCUMENT
 A SIGNATURE AND DATE
 FOR CONTRIBUTION IS REQUIRED

IDENTIFICATION STAMP
 DIV. OF THE STATE ARCHITECT
 OFFICE OF REGULATION SERVICES

PC 04-114102
 AC FLS SS RA
 DATE AUG - 4 2015

REVISIONS

SILVER CREEK INDUSTRIES
24' x 40' PC - 2:12 PITCH

PROJECT NO:
DRAWN BY:
SCALE: AS NOTED
DATE: 01-30-15

P.C. SHEET NUMBER
A-2.11

REFER TO SHEET "A-2.11N" FOR PROJECT SPECIFIC