


NOT USED

NOT USED

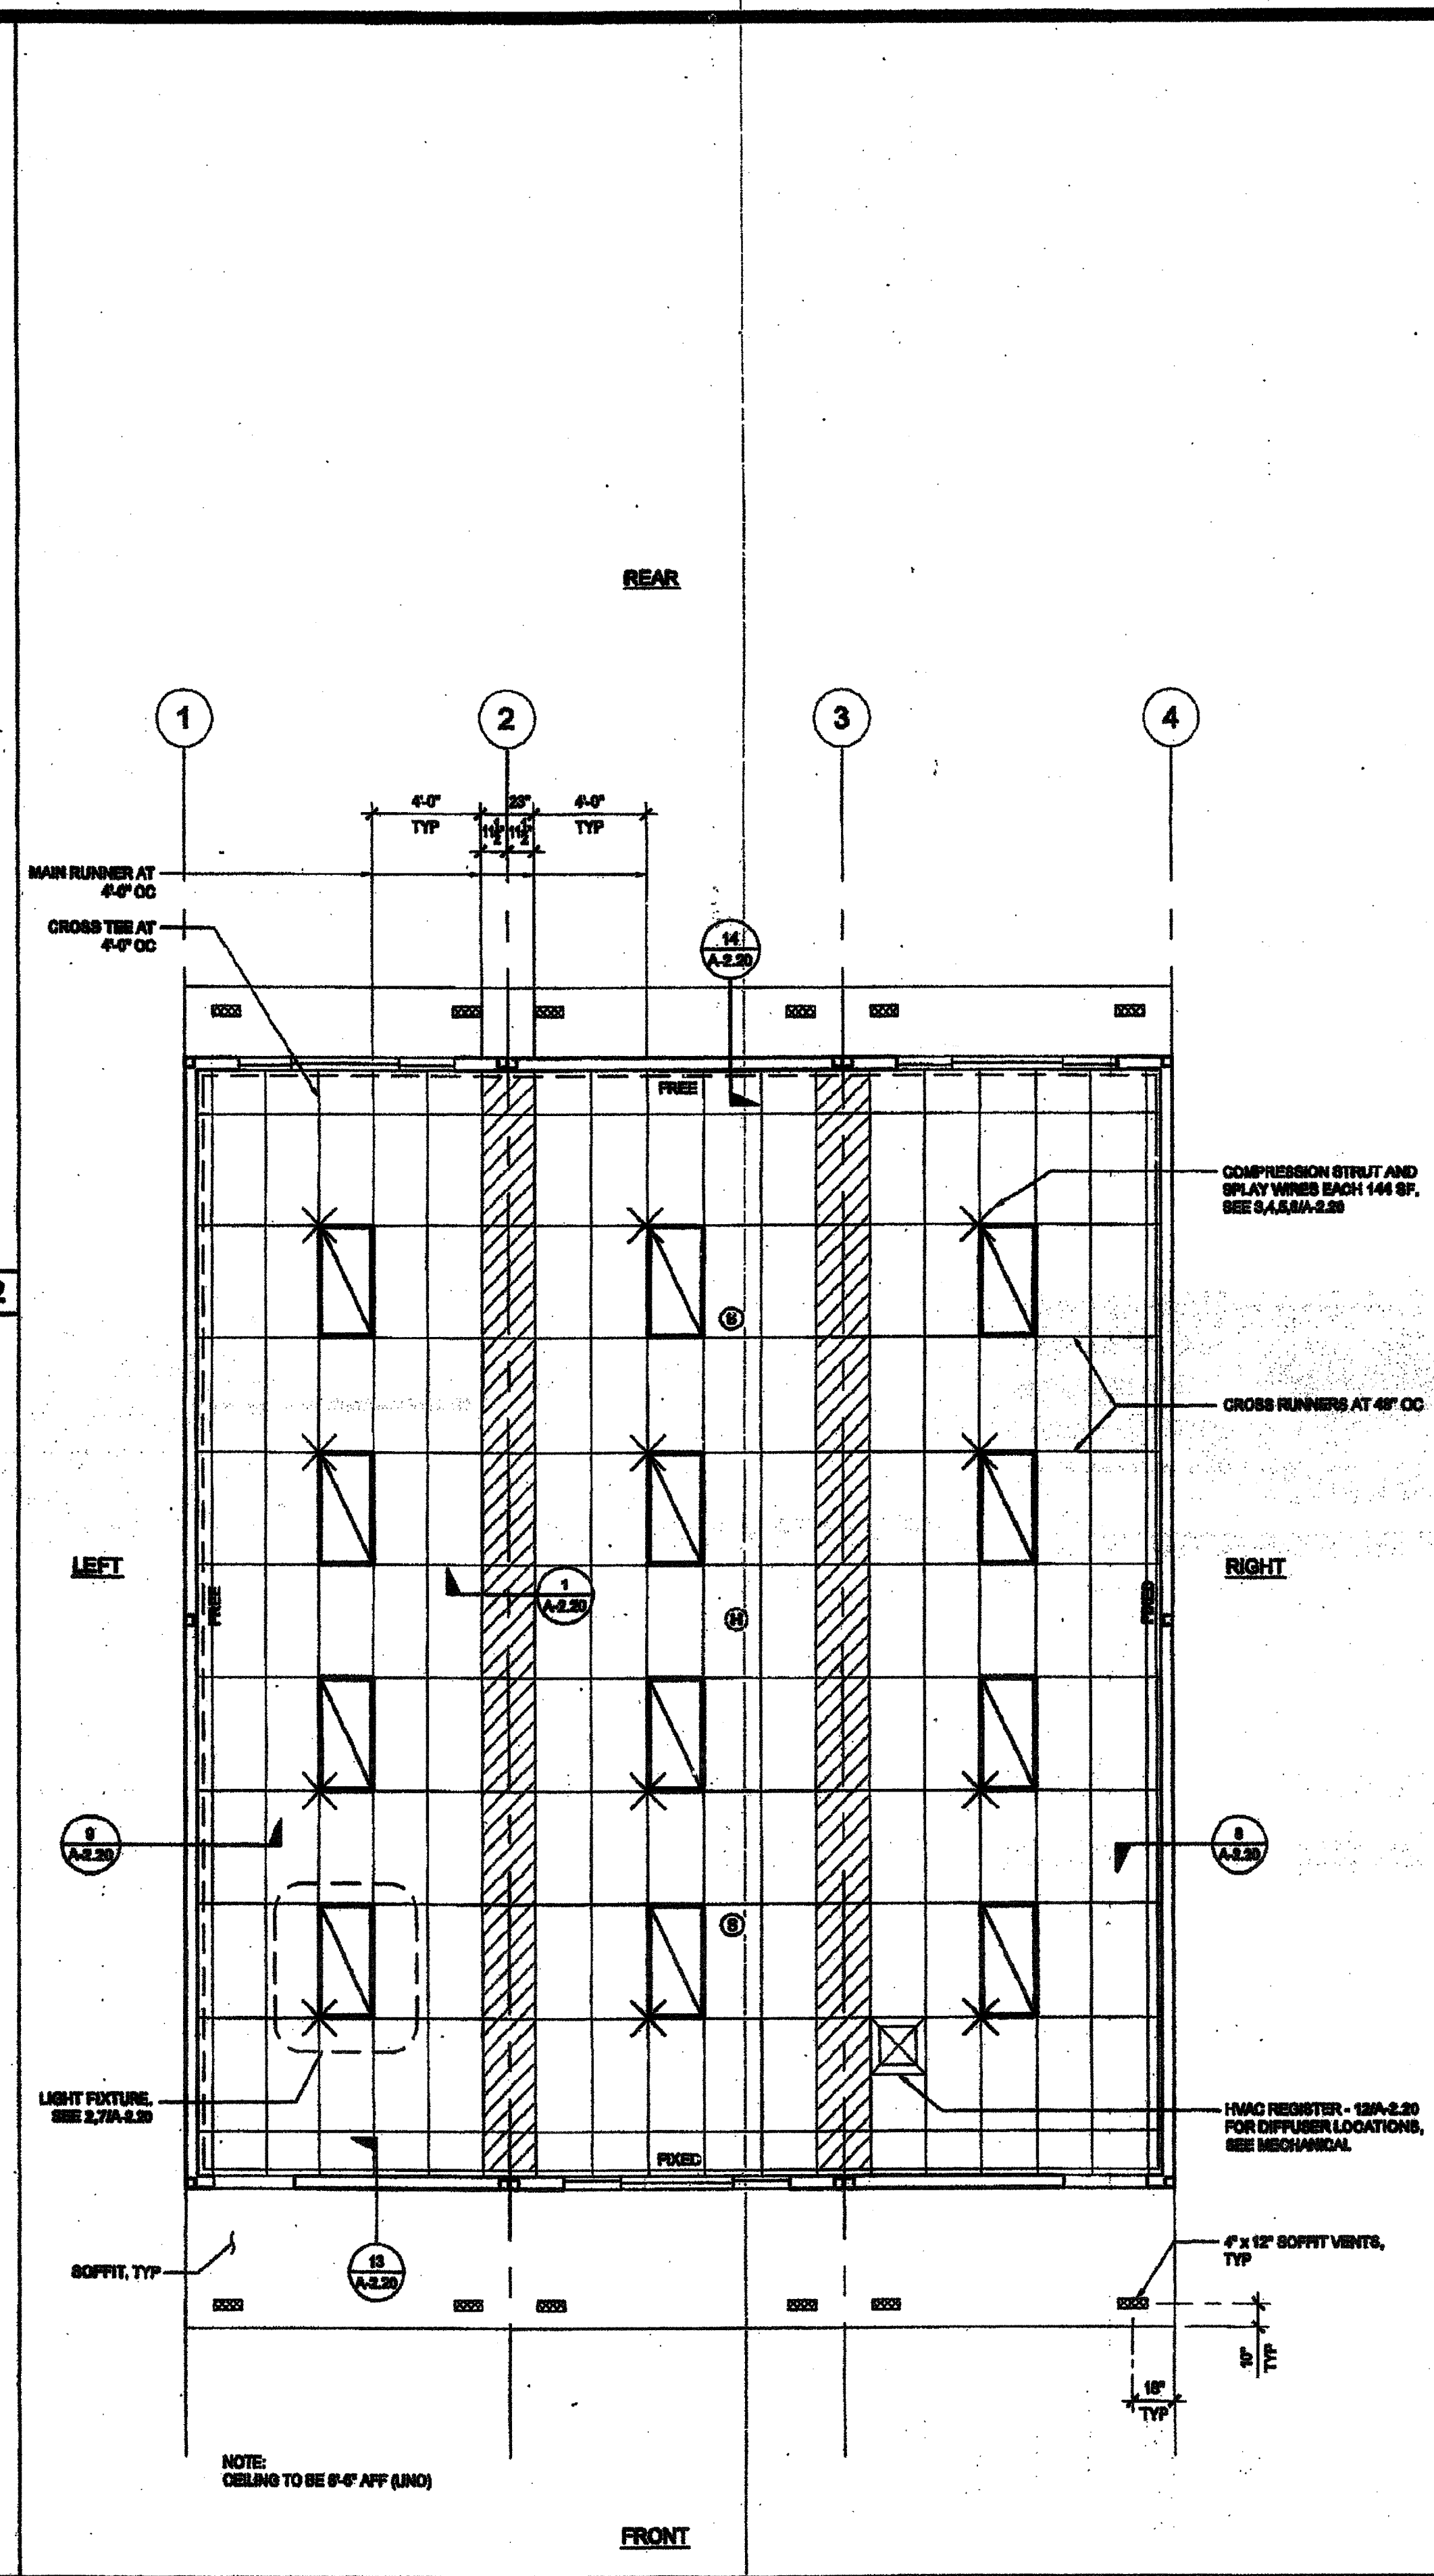

3 REFLECTED CEILING PLAN

LEGEND

- T-BAR CEILING
- FIELD INSTALLED PANEL AT MODULE LINE
- 2' x 4' RECESSED LIGHT FIXTURE
- "OPTIONAL" 1' x 4' RECESSED LIGHT FIXTURE
- SPRAY WIRE
- CEILING MOUNTED SMOKE DETECTOR
- ATTIC MOUNTED HEAT DETECTOR
- SUPPLY AIR REGISTER
- CEILING EXHAUST FAN

NOTE:
FOR ALL REFLECTED CEILING NOTES
SEE SHEET A-0.1

REVISIONS

NO.	DATE	DESCRIPTION
1		
2		
3		
4		
5		
6		
7		
8		
9		
10		

IDENTIFICATION STAMP
DIV. OF THE STATE ARCHITECT
OFFICE OF REGULATION SERVICES
APPD 116973
AC [Signature] FLS [Signature] SS [Signature] EY
DATE FEB 18 2016

NOTE:
SEE CCD.1.01 FOR ACTUAL
BUILDING LAY-OUT

T-BAR SCHEDULE

ARMSTRONG PART NUMBERS PA-041
MAIN RUNNER: 7301
4" CROSS TEE: XL741
2" CROSS TEE: XL728

STANDARD 78" WALL ANGLE WITH BERC-2 CLIP (00 #289-1200) 2"
WALL ANGLE: 7810 (OPTIONAL)

THESE DRAWINGS AND ALL MATERIAL CONTAINED HEREIN ARE THE PROPERTY OF SILVER CREEK INDUSTRIES, INC. (SCI INC) AND SHALL NOT BE REPRODUCED, COPIED OR OTHERWISE DISSEMINATED IN ANY MANNER WITHOUT THE WRITTEN CONSENT OF SCI INC. ALL INFORMATION CONTAINED HEREIN AND CONSIDERED TO BE THE PROPERTY OF SCI INC.

SILVER CREEK INDUSTRIES, INC.
"BUILDING FOR THE NEXT GENERATION"
SILVER CREEK
156 EAST MORGAN AVENUE, CALIFORNIA 92571
PHONE: 951-948-2288 FAX: 951-948-2211

PROJECT NAME:
CLASS LEASING CLASSROOM BLDG'S

SHEET TITLE:
REFLECTED CEILING PLAN 36' x 40'

STAVARE
REGISTERED ARCHITECT
12/22/2011

IDENTIFICATION STAMP
DIV. OF THE STATE ARCHITECT
OFFICE OF REGULATION SERVICES
04 113602
AC [Signature] FLS [Signature] SS [Signature] EY
DATE FEB 18 2016

PROJECT SPECIFIC STATE AGENCY APPROVAL
IDENTIFICATION STAMP
DIV. OF THE STATE ARCHITECT
OFFICE OF REGULATION SERVICES
04 113602
AC [Signature] FLS [Signature] SS [Signature] EY
DATE APR 14 2016

ORIGINAL PG STATE AGENCY APPROVAL
IDENTIFICATION STAMP
DIV. OF THE STATE ARCHITECT
OFFICE OF REGULATION SERVICES
PC 04-12072
AC [Signature] FLS [Signature] SS [Signature] EY
DATE FEB 18 2016

REVISIONS

SILVER CREEK INDUSTRIES 36' x 40' PC

PROJECT NO:
DRAWN BY:
SCALE: AS NOTED
DATE: 12-23-11

P.C. SHEET NUMBER
A-2.02

STK 126