

THESE DRAWINGS AND ALL MATERIAL CONTAINED HEREIN ARE THE PROPERTY OF SILVERCREEK INDUSTRIES, INC. (SOCI) AND SHALL NOT BE REPRODUCED, COPIED OR OTHERWISE DISPOSED OF DIRECTLY OR INDIRECTLY AND SHALL NOT BE USED IN WHOLE OR IN PART TO ASSIST IN THE MAKING OF OR FOR THE PURPOSE OF FURNISHING ANY INFORMATION FOR THE MAKING OF DRAWINGS, PRINTS, APPARATUS OR PARTS THEREOF WITHOUT THE FULL KNOWLEDGE AND WRITTEN CONSENT OF SOCI INC. ALL PATENTABLE MATERIAL CONTAINED HEREIN AND ORIGINATING WITH SOCI INC SHALL BE THE PROPERTY OF SOCI INC.


SILVER CREEK INDUSTRIES, INC.




195 EAST MORGAN FERRIS, CALIFORNIA 92571
PHONE: 951-943-9393 FAX: 951-943-2211

PROJECT NAME:
CLASS LEASING CLASSROOMS BLDG'S

SHEET TITLE:
PLUMBING DETAILS AND SCHEDULE

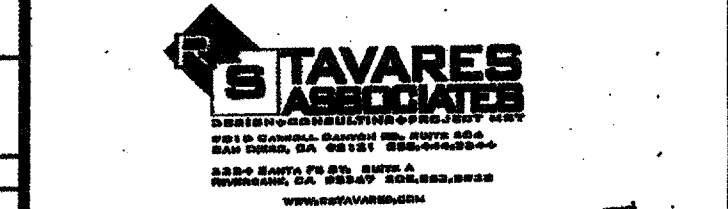

REVISED FEB 26 2015
SEP 18 2012

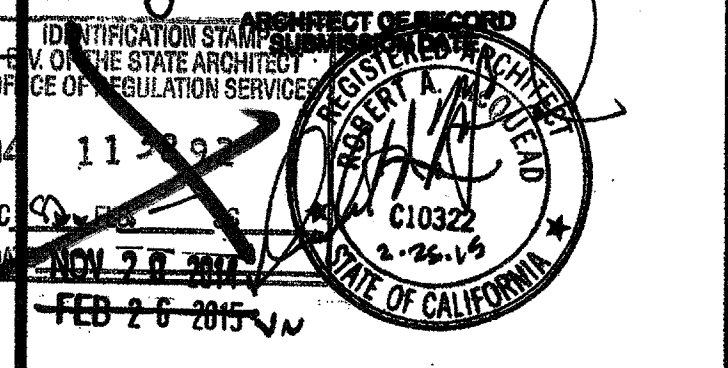

PROJECT SPECIFIC STATE AGENCY APPROVAL
DATE: AUG 28 2014

ORIGINAL PG STATE AGENCY APPROVAL
DATE: JAN 8 2015
REVISED

PC REVISION 12/13/2012

SILVER CREEK INDUSTRIES
24" x 40" PC

PROJECT NO:
DRAWN BY:
SCALE: AS NOTED
DATE: 12-13-12
F.O. SHEET NUMBER
P-1.01 STKP 126

PLUMBING FIXTURE SCHEDULE						
SYMBOL	FIXTURE	COLD WATER	HOT WATER	WASTE	VENT	FIXTURE DESCRIPTION (AS CALLED OUT OR APPROVED EQUAL)
WC 1	[A] WATER CLOSET TANK TYPE (ACCESSIBLE)	1/2"	-	3"	2"	STD: PROFLO ADA PFM30 ALT: AMERICAN STANDARD ADA 2758, 128 1.28 GPF, 17" HIGH, VITREOUS CHINA ELONGATED RIM, TANK TYPE: 12" ROUGH-IN; OLSONITE 100C SOLID OPEN WHITE ELONGATED PLASTIC SEAT
WC 2	[E] WATER CLOSET TANK TYPE (ACCESSIBLE)	1/2"	-	3"	2"	STD: PROFLO STANDARD PFM300 ALT: AMERICAN STANDARD 2882, 128, 16" HIGH, VITREOUS CHINA ELONGATED RIM, TANK TYPE: 12" ROUGH-IN; OLSONITE 100C SOLID OPEN WHITE ELONGATED PLASTIC SEAT
WC 3	[K] WATER CLOSET TANK TYPE (ACCESSIBLE & NON-ACCESSIBLE)	1/2"	-	3"	2"	STD: PROFLO PFM708S ALT: AMERICAN STANDARD 2316, 816 BABY DEVORD 16" HIGH, 16" ROUGH-IN, VITREOUS CHINA ELONGATED RIM, TANK TYPE: OLSONITE 100C SOLID OPEN WHITE ELONGATED PLASTIC SEAT
LAV 1	LAVATORY (ACCESSIBLE)	1/2"	-	2"	1 1/2"	STD: AMERICAN STANDARD 086, 612 LUCERNE ALT: CRANE 1412-20 "HARWICH" 20K16 VITREOUS CHINA; JAY R SMITH #722 CONCEALED HANGERS; VALLEY #1858S SINGLE HANDLE FAUCET (AMERICAN STANDARD #14101 TO BE USED @ KINDER & ELEMENTARY APPLICATIONS ONLY)
FD 1	FLOOR DRAIN	-	-	2"	1 1/2"	JAY R SMITH #2005YA-02-P004-8B, FLOOR DRAIN TAPPED FOR PRIMER, 8" NICKEL BRONZE STRAINER
TP 1	TRAP PRIMER	1/2"	-	-	-	PR-500 WITH 8"x12" LOCKABLE BOX, 1/2" BALL SHUT-OFF VALVE, AND PVP D14-U FRESH WATER DISTRIBUTION SYSTEM
GB 1	GRAB BAR	-	-	-	-	McKINNEY 9704-1-1/2 OC STAINLESS STEEL GRAB BAR - BATIN FINISH; 36" LONG ON BACK AND 42" ON SIDE
MR 1	MIRROR	-	-	-	-	SERIES 630 RETURNED MIRRORS STAINLESS STEEL - 18GA 17"x24" - "J" SHEET METAL MANUFACTURED OR APPROVED EQUAL
CS 1	CLASSROOM SINK	1/2"	1/2"	2"	1 1/2"	JUST CRA-1725-A-GR 17"x25" w/ 4 1/2" BOWL DEPTH, WITH CHICAGO FAUCET #850 AND BUBBLER JSB-10
WH 1	WATER HEATER	3/4"	3/4"	-	-	A.O. SMITH #DEL-8 (8 GALLON) A.O. SMITH #DEL-10 (10 GALLON)
WH 2	INSTANT WATER HEATER	1/2"	1/2"	-	-	SEMAX #SPS012, 120V, 3.0KW, 25A
DF 1	DRINKING FOUNTAIN	1/2"	-	2"	1 1/2"	HALSEY-TAYLOR / BI-LEVEL HACRPSBL-Q / COOLING TYPE

* 34"-38" (REQUIRED) LOWER HAND RAIL MAY BE ADDED.

THE DIVISION OF THE STATE ARCHITECT, OFFICE OF REGULATION SERVICES RECOMMENDS THE FOLLOWING DIMENSIONS AS ADEQUATELY SERVING THE NEEDS OF CHILDREN IN PROJECTS UNDER THEIR JURISDICTION. THESE RECOMMENDATIONS ARE BASED ON TABLE 11B-604.9 SUGGESTED DIMENSIONS FOR WATER CLOSETS SERVING CHILDREN AGES 3 TO 12.

ACCESSIBILITY DIMENSIONS	11B-604.9 SUGGESTED DIMS		
	ADULT	AGES 9 THROUGH 12	AGES 5 THROUGH 8
TOILET CENTERING FROM WALL	17" - 18"	15" - 18"	12" - 15"
TOILET SEAT HEIGHT (DIM TO TOP OF SEAT)	17" - 19"	15" - 17"	12" - 15"
GRAB BAR HEIGHT (TO TOP)	33" - 36"	25" - 27"	20" - 25"
TOILET PAPER IN FRONT OF TOILET	7" - 9"	7" - 9"	7" - 9"
NAPKIN DISPOSAL IN FRONT OF TOILET	12" MAX.	12" MAX.	N/A
MIRROR HEIGHT (TO BOTTOM OF GLASS)	40" MAX.	40" MAX.	36" MAX.
DISPENSER HEIGHT	19" MIN.	17" - 19"	14" - 17"
LAVATORY/SINK TOP HEIGHT	34" MAX.	31" MAX.	31" MAX.
LAVATORY/SINK KNEE CLEARANCE	27" MIN.	24" MIN.	24" MIN.
URINAL LIP HEIGHT	17" MAX.	17" MAX.	13" MIN.
URINAL FLUSH HANDLE HEIGHT	44" MAX.	44" MAX.	32" MAX.
DRINKING FOUNTAIN BUBBLER HEIGHT	36" MAX.	30" MAX.	30" MAX.
DRINKING FOUNTAIN KNEE CLEARANCE	27" MIN.	27" MIN.	22" MIN.
RAMP/STAIR HANDRAIL HEIGHT (TO TOP)	34" - 38"	34" - 38"	34" - 38"

STANDARD DIMENSIONS	ALT. HEIGHT (DIMS)		
	ADULT	AGES 9 THROUGH 12	AGES 5 THROUGH 8
TOILET CENTERING FROM WALL/PARTITION	15" MIN	15" MIN	15" MIN
TOILET SEAT HEIGHT (DIM TO TOP OF SEAT)	15"	15"	15"
TOILET CLEARANCE/FRONT	24"	24"	24"
URINAL LIP HEIGHT	24"	24"	18"
URINAL CENTER FROM WALL/PARTITION	12"	12"	12"

PLUMBING ACCESSORIES (REF. ONLY - MODELS FURNISHED AND INSTALLED BY DISTRICT U.A.G.)

A) SOAP DISPENSER: LIQUID SOAP DISPENSER 4" MAX. PROJECTION
B) PAPER TOWEL DISPENSER/TRASH BIN COMBO: SURFACE MOUNTED 4" MAX. PROJECTION-CANNOT ENVOUCH INTO 28" CLEAR SPACE OF FIXTURE
C) TOILET PAPER HOLDER: SINGLE ROLL SEMI-RECESSED OR 3" MAX PROJECTION
D) TOILET SEAT DISPENSER: SURFACE MOUNTED

