
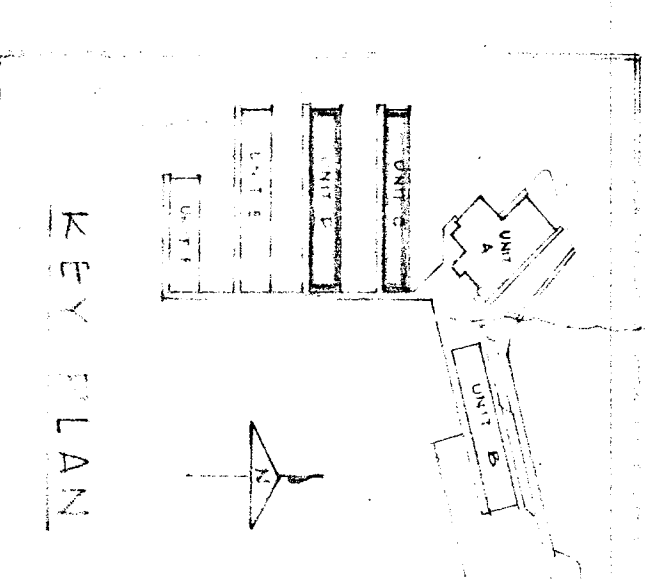


PLUMBING FLOOR PLANS

SCALE 1/8" = 1'-0"

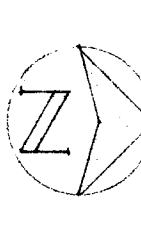

NOTES
 1. FOR PLUMBING SYMBOLS, LEGEND & FIXTURE SCHEDULE, SEE SHEET P-1.
 2. FOR CONSTRUCTION OF ALL LINES, OBTAIN THE BUILDING'S SET FROM PLANS SHEET P-1.

CHESTER D. WALK
 CONSULTING MECHANICAL ENGINEER
 800 S. E. 183RD ST. LOS ANGELES
 CALIF. LICENSE NO. 1000

STATE DIVISION OF ARCHITECTURE
 1105
 1105
 1105

ARCHITECTS
 WRIGHT METCALLE & PATTINSON
 222 E. STREET
 BAKERSFIELD, CALIF. 93301

WRIGHT METCALLE & PATTINSON
 222 E. STREET
 BAKERSFIELD, CALIF. 93301

BAKERSFIELD CITY SCHOOL DISTRICT
 BOARD OF EDUCATION
 APPROVED: _____
 DATE: _____

BAKERSFIELD CITY SCHOOL DISTRICT
 BOARD OF EDUCATION
 APPROVED: _____
 DATE: _____

PLUMBING FLOOR PLANS - UNIT'S C & D
 JOHN C. FREMONT SCHOOL
 THE SCHOOL DISTRICT
 1545 STREET, BAKERSFIELD, CALIFORNIA

SHEET NO. 209
 209
 209