

THIS PLAN AND SPECIFICATIONS ARE PREPARED BY THE ARCHITECT AND ARE TO BE USED ONLY FOR THE PROJECT AND SITE SPECIFICALLY IDENTIFIED HEREON. ANY REUSE OF THIS PLAN OR SPECIFICATIONS FOR ANY OTHER PROJECT WITHOUT THE WRITTEN CONSENT OF THE ARCHITECT IS STRICTLY PROHIBITED. THE ARCHITECT SHALL NOT BE RESPONSIBLE FOR ANY DAMAGE TO PERSONS OR PROPERTY CAUSED BY THE USE OF THIS PLAN OR SPECIFICATIONS.

APPROVED  
 11/11/06  
 11/11/06  
 11/11/06

DATE PRINTS ISSUED FOR: MARK DATE REVISIONS  
 11/11/06  
 11/11/06  
 11/11/06


DATE 11/11/06  
 PRINTS ISSUED FOR: MARK DATE  
 REVISIONS  
 DATE 4/19/09  
 JOB NO. 77-91-1  
 CHECKED BY E.H.W.  
 DRAWN BY S.G.S.  
 DATE 4/19/09  
 JOB NO. 77-91-1  
 CHECKED BY E.H.W.  
 DRAWN BY S.G.S.

ROBERT M. BOY C-113  
 WILLIAM M. DANIEL C-115  
 CHARLES W. BROWN C-116  
 JOHN W. BROWN C-117


PUBG. PLR PLANS (UNITS A, B-C)  
 ADDITIONS & ALTERATIONS, HORACE MANN SCHOOL  
 BAKERSFIELD CITY SCHOOL DISTRICT  
 BAKERSFIELD, CALIFORNIA

EDDY · PAYNTER · RENFRO & ASSOCIATES  
 A.I.A. ARCHITECTS - 5405 STOCKDALE HWY. BAKERSFIELD, CALIFORNIA 93309 - (805) 832-1105

PLUMBING FLOOR PLAN - KINDERGARTEN UNIT 'B' 1/4

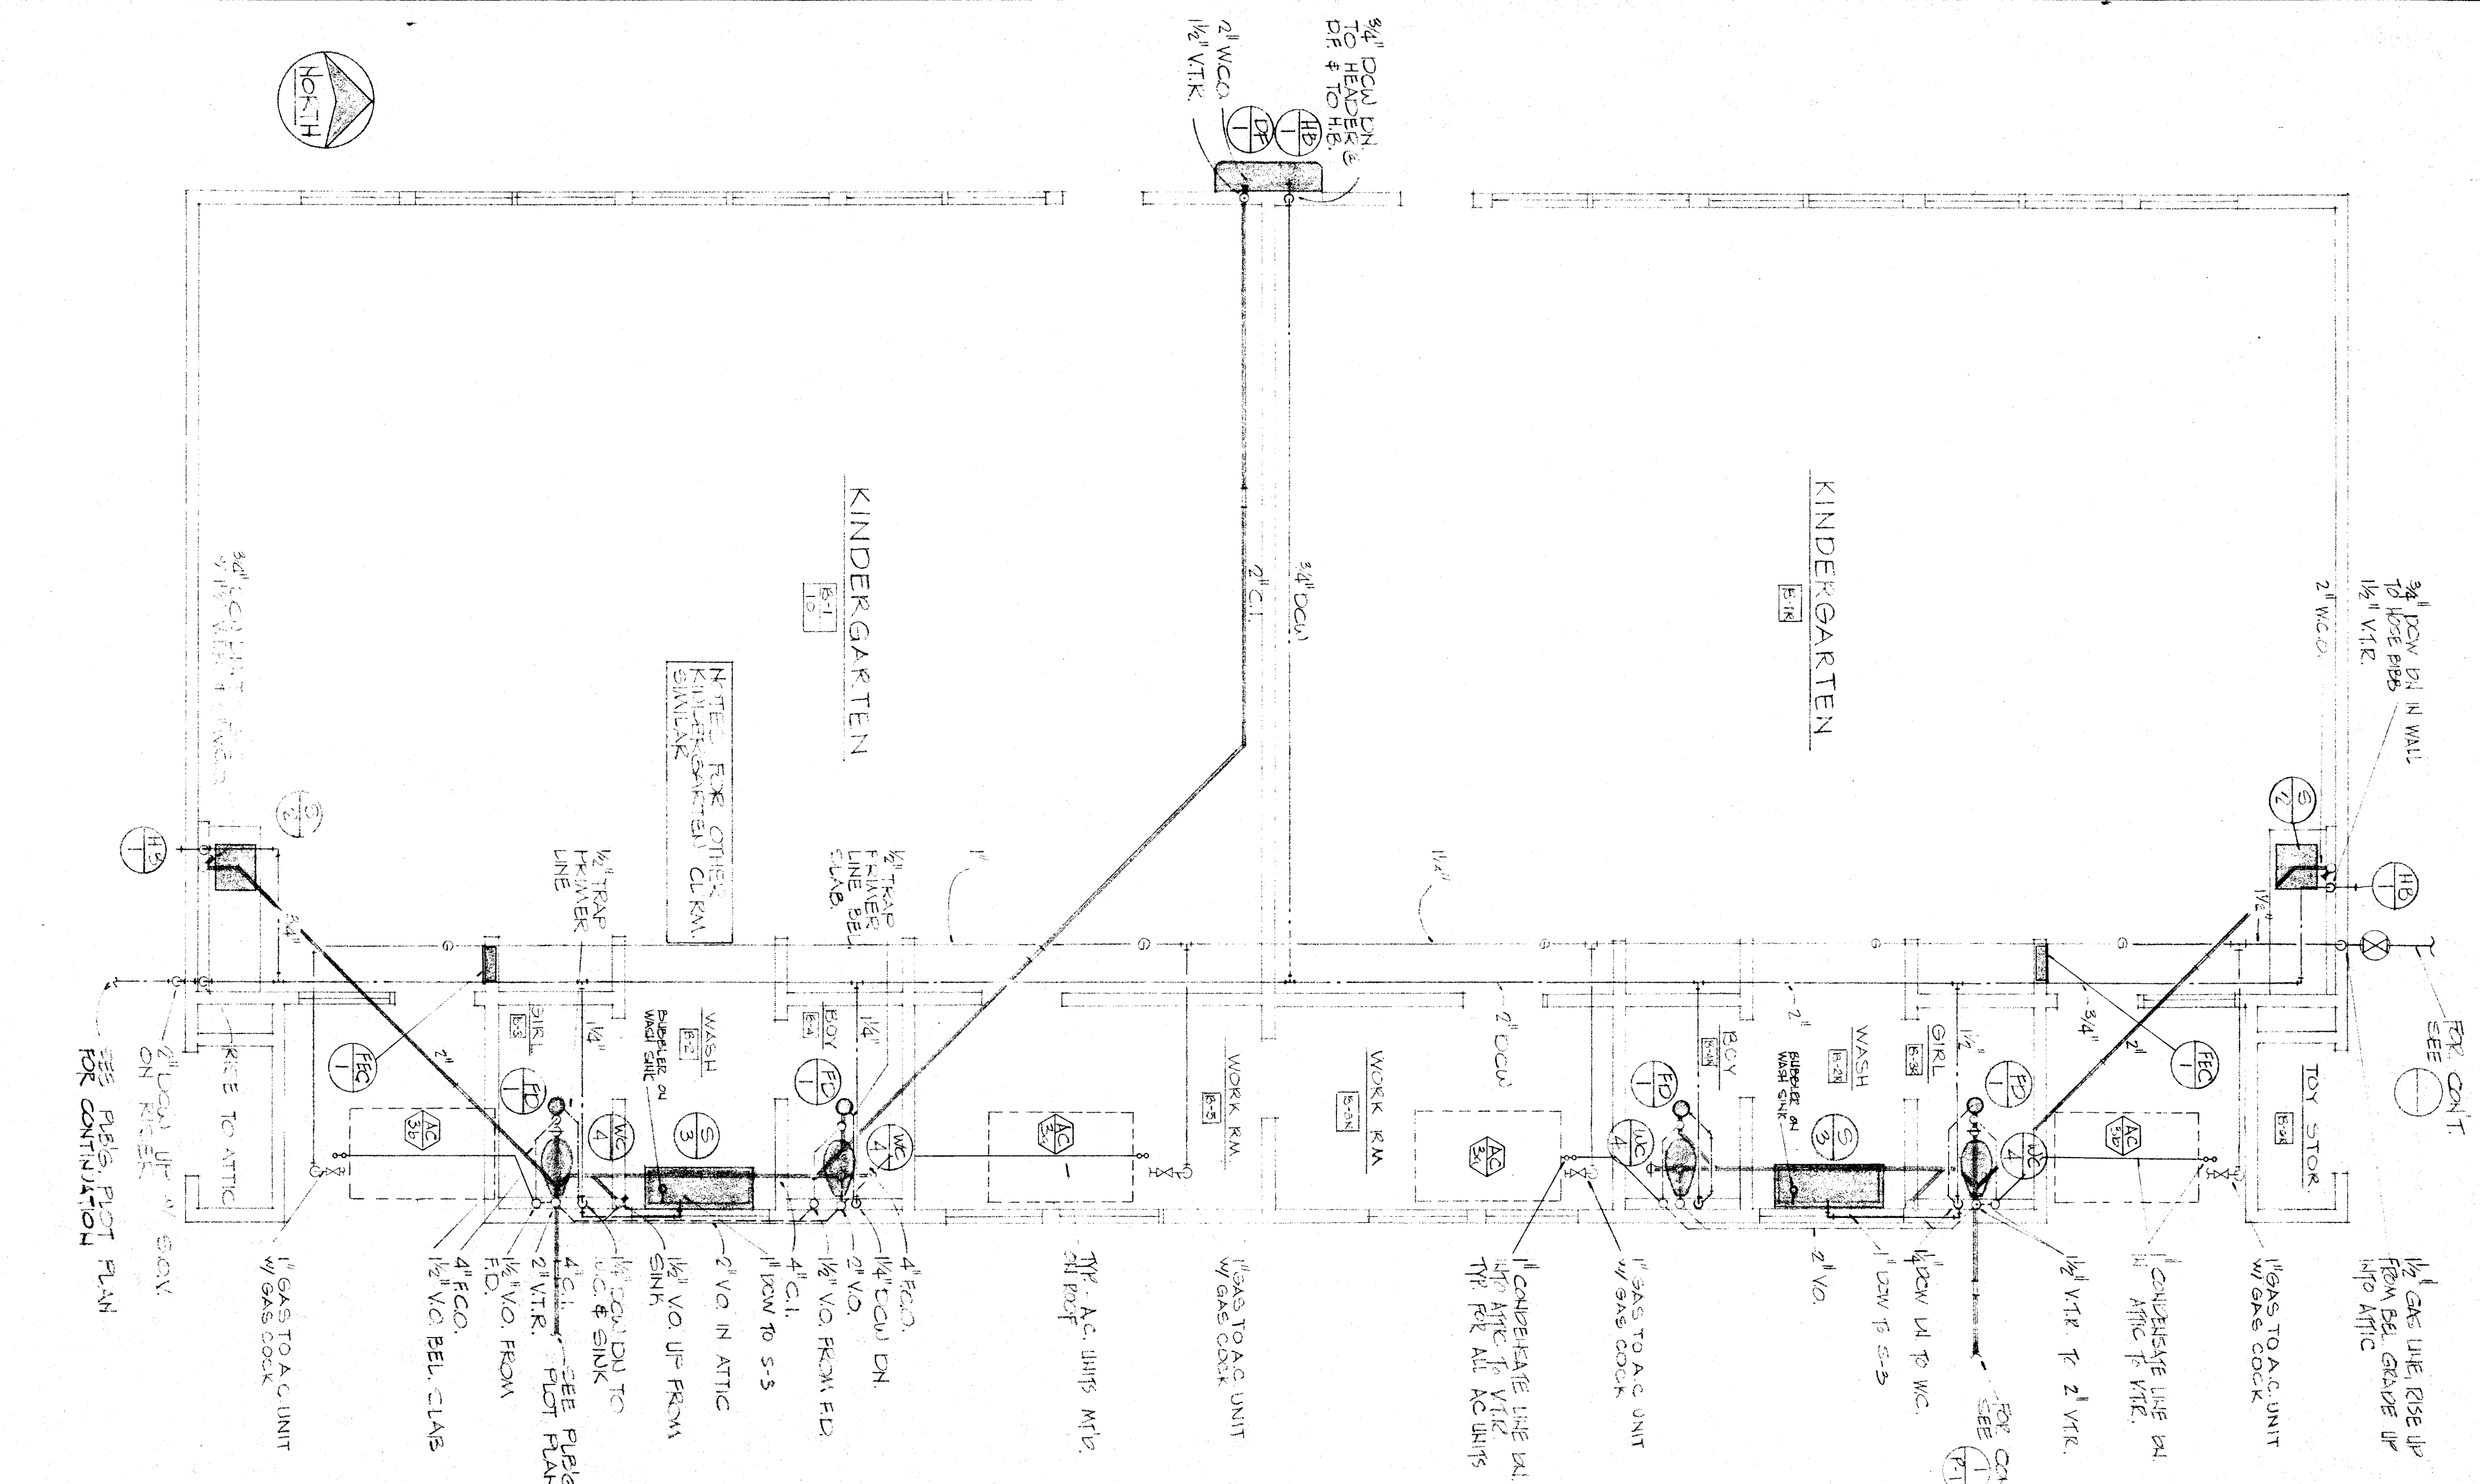

PLUMBING FLOOR PLAN - TOILET RM. 1/4

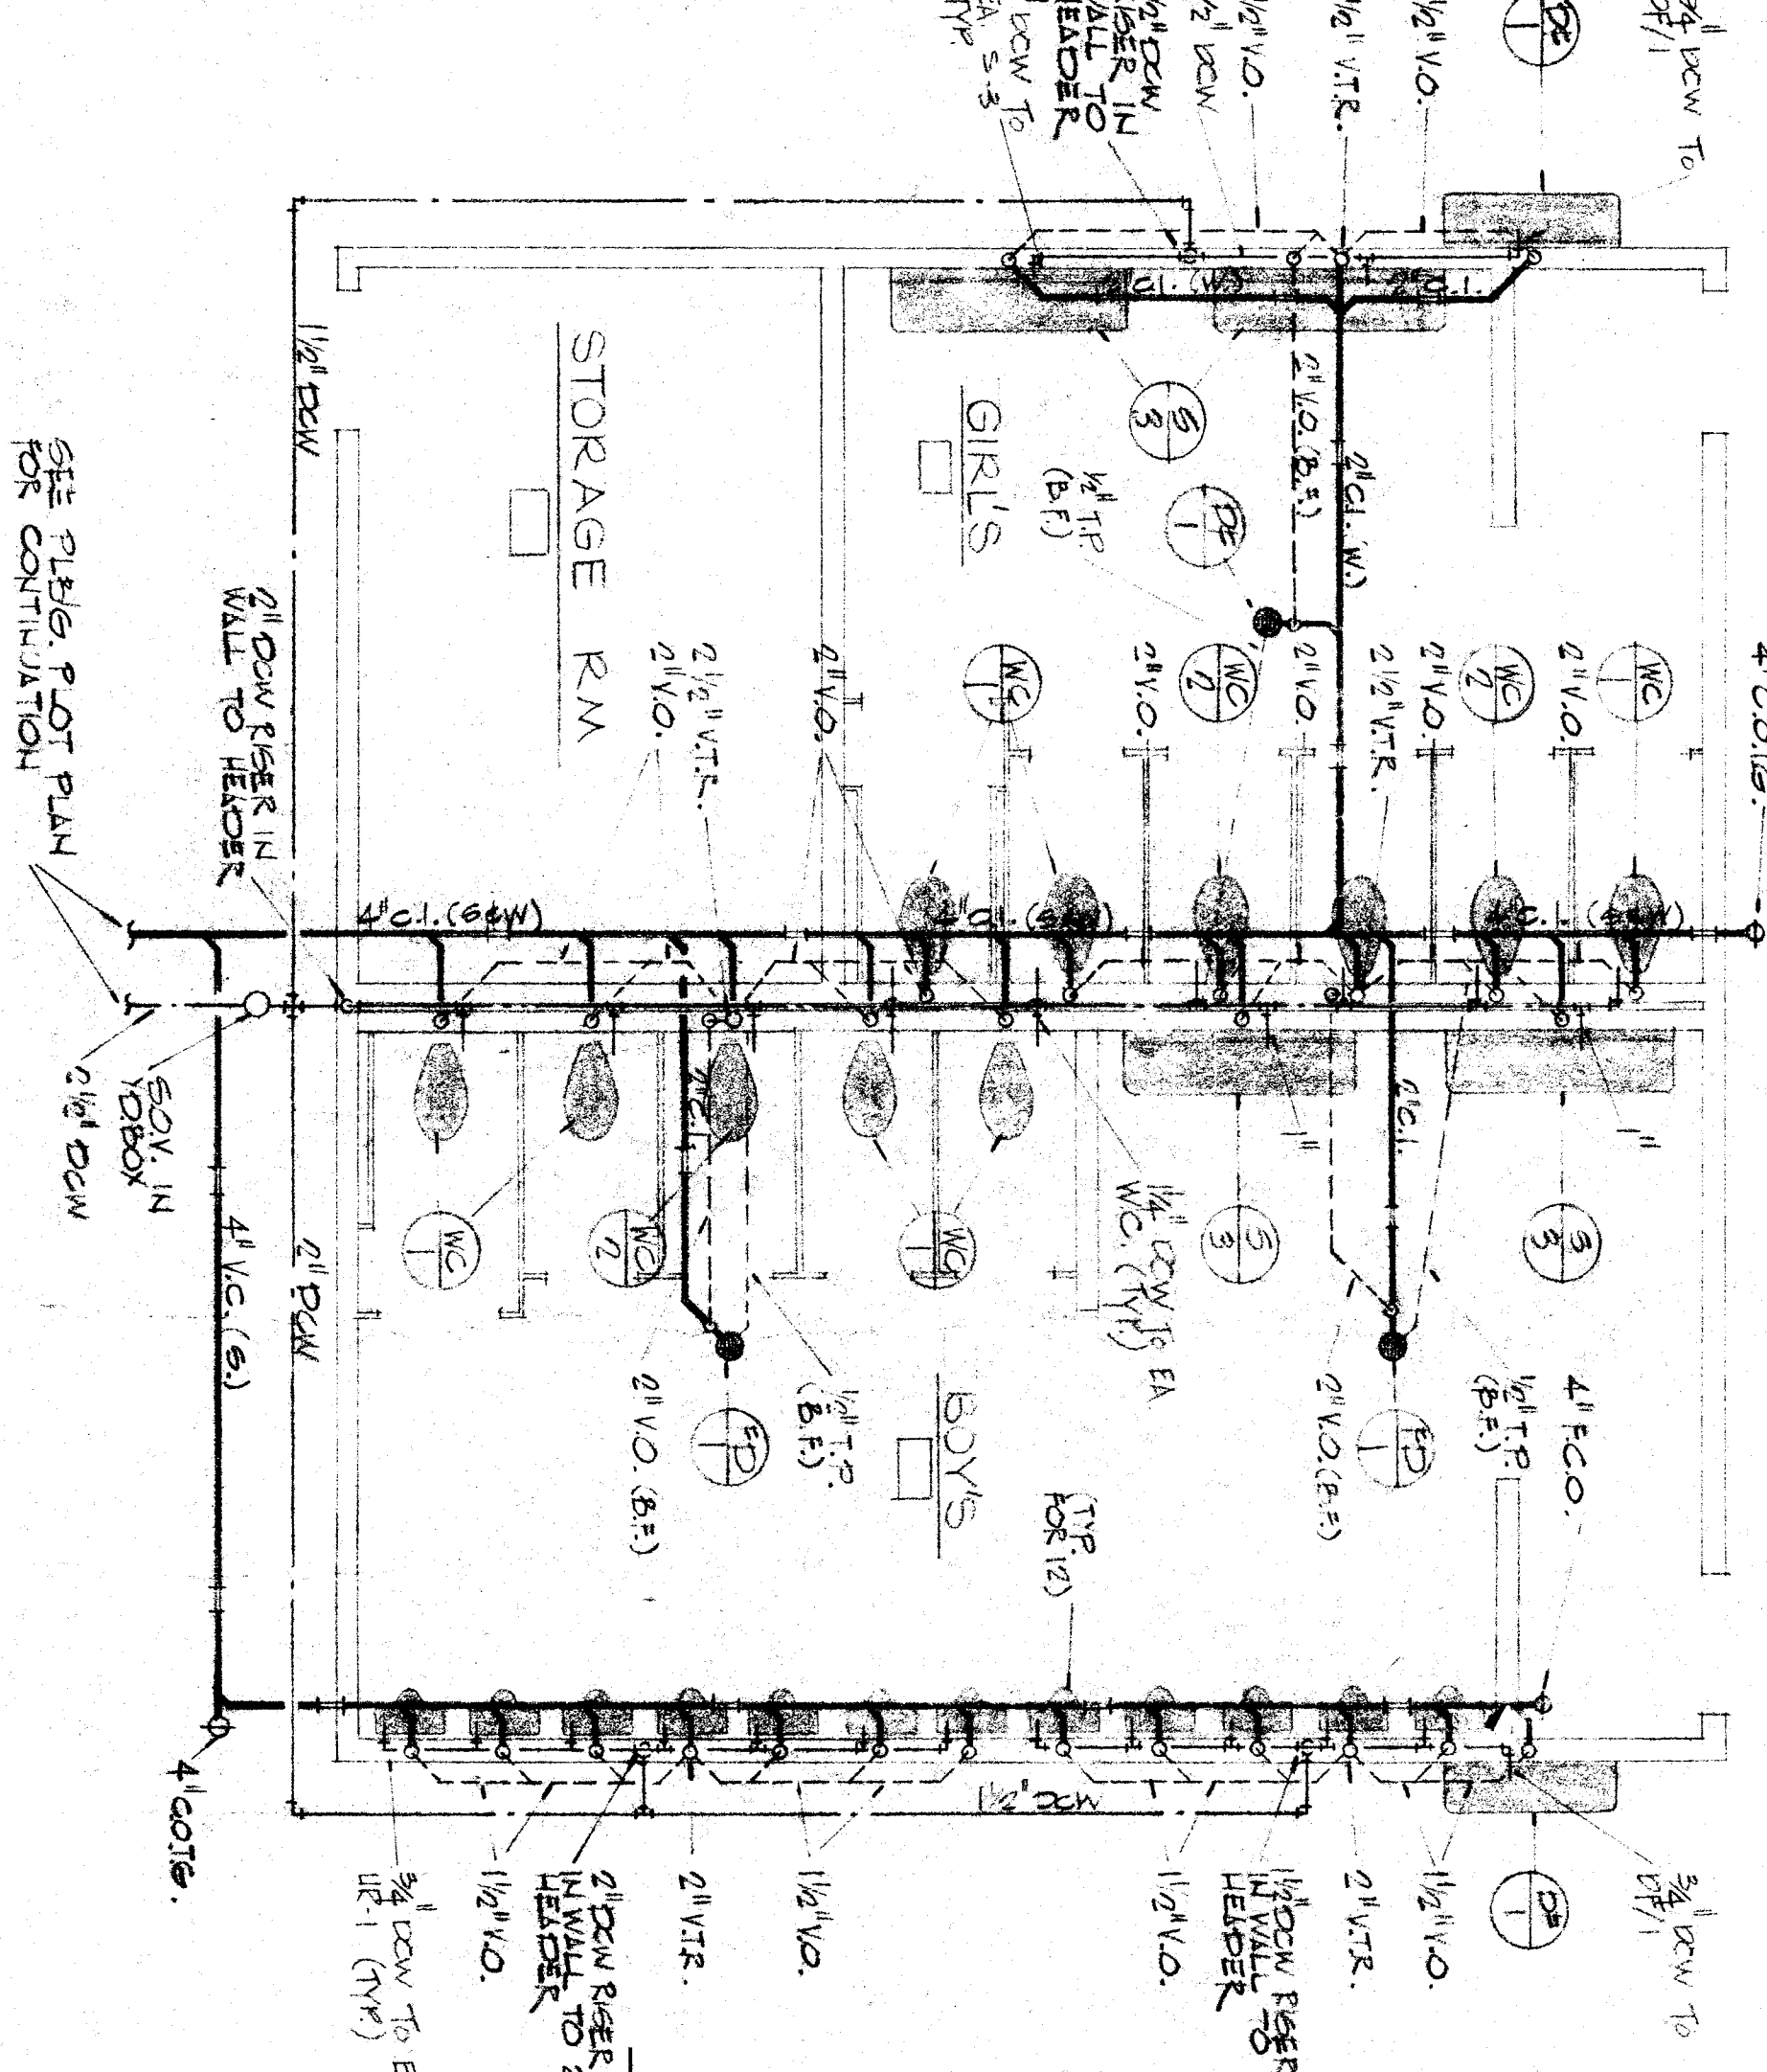

PLUMBING FLOOR PLAN - ADMINISTRATION BLDG. (NEW) UNIT 'A' 1/4

