


SHEET INDEX

- A1 PLOT AND GRADING PLAN
- A2 FLOOR PLAN OF UNITS A & B
- A3 EXTERIOR ELEVATIONS
- A4 TYPICAL CLASSROOM PLAN ELEVATIONS & DETAILS
- A5 TYPICAL DETAILS
- A6 KITCHEN PLAN & DETAILS
- A7 KITCHEN INT. ELEVATIONS
- A8 ROPE PLAN & DETAILS
- A9 DOOR & WINDOW SCHEDULES
- A10 DOOR & WINDOW DETAILS
- A11 ROOM FINISH SCHEDULE & MISC. DETAILS
- A12 TYPICAL DETAILS
- A3 EDUCATION PLAN UNITS A & B
- A4 ROPE PLAN UNITS A & B
- A5 SECTIONS & DETAILS
- A6 MISC. DETAILS
- A7 KITCHEN CANS. DETAILS
- A8 PUMPING PLAN UNITS A & B
- A9 DIAGRAMS & DETAILS
- A10 KITCHEN PLUMBING PLAN & DIAGRAMS
- A11 ELECTRICAL PLAN UNITS A & B
- A12 KITCHEN ELEC. PLAN & SWITCHBOARD DIAGRAM

NILES STREET
 PLOT & GRADE PLAN SCALE 1/8" = 1'-0"

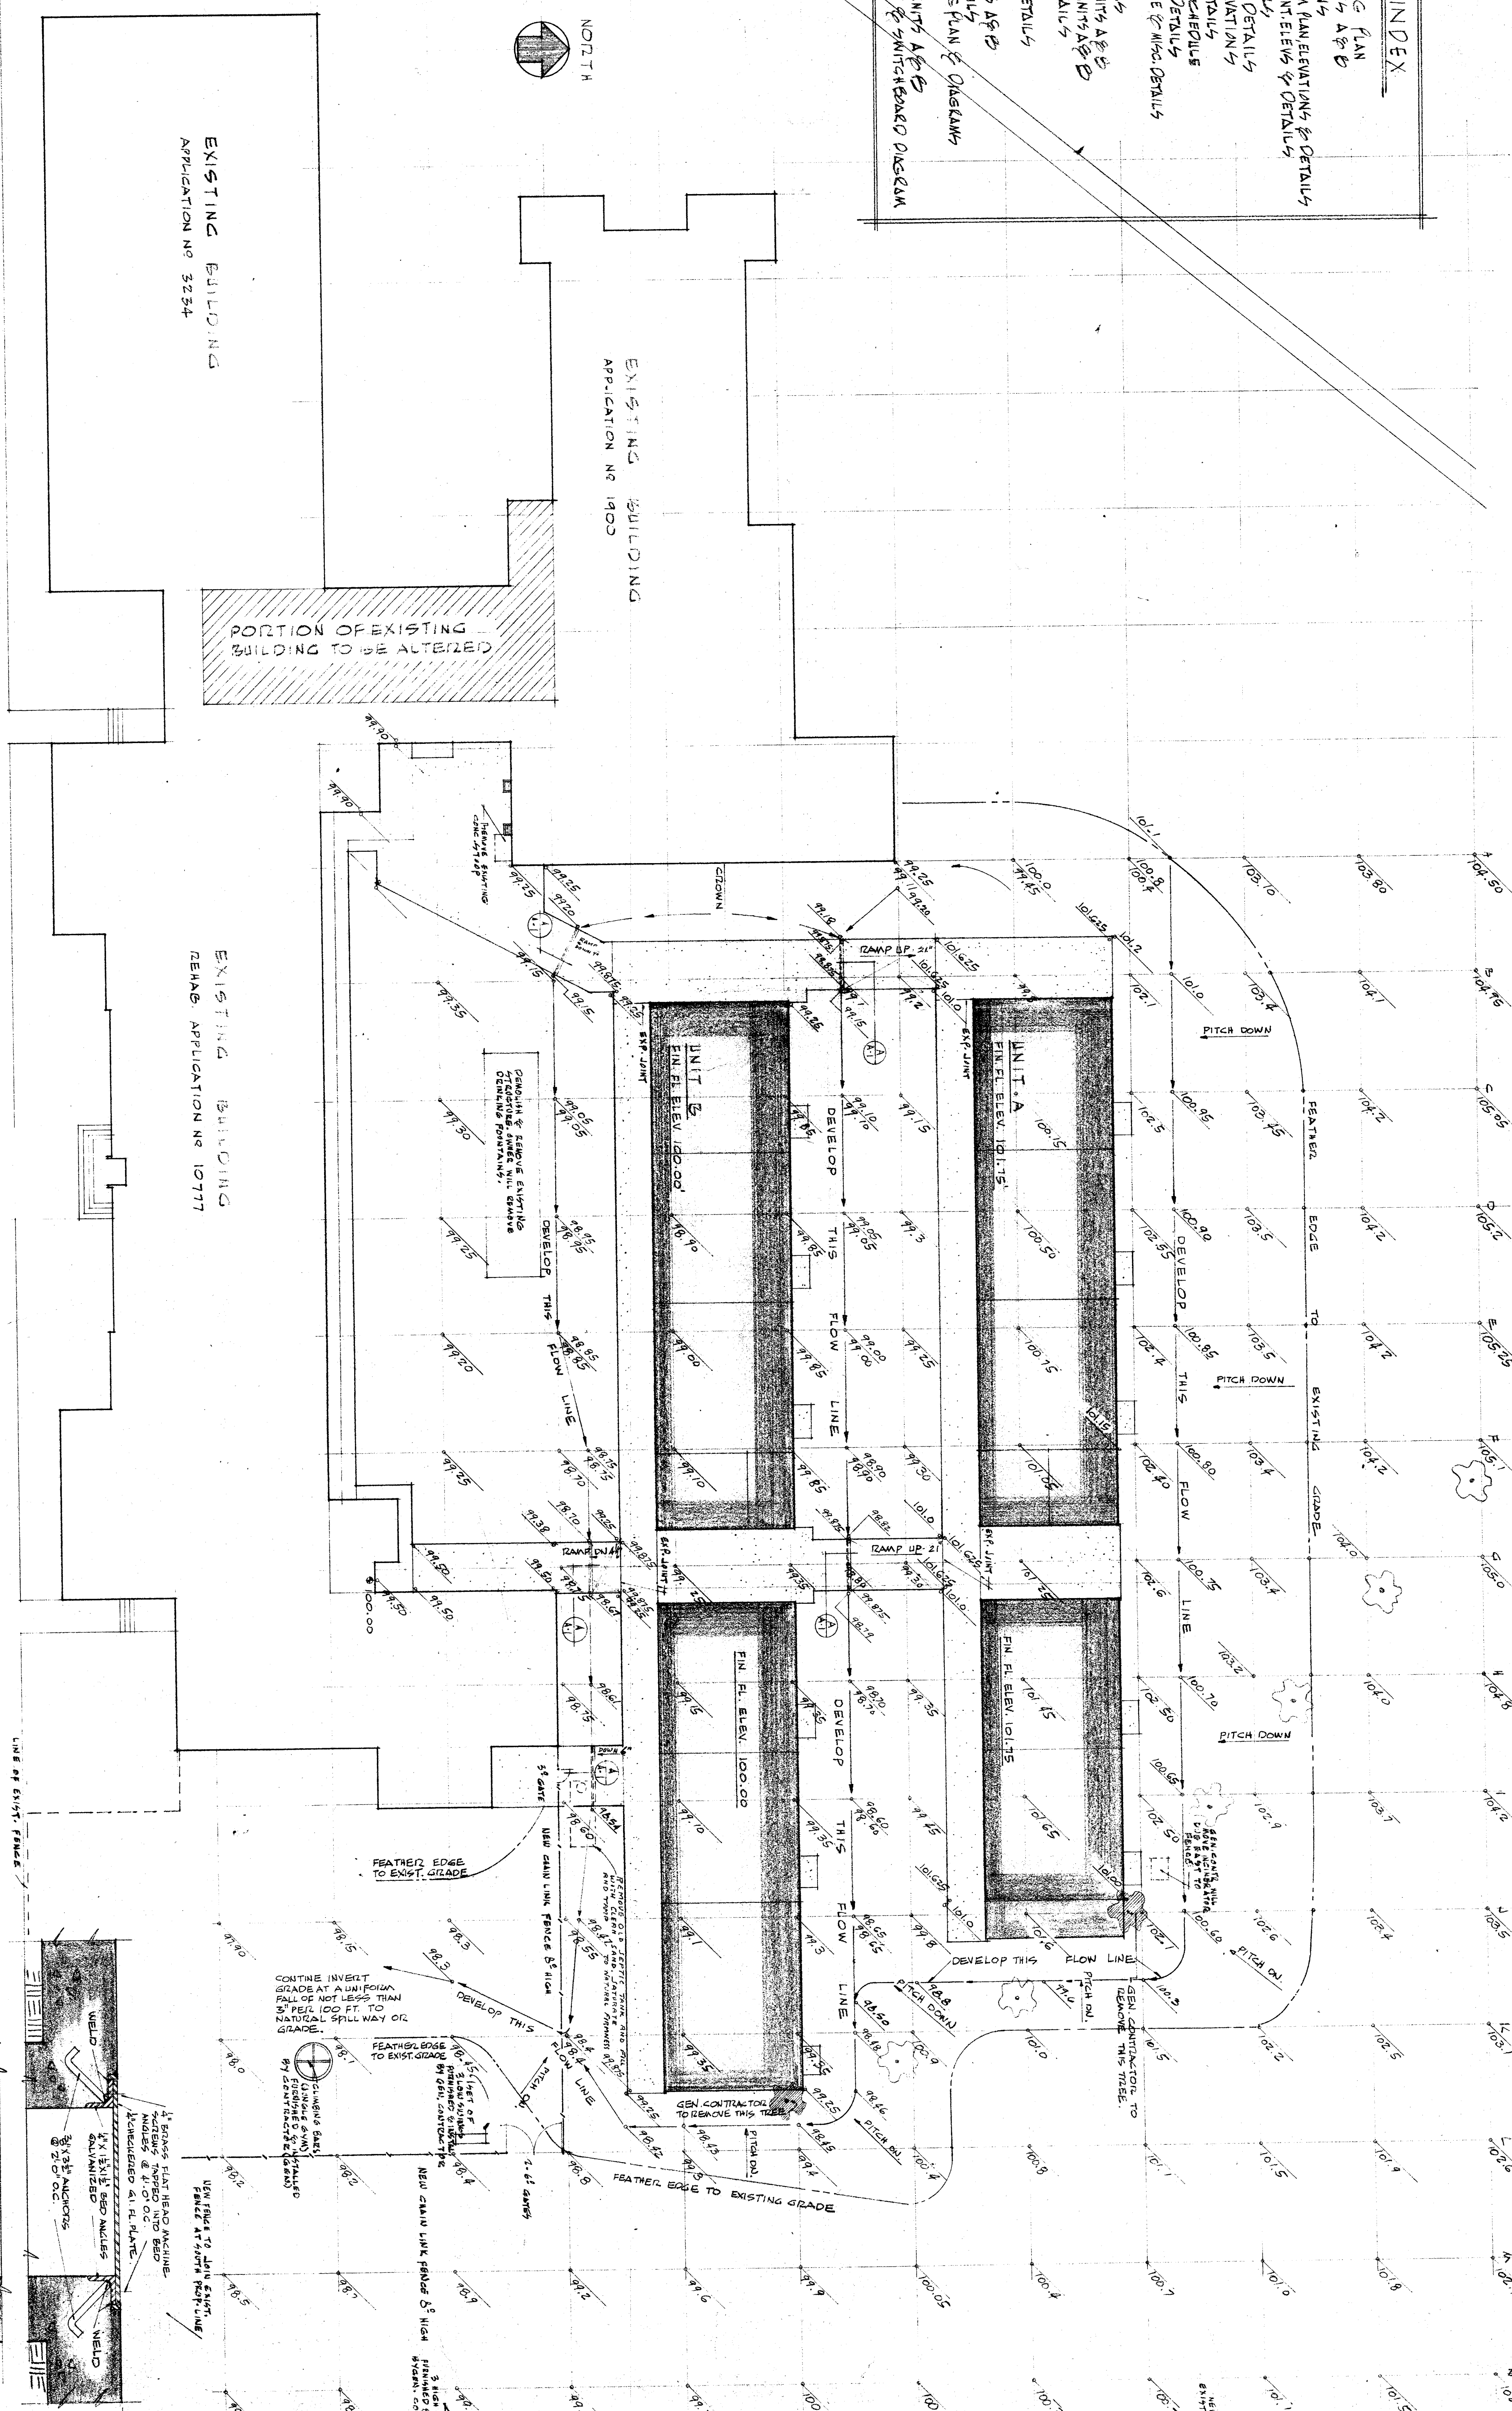

LEGEND
 NEW
 EXISTING

FINISH GRADE ABOVE LINE
 EXISTING GRADE BELOW LINE
 FIN. FL. EXIST. BLDG.
 EXISTING TREE (SEE PLANS FOR CONFLICT WITH GROUNDS)

DETAIL OF GUTTER UNDER W.
 SCALE 3/4" = 1'-0"

CHECK AND VERIFY ALL DIMENSIONS AND CONDITIONS AT JOB SITE BEFORE PROCEEDING WITH THE WORK. REPORT ANY DISCREPANCIES TO THE ARCHITECT.

OFFICE OF SUPERINTENDENT OF SCHOOLS
 DEPARTMENT OF PUBLIC WORKS
 DIVISION OF ARCHITECTURE

STATE OF CALIFORNIA
 DEPARTMENT OF PUBLIC WORKS
 DIVISION OF ARCHITECTURE

STATE OF CALIFORNIA
 DEPARTMENT OF PUBLIC WORKS
 DIVISION OF ARCHITECTURE

BAKERFIELD CITY SCHOOLS
 1600 WEST SANDESFIELD CALIF.
 BOARD OF EDUCATION

APPROVED
 DATE

ADDITIONS & ALTERATIONS TO
 HORACE MANN ELEM. SCHOOL
 2710 NILES STREET
 BAKERFIELD CALIFORNIA

ERNEST L. MCCOY A.I.A. ARCH.
 2011 H STREET
 BAKERFIELD