



TYPICAL SECTION THRU UNIT VENTILATOR
SCALE: 3/4" = 1'-0"

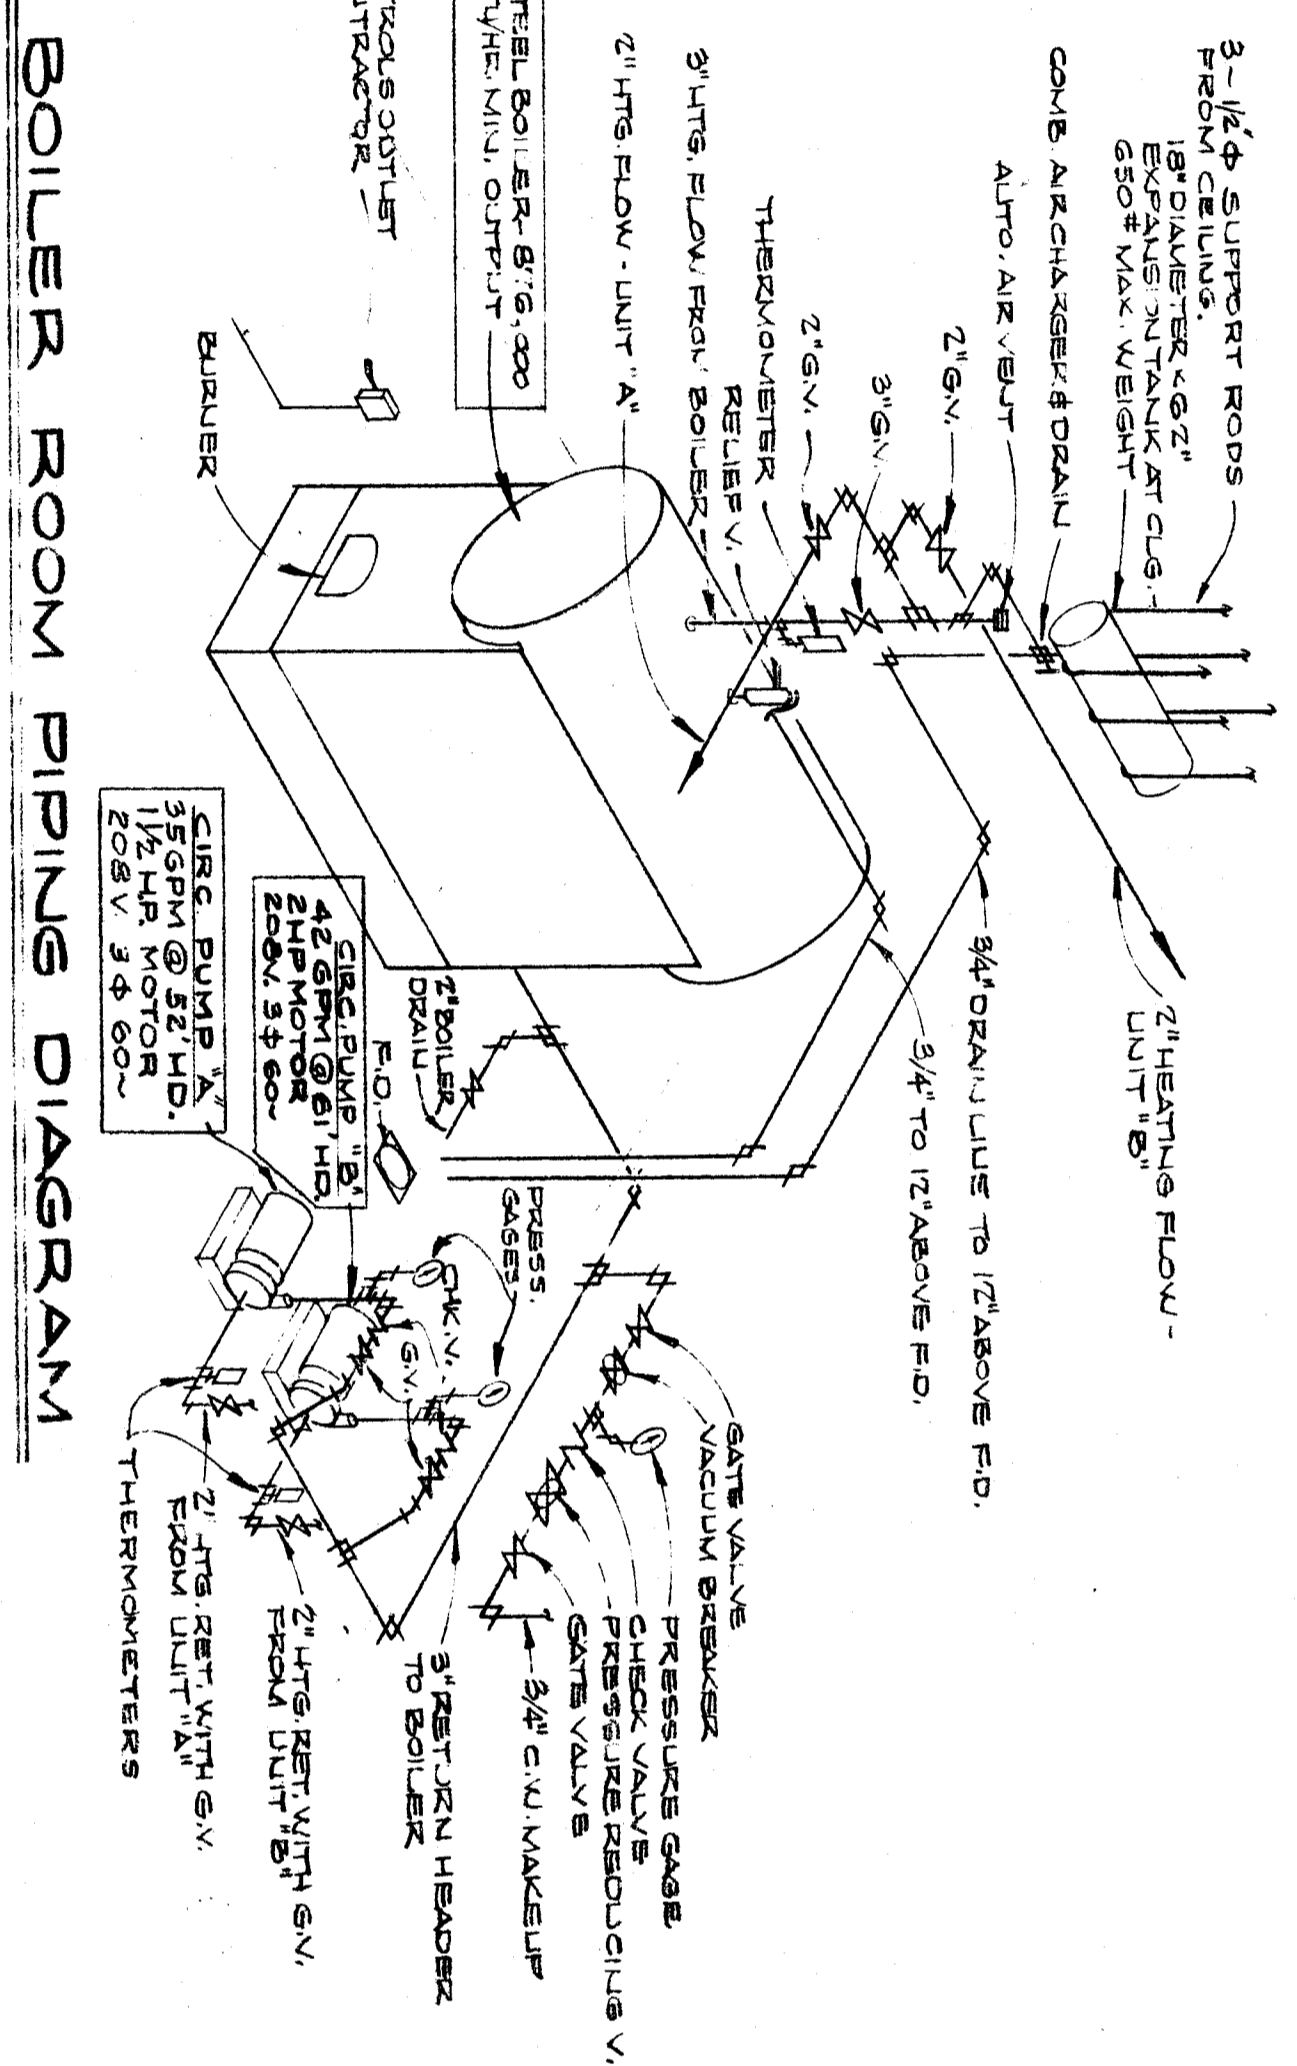

BOILER ROOM PIPING DIAGRAM

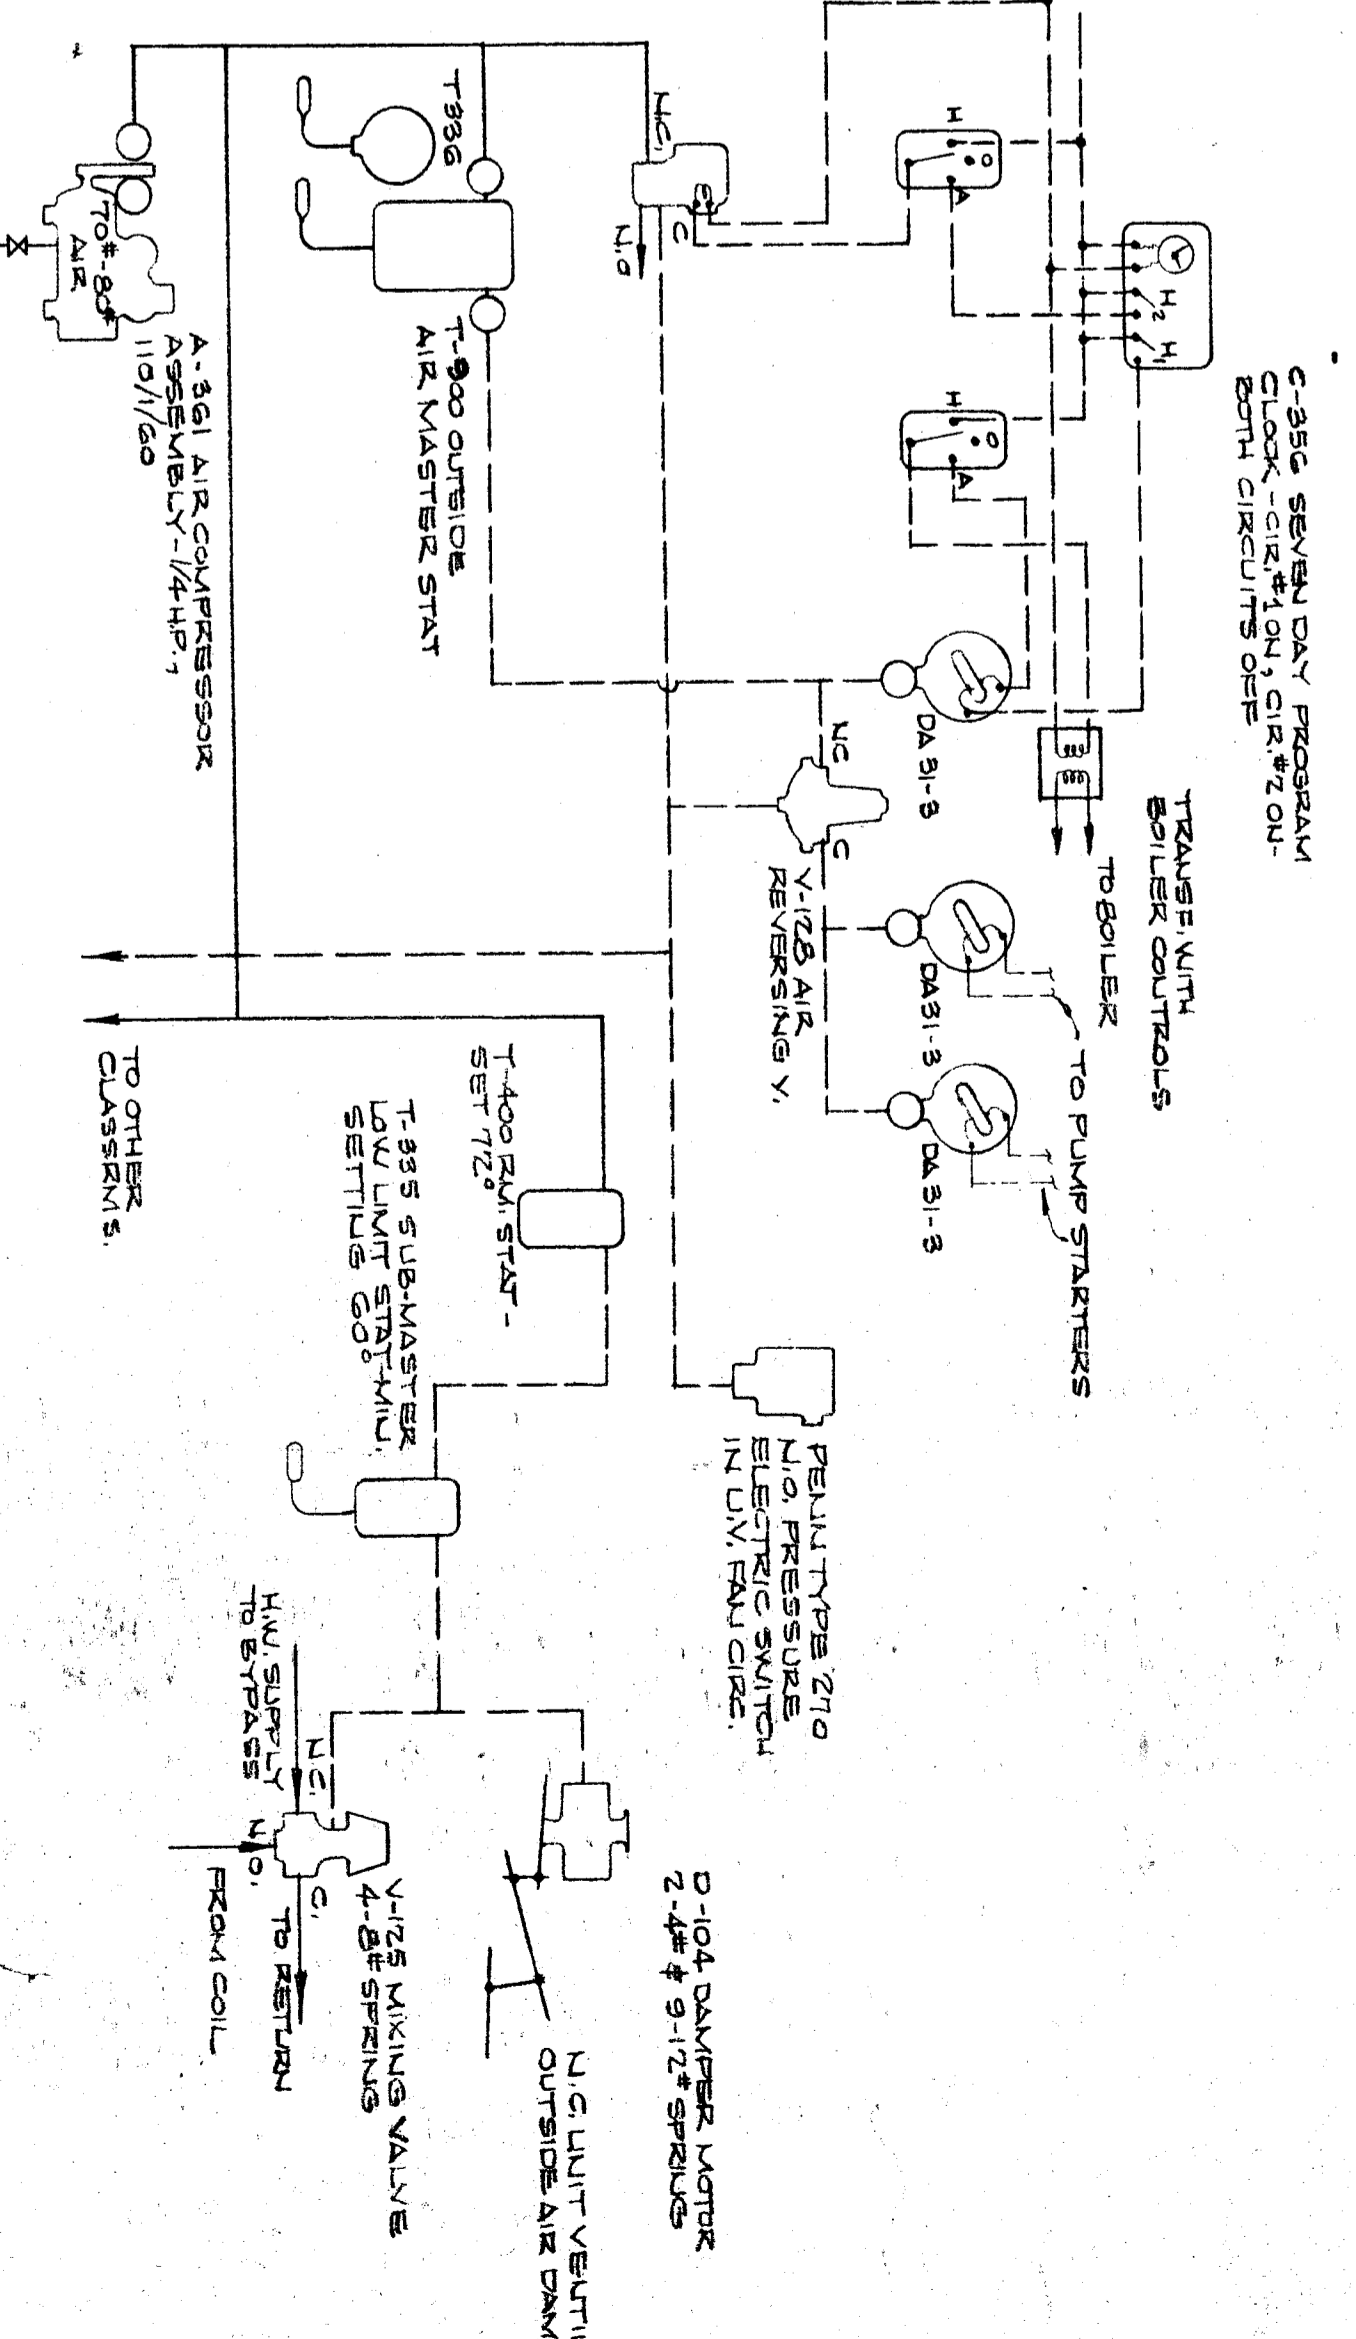

HEATING PLANS & DETAILS

W. A. STAINS
CONSULTING ENGINEER
MECH. 5305
1603 CALIFORNIA AVENUE
BAKERSFIELD, CALIFORNIA

OFFICE OF SUPERINTENDENT OF SCHOOLS
DIVISION OF ARCHITECTURE

STATE OF CALIFORNIA
DEPARTMENT OF PUBLIC WORKS
DIVISION OF ARCHITECTURE

BAKERSFIELD CITY SCHOOLS
800K ST. BAKERSFIELD, CALIF.
BOARD OF EDUCATION

APPROVED

ADDITIONS & ALTERATIONS TO
HORACE MANN ELEM. SCHOOL
2710 NILES STREET
BAKERSFIELD, CALIFORNIA

ENEST L. MCCOY A.I.A. ARCHITECT
8811 N STREET
BAKERSFIELD

DATE: 11-20-55
DRAWN BY: M-2
CHECKED: M-2
SHEET NO. OF 3 SHEETS

CHECK AND VERIFY ALL DIMENSIONS AND CONDITIONS AT JOB SITE BEFORE PROCEEDING WITH THE WORK. REPORT ANY DISCREPANCIES TO THE ARCHITECT.