


BUILDING 100

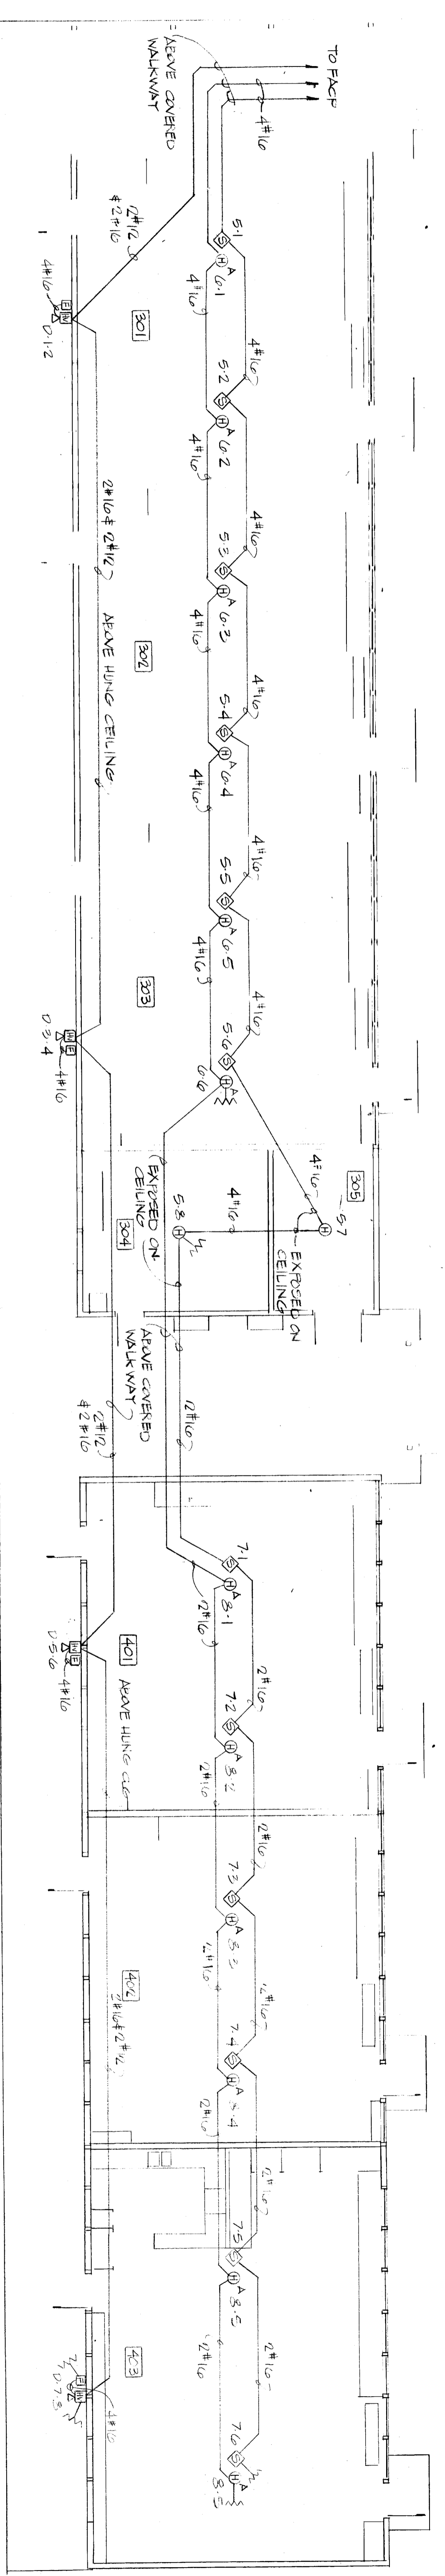

BUILDING 300


BUILDING 200

BUILDING 400

FLOOR PLANS - FIRE ALARM


FIRE ALARM SYSTEM NOTES: BASE BID SHALL INCLUDE FIRE ALARM HORNS AND PULL STATIONS AND ALL NECESSARY WIRING. ALTERNATE BID SHALL INCLUDE PULL FIRE ALARM DETECTION AS SHOWN (SEE # 1 NOTE (S))

1/8"=1'-0"

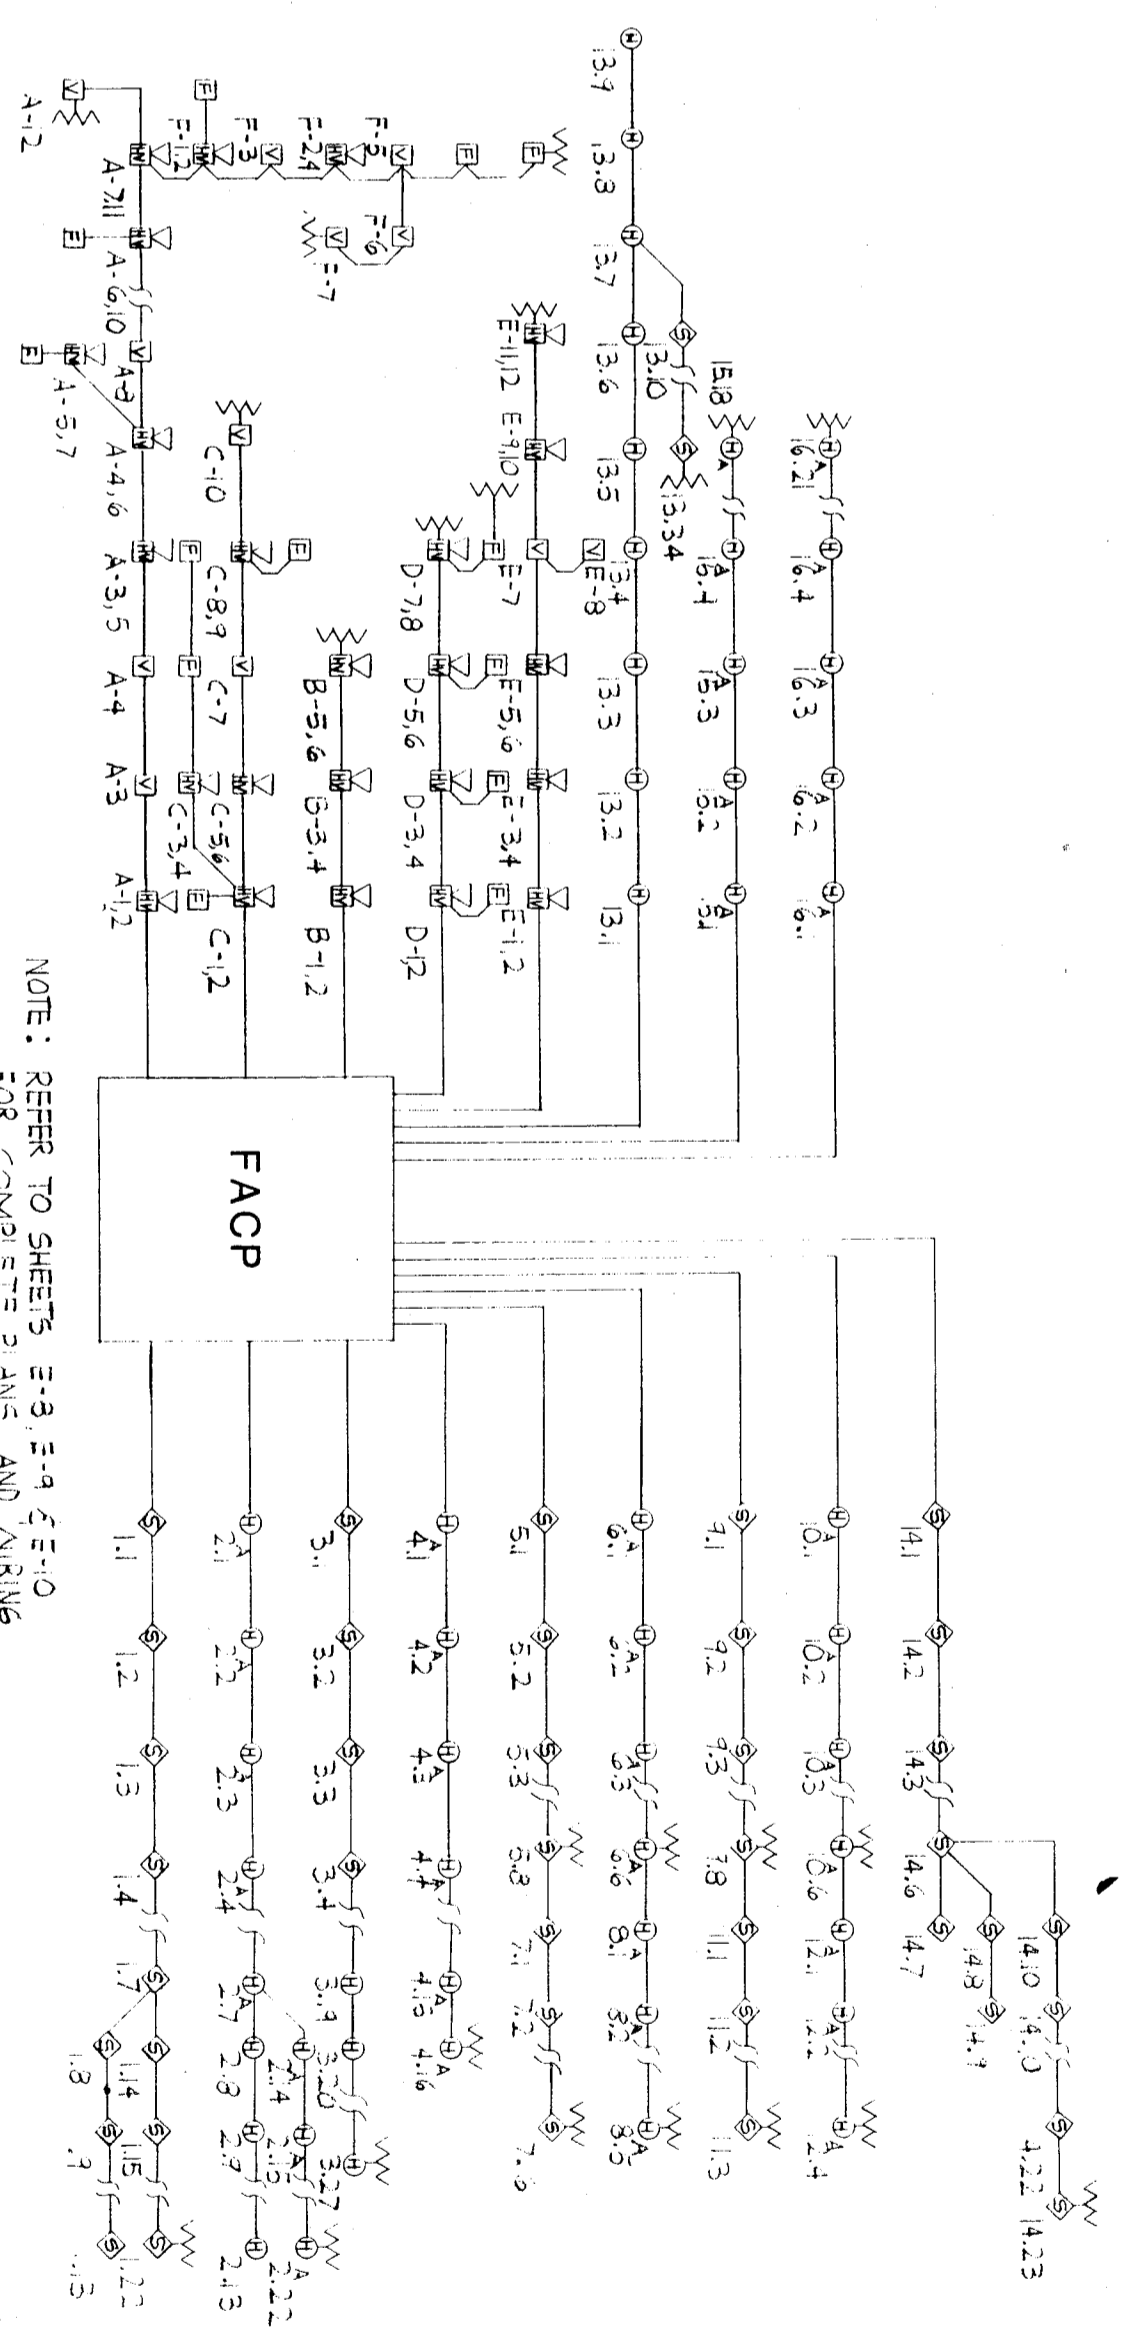

FIRE ALARM RISER DIAGRAM

NO SCALE

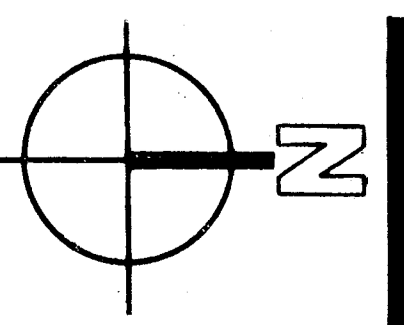

architects - planners

approved

DATE: FEB 81

DATE: FEB 81

DATE: FEB 81

INTERSTATE ENGINEERING, INC.
REGISTERED PROFESSIONAL ENGINEERS
CALIFORNIA LICENSE NO. 10000

C. 3182
C. 3226
* C. 5554
C. 8021
C. 8702
© Copyrighted 1981
DP [Signature]

bfgc Inc.
architects - planners
2710 NILES AVENUE
BAKERSFIELD, CALIFORNIA 93307
805 832 8122

FIRE ALARM FLOOR PLANS - BUILDING 100/200/300 & 400
HORACE MANN MODERNIZATION
BAKERSFIELD CITY SCHOOL DISTRICT
2710 NILES AVENUE
BAKERSFIELD, CALIFORNIA 93307

DATE: FEB 81

