


PLUMBING LEGEND					
SYMB	ABBR	DESCRIPTION	SYMB	ABBR	DESCRIPTION
-AP-	AP	ACCESS PANEL	-LAV-	LAV	LAVATORY
-BP-	BP	BELOW FLOOR	-LPG-	LPG	LIQUID PETROLEUM GAS
-CB-	CB	CATCH BASIN	-MR-	MR	MANHOLE
-CC-	CC	CASE	-MPS-	MPS	MOP SINK
-CG-	CG	CLEANOUT	-NIC-	NIC	NOT IN CONTRACT
-CGG-	CGG	CLEANOUT TO GRADE	-OC-XY	OC XY	OUTSIDE STEM & YOKE
-CP-	CP	CIRCULATING PUMP	-PI-	PI	PLASTER INTERCEPTOR
-DCW-	DCW	DOMESTIC COLD WATER	-PDR-	PDR	POINT OF CONNECTION
-DWH-	DWH	DOMESTIC HOT WATER	-PR-	PR	PRESSURE REGULATOR
-DWR-	DWR	DOMESTIC HOT WATER RETURN	-PDR-	PDR	POINT OF CONNECTION
-DW-	DW	DOMESTIC TEMPERED WATER	-PTC-	PTC	POUR-TIGHT GROUT
-EDP-	EDP	ELECTRIC DRINKING POT/MAIN EXPOSED	-RD-	RD	ROOF DRAIN
-FD-	FD	FLOOR DRAIN	-S-	S	SINK
-FDL-	FDL	FLOOR DRAIN	-SB-	SB	SPLASH BLOCK
-FE-	FE	FIRE EXTINGUISHER	-SDI-	SDI	SPRINKLER DRAIN LINE
-FPC-	FPC	FIRE HOSE CABINET	-SD-	SD	SHOWER
-FHS-	FHS	FIRE HOSE CABINET	-SO-	SO	SOFFIT VALVE
-FSL-	FSL	FIRE SPRINKLER HEAD	-SPR-	SPR	SERVICER SINK
-FTR-	FTR	FIRE TRUCK ROOF	-S&W-	S&W	SOIL AND WASTE
-G-	G	GAS COCK	-TP-	TP	TRAP PRIMER
-GAL-	GAL	GAS TRAP	-TY-	TY	TEMPERING VALVE
-GR-	GR	GREASE TRAP	-UR-	UR	URINAL
-HB-	HB	ROSE BIB	-VC-	VC	VITRIFIED CLAY
-HC-	HC	ROSE COCK	-VO-	VO	VENT OFFSET
-HR-	HR	ROSE REEL	-VTR-	VTR	VENT THRU ROOF
-HP-	HP	HIGH PRESSURE	-WC-	WC	WATER CLOSET
-IA-	IA	INDIRECT WASTE	-WCO-	WCO	WATER CLOSET
			-WH-	WH	WATER HEATER
			-WMA-	WMA	WATER HAMMER ARRESTER
			-YB-	YB	WASHING MACHINE FITTING
					YARD BOX

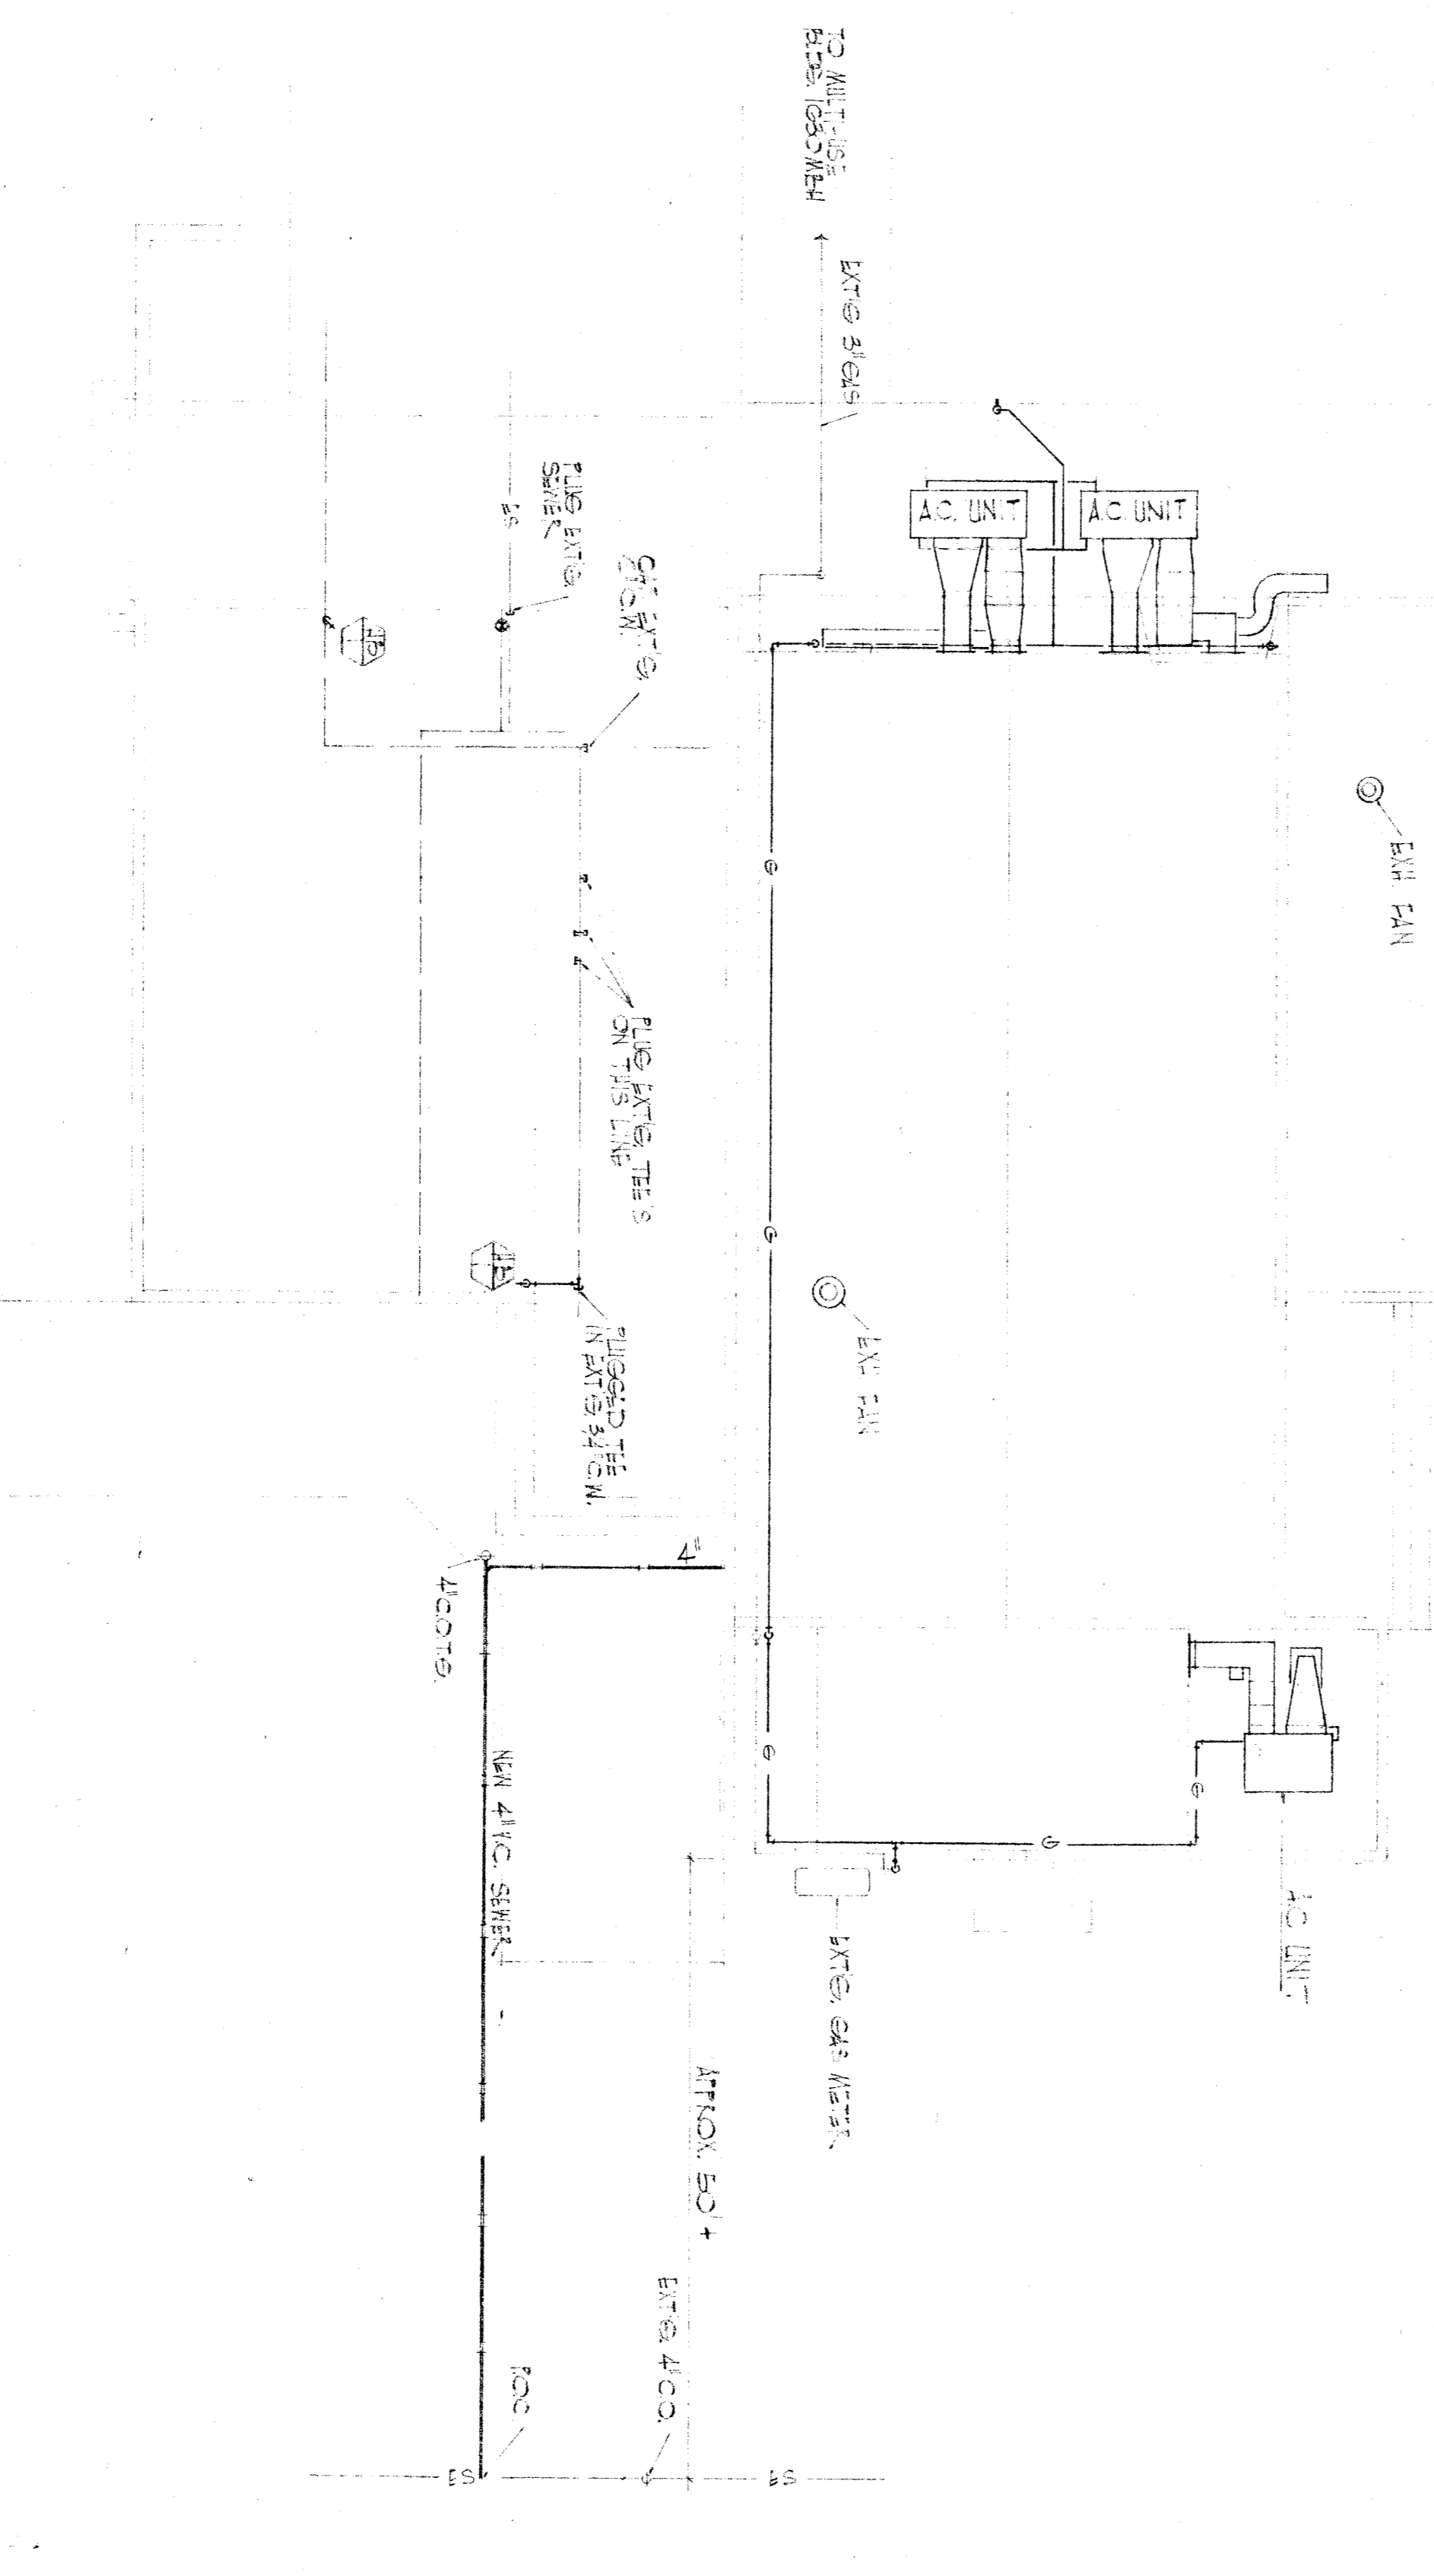

PLUMBING FIXTURES SCHEDULE				
MARK OR WASTE	SOIL TRAP VENT	DIW	DHW	MANUFACTURER AND MODEL NO.
1	4" INT 2"	1"		American Std. American Std. No. F-72-41 "New Maderna" No. 22222
1	2" 1 1/2"	1/2"	1/2"	American Std. Acid-Resisting Enamelled Cast Iron Lavatory - Front No. 2131 "Regalyn" No. 2131 "New Maderna" No. 2131 "Regalyn" No. 2131 "New Maderna" No. 2131 "Regalyn" No. 2131 "New Maderna" No. 2131
2	2" 1 1/2"	1/2"	1/2"	American Std. Acid-Resisting Enamelled Cast Iron Lavatory - Front No. 2131 "Regalyn" No. 2131 "New Maderna" No. 2131 "Regalyn" No. 2131 "New Maderna" No. 2131
3	2" 1 1/2"	1/2"	1/2"	American Std. Acid-Resisting Enamelled Cast Iron Lavatory - Front No. 2131 "Regalyn" No. 2131 "New Maderna" No. 2131 "Regalyn" No. 2131 "New Maderna" No. 2131
4	2" 1 1/2"	1/2"	1/2"	American Std. Acid-Resisting Enamelled Cast Iron Lavatory - Front No. 2131 "Regalyn" No. 2131 "New Maderna" No. 2131 "Regalyn" No. 2131 "New Maderna" No. 2131
5	2" 1 1/2"	1/2"	1/2"	American Std. Acid-Resisting Enamelled Cast Iron Lavatory - Front No. 2131 "Regalyn" No. 2131 "New Maderna" No. 2131 "Regalyn" No. 2131 "New Maderna" No. 2131
6	2" 1 1/2"	1/2"	1/2"	American Std. Acid-Resisting Enamelled Cast Iron Lavatory - Front No. 2131 "Regalyn" No. 2131 "New Maderna" No. 2131 "Regalyn" No. 2131 "New Maderna" No. 2131

C. A. McArthur

FRAPWELL AND GHEZZI ARCHITECTS A.I.A.
 P. O. BOX 2022 PHONE 324-3441
 1717 - 28th STREET BAKERSFIELD, CALIF. 93303

DRAWN BY: MICHAEL WOODS
 DATE: Nov. 24, 69

CHECK AND VERIFY ALL DIMENSIONS AND CONDITIONS AT THE JOB SITE BEFORE PROCEEDING WITH THE WORK. REPORT ANY DISCREPANCIES TO THE ARCHITECT

PLUMBING PLOT PLAN, LEGEND & SCHEDULE

ADMINISTRATION REHABILITATION
 MT. VERNON SCHOOL
 BAKERSFIELD CITY SCHOOL DISTRICT
 BAKERSFIELD, KERN COUNTY, CALIF.

OF 4 SHEETS SHEET 1 JOB NO. 69-107 R