

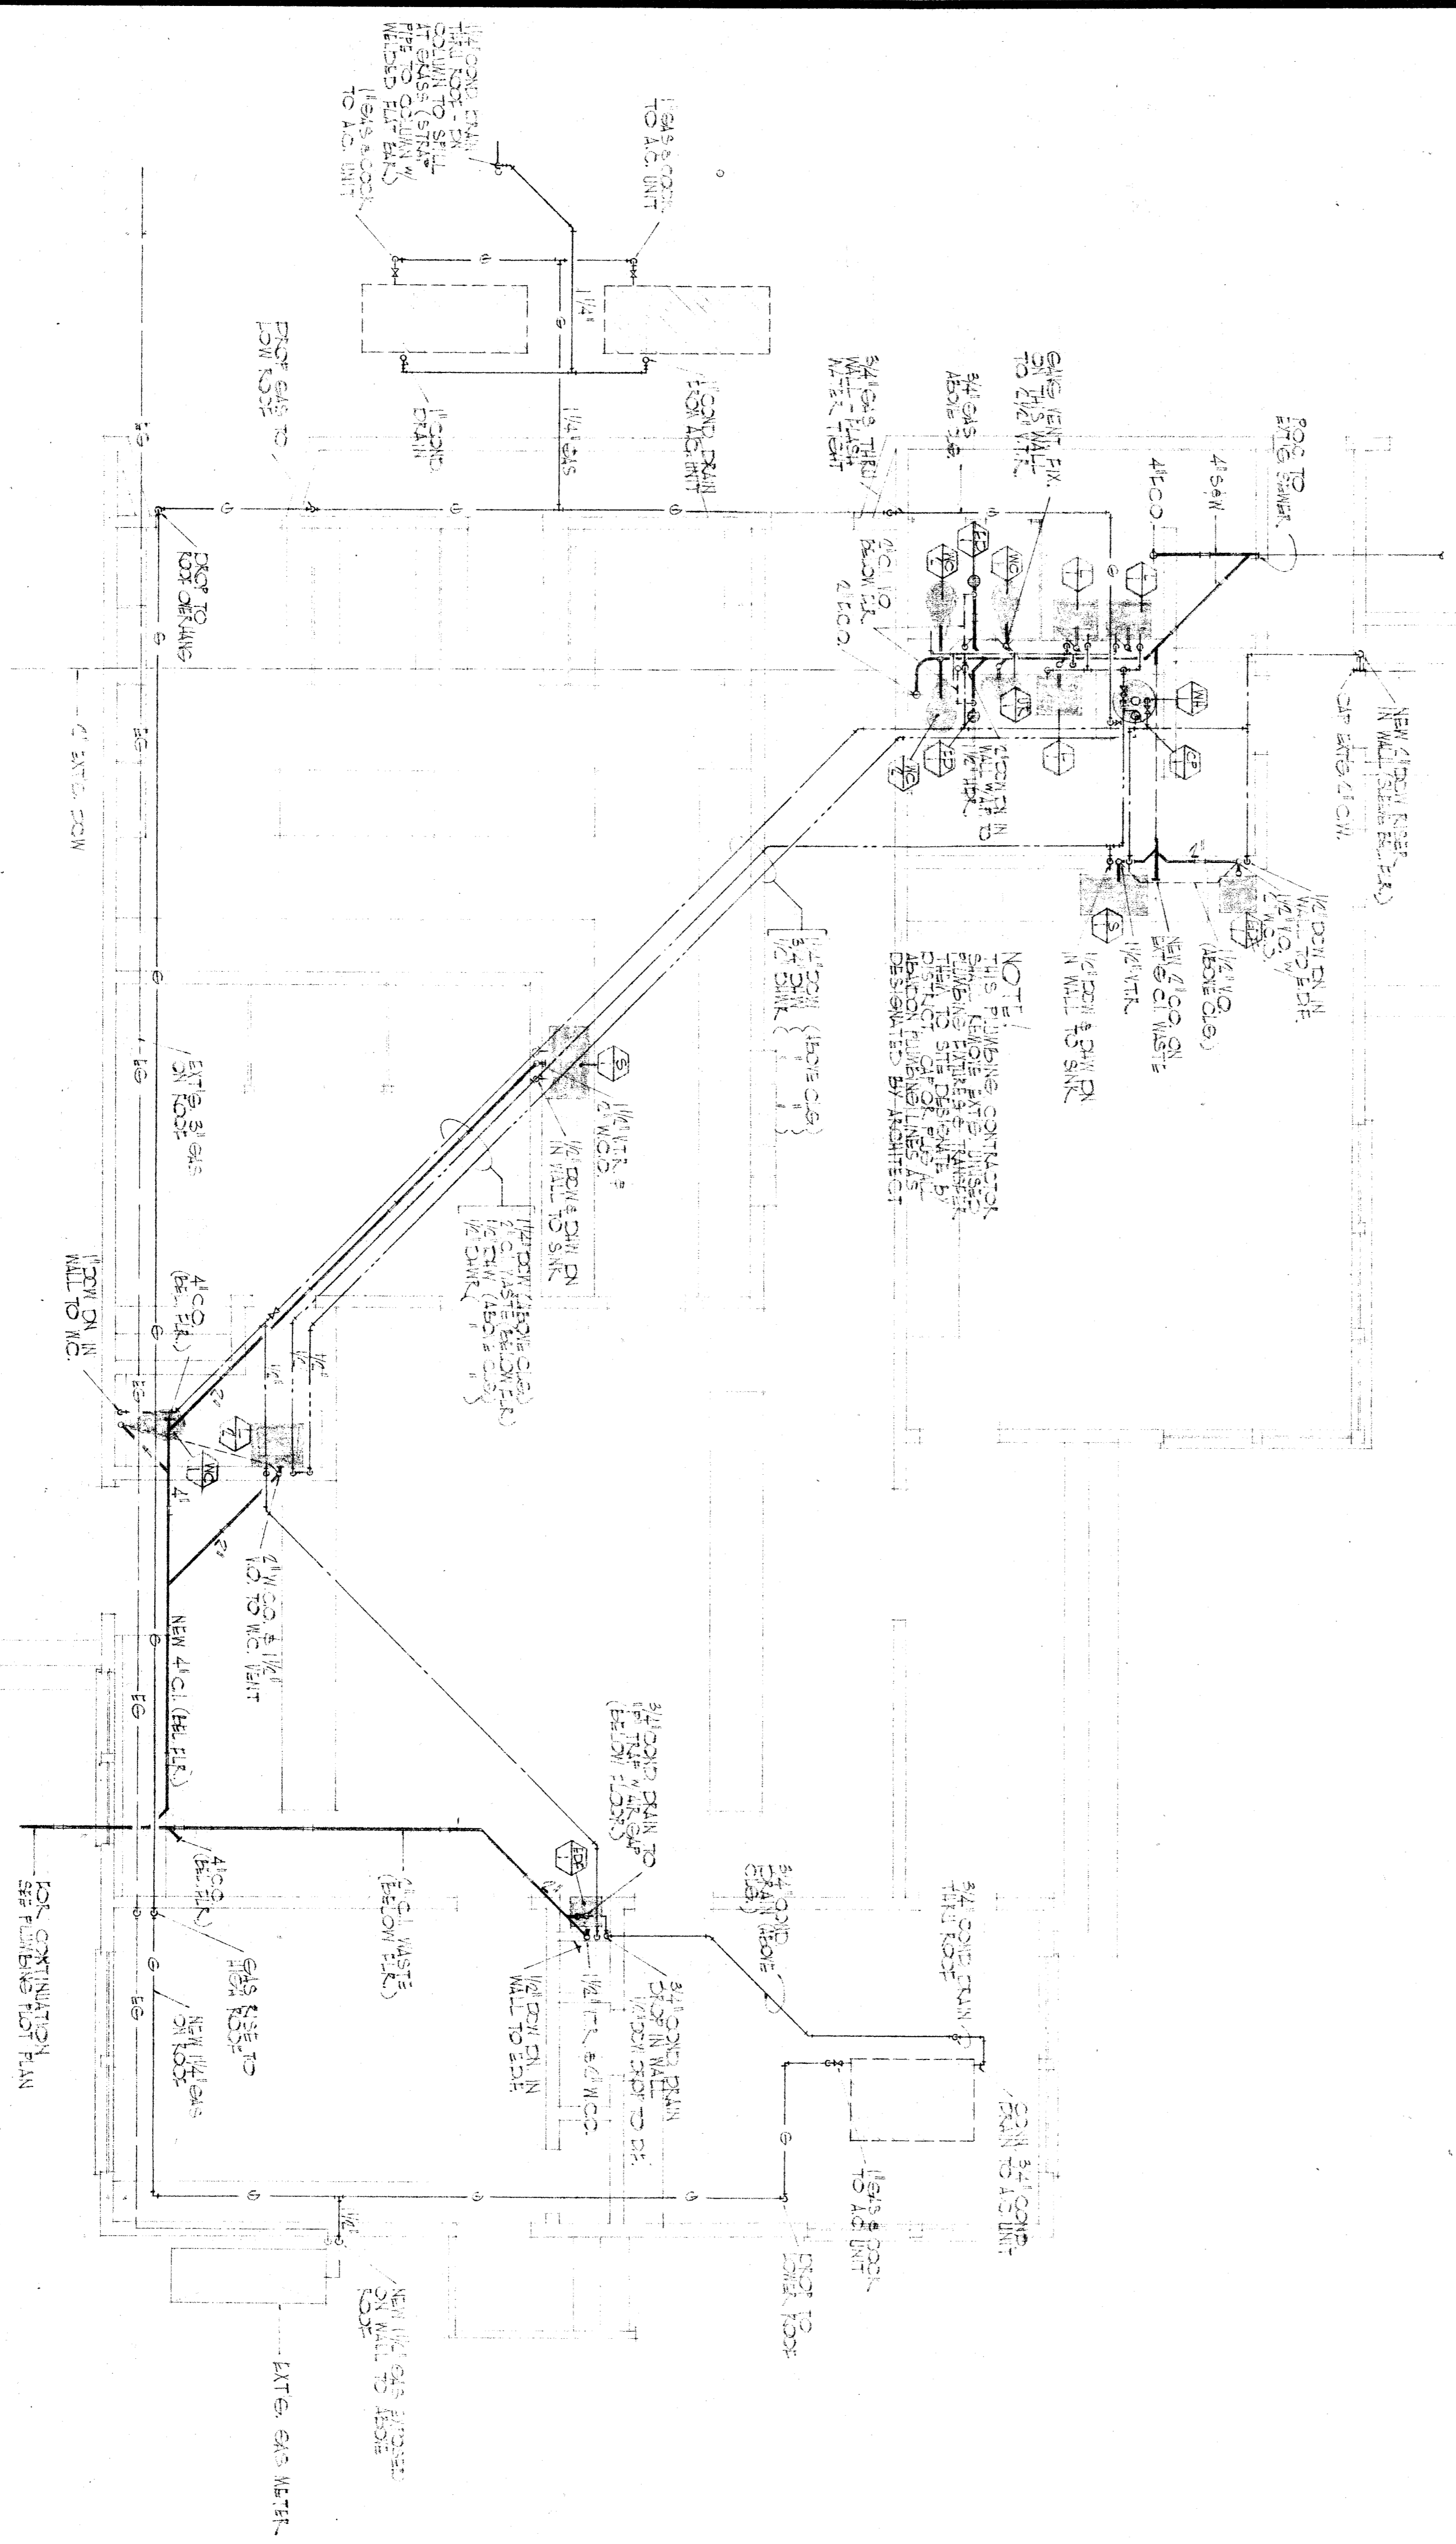
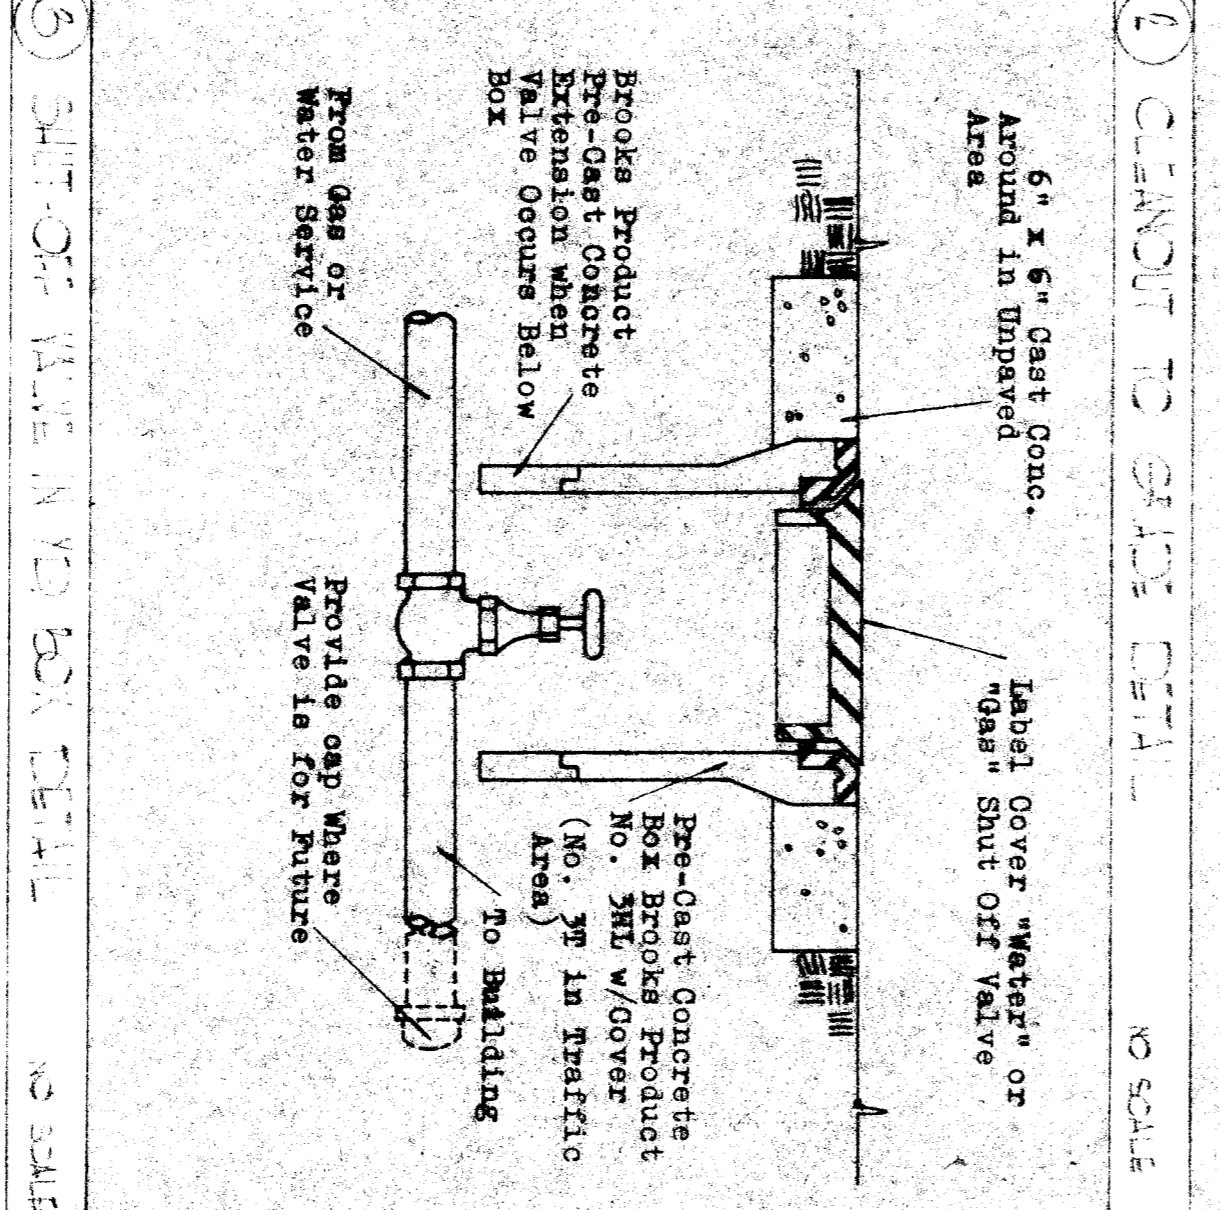


# PLUMBING FLOOR PLAN

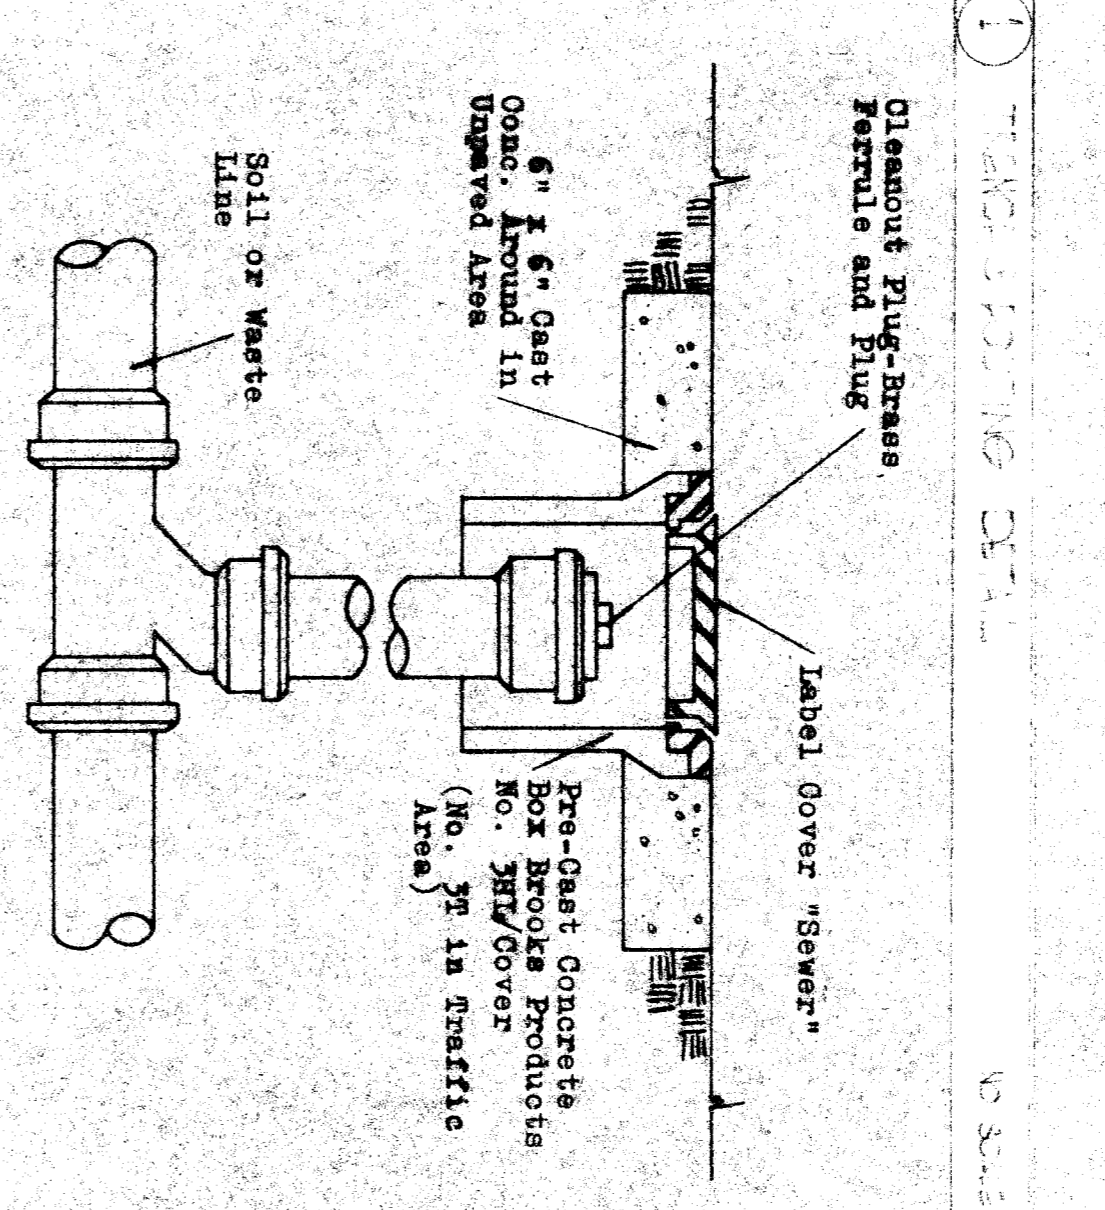


NOTE:  
THIS FLOORING CONTRACTOR  
IS RESPONSIBLE FOR  
PROTECTING ALL EXISTING  
PLUMBING AND ELECTRICAL  
WORK. ALL NEW WORK  
SHALL BE INSTALLED  
IN ACCORDANCE WITH THE  
DESIGN AND BY THE ARCHITECT.

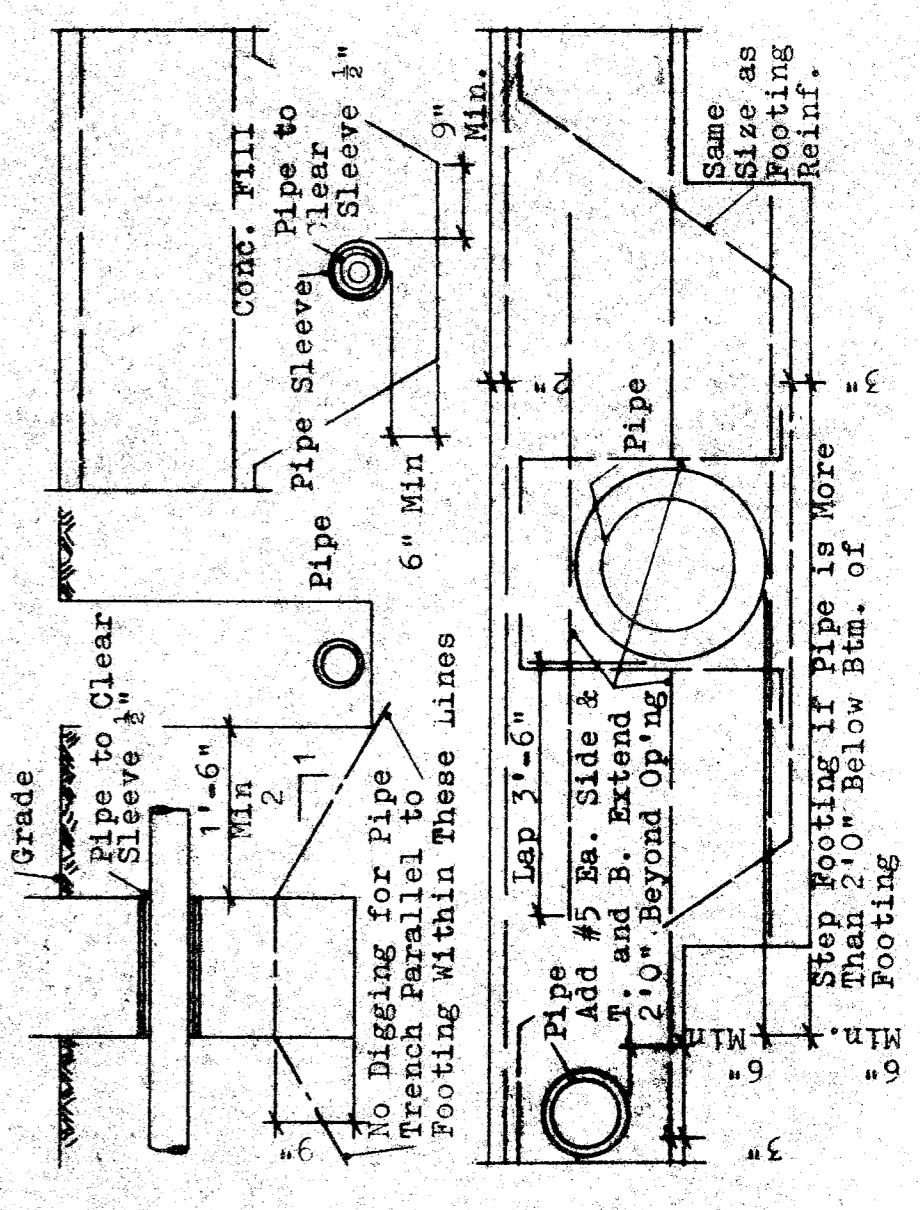

12-2  
SHEETS  
OF 2  
JOB NO. 67 107 2

PLUMBING PLAN & DETAILS  
ADMINISTRATION REHABILITATION  
MT. VERNON SCHOOL  
BAKERSFIELD CITY SCHOOL DISTRICT  
BAKERSFIELD KERN COUNTY, CALIF.

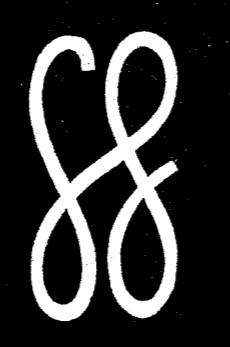

**FRAPWELL AND GHEZZI ARCHITECTS A.I.A.**  
P. O. BOX 2022 PHONE 324-3441  
1717 - 28th STREET BAKERSFIELD, CALIF. 93303

DRAWN BY: [Signature]  
DATE: NOV. 24, 69

CHECK AND VERIFY ALL DIMENSIONS AND CONDITIONS AT THE JOB SITE BEFORE PROCEEDING WITH THE WORK. REPORT ANY DISCREPANCIES TO THE ARCHITECT

[Signature]