



PLUMBING FLOOR PLAN SCALE 1/8"=1'-0"

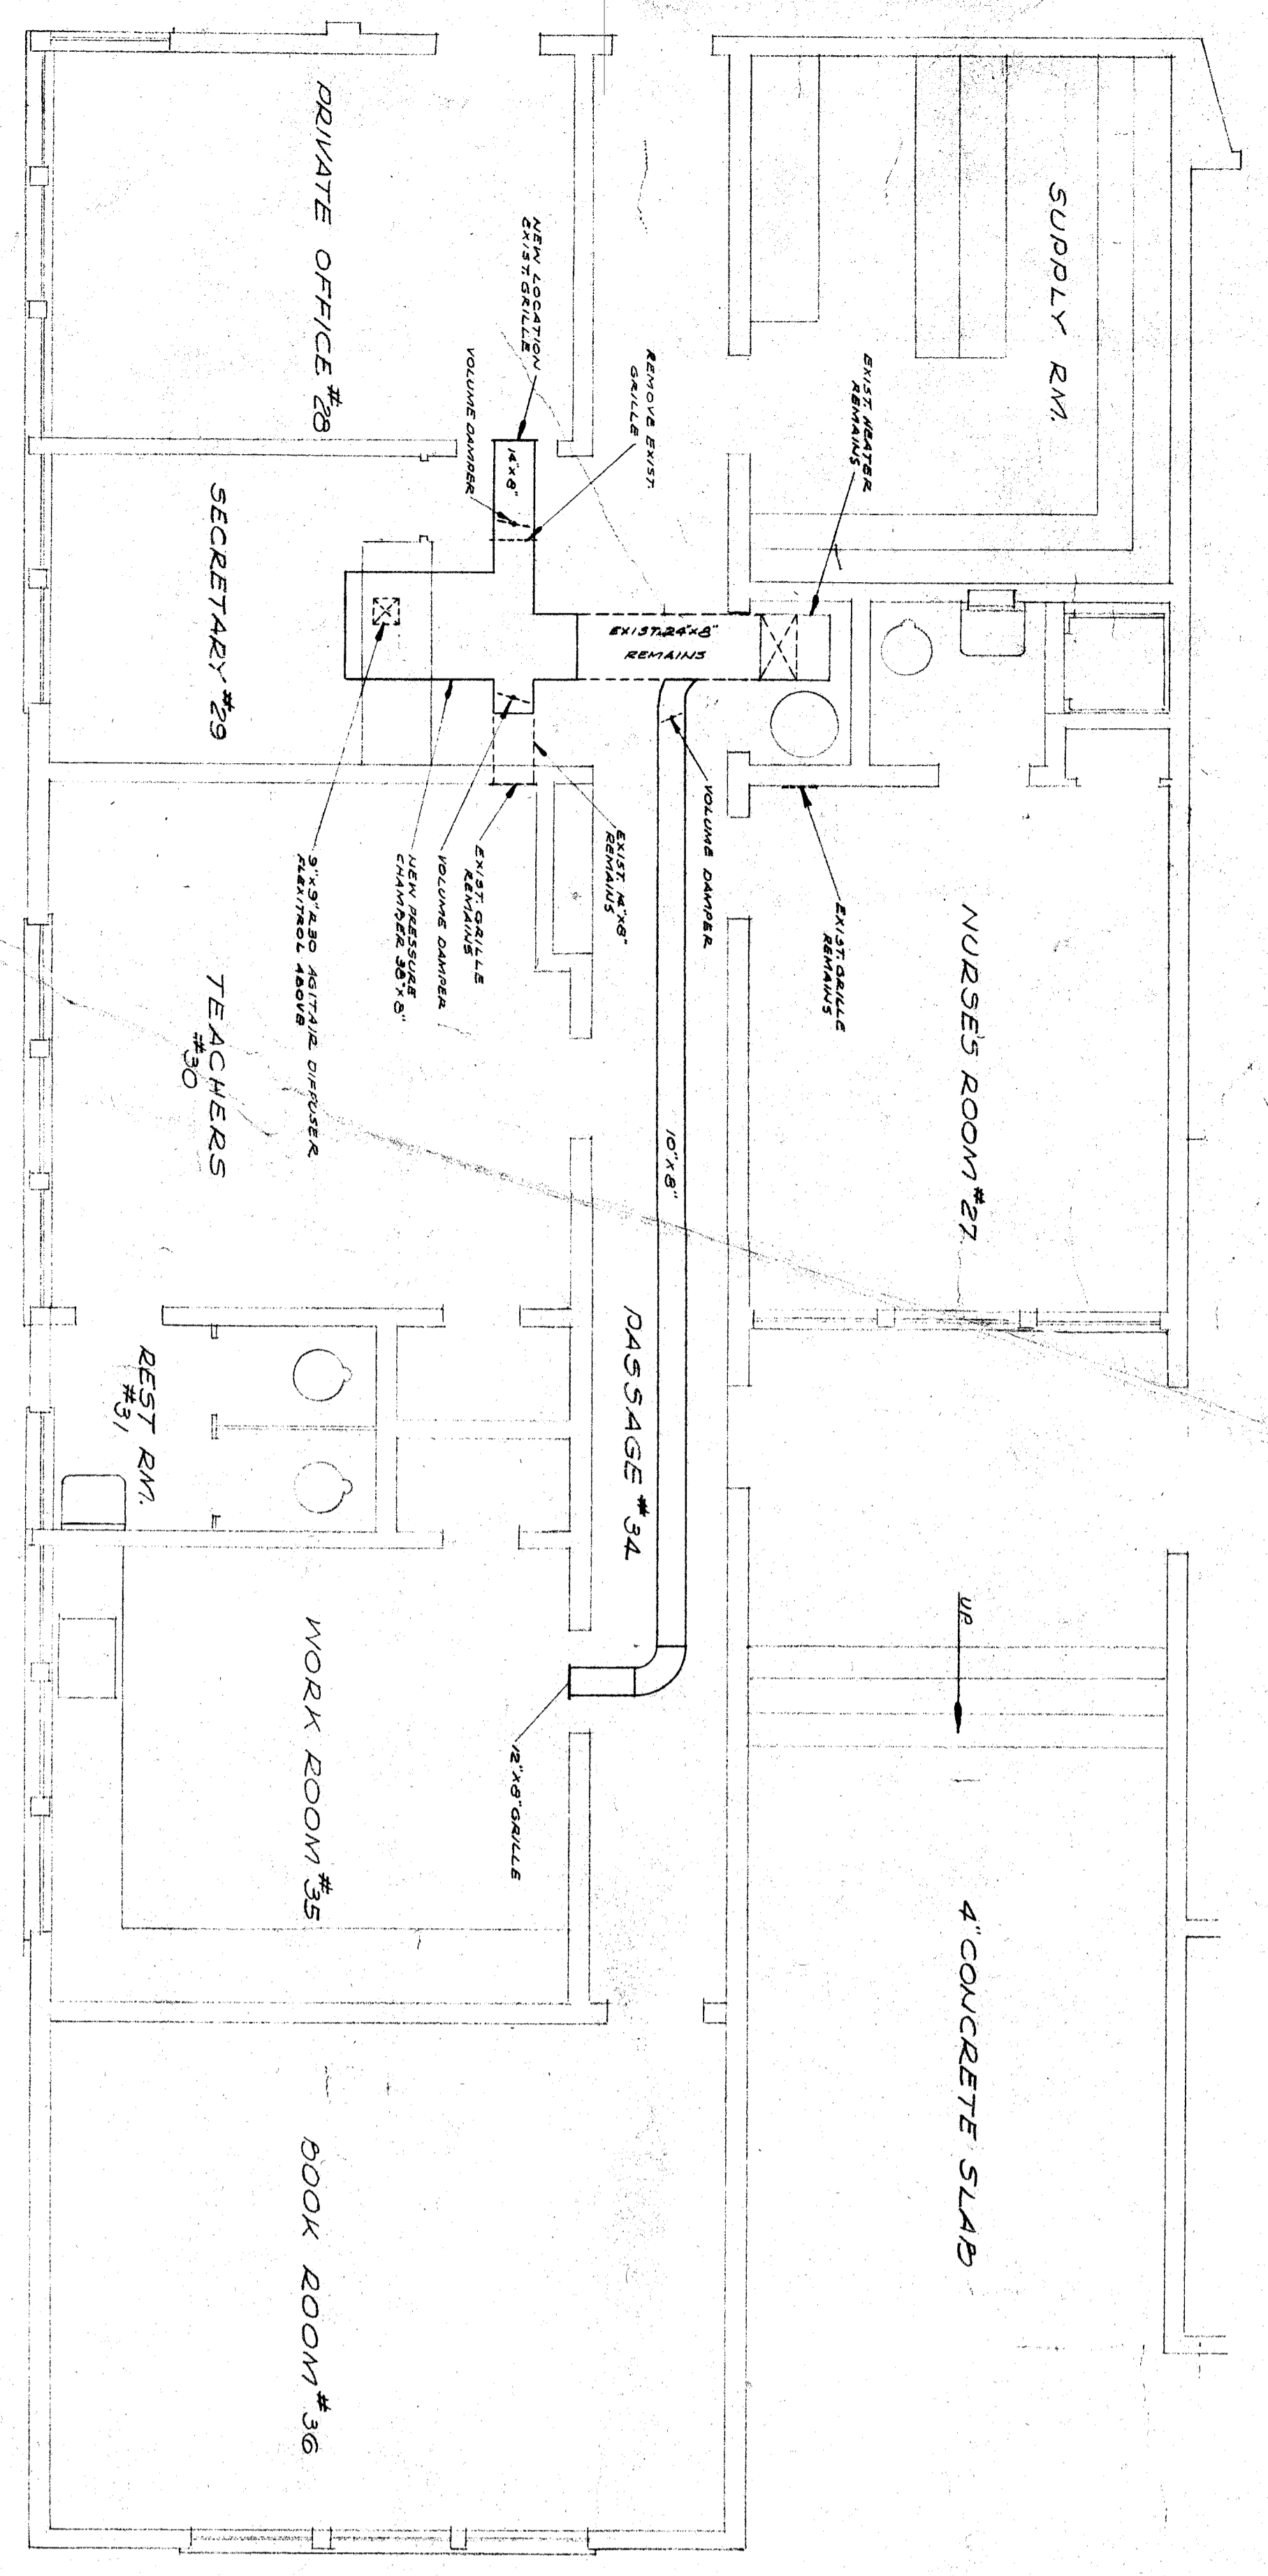

HEATING FLOOR PLAN SCALE 1/8"=1'-0"

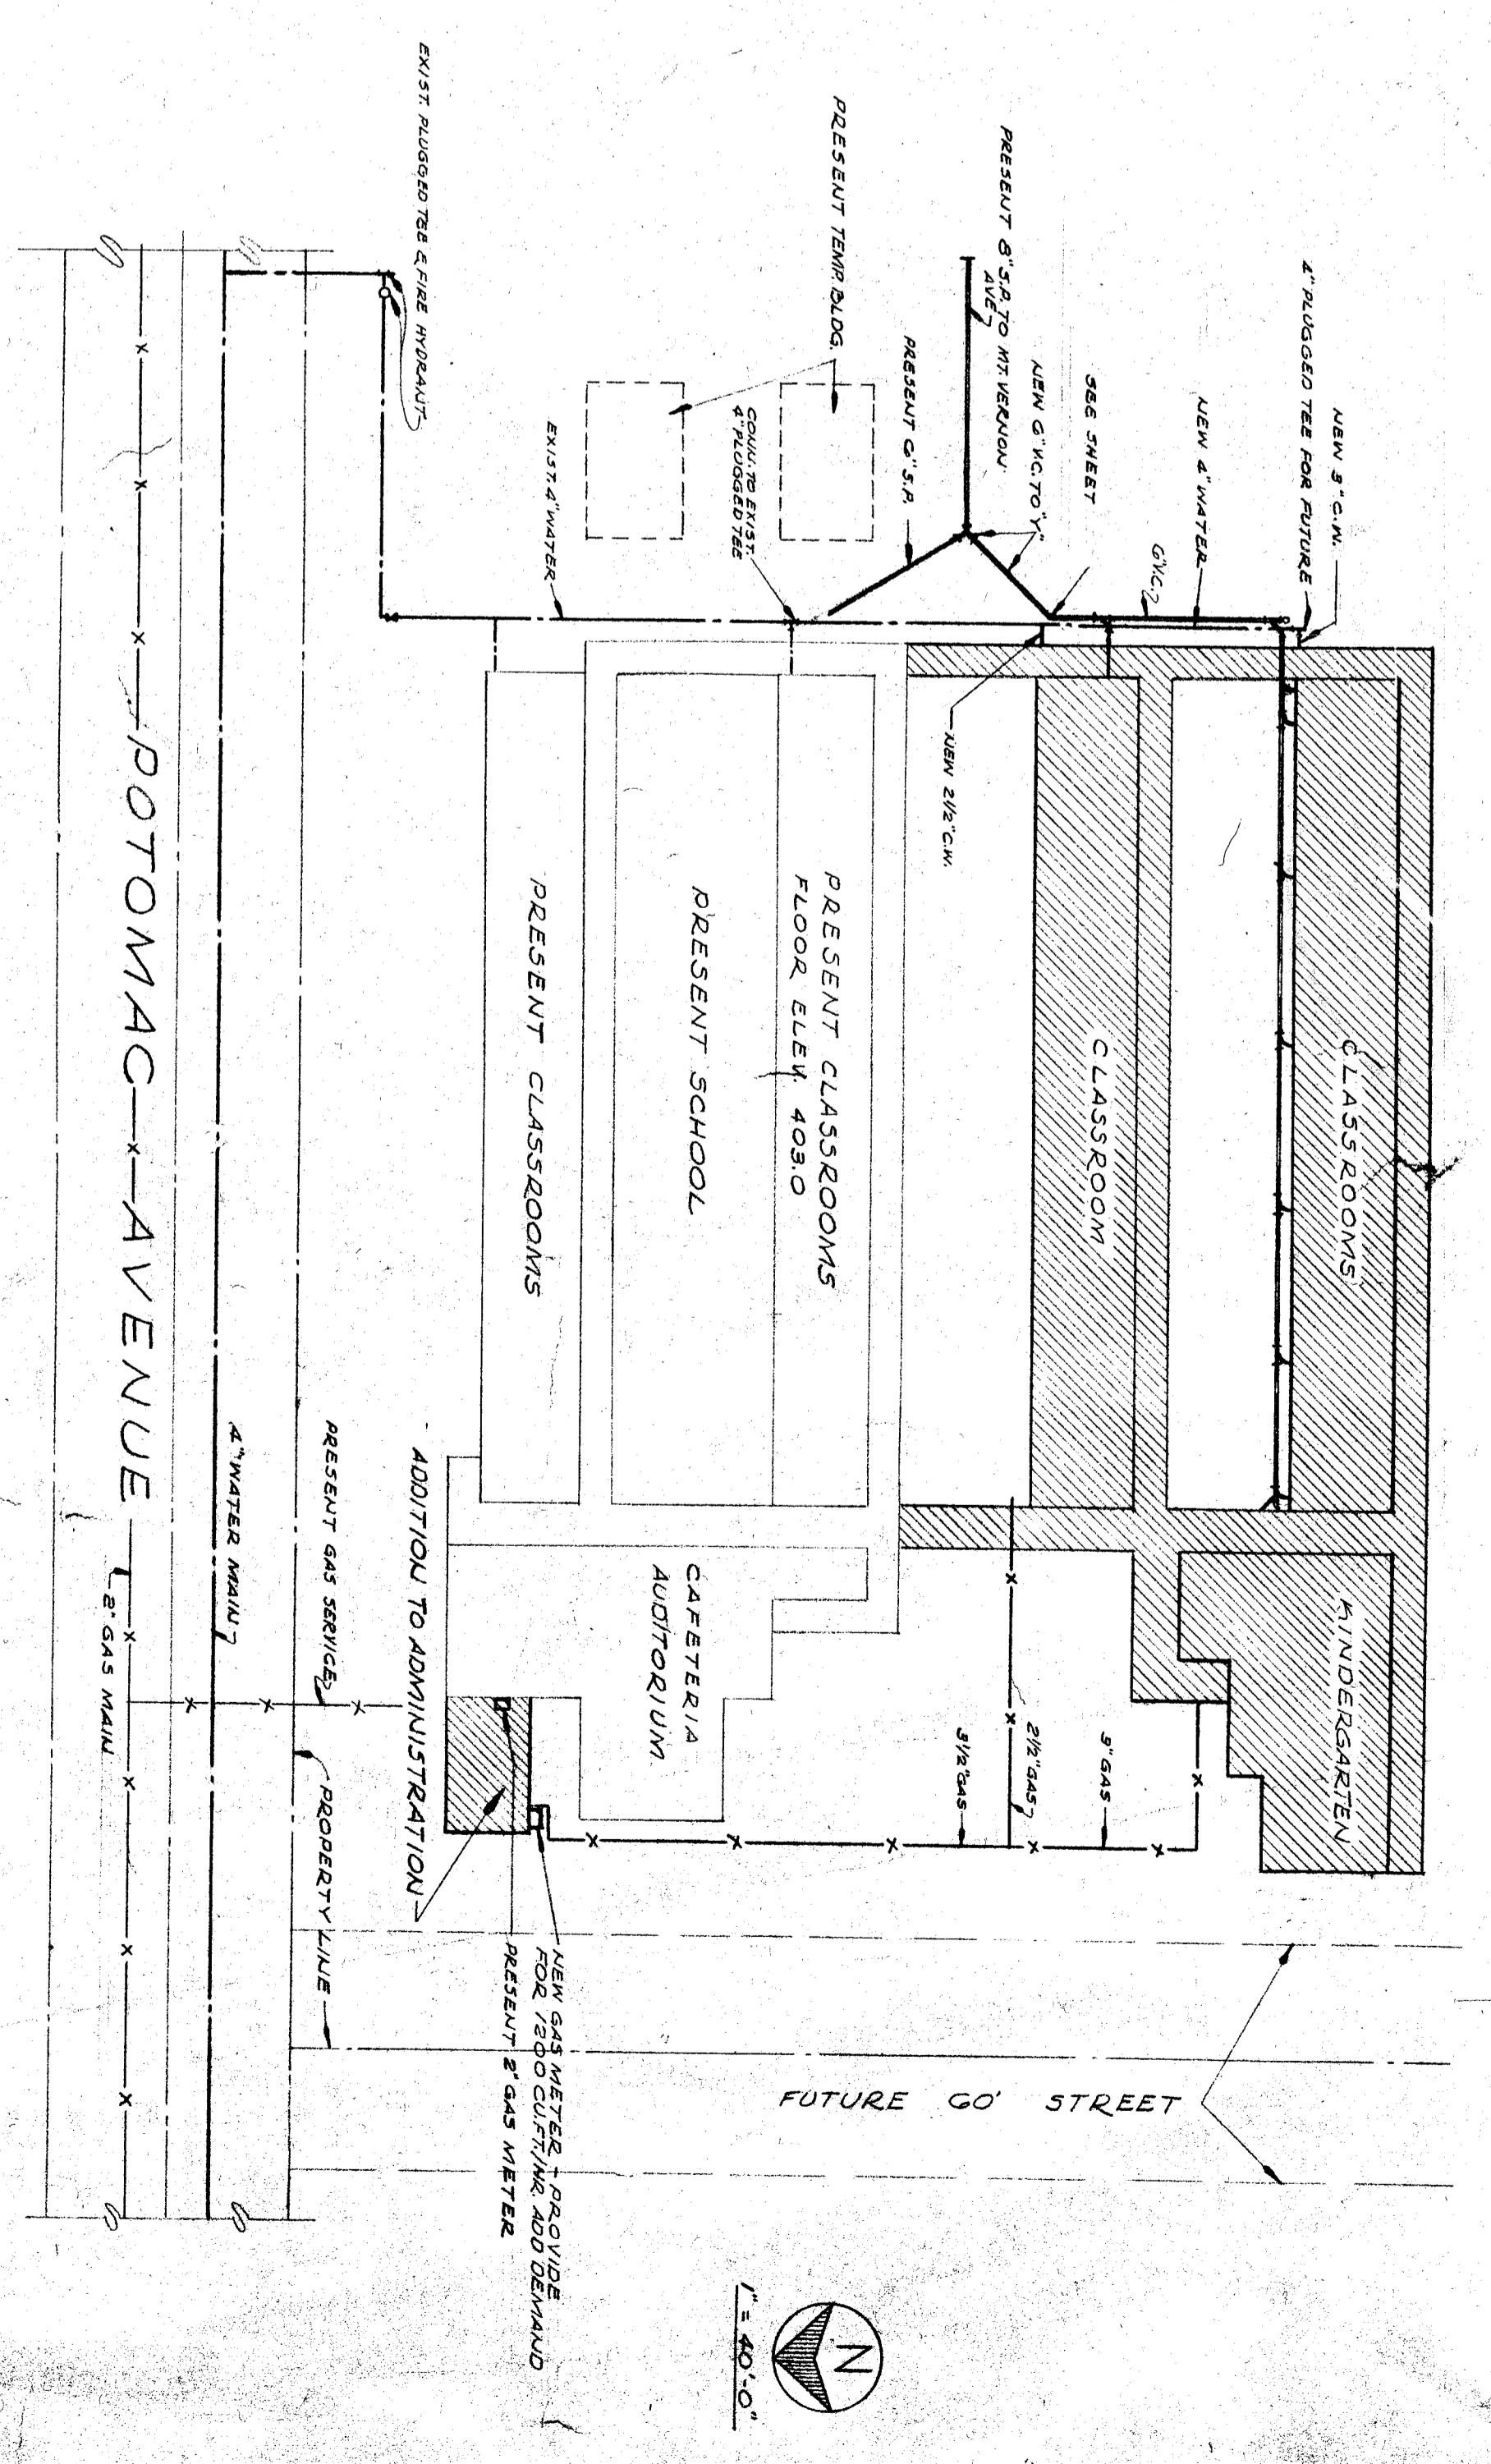

PLOT PLAN

STATE OF CALIFORNIA DEPARTMENT OF PUBLIC WORKS DIVISION OF ARCHITECTURE TITLE OF DRAWING: ADDITION TO ADMINISTRATION BUILDING & HEATING MOUNT VERNON SCHOOL ADDITION PROJECT NO.: 5616 DATE: 3-4-48		BAKERSFIELD CITY SCHOOL DISTRICT SUPERINTENDENT OF SCHOOLS RECOMMENDED FOR APPROVAL APPROVED: _____ DATE: _____	
ARCHITECT: WRIGHT METCALF & PARSONS 111 Broadway Building San Francisco, California		ENGINEER: WRIGHT METCALF & PARSONS 111 Broadway Building San Francisco, California	