 










LEGEND

-  T-BAR CEILING
-  FIELD INSTALLED PANEL AT MODULE LINE
-  2 x 4 RECESSED LIGHT FIXTURE
-  "OPTIONAL" 1 x 4 RECESSED LIGHT FIXTURE
-  SPLOY WIRE
-  CEILING MOUNTED SMOKE DETECTOR
-  ATTIC MOUNTED HEAT DETECTOR
-  SUPPLY AIR REGISTER
-  CEILING EXHAUST FAN

NOTE:
FOR ALL REFLECTED CEILING NOTES
SEE SHEET A-0.1

THESE DRAWINGS AND ALL MATERIAL CONTAINED HEREIN ARE THE PROPERTY OF SILVERCREEK INDUSTRIES, INC (SCI Inc) AND SHALL NOT BE REPRODUCED, COPIED OR OTHERWISE DISPOSED OF DIRECTLY OR INDIRECTLY AND SHALL NOT BE USED IN WHOLE OR IN PART TO ASSIST IN THE MAKING OF OR FOR THE PURPOSE OF FURNISHING ANY INFORMATION FOR THE MAKING OF DRAWINGS, PRINTS, APPARATUS OR PARTS THEREOF WITHOUT THE FULL KNOWLEDGE AND WRITTEN CONSENT OF SCI Inc. ALL PATENTABLE MATERIAL CONTAINED HEREIN AND ORIGINATING WITH SCI Inc SHALL BE THE PROPERTY OF SCI Inc.

SILVER CREEK INDUSTRIES, INC.

SILVER CREEK

195 EAST MORGAN PERRIS, CALIFORNIA 92571
PHONE: 951-948-8399 FAX: 951-948-2211

PROJECT NAME:

CLASS LEASING CLASSROOM BLDG'S

SHEET TITLE:
REFLECTED CEILING PLAN
36' x 40'

TAVARES

REGISTERED ARCHITECT

1222/2011

PROJECT SPECIFIC STATE AGENCY APPROVAL

IDENTIFICATION STAMP
DIV. OF THE STATE ARCHITECT
OFFICE OF REGULATION SERVICES

04 115892
AC: [Signature]
DATE: FEB 26 2015

PROJECT SPECIFIC STATE AGENCY APPROVAL

IDENTIFICATION STAMP
DIV. OF THE STATE ARCHITECT
OFFICE OF REGULATION SERVICES

04 115892
AC: [Signature]
DATE: APR 17 2015

ORIGINAL PC STATE AGENCY APPROVAL

IDENTIFICATION STAMP
DIV. OF THE STATE ARCHITECT
OFFICE OF REGULATION SERVICES

PC 04-112072
AC: [Signature]
DATE: DEC 3 2011

REVISIONS

SILVER CREEK INDUSTRIES
36' x 40' PC

PROJECT NO:
DRAWN BY:
SCALE: AS NOTED
DATE: 12-22-11


P.C. SHEET NUMBER
STW 140

T-BAR SCHEDULE

ARMSTRONG PART NUMBERS PA-041

MAIN RUNNER: 7301
4 CROSS TEE: XL7341
2 CROSS TEE: XL7328

STANDARD 7/8" WALL ANGLE WITH BERC-2 CLIP (ICC #E59-1300) 2"
WALL ANGLE: 7310 (OPTIONAL)

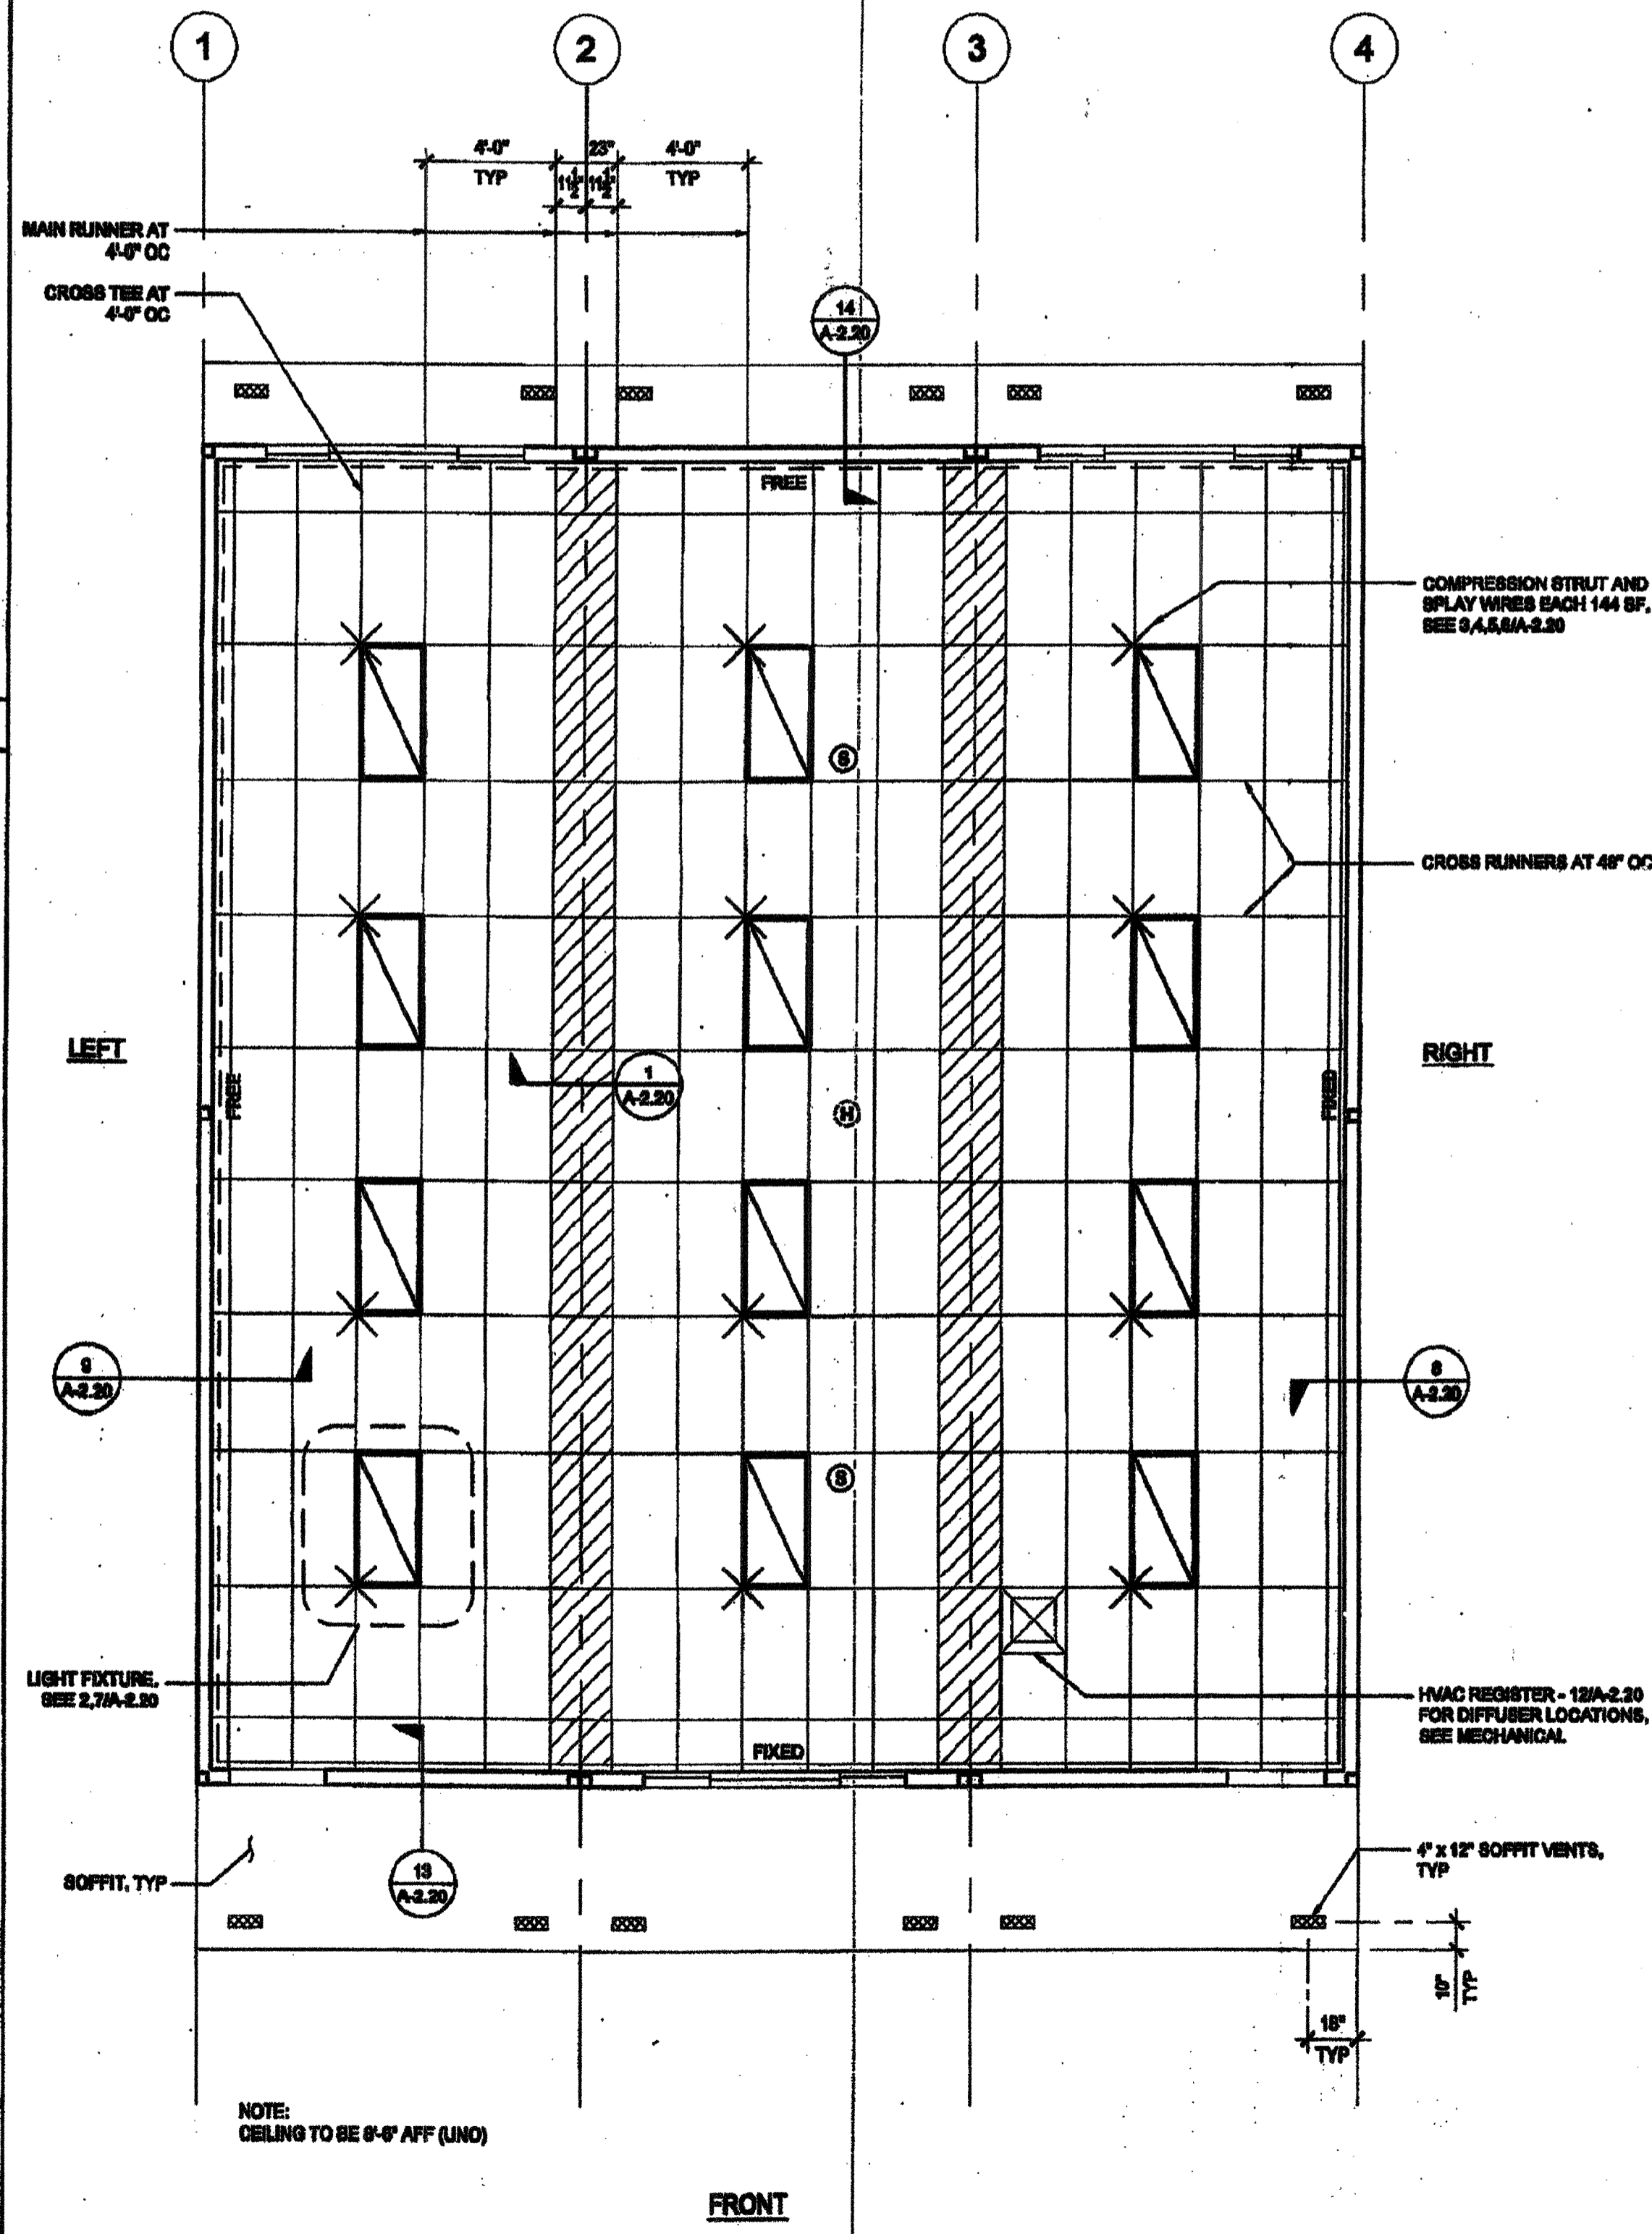

NOTE:
SEE CCD-1 FOR SITE
SPECIFIC
CONFIGURATION

NOT USED

NOT USED

3 REFLECTED CEILING PLAN SCALE: 1/4" = 1'-0" **1**