


**SITE PLAN - ELECTRICAL**  
**1 RELOCATABLE CLASSROOM**

SCALE : 1" = 30' - 0"

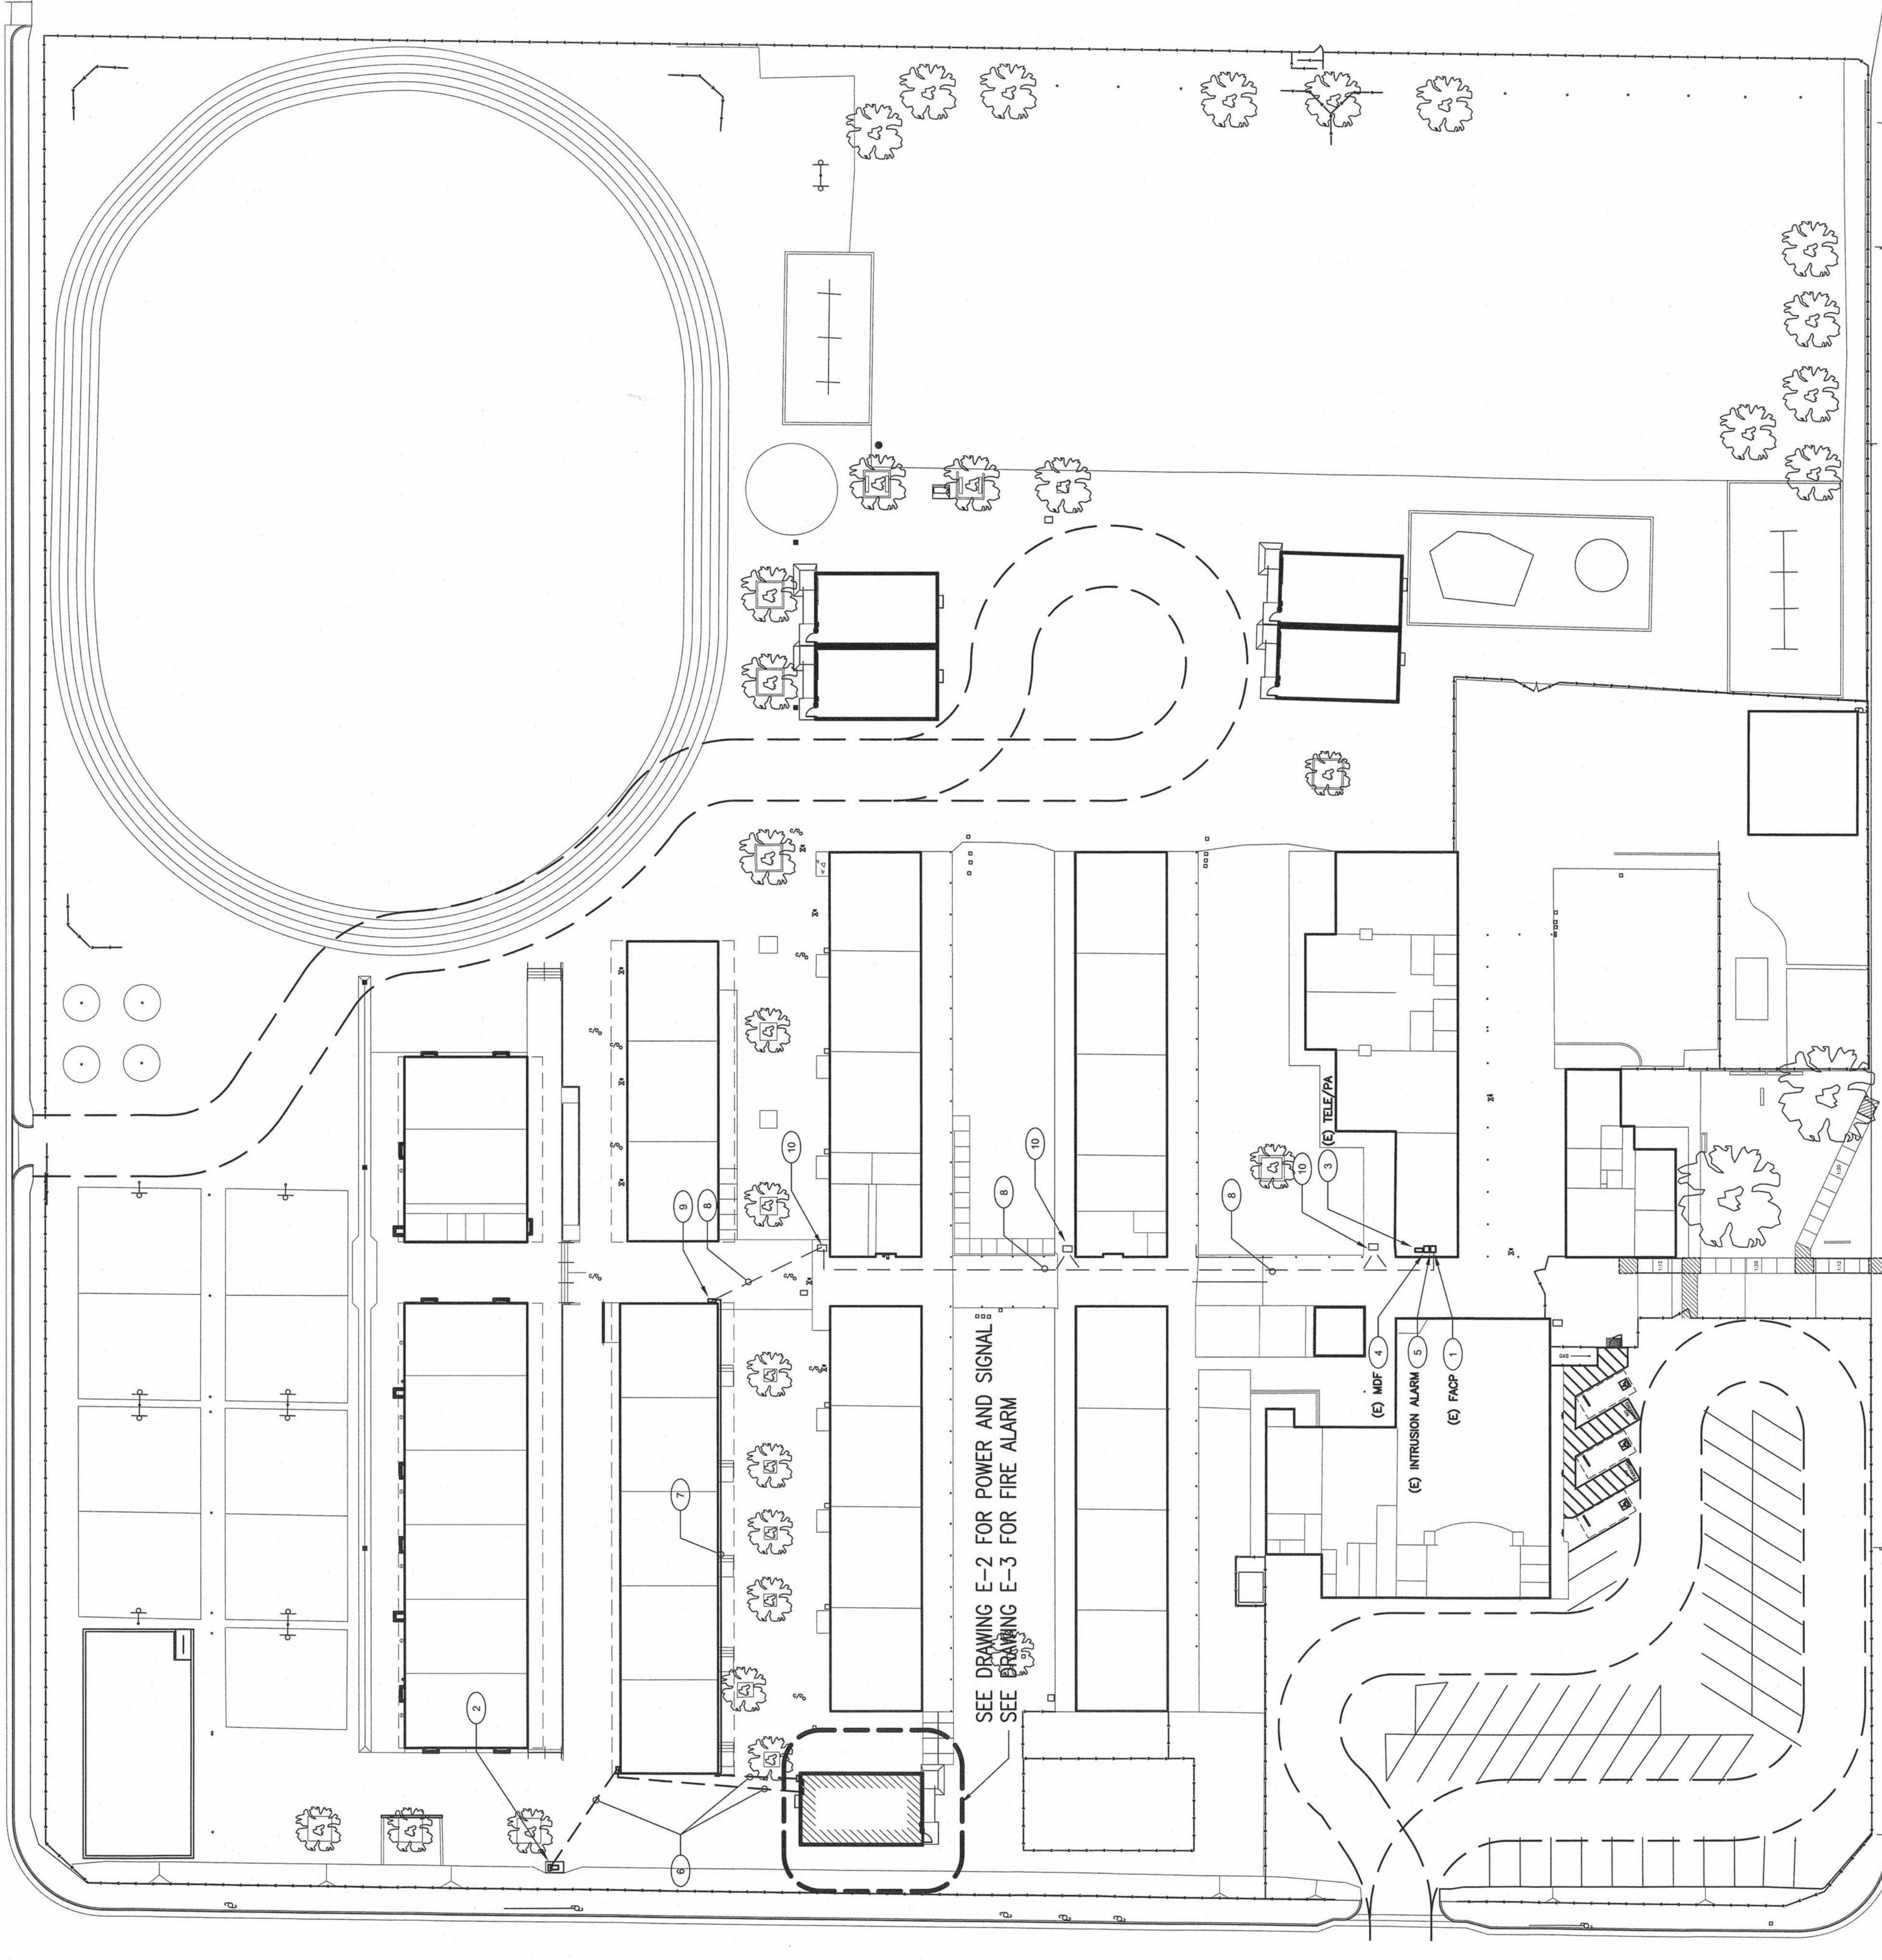

**SHEET NOTES**

1. APPROXIMATE LOCATION FOR EXISTING FIRE ALARM CONTROL PANEL AND TRANSFORMER. SEE DRAWING E-2 FOR FIRE ALARM EQUIPMENT. NEW FIRE ZONE MAP AND PROGRAM NEW DEVICES INFORMATION. MEASURE ACTUAL LAND CURRENT AND VOLTAGE DROP FOR EACH MIC SIGNAL DEVICES. REPORT TO OWNER AND ENGINEER FOR REVIEW AND PLASTIC LAMINATED ONE COPY INSIDE FACP CABINET DOOR.
2. APPROXIMATE LOCATION FOR EXISTING POWER PANEL AND TRANSFORMER. SEE DRAWING E-2 FOR POWER AND SIGNAL CONDUITS AND WIRING. SEE DRAWING E-2 & E-3 FOR MORE INFORMATION.
3. APPROXIMATE LOCATION FOR EXISTING PA/TELEPHONE EQUIPMENT IN CLASSROOM BUILDING PER PLANS. SEE SINGLE LINE DIAGRAM.
4. APPROXIMATE LOCATION FOR EXISTING COMPUTER AND SERVERS EQUIPMENT IN ADMIN OFFICE. PROVIDE CONNECTION FOR NEW DATA DEVICES PER PLANS.
5. APPROXIMATE LOCATION FOR EXISTING INTRUSION ALARM EQUIPMENT IN ADMIN OFFICE. PROVIDE CONNECTION FOR NEW INTRUSION ALARM DEVICES PER PLANS.
6. NEW UNDERGROUND POWER AND SIGNAL CONDUITS AND WIRING. SEE DRAWING E-2 & E-3 FOR MORE INFORMATION.
7. NEW SIGNAL TO ON EXTERIOR WILL SEE DRAWING E-2 & E-3 FOR MORE INFORMATION.
8. EXISTING UNDERGROUND SIGNAL CONDUITS, PULL BACK NEW SIGNAL WIRING PER PLANS, FIELD VERIFY LOCATION.
9. EXISTING SIGNAL TO ON EXTERIOR WILL FIELD VERIFY LOCATION.
10. EXISTING SIGNAL PULL BOX. FIELD VERIFY LOCATION.

(E) — INDICATE EXISTING CONDUIT AND WIRING FOR REFERENCE ONLY. FIELD VERIFY AS REQUIRED.

**SPECIAL NOTES:**

- A. SOURCE OF POWER HAS BEEN IDENTIFIED AND IS ADEQUATE FOR THE APPL LOADS.
- B. THE INTRUSION IS REPAIRABLE TO WITNESS & VERIFY GROUNDING TESTS.

**integrated designs** by SOMAM, Inc.  
ARCHITECTURE · ENGINEERING · INTERIOR DESIGN · CONSTRUCTION MANAGEMENT  
6011 N. Fresno, Suite 130 - Fresno, California 93710  
Phone (559) 435-0881 Fax (559) 435-0887  
www.integrateddesigns.com E-Mail: design@somam.com

**1 RELOCATABLE CLASSROOM**  
**PIONEER ELEMENTARY**  
BAKERSFIELD CITY SCHOOL DISTRICT  
4404 PIONEER DR., BAKERSFIELD, CA 93306

Project Name & Address:  
Issue Date: 00/00/14  
Date: 03/14/14  
Designer: J CHONG  
DR: J CHONG  
PC: JMF

Agency Approval Stamp:  
IDENTIFICATION STAMP  
BY: OF THE STATE ARCHITECT  
APPROS 116740  
AC: FRS  
DATE: MAY 14 2014

Stamp(s):  
Job No.: **5117**  
Sheet No.: **E-1**  
Professional Engineer Seal: JOHN S. CHONG, E 14419, Exp. 6/30/2014, License No. 1071, State of CA

Ownership of Documents:  
This document, the ideas and designs incorporated herein, as an instrument of service, shall remain the property of Integrated Designs by SOMAM, Inc. and is not to be used, in whole or in part for any other project without written authorization.  
© COPYRIGHT 2013

3/18/2014 3:25:53 PM