


1 NEW PORTABLE GROUP FIRE ALARM FLOOR PLANS
SCALE: 1/8"=1'-0"

INPUT	OUTPUT						
	DISPLAY GENERAL ALARM FACP	INDICATE ZONE AT FACP	DISPLAY SUPERVISION SIGNAL AT FACP	ACTIVATE NOTIFICATION APPLIANCES	NOTIFY UL APPROVED MONITORING STATION	ACTIVATE FACP AUDIBLE ALARM	DISPLAY TROUBLE AT FACP
HEAT DETECTOR	•	•		•	•	•	•
SMOKE DETECTOR	•	•		•	•	•	•

CABLE LEGEND	
A = (2) #12	
H = (2) #12	
S = (2) #12	

ALL UNDERGROUND CABLES SHALL BE LISTED FOR SUCH USE.

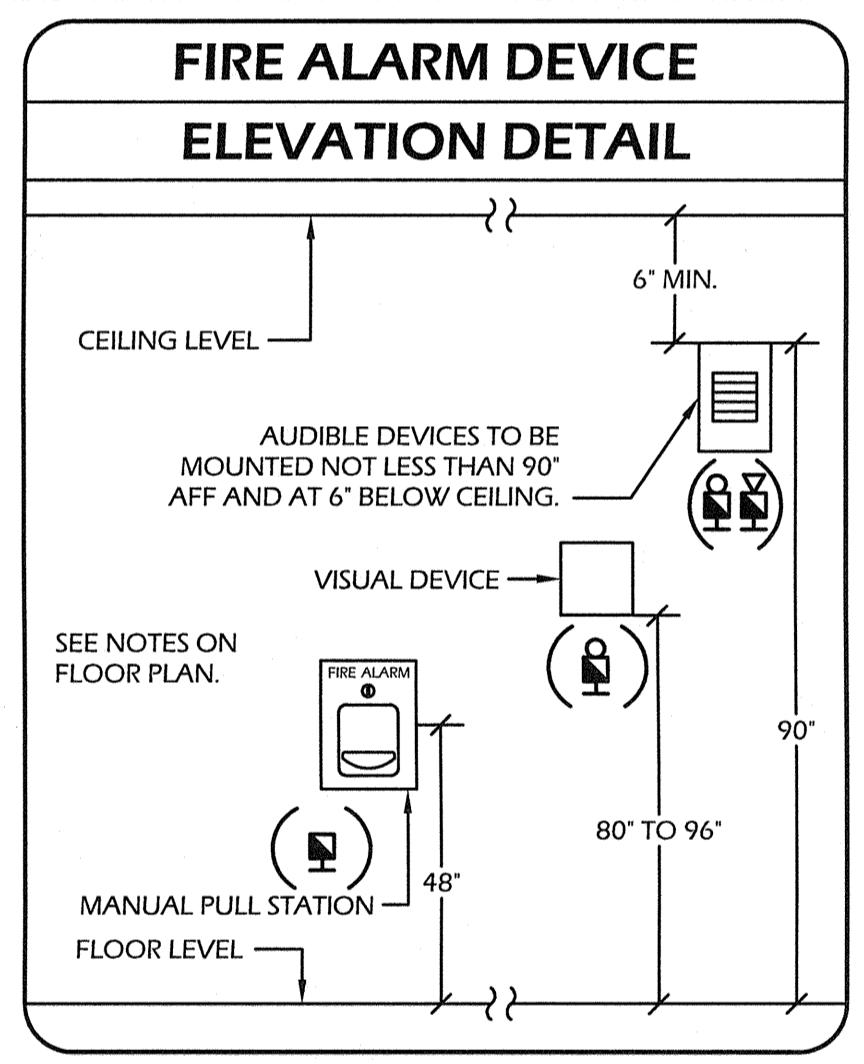

Ownership of Documents
This document, the ideas and designs incorporated herein, as an instrument of Professional Service is the property of Integrated Designs by SOMAM Inc. and is not to be used, in whole or in part for any other project without written authorization.
© COPYRIGHT 2010


integrated designs by SOMAM, Inc.
ARCHITECTURE • INTERIOR DESIGN • CONSTRUCTION MANAGEMENT
601 N. Fremont Suite 330 - Fresno, California 93710
Phone (559) 335-0881 Fax (559) 435-0887 E-Mail: design@somam.com
www.integrateddesigns.com

Rev. Date: _____
Revision Description: _____

Sheet Title: **PORTABLE GROUP FIRE ALARM FLOOR PLANS**
Project Name & Address: **PIONEER DRIVE ELEMENTARY SCHOOL 5 PERMANENT MODULAR CLASSROOMS**
BAKERSFIELD CITY SCHOOL DISTRICT
4404 PIONEER DRIVE, BAKERSFIELD, CA 93306

Issue Date: _____
Date: _____
Designer: _____
DR: _____
PC: _____

DSA Identification Stamp:
FILE #: 15-6
IDENTIFICATION STAMP
DIV. OF THE STATE ARCHITECT
OFFICE OF REGULATION SERVICES
08-113549
AC: [Signature]
DATE: 9/2/2010
TRACKING #: -

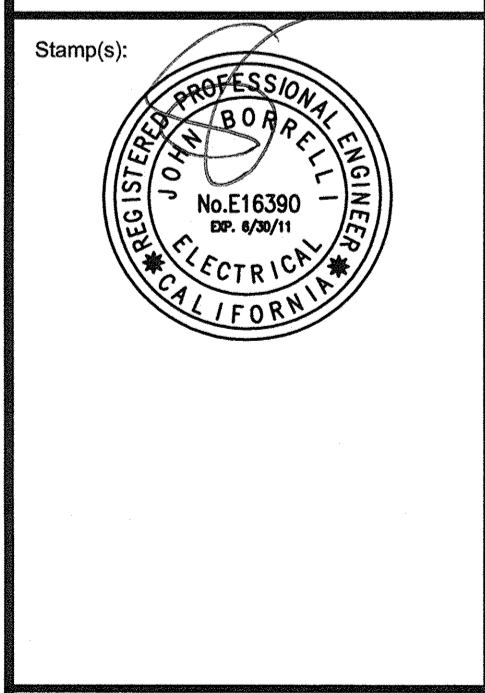

Job No.: **3862**
Sheet No.: **E3.2**
Release: _____

BORRELLI AND ASSOCIATES, INC.
CONSULTING ELECTRICAL ENGINEERS
1800 N. ECHO AVENUE
FRESNO, CALIFORNIA 93704
PH: 559-253-4138 FAX: 559-253-4334
BORN 1937
HTTP://WWW.BORRELLIENGINEERING.COM
E-MAIL: ADMIN@BORRELLIENGINEERING.COM