

NOTES

- FOR WALL MOUNTED HVAC UNIT, PROVIDE OPENING THROUGH REAR ROOF HEADER WHERE IT OCCURS. SEE FLOOR PLAN FOR HVAC LOCATION. SEE 5, 16 / 8-2.00 OR 5, 16 / 8-2.51 FOR DETAILS.
- OPTIONAL PURLIN FOR FIRE SPRINKLER LINE AS NEEDED. LOCATION OF FIRE SPRINKLER PURLIN TO BE DETERMINED BY SITE STIFFENER PLATE OR ANGLE BRACE REQUIRED AT THIS LOCATION. FOR FIRE SPRINKLER LINE SIDE BEAM PENETRATION, SEE 14 / 8-2.00 OR 14 / 8-2.51 DETAILS.
- FOR OPTIONAL SIDE BEAM OPENING SEE 10, 15/8-2.00 OR 10, 15/8-2.51 FOR DETAILS.

THESE DRAWINGS AND ALL MATERIAL CONTAINED HEREIN ARE THE PROPERTY OF SILVERCREEK INDUSTRIES, INC (SCI Inc) AND SHALL NOT BE REPRODUCED, COPIED OR OTHERWISE DISPOSED OF DIRECTLY OR INDIRECTLY AND SHALL NOT BE USED IN WHOLE OR IN PART TO ASSIST IN THE MAKING OF OR FOR THE PURPOSE OF FURNISHING ANY INFORMATION FOR THE MAKING OF DRAWINGS, PRINTS, APPARATUS OR PARTS THEREOF WITHOUT THE FULL KNOWLEDGE AND WRITTEN CONSENT OF SCI Inc. ALL PATENTABLE MATERIAL CONTAINED HEREIN AND ORIGINATING WITH SCI Inc SHALL BE THE PROPERTY OF SCI Inc



SILVER CREEK INDUSTRIES, INC.



175 EAST MORGAN FERRIS, CALIFORNIA 92571
PHONE: 951-943-5393 FAX: 951-943-2211

CLASS LEASING CLASSROOM BLDG'S

ROOF FRAMING PLAN 0.018", B.U.R., OR TPO MONO SLOPE

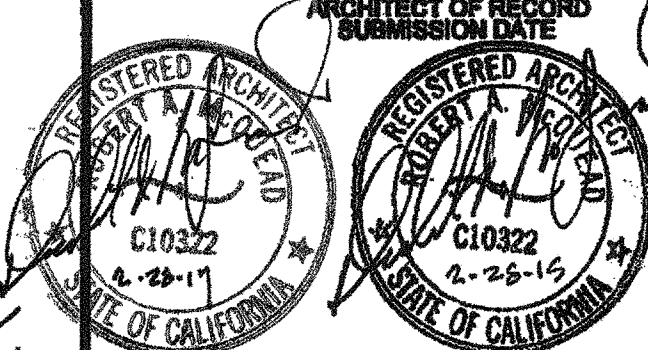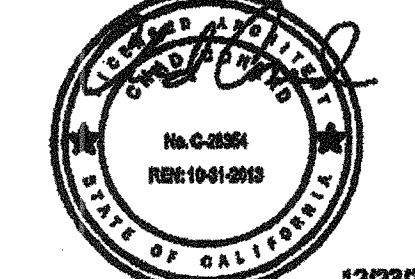

REVISED
FEB 26 2015
IDENTIFICATION STAMP
DIV. OF THE STATE ARCHITECT
OFFICE OF REGULATION SERVICES
04 113892
NOV 20 2014

IDENTIFICATION STAMP
DIV. OF THE STATE ARCHITECT
OFFICE OF REGULATION SERVICES
04 111
APR 23 2015

PROJECT SPECIFIC STATE AGENCY APPROVAL
IDENTIFICATION STAMP
DIV. OF THE STATE ARCHITECT
OFFICE OF REGULATION SERVICES
04-112072
APR 08 2016

ORIGINAL STATE AGENCY APPROVAL
IDENTIFICATION STAMP
DIV. OF THE STATE ARCHITECT
OFFICE OF REGULATION SERVICES
04-112072
APR 08 2016

REVISIONS

SILVER CREEK INDUSTRIES
24' x 40' PC

PROJECT NO: _____
DRAWN BY: _____
SCALE: AS NOTED
DATE: 12-23-11
P.C. SHEET NUMBER: **S-2.01**

STKP 140

ROOF FRAMING PLAN