




1

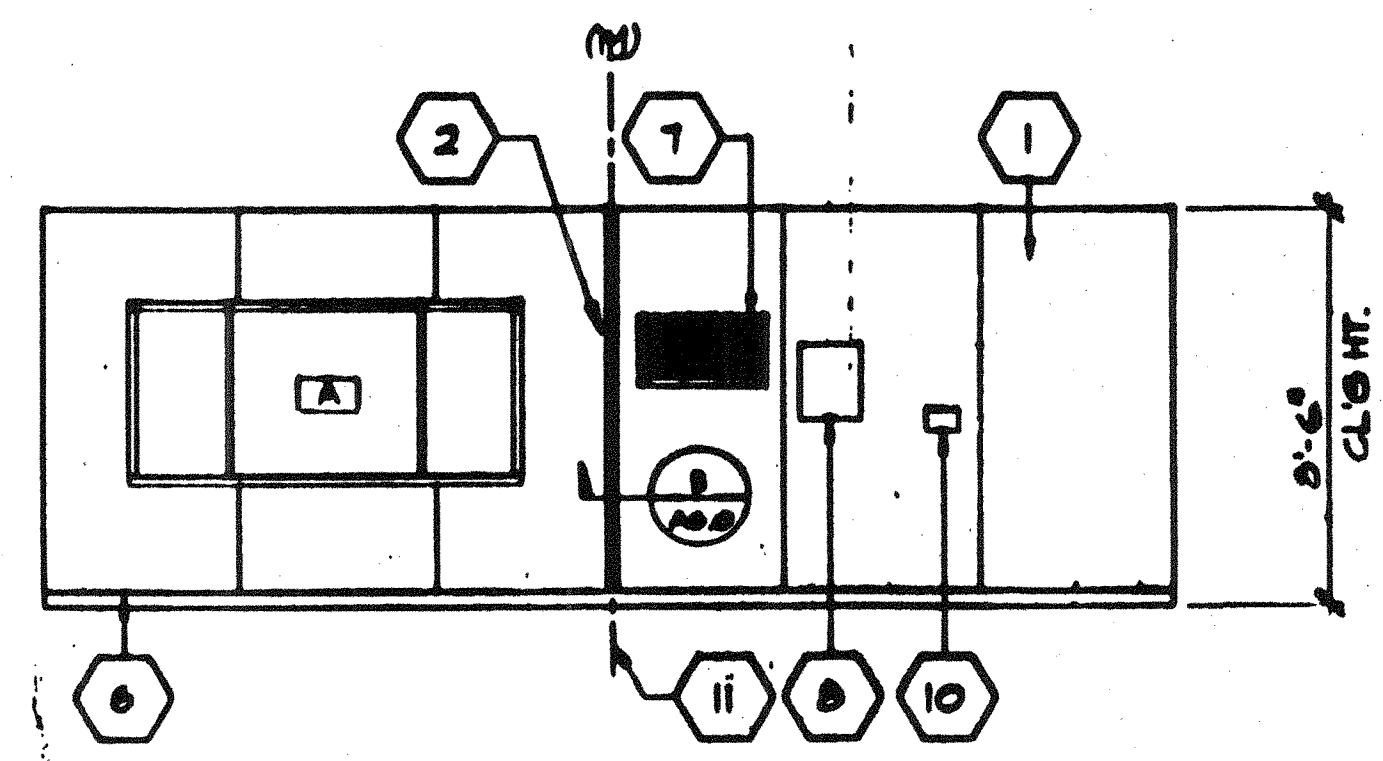

2

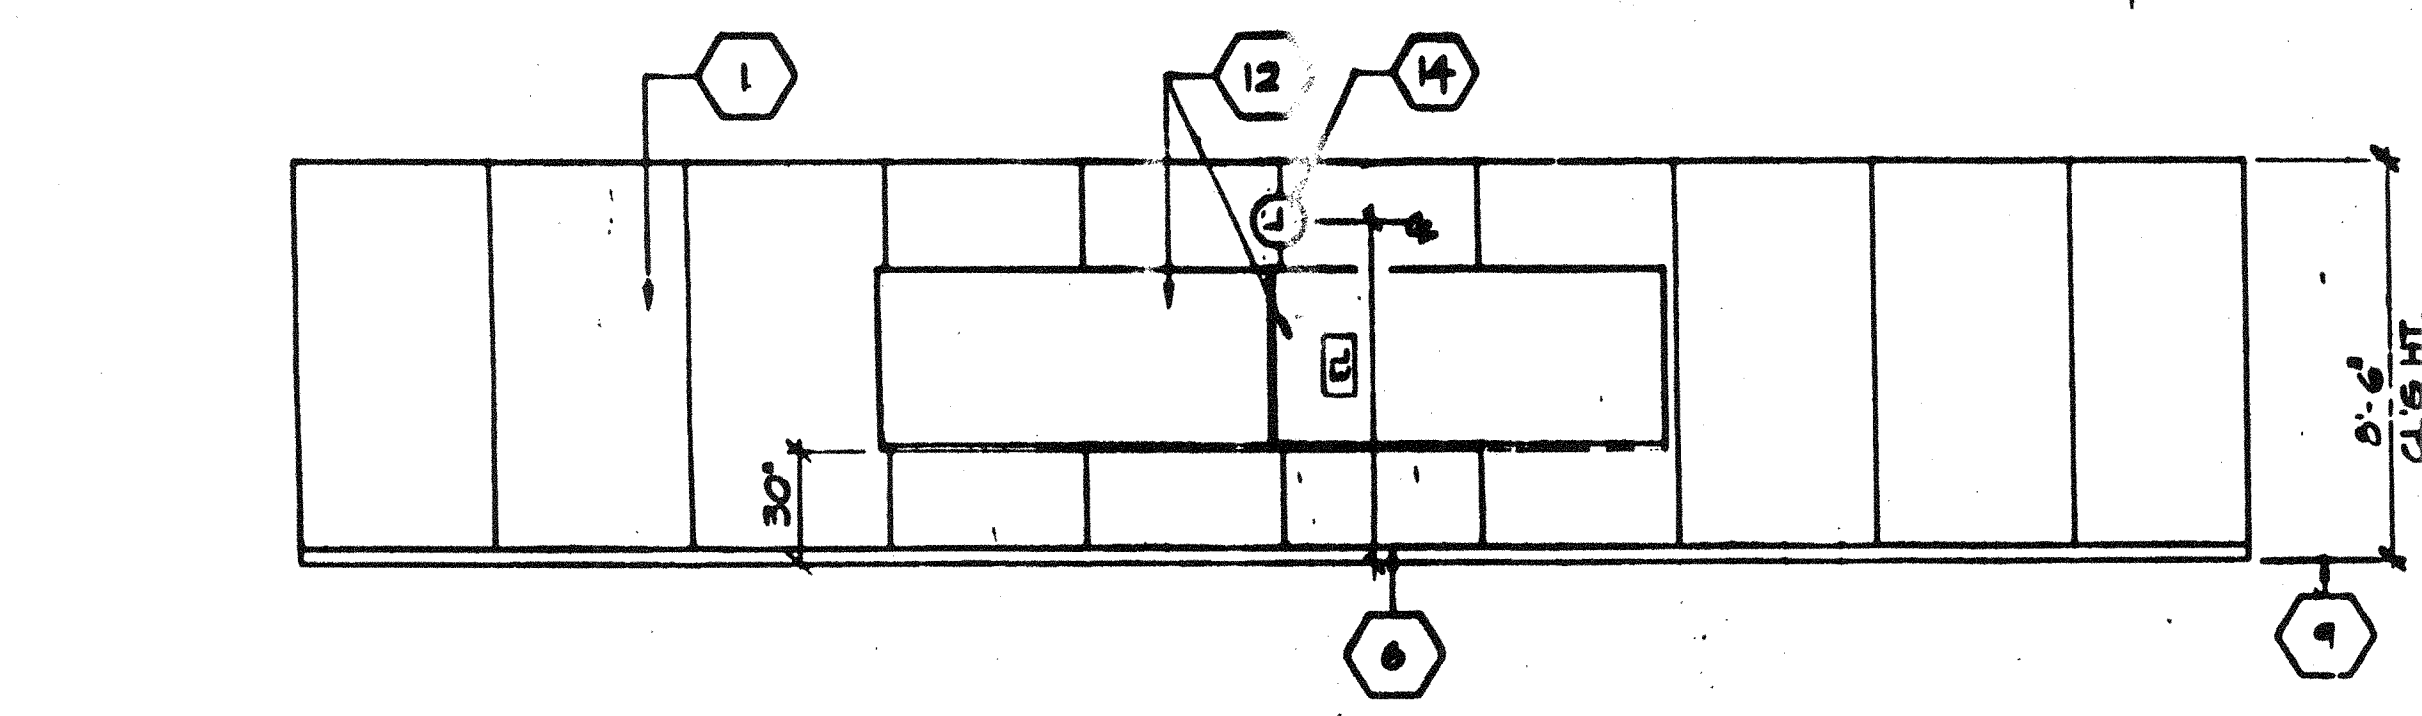

3

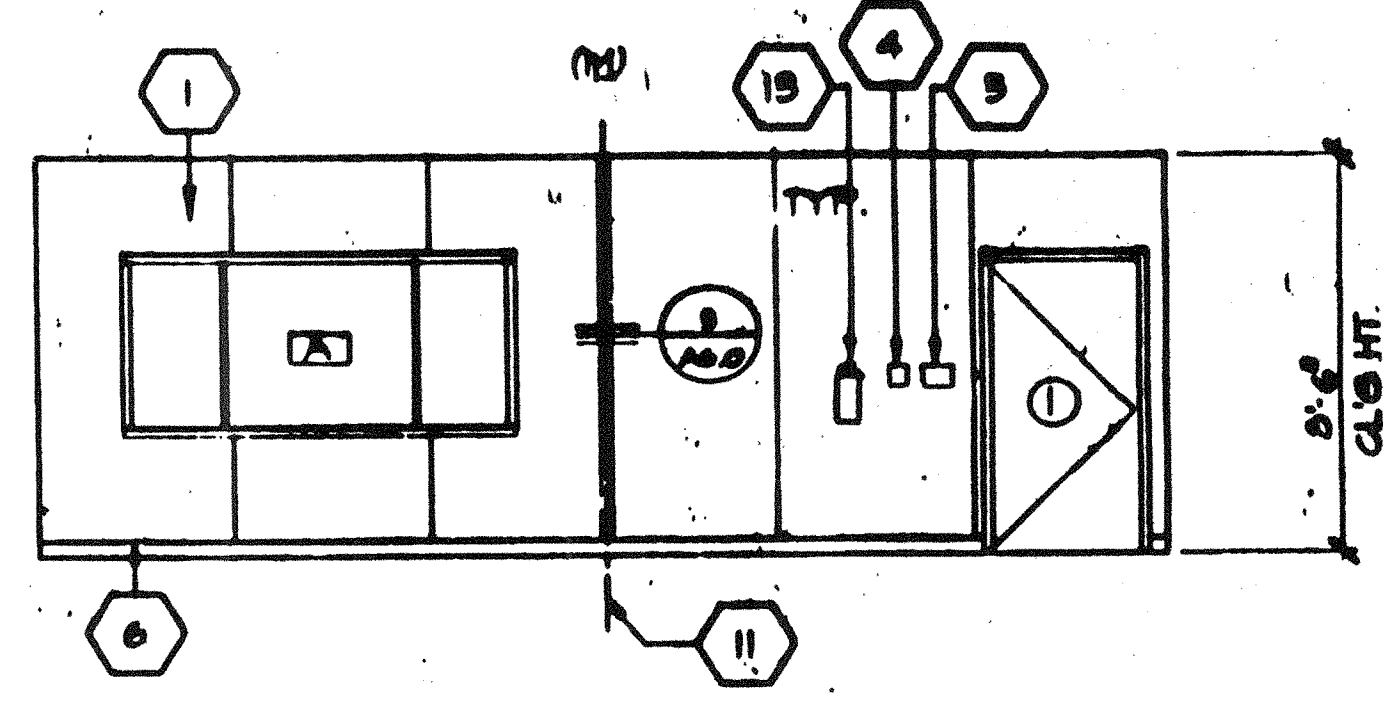

4



"A" SHOWN  
"B" OPPOSITE

INTERIOR ELEVATIONS (24' x 40')

SCALE 1/4"=1'-0"

KEY NOTES

- 1 TYPICAL INTERIOR FINISH (SEE FINISH SCHEDULE 547 A5 C)
- 2 CLOSURE AT MODULAR JOINT
- 3 DUPLEX WALL RECEPTACLE (FCI)
- 4 FIRE ALARM FULL STATION
- 5 LIGHT SWITCH
- 6 TOP SET BASE (TYPICAL) SEE FINISH SCHED
- 7 RETURN AIR GRILL
- 8 ELECTRICAL PANEL (EL)
- 9 FINISH FLOOR
- 10 THERMOSTAT (HV)
- 11 MODULAR JOINT
- 12 8040 MARKBOARD
- 13 FIRE EXTINGUISHER, 5LBS. DRY CHEMICAL WITH 2A-10BC UL RATING ON WALL MTD BRACKET. HANDLE AT 48" A.F.F.
- 14 12" DIA ELECTRIC CLOCK

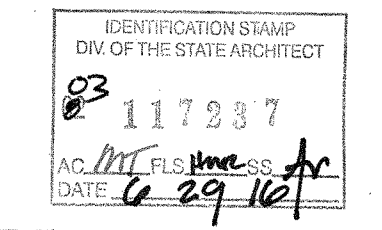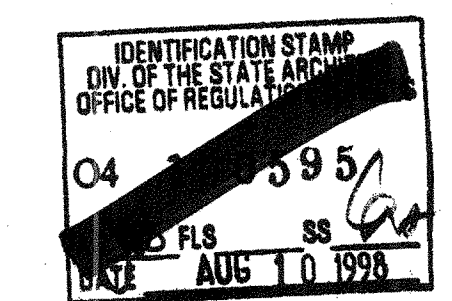

NOTE:  
SEE ELECTRICAL PLAN FOR MOUNTING HEIGHTS

STKP-39

ARCHITECT

ELECTRICAL




STRUCTURAL

MECHANICAL

FIRE MARSHAL

ACCESS COMPLIANCE

STRUCTURAL SAFETY

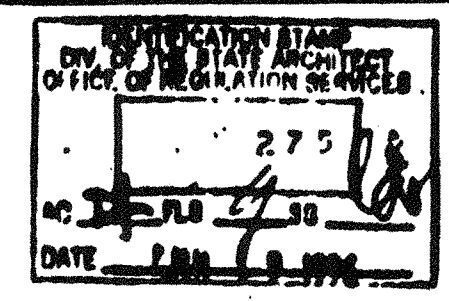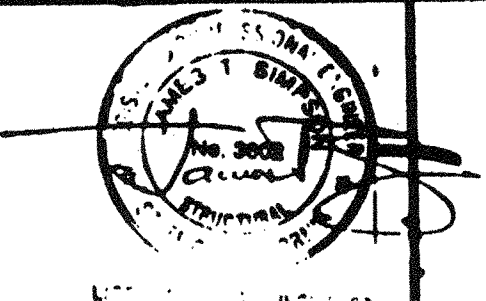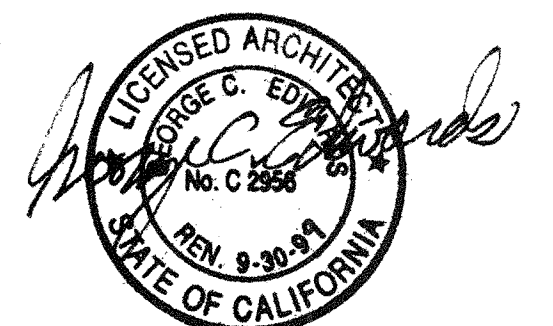

INTERIOR ELEVATIONS

2926

4012-084

DATE 2867  
DATE 2926

A4.0