



**COPYRIGHT:**  
 Any reproduction or distribution for any purpose other than authorized by IBI Group is forbidden.  
**COPYRIGHT 2014 IBI GROUP**

REVISIONS			
NO.	DATE	APPRD.	DESCRIPTION

CONSULTANT  
**JMPE**  
 ELECTRICAL ENGINEERING  
 LIGHTING DESIGN  
 CA REGISTRATION NO. E13083  
 16136  
 5500 MING AVENUE,  
 SUITE 201  
 BAKERSFIELD, CA 93309  
 (805) 831-7805  
 FAX (805) 831-7813  
 email: jmloney@jmpe.net  
 www.jmpe.net

AGENCY INFORMATION:  
 AGENCY TRACKING NO. 63321-212  
 FILE NO. 15-6  
 IDENTIFICATION STAMP  
 DIV. OF THE STATE ARCHITECT  
 OFFICE OF REGULATION SERVICES  
 03-117283  
 AC. FLS. 03/20/16  
 DATE SEP 14 2016

**BAKERSFIELD CITY SCHOOL DISTRICT**  
  
**CHIPMAN JR. HIGH  
 RELOCATABLES R-6 & R-7**  
 2905 EISSLER ST  
 BAKERSFIELD, CA 93306


OPSC or OSHPD PROJ. NO:	18132.000
PROJECT NO:	18132.000
DRAWN BY:	AC
CHKD BY:	WR
ISSUE DATE:	06/22/2016

SHEET TITLE  
**ELECTRICAL  
 PARTIAL SITE  
 PLAN**

SHEET NUMBER  
**E-1**

**ELECTRICAL PARTIAL SITE PLAN NOTES**

- 1 ADD (2)(N) 100/2 BREAKERS INTO PANEL DP-1.
- 2 PROVIDE NEW EMERGENCY EGRESS LIGHT. ISOLITE #ELED-EM-BZ; MOUNT IN CENTER OF FRONT EXTERIOR WALL AS SHOWN. CONNECT TO (E) UNSWITCHED LIGHT CIRCUIT IN ATTIC ABOVE T-BAR CEILING. FIELD VERIFY WALL PENETRATION TO BE ABOVE T-BAR AND BELOW BUILDING STEEL
- 3 EXISTING LIGHT TO REMAIN.

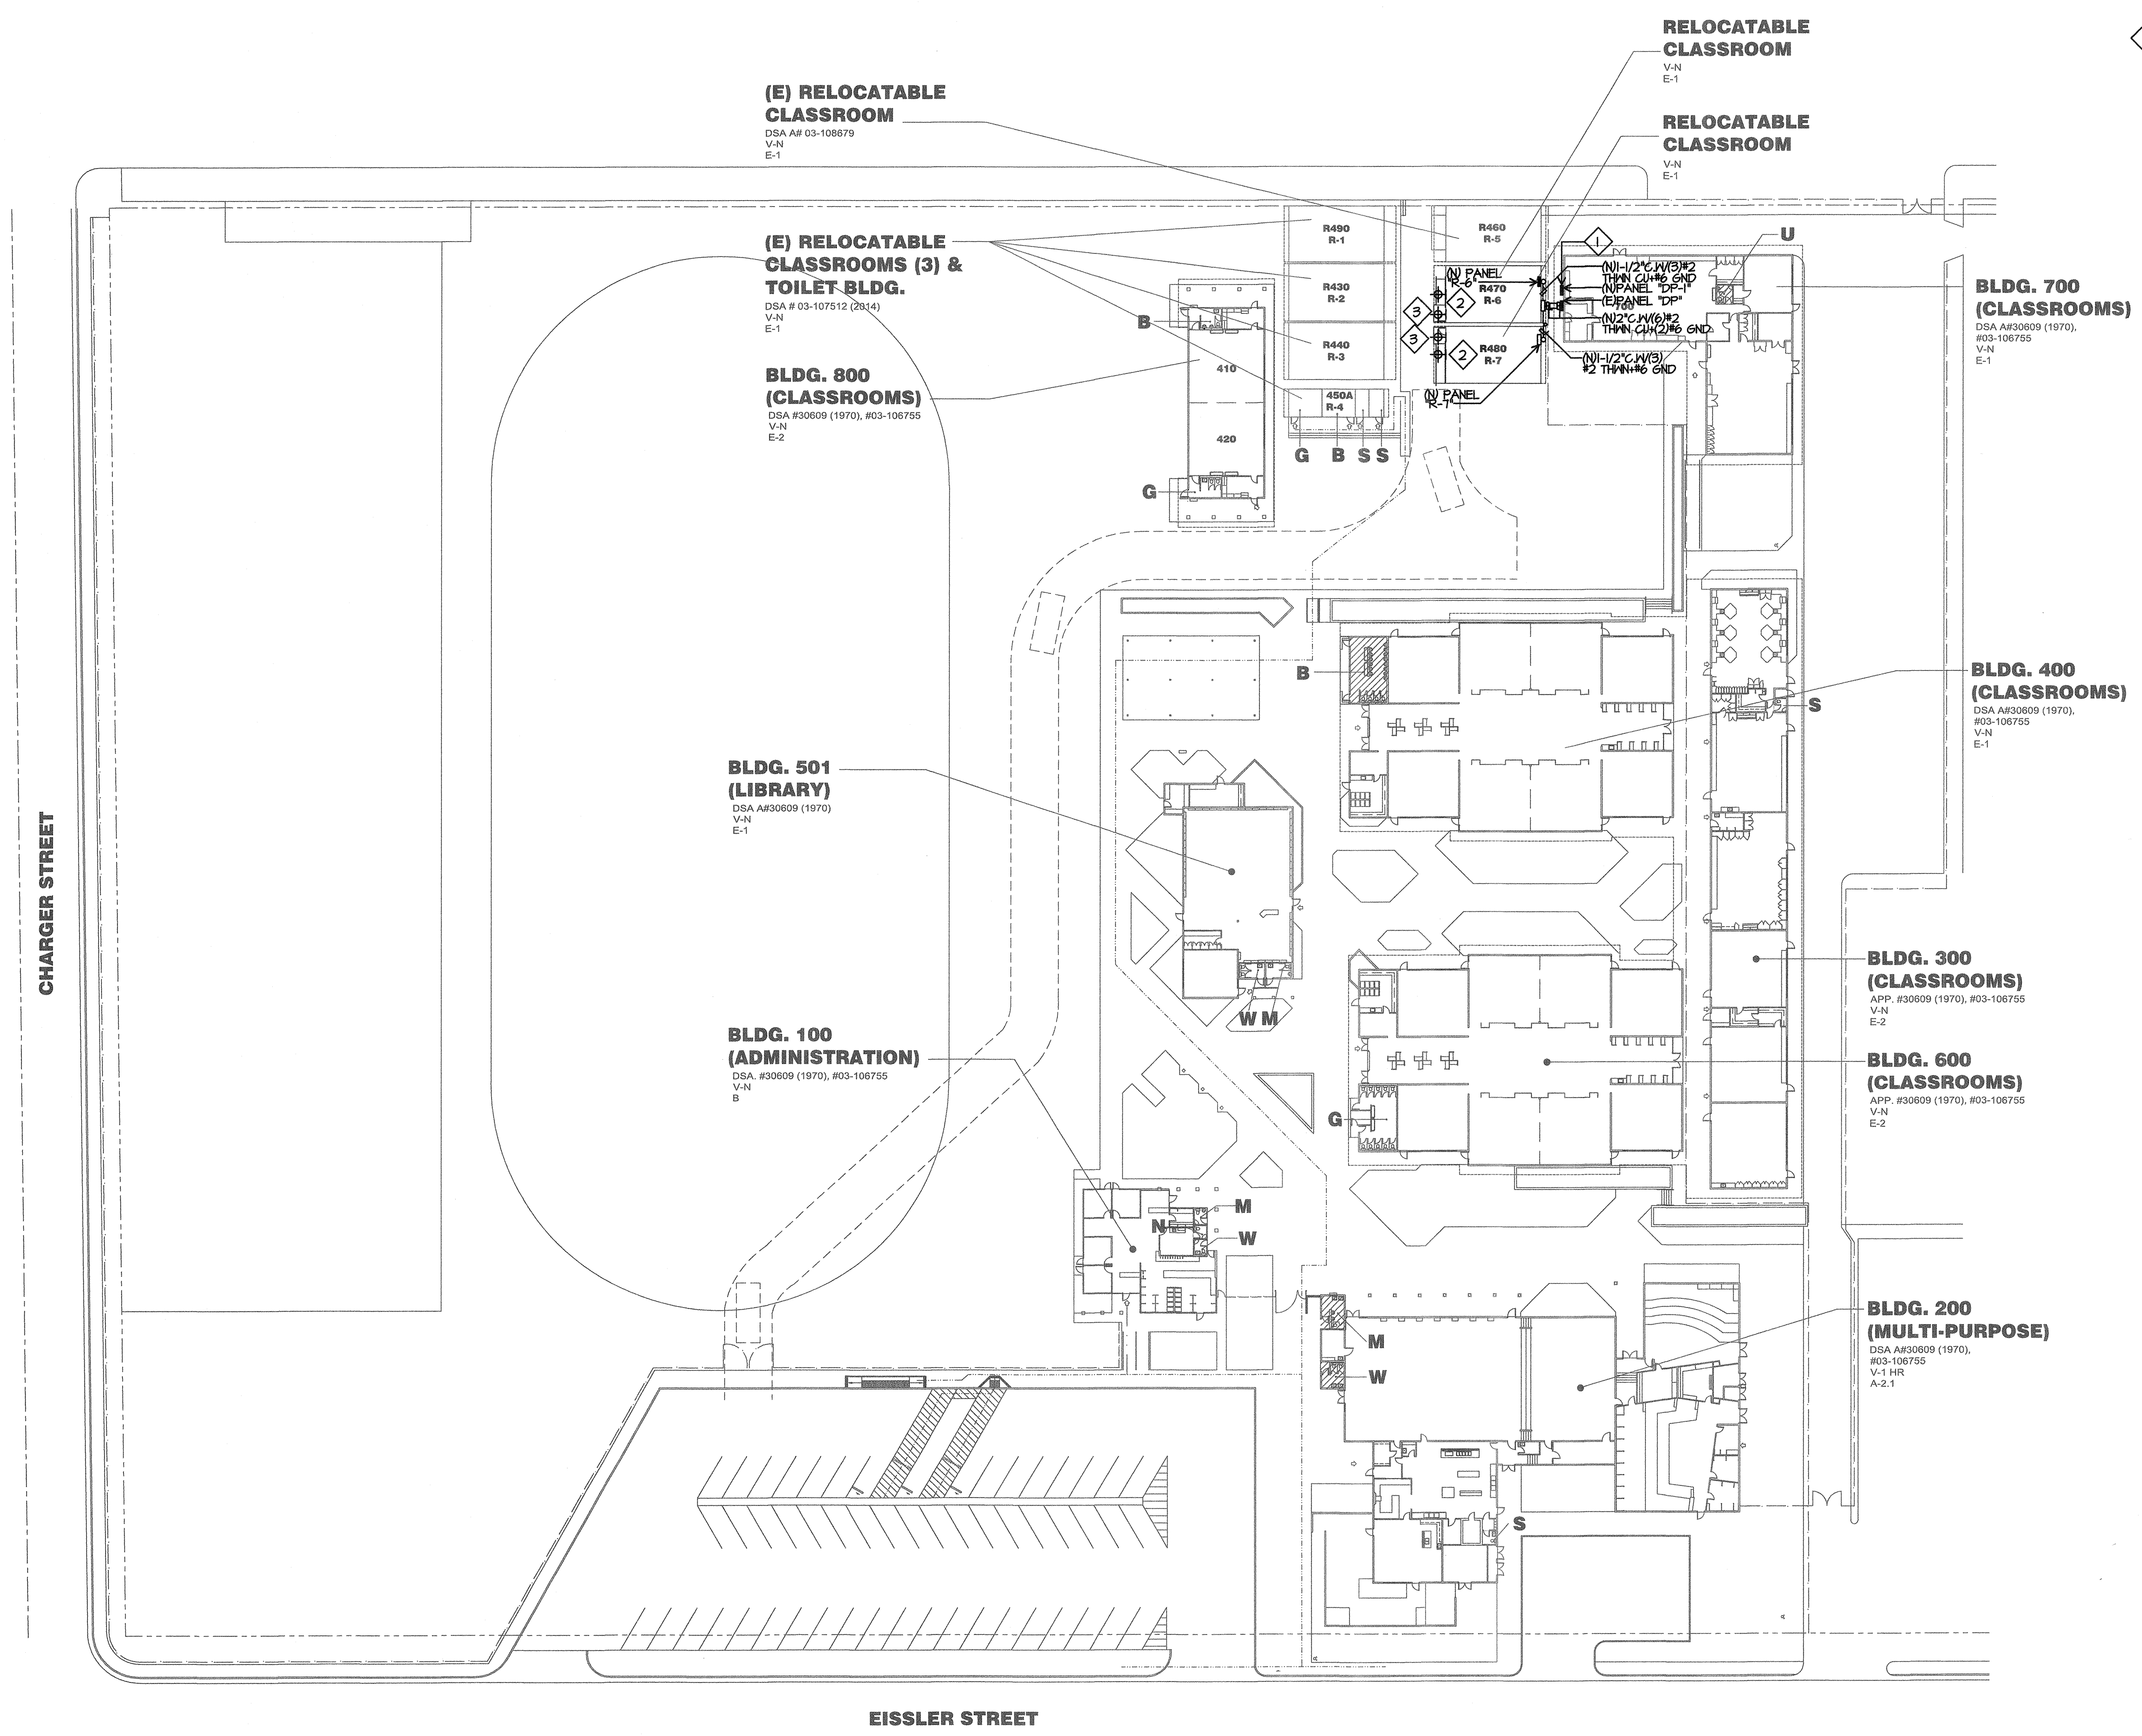

ELECTRICAL PARTIAL SITE PLAN

SCALE: 1"=40'-0"