

COPYRIGHT:
 Any reproduction or distribution for any purpose other than authorized by IBI Group is forbidden.
 COPYRIGHT 2014 IBI GROUP

REVISIONS			
NO.	DATE	APPRD.	DESCRIPTION

CONSULTANT
JMPE
 ELECTRICAL ENGINEERING
 LIGHTING DESIGN
 CA REGISTRATION NO. E13089
 14223
 5500 MING AVENUE,
 SUITE 201
 BAKERSFIELD, CA 93309
 (805) 851-7951
 FAX (805) 851-7913
 email: malouey@jmpe.net
 www.jmpe.net

AGENCY INFORMATION:
 AGENCY TRACKING NO. 63321-154
 FILE NO. 15-6
 IDENTIFICATION STAMP
 DIV. OF THE STATE ARCHITECT
 OFFICE OF REGULATION SERVICES
 03-117035
 AC FLS SS
 DATE 6/28/2016


BAKERSFIELD CITY SCHOOL DISTRICT

CHIPMAN JR. HIGH SCHOOL (2)
RELOCATABLES
 2905 EISSLER STREET
 BAKERSFIELD, CA 93306

OPSC or OSHPD PROJ. NO:	
PROJECT NO:	14146.000
DRAWN BY:	AC
CHKD BY:	KT
ISSUE DATE:	04/27/2016

SHEET TITLE
**DATA/COMM.
 PARTIAL
 SITE PLAN**

SHEET NUMBER
E-3

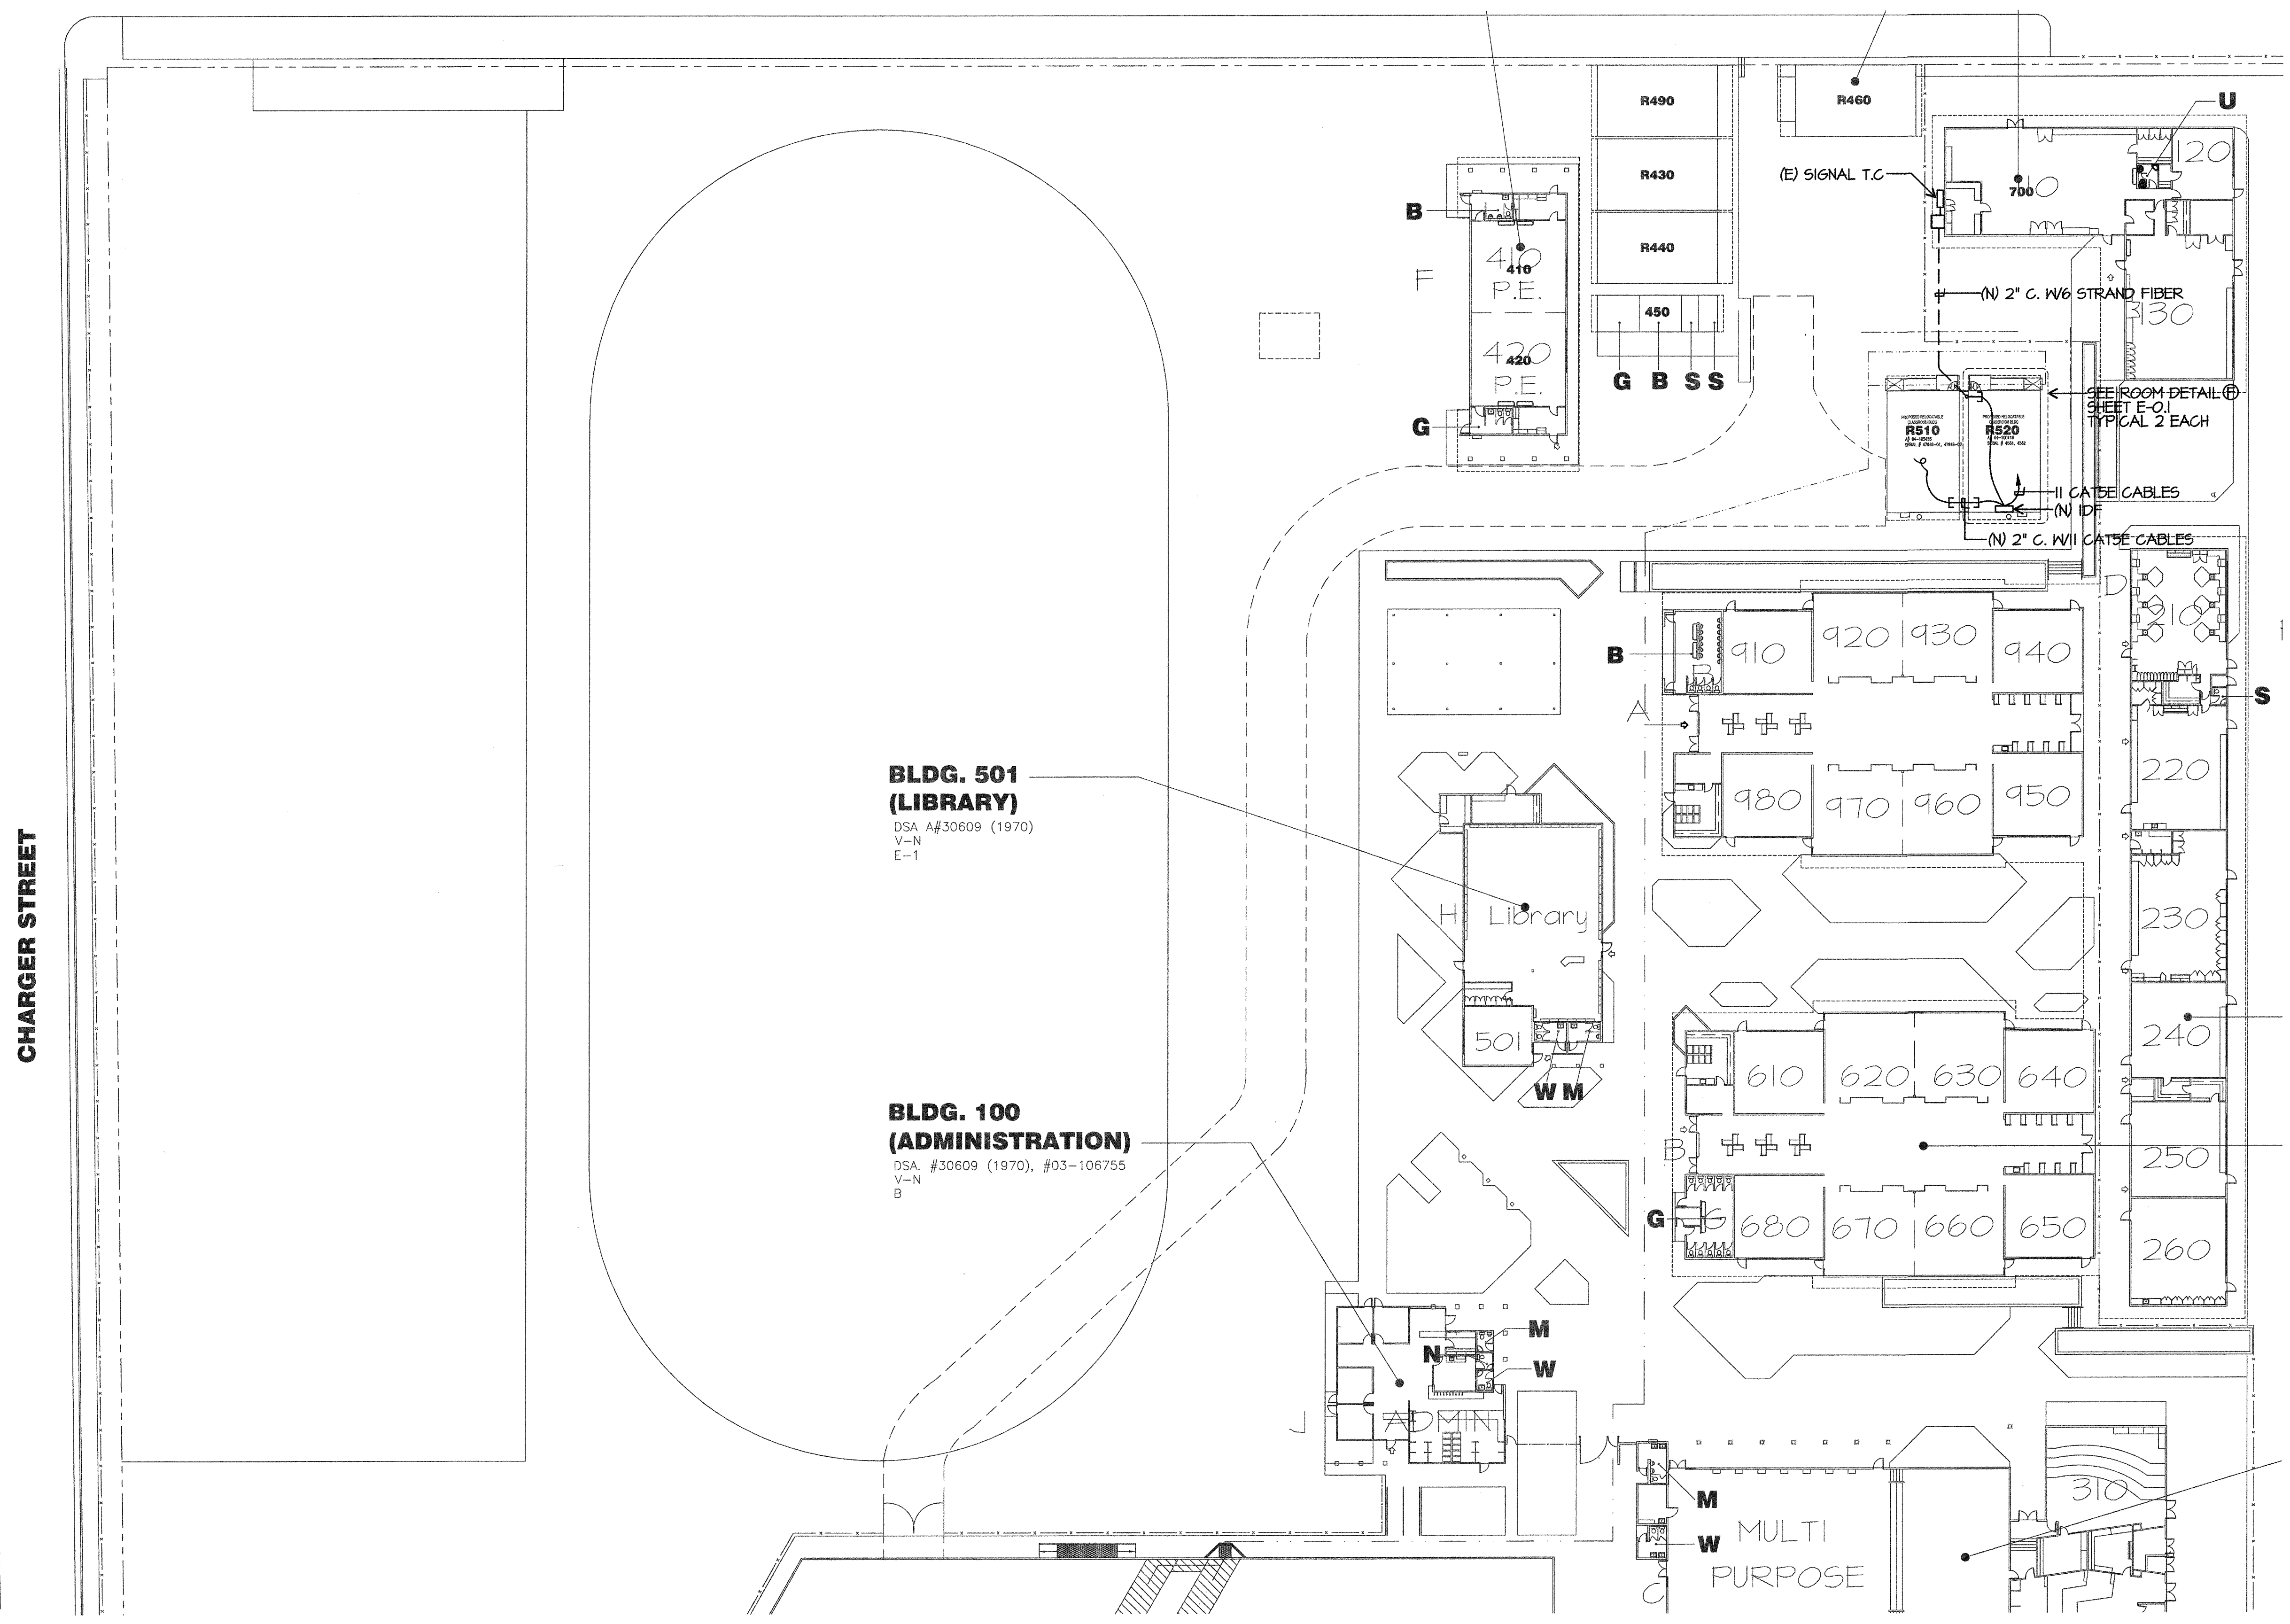

CHARGER STREET

DATA/COMM. PARTIAL SITE PLAN

SCALE: 1"=30'-0"