


ELECTRICAL PARTIAL SITE PLAN NOTES

- 1 ADD (2)(N) 100/2 BREAKERS INTO PANEL DP-2.
- 2 PROVIDE NEW EMERGENCY EGRESS LIGHT. ISOLITE #ELED-EM-BZ. MOUNT IN CENTER OF FRONT EXTERIOR WALL AS SHOWN. CONNECT TO (E) UNSWITCHED LIGHT CIRCUIT IN ATTIC ABOVE T-BAR CEILING. FIELD VERIFY WALL PENETRATION TO BE ABOVE T-BAR AND BELOW BUILDING STEEL.
- 3 EXISTING LIGHT TO REMAIN.
- 4 RUN CONDUIT EXPOSED ON BUILDING EXTERIOR WALL.

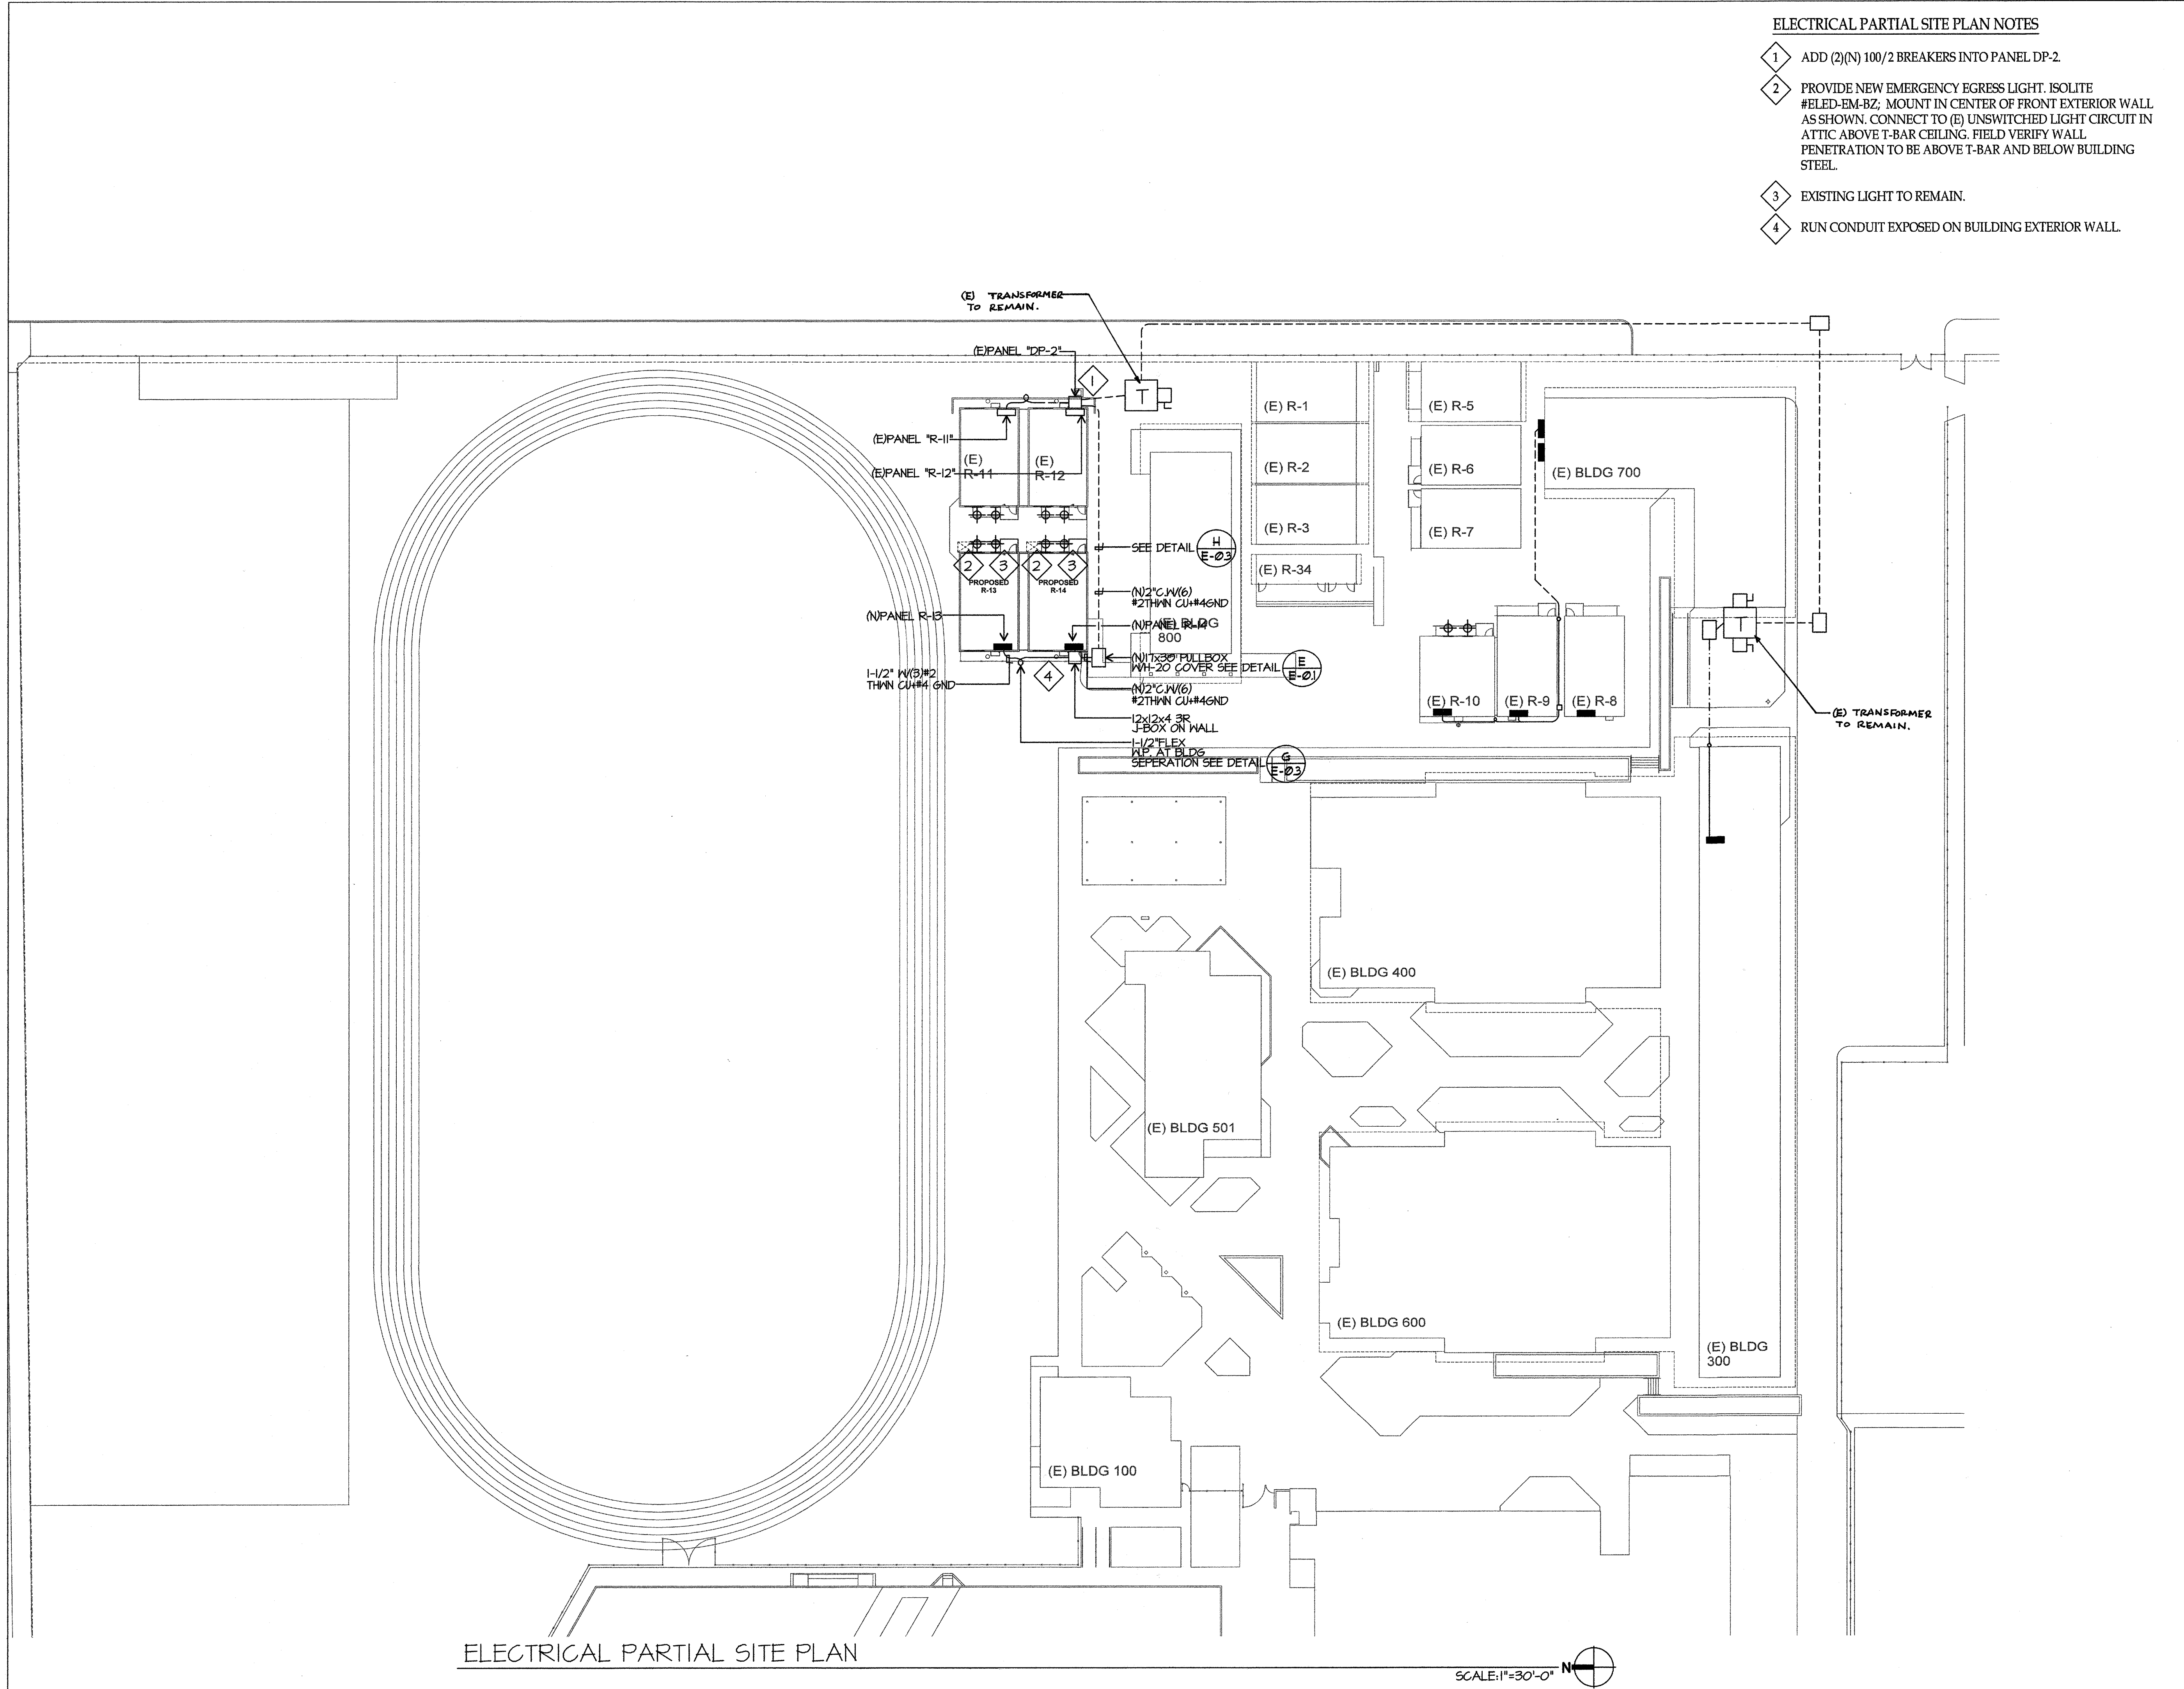

PRIME CONSULTANT

IBI ARCHITECTURE PLANNING
San Luis Obispo
 4115 Broad Street, Suite B-6
 San Luis Obispo, CA 93401
 805.546.0433 fax:805.546.0504

SEAL

COPYRIGHT:
 Any reproduction or distribution for any purpose other than authorized by IBI Group is forbidden.
 COPYRIGHT 2017 IBI GROUP

REVISIONS			
NO.	DATE	APPRD.	DESCRIPTION

CONSULTANT
JMPE
 ELECTRICAL ENGINEERING
 LIGHTING DESIGN
 CA REGISTRATION NO. 813003
 17148

AGENCY INFORMATION:
 AGENCY TRACKING NO. 63321-267
 FILE NO. 15-8
 IDENTIFICATION STAMP
 DIV. OF THE STATE ARCHITECT
 OFFICE OF REGULATION SERVICES
 0318235
 AC [Signature]
 DATE JUL 11 2017

BAKERSFIELD CITY SCHOOL DISTRICT

**CHIPMAN JR. HIGH,
 RELOCATABLES R13 & R14**
 2905 EISSLER ST. BAKERSFIELD, CA 93306

OPSC or OSHPD PROJ. NO:
 PROJECT NO: 17150/109623
 DRAWN BY: AC
 CHKD BY: KT
 ISSUE DATE: 07/11/2017

SHEET TITLE
**ELECTRICAL
 PARTIAL SITE
 PLAN**

SHEET NUMBER
E-1

ELECTRICAL PARTIAL SITE PLAN

SCALE: 1"=30'-0"

\\bratsuu\shores\Uwg\2017_UWUS\1148\1148_e-1.dwg, 5/30/2017 11:07:26 AM, atoniso