


ELECTRICAL PARTIAL SITE PLAN NOTES

- 1 ADD (1)(N) 100/2 BREAKERS INTO PANEL DP-1.
- 2 PROVIDE NEW EMERGENCY EGRESS LIGHT, ISOLITE #ELED-EM-BZ, MOUNT IN CENTER OF FRONT EXTERIOR WALL AS SHOWN. CONNECT TO (E) UNSWITCHED LIGHT CIRCUIT IN ATTIC ABOVE T-BAR CEILING. FIELD VERIFY WALL PENETRATION TO BE ABOVE T-BAR AND BELOW BUILDING STEEL
- 3 EXISTING LIGHT TO REMAIN.
- 4 CONTRACTOR SHALL PROVIDE NEW 200/3 BREAKER IN EXISTING MSB

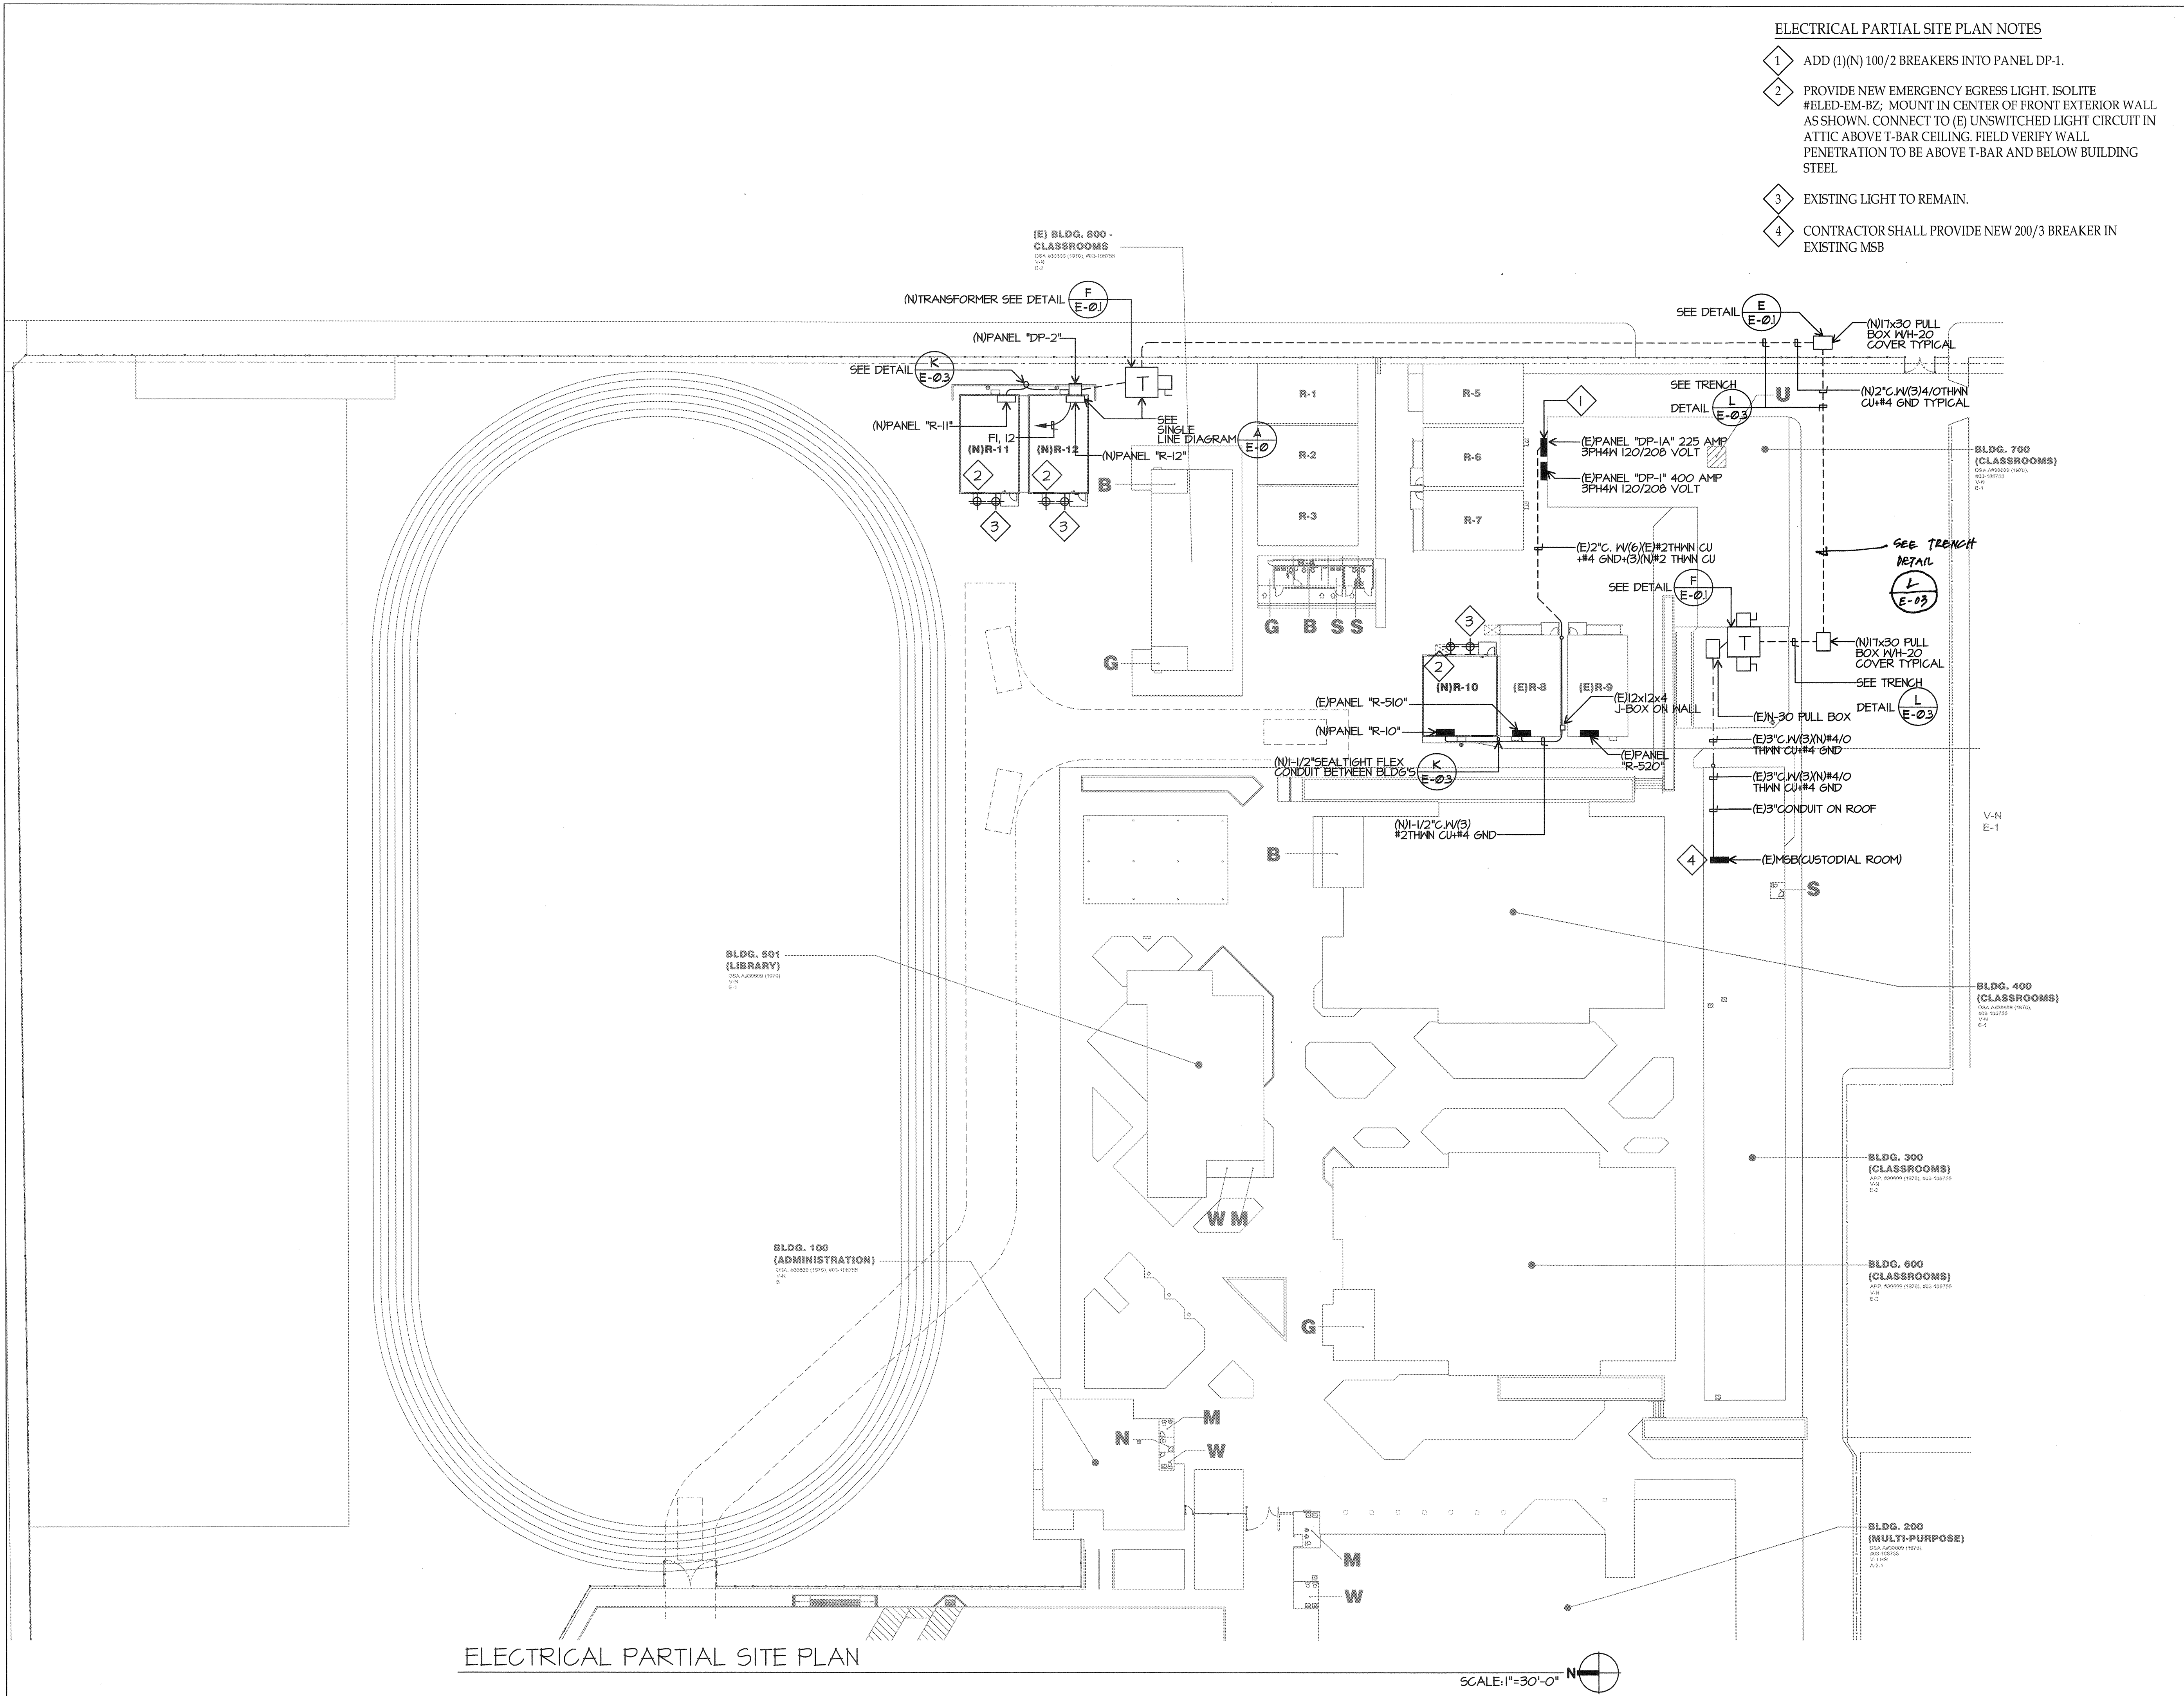

PRIME CONSULTANT

**IBI** ARCHITECTURE PLANNING  
 San Luis Obispo  
 4115 Broad Street, Suite B-6  
 San Luis Obispo, CA 93401  
 805.546.0433 fax:805.546.0504

SEAL

COPYRIGHT: Any reproduction or distribution for any purpose other than authorized by IBI Group is forbidden.

COPYRIGHT 2014 IBI GROUP

REVISIONS			
NO.	DATE	APPRD.	DESCRIPTION

CONSULTANT

**JMPE**  
 ELECTRICAL ENGINEERING  
 LIGHTING DESIGN  
 CA REGISTRATION NO E13083  
 1621T

5500 MING AVENUE,  
 SUITE 201  
 BAKERSFIELD, CA 93309  
 (805) 831-7782  
 FAX (805) 831-7813  
 email: jmaloney@jmpe.com  
 www.jmpe.com

AGENCY INFORMATION:

AGENCY TRACKING NO. 63321-243  
 FILE NO. 15-6

IDENTIFICATION STAMP  
 DIV. OF THE STATE ARCHITECT  
 OFFICE OF REGULATION SERVICES

AC: W FLS: W SS: 71  
 DATE: OCT 11 2016

BAKERSFIELD CITY SCHOOL DISTRICT

**CHIPMAN JR. HIGH NEW RELOCATABLES (3)**

2905 EISSLER ST  
 BAKERSFIELD, CA 93306

OPSC or OSHPD PROJ. NO:

PROJECT NO:	16166.000
DRAWN BY:	AC
CHK'D BY:	KT
ISSUE DATE:	10/05/2016

SHEET TITLE

**ELECTRICAL PARTIAL SITE PLAN**

SHEET NUMBER

**E-1**