


PARTIAL FIRE ALARM SITE PLAN NOTES

- 1 TERMINATE (N) CABLES SO CABLES TO (N) R11 IS AT END OF SLC.

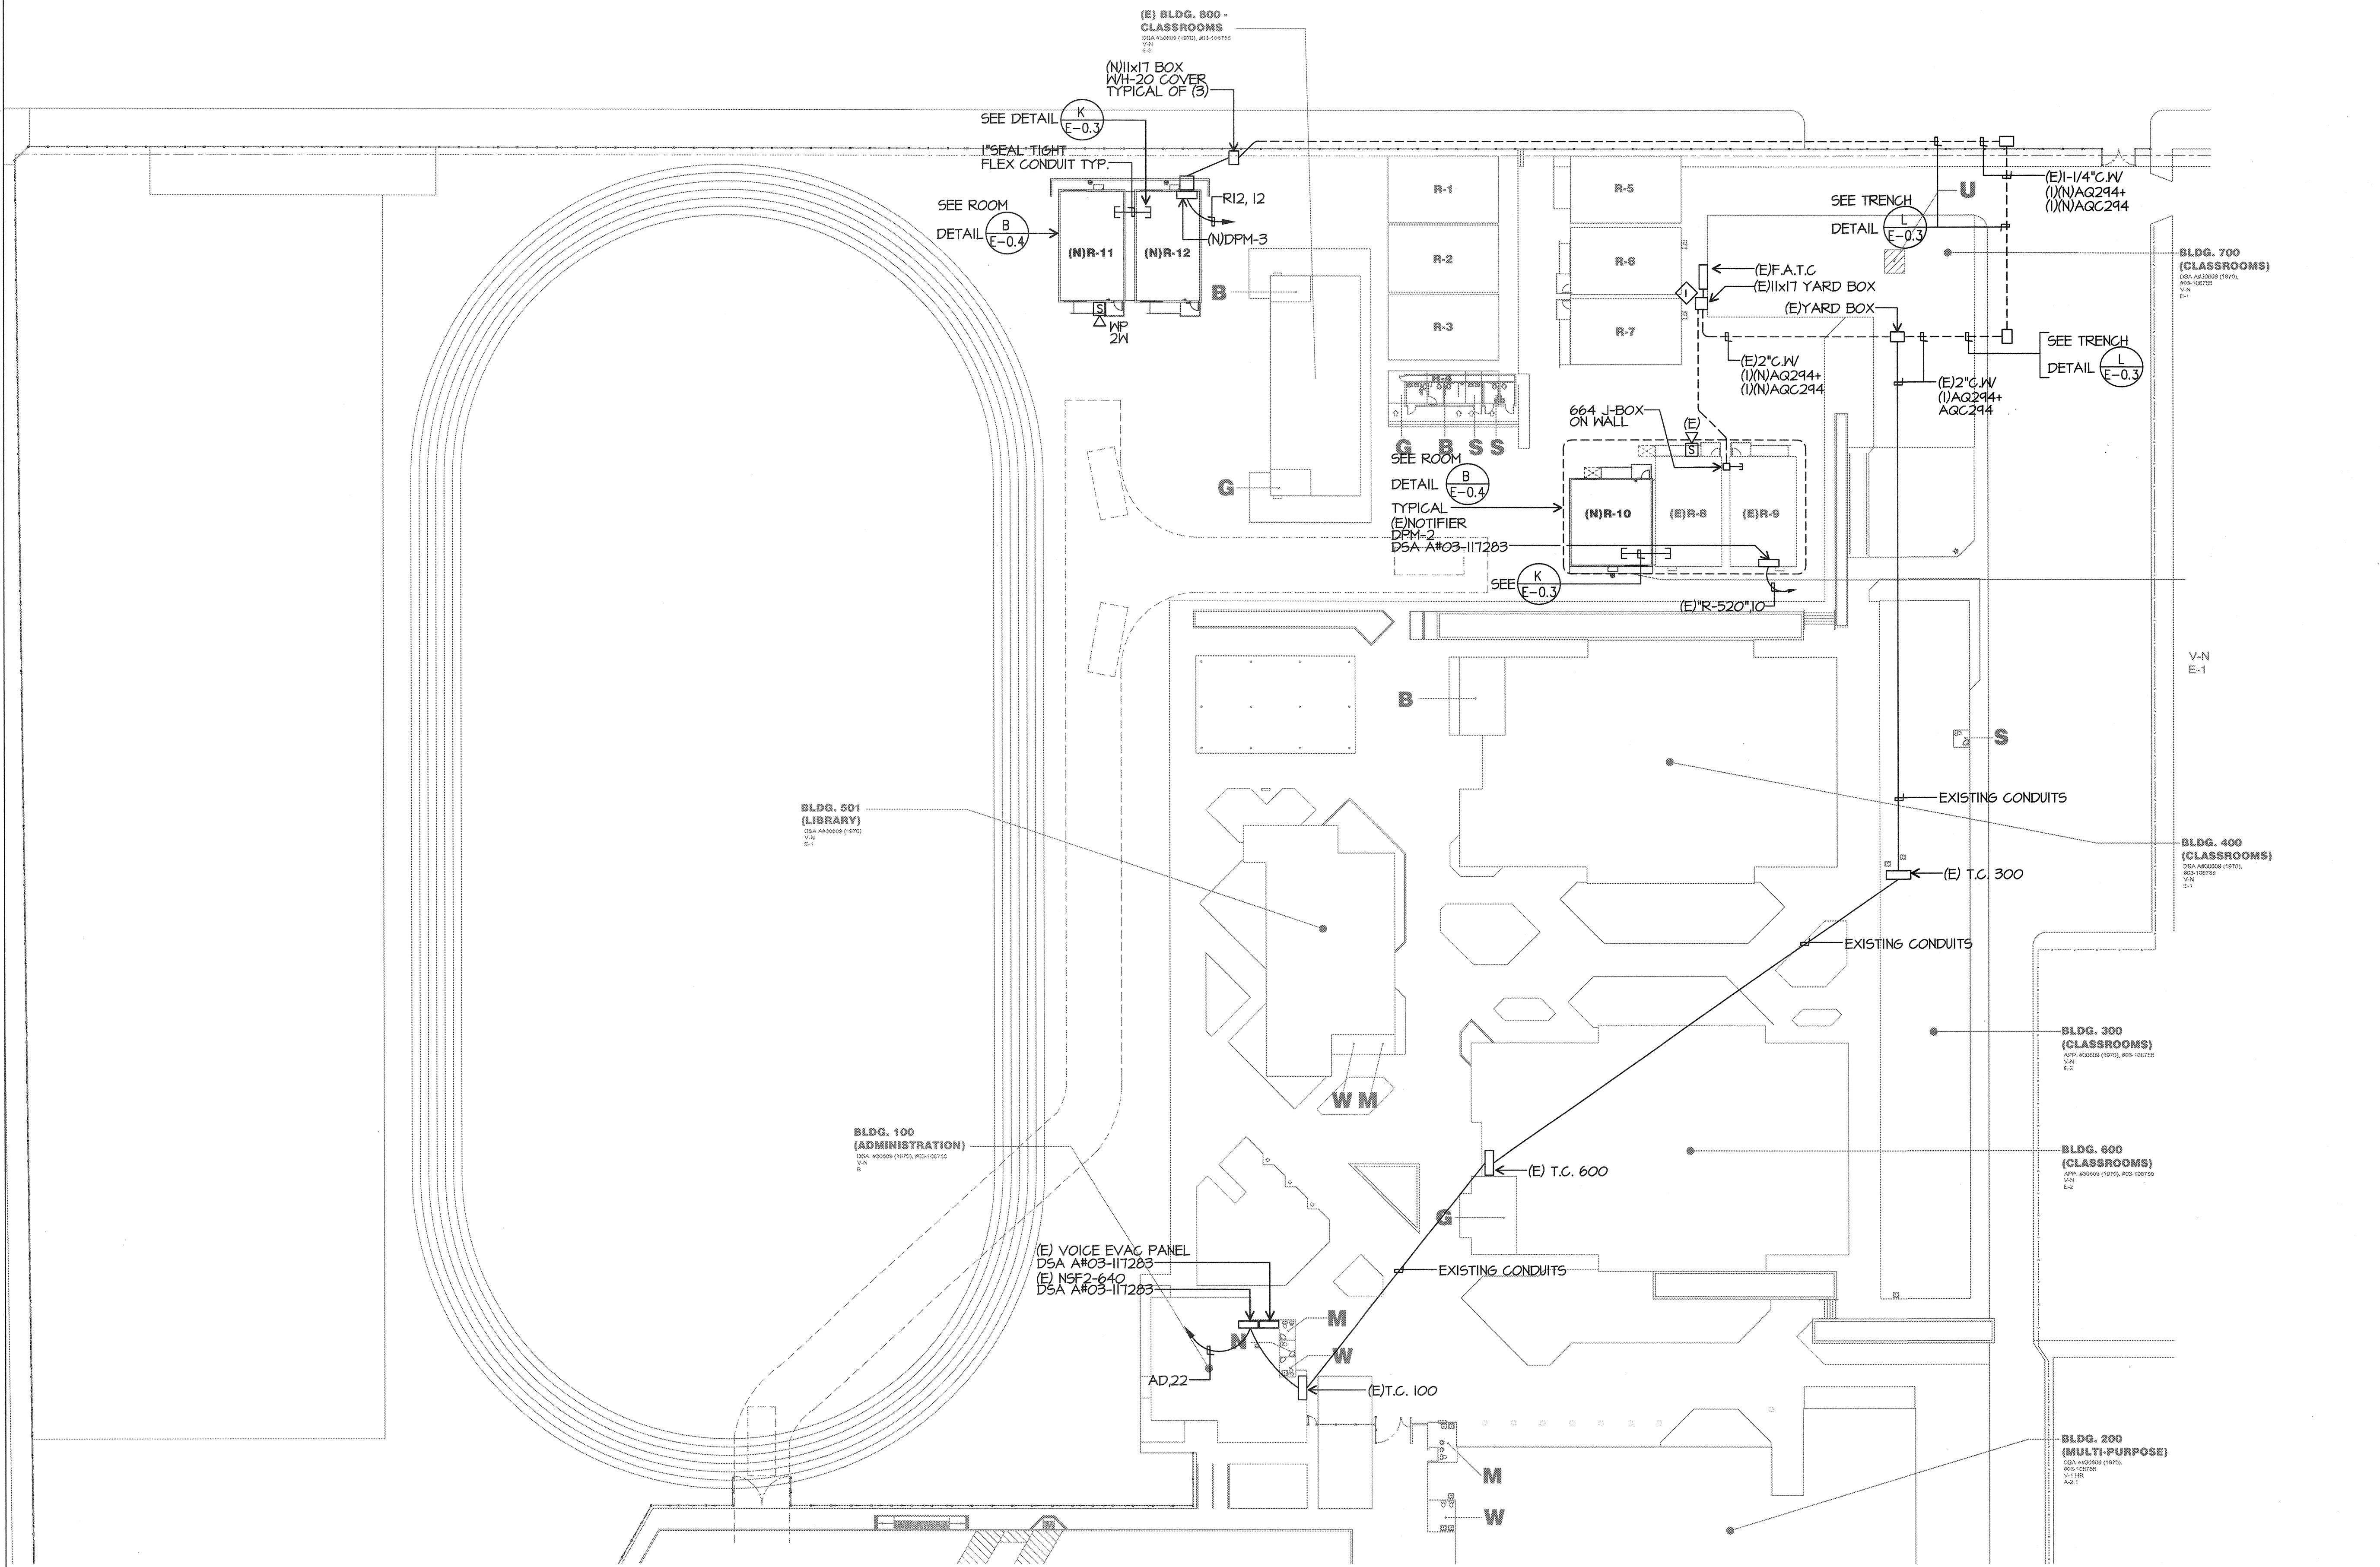

FIRE ALARM PARTIAL SITE PLAN


SCALE: 1"=30'-0"

PRIME CONSULTANT
IBI ARCHITECTURE PLANNING
 San Luis Obispo
 4115 Broad Street, Suite B-6
 San Luis Obispo, CA 93401
 805.546.0433 fax:805.546.0504


SEAL


COPYRIGHT:
 Any reproduction or distribution for any purpose other than authorized by IBI Group is forbidden.
 COPYRIGHT 2014 IBI GROUP

REVISIONS			
NO.	DATE	APPRD.	DESCRIPTION

CONSULTANT
JMPE
 ELECTRICAL ENGINEERING
 LIGHTING DESIGN
 CA REGISTRATION NO. E13085
 16217


AGENCY INFORMATION:
 AGENCY TRACKING NO. 63321-243
 FILE NO. 15-6
 IDENTIFICATION STAMP
 DIV. OF THE STATE ARCHITECT
 OFFICE OF REGULATION SERVICES
 03-117549
 AC: W FLS M SS TN
 DATE: OCT 11 2016

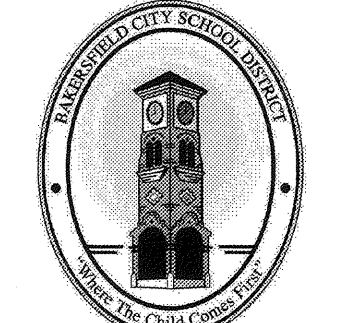BAKERSFIELD CITY SCHOOL DISTRICT

CHIPMAN JR. HIGH NEW RELOCATABLES (3)
 2905 ESSLER ST
 BAKERSFIELD, CA 93306

OPSC or OSHPD PROJ. NO:	
PROJECT NO:	16166.000
DRAWN BY:	AC
CHKD BY:	KT
ISSUE DATE:	10/05/2016

SHEET TITLE
FIRE ALARM PARTIAL SITE PLAN

SHEET NUMBER
E-2

PLOT DATE: 8/26/2016 1:49:22 PM J:\16166_BC_Chipman315.9 Drawings\Arch\current\ATW-16166-Asite_Chipman 2.rvt