
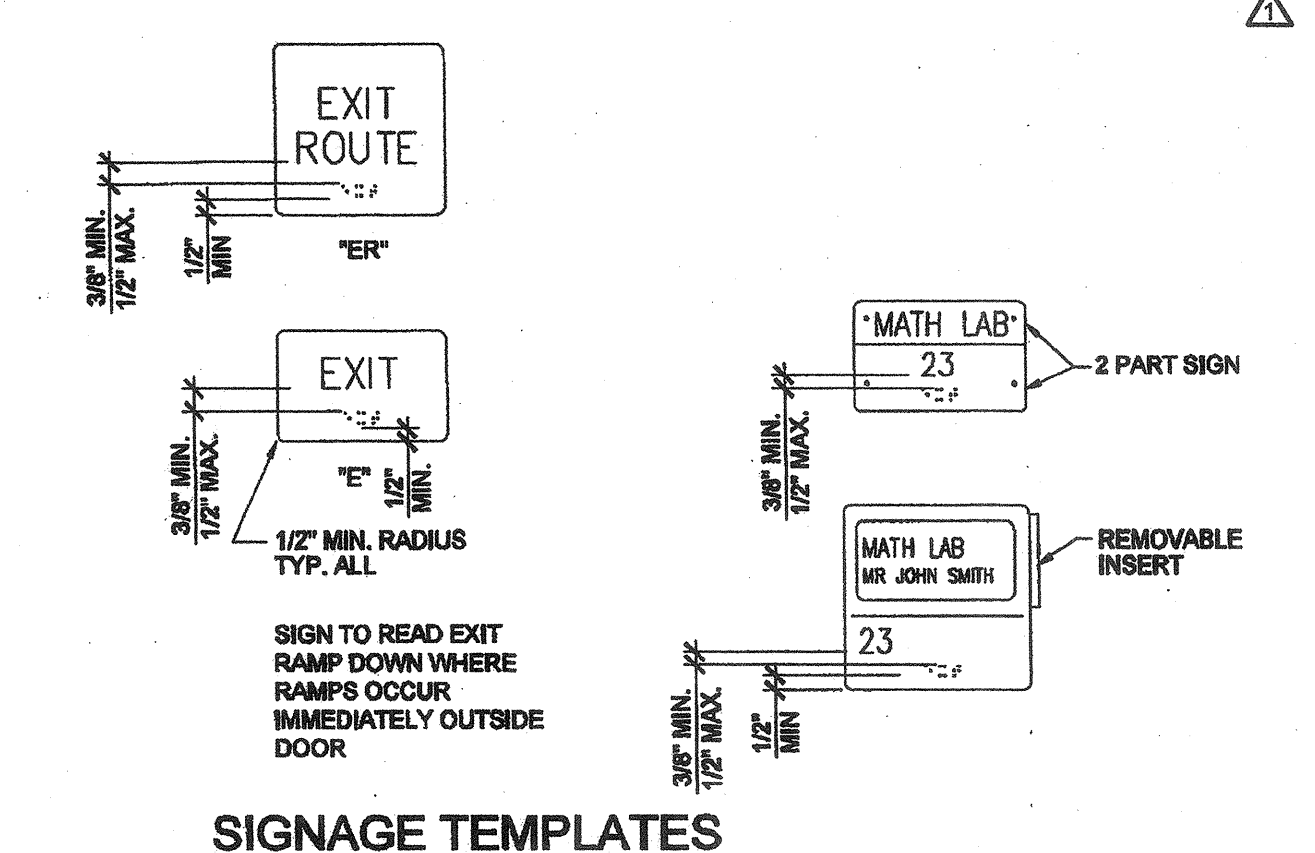


**REFLECTED CEILING NOTES**



**METAL SUSPENSION FOR LAY-IN PANEL CEILING:**

- 12GA. (MIN.) HANGER WIRES MAY BE USED FOR UP TO THE INCLUDING 4'-0" X 4'-0" GRID SPACING, ALONG MAIN RUNNER. SPLICES WILL NOT BE PERMITTED IN ANY HANGER WIRES UNLESS SPECIFICALLY APPROVED BY DSA.
- PROVIDE 12GA. HANGER WIRES WITHIN 8" OF THE ENDS OF ALL MAIN & CROSS RUNNERS OR AT 1/4 OF THE LENGTH OF THE END TEE, WHICHEVER IS LESS AT THE PERIMETER OF THE CEILING AREA.
- PROVIDE TRAPEZE OR OTHER SUPPLEMENTARY SUPPORT MEMBERS AT OBSTRUCTIONS TO MAINTAIN HANGER SPACING. PROVIDE ADDITIONAL HANGERS, STRUTS OR BRACES AS REQUIRED AT THE CEILING BREAKS, SOFFITS OR DISCONTINUOUS AREAS. HANGER WIRES THAT ARE MORE THAN 1 IN 6 PLUMB ARE TO HAVE COUNTER SLOPING WIRES.
- CEILING GRID MEMBERS MAY BE ATTACHED TO NOT MORE THAN 2 ADJACENT WALLS. CEILING GRID MEMBERS SHOULD BE AT LEAST 3/4" CLEAR OF OTHER WALLS. IF WALLS RUN DIAGONALLY TO CEILING GRID SYS. RUNNERS, THE MAIN AND CROSS RUNNERS SHOULD BE FREE & A MIN. OF 3/4" CLEAR OF WALL.
- AT THE PERIMETER OF THE CEILING AREA WHERE MAIN OR CROSS RUNNERS ARE NOT CONNECTED TO THE ADJACENT WALL, PROVIDE INTERCONNECTION BETWEEN THE RUNNERS AT THE FREE END TO PREVENT LATERAL SPREADING. A METAL STRUT OR A 18GA. WIRE WITH A POSITIVE MECHANICAL CONNECTION TO THE RUNNERS MAY BE USED, WHERE THE PERPENDICULAR DISTANCE FROM THE WALL TO THE FIRST PARALLEL RUNNERS IS 8" OR LESS, THIS INTERLOCK IS NOT REQ'D.
- PROVIDE BRACING ASSEMBLY CONSISTING OF A COMPRESSION STRUT (COMPRESSION STRUTS SHALL BE ADEQUATE TO RESIST THE VERTICAL COMPONENT INDUCED BY THE BRACING WIRES, AND SHALL NOT BE MORE THAN 1 (HORIZONTAL) IN 8 (VERTICAL) OUT OF PLUMB) AND (4) 12GA. SPLAYED WIRES ORIENTED 90° FROM EA. OTHER AT THE FOLLOWING SPACING:
  - PLACE BRACING ASSEMBLIES AT A SPACING NOT MORE THAN 12'-0" 12'-0" ON CENTER.
  - PROVIDE BRACING ASSEMBLIES AT LOCATIONS NOT MORE THAN 1/2 THE ABOVE SPACING FROM EA. PERIMETER WALL OR AT THE EDGE OF VERTICAL CEILING OFFSETS. THE SLOPE OF THESE WIRES SHALL NOT EXCEED 45° FROM THE PLANE OF THE CEILING AND SHOULD BE TAUT WITHOUT CAUSING THE CEILING TO LIFT. SPLICES IN BRACING WIRES ARE NOT PERMITTED WITHOUT SPECIAL DSA APPROVAL.
- FASTEN #12 HANGER WIRES WITH NOT LESS THAN THREE (3) TIGHT TURNS IN 3 INCHES. HANGER WIRE LOOPS SHALL BE TIGHTLY WRAPPED AND SHARPLY BENT TO PREVENT ANY VERTICAL MOVEMENT OR ROTATION OF THE MEMBER WITHIN THE LOOPS (SEE ASTM E980, SECTION 5.2.7.2). FASTEN SPLAY WIRES WITH 4 TIGHT TURNS. HANGER OR BRACING WIRE ANCHORS TO THE STRUCTURE SHOULD BE INSTALLED IN SUCH A MANNER THAT THE DIRECTION OF THE ANCHOR ALIGNS AS CLOSELY AS POSSIBLE WITH THE DIRECTION OF THE WIRE.
- SEPARATE ALL CEILING HANGING AND BRACING WIRES AT LEAST 6" FROM ALL UNBRACED DUCTS, PIPES, CONDUITS, ETC. HANGER WIRES SHALL NOT ATTACH TO OR BEND AROUND INTERFERING MATERIAL OR EQUIPMENT. PROVIDE TRAPEZE OR OTHER SUPPLEMENTARY SUPPORT MEMBERS AT OBSTRUCTIONS TO TYPICAL HANGER SPACING. SEE FIGURE 3A, DETAIL F OF DSA IR 25-2.10. PROVIDE ADDITIONAL HANGERS, STRUTS OR BRACES AS REQUIRED AT ALL CEILING BREAKS, SOFFITS, OR DISCONTINUOUS AREAS.
- CEILING PANELS SHALL NOT SUPPORT ANY LIGHT FIXTURES, AIR TERMINALS OR DEVICES. ATTACH ALL LIGHT FIXTURES CEILING MOUNTED AIR TERMINALS AND ALL OTHER DEVICES TO THE CEILING GRID RUNNERS TO RESIST A HORIZONTAL FORCE EQUAL TO THE WEIGHT OF THE FIXTURES. SCREWS OR APPROVED FASTENERS ARE REQUIRED. MINIMUM OF TWO ATTACHMENTS ARE REQUIRED AT EACH LIGHT FIXTURE PER ASTM E980 SECTION 5.3.1. RECESSED OR DROP-IN LIGHT FIXTURES, GRILLES, MECHANICAL TERMINALS, AND FLEXIBLE SPRINKLER HOSE FITTINGS OR OTHER SERVICES BE SUPPORTED DIRECTLY ON RUNNERS CLASSIFIED AS ASTM HEAVY DUTY, BUT THEY MUST ALSO HAVE A MINIMUM OF TWO (2) #12 GAGE SLACK SAFETY WIRES ATTACHED TO THE FIXTURE AT DIAGONAL CORNERS AND ANCHORED TO THE STRUCTURE ABOVE.
- ALL FLUSH OR RECESSED LIGHT FIXTURES, MECHANICAL TERMINALS, AND FLEXIBLE SPRINKLER HOSE FITTINGS OR OTHER SERVICES WEIGHING 50 LBS. OR MORE MUST BE INDEPENDENTLY SUPPORTED BY NOT LESS THAN FOUR (4) TAUT #12 GAGE WIRES ATTACHED AND TO THE STRUCTURE ABOVE. THE FOUR (4) TAUT #12 GAGE WIRES, INCLUDING THEIR ATTACHMENT TO THE STRUCTURE ABOVE, MUST BE CAPABLE OF SUPPORTING FOUR (4) TIMES THE WEIGHT OF THE UNIT. ALL 4 IN. X 4 IN. LIGHT FIXTURES MUST HAVE SLACK SAFETY WIRES AT EACH CORNER. SURFACE MOUNTED FIXTURES SHALL BE ATTACHED TO THE MAIN RUNNER WITH AT LEAST TWO POSITIVE CLAMPING DEVICES MADE OF MATERIAL WITH A MINIMUM #14 GAGE. ROTATIONAL SPRING CATCHES DO NOT COMPLY. A #12 GAGE SUSPENSION WIRE SHALL BE ATTACHED TO EACH CLAMPING DEVICE TO THE STRUCTURE ABOVE. PROVIDE ADDITIONAL SUPPORTS WHEN LIGHT FIXTURES ARE 8 IN. OR LONGER. MAXIMUM SPACING BETWEEN SUPPORTS SHALL NOT EXCEED 8 FEET. SUPPORT PENDANT MOUNTED LIGHT FIXTURES DIRECTLY FROM THE STRUCTURE ABOVE WITH HANGER WIRES OR CABLES PASSING THROUGH EACH PENDANT HANGER AND CAPABLE OF SUPPORTING TWO (2) TIMES THE WEIGHT OF THE FIXTURE. A BRACING ASSEMBLY, PER FIGURE 1, IS REQUIRED WHERE THE PENDANT HANGER PENETRATES THE CEILING. SPECIAL DETAILS ARE REQUIRED TO ATTACH THE PENDANT HANGER TO THE BRACING ASSEMBLY TO TRANSMIT HORIZONTAL FORCE. IF THE PENDANT MOUNTED LIGHT FIXTURE IS DIRECTLY AND INDEPENDENTLY BRACED BELOW THE CEILING, I.E. AIRCRAFT CABLES TO WALLS, THEN BRACE ASSEMBLY IS NOT REQUIRED ABOVE THE CEILING. SEE IR 19-9 FOR ADDITIONAL REQUIREMENT FOR PENDANT MOUNTED FIXTURES. ALL LIGHT-WEIGHT MISCELLANEOUS DEVICES, SUCH AS STROBE LIGHTS, SPEAKERS, ETC., SHALL BE ATTACHED TO THE CEILING GRID PER SECTION 7.1 OF DSA IR 25-2.10. IN ADDITION, DEVICES WEIGHING MORE THAN 10 LBS SHALL HAVE A #12 SLACK SAFETY WIRE ANCHORED TO THE STRUCTURE ABOVE. DEVICES WEIGHING MORE THAN 20 LBS SHALL BE SUPPORTED FROM THE STRUCTURE ABOVE PER SECTION 7.3 OF DSA IR 25-2.10. PENETRATIONS THROUGH THE CEILING FOR SPRINKLER HEADS AND OTHER SIMILAR DEVICES THAT ARE NOT INTEGRALLY TIED TO THE CEILING SYSTEM IN THE LATERAL DIRECTION SHALL HAVE A TWO (2) INCH OVERSIZED RING, SLEEVE OR ADAPTER THROUGH THE CEILING TIE TO ALLOW FREE MOVEMENT OF ONE (1) INCH IN ALL HORIZONTAL DIRECTIONS. ALTERNATIVELY, PER ASTM E980 SECTION 5.2.8.8, A FLEXIBLE SPRINKLER HOSE FITTING THAT CAN ACCOMMODATE 1 INCH OF CEILING MOVEMENT SHALL BE PERMITTED TO BE USED IN LIEU OF THE OVERSIZED RING, SLEEVE OR ADAPTER.
- CLASSIFICATION OF CEILING GRID: CLASSIFICATION OF CEILING GRID SHALL BE "HEAVY DUTY"
  - MAIN RUNNER: 7301
  - # CROSS TEE: XL7341
  - 2" CROSS TEE: XL7328
  - 2" WALL ANGLE: 7810
 ARMSTRONG PER ASTM C835 AND C836. PERIMETER SUPPORTING CLOSURE ANGLE SHALL BE NOT LESS THAN 2". ACOUSTICAL PANELS SHALL BE 5/8" MINIMUM THICK, MINERAL FIBERBOARD OR VINYL FACED FIBERGLASS LAY-IN PANELS SQUARE EDGE AND CBC CLASS C FLAME-SPREAD 78-200; SMOKE-DEVELOPED 0-450.
- FOR CEILING AREAS EXCEEDING 2500 SQUARE FEET, A SEISMIC SEPARATION JOINT SHALL BE PROVIDED IN ACCORDANCE WITH DSA IR 25-2.10 SECTION 8, FIGURE 7, DETAIL A TO DIVIDE THE CEILING INTO AREAS NOT EXCEEDING 2500 SQUARE FEET. ALTERNATIVELY, COMPLY WITH ASTM E580-06 SECTION 5.2.9 - 5.6.E. A-2.7d/2
- NOTE FOR FIRE BLK CONSTRUCTION: SECTION 717 PER CBC SECTION 717.2.1. FIRE BLOCKS MAY BE OF GYPSUM BOARD, CEMENT FIBER BOARD, BATTIS OR MINERAL OR GLASS FIBER, OR OTHER APPROVED MATERIALS INSTALLED IN SUCH A MANNER AS TO BE SECURELY RETAINED IN PLACE. LOOSE INSULATION MATERIAL SHALL NOT BE USED AS A FIRE BLOCK UNLESS SPECIFICALLY TESTED IN THE FORM AND MANNER INTENDED FOR USE TO DEMONSTRATE ITS ABILITY TO REMAIN IN PLACE AND TO RETARD THE SPREAD OF FIRE AND HOT GASES. (SECTION 717.2.1). FLAME SPREAD - 25 SMOKE DEVELOPMENT - 50 MAX. FIRE BLOCKING IS NOT REQUIRED WITHIN CONCEALED SPACES CONSTRUCTED OF NON-COMBUSTIBLE MATERIALS.
- DUCTWORK SHALL BE RIGIDLY ATTACHED TO BUILDING AND SHALL NOT BE CLOSER THAN 6" TO HANGER WIRES
- HANGER WIRES MORE THAN 1-IN-6 OUT OF PLUMB SHALL HAVE COUNTER SLOPING WIRES





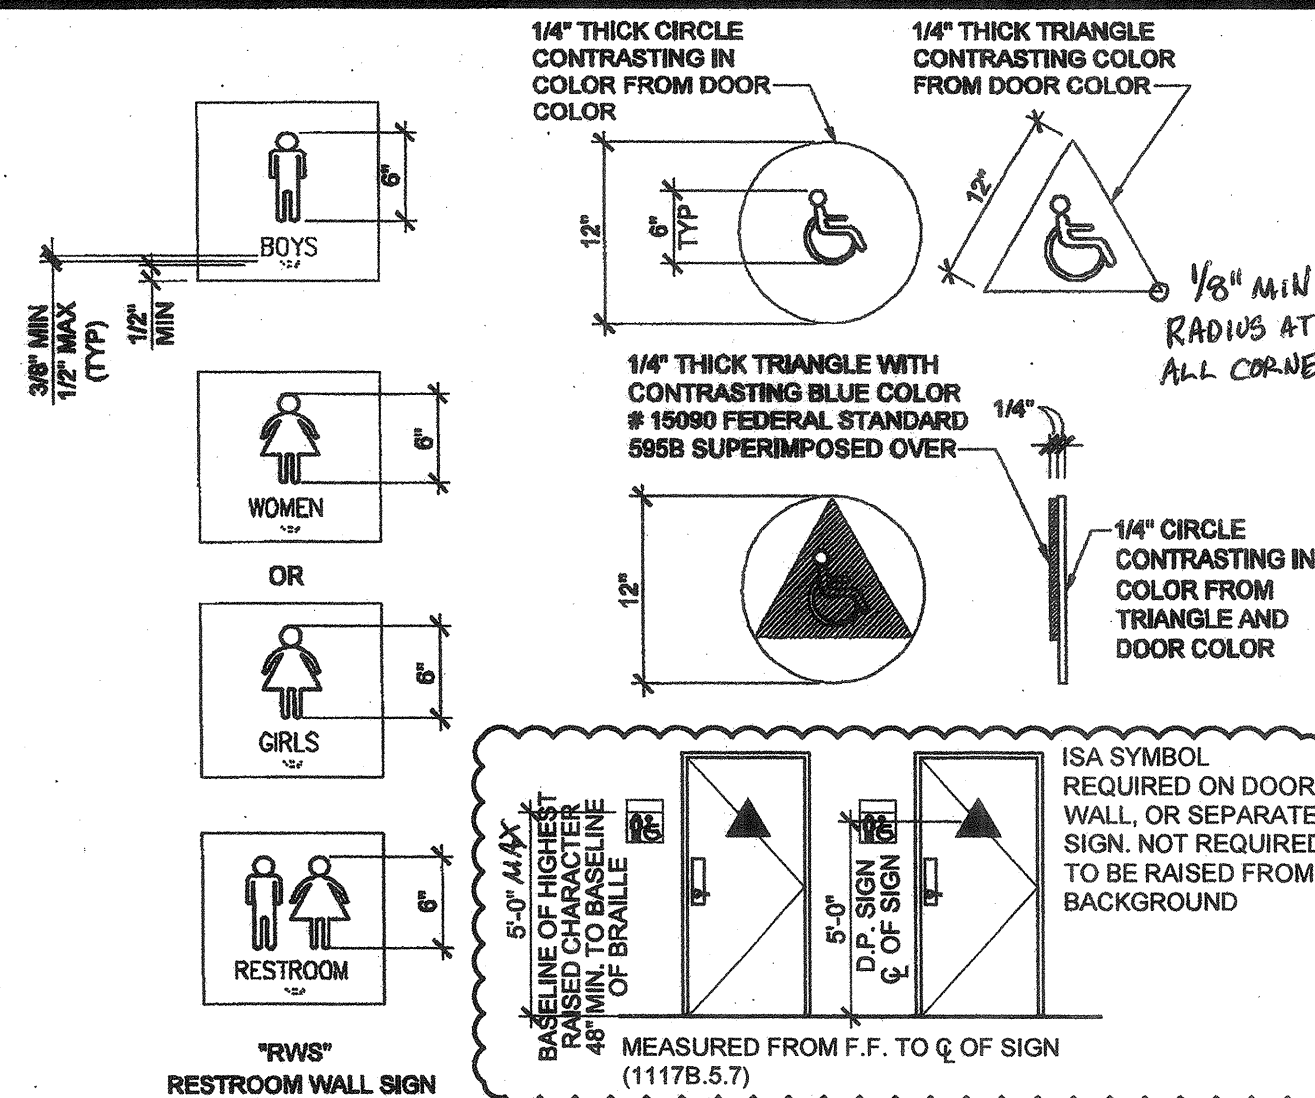


**TACTILE EXIT SIGNS**

- CHARACTER TYPE: CHARACTERS ON SIGNS SHALL BE RAISED 1/32 INCH (0.794 mm) MINIMUM AND SHALL BE SANS SERIF UPPERCASE CHARACTERS ACCOMPANIED BY CONTRACTED GRADE 2 BRAILLE (SEE NOTE 6 BELOW).
- CHARACTER SIZE: RAISED CHARACTERS SHALL BE A MINIMUM OF 5/8 INCH (15.9 mm) AND A MAXIMUM OF 2 INCHES (51 mm) HIGH.
- FINISH AND CONTRAST: CONTRAST BETWEEN CHARACTERS, SYMBOLS AND THEIR BACKGROUND MUST BE 70% MINIMUM AND HAVE A NON-GLARE FINISH. 1117B.5.2
- PROPORTIONS: CHARACTERS ON SIGNS SHALL HAVE A WIDTH-TO-HEIGHT RATIO OF BETWEEN 3:5 AND 1:1 AND A STROKE WIDTH-TO-HEIGHT RATIO OF BETWEEN 1:5 AND 1:10. 1117B.5.3

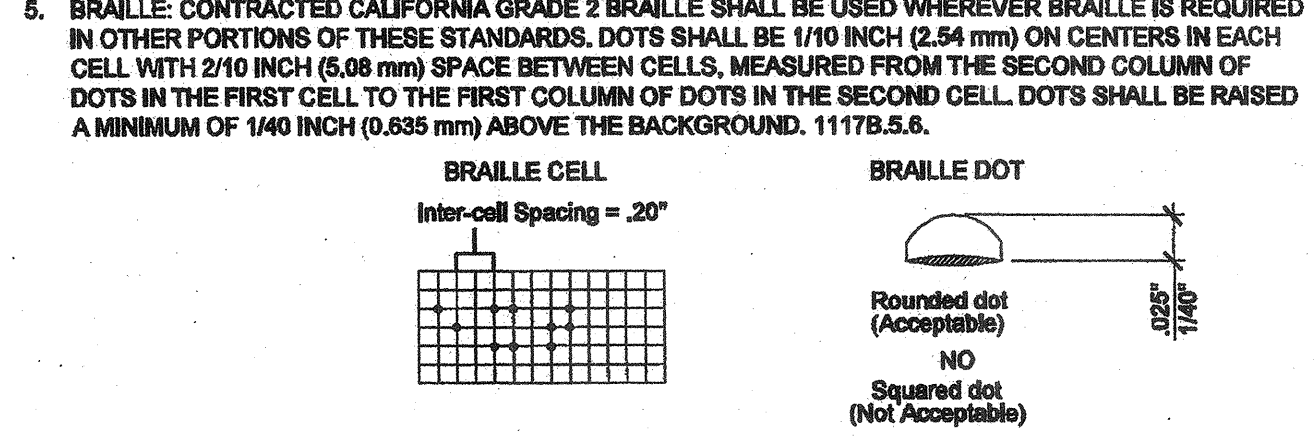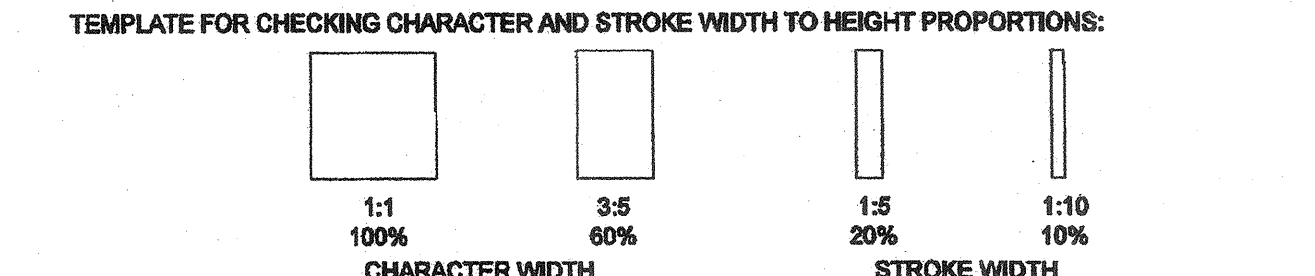


REQUIRED ROUNDED OR DOMED CALIFORNIA BRAILLED DOTS, EACH DISTINCT AND SEPARATE. DOTS WITH STRAIGHT SIDES AND FLAT TOPS ARE NOT READABLE FOR MANY BRAILLE USERS.

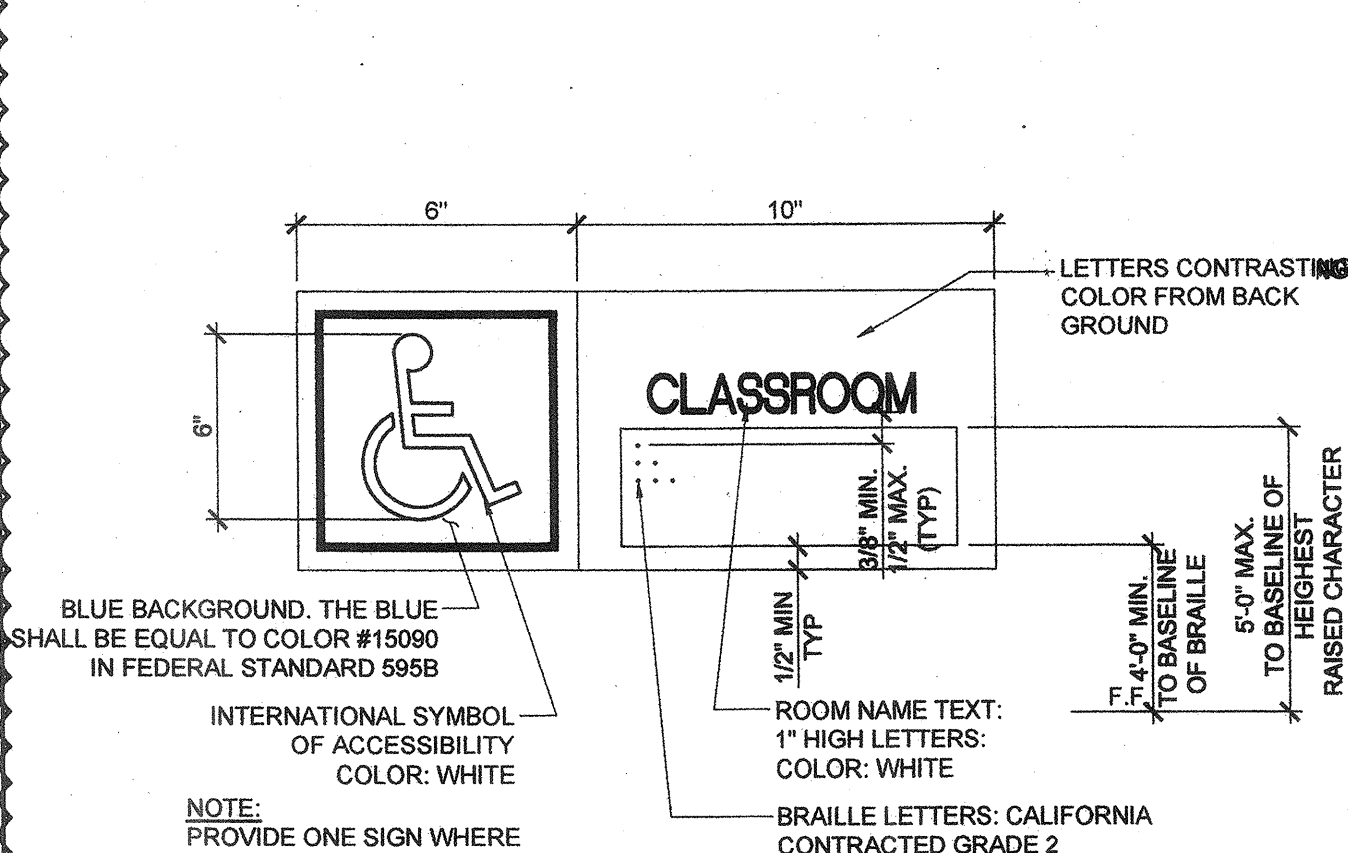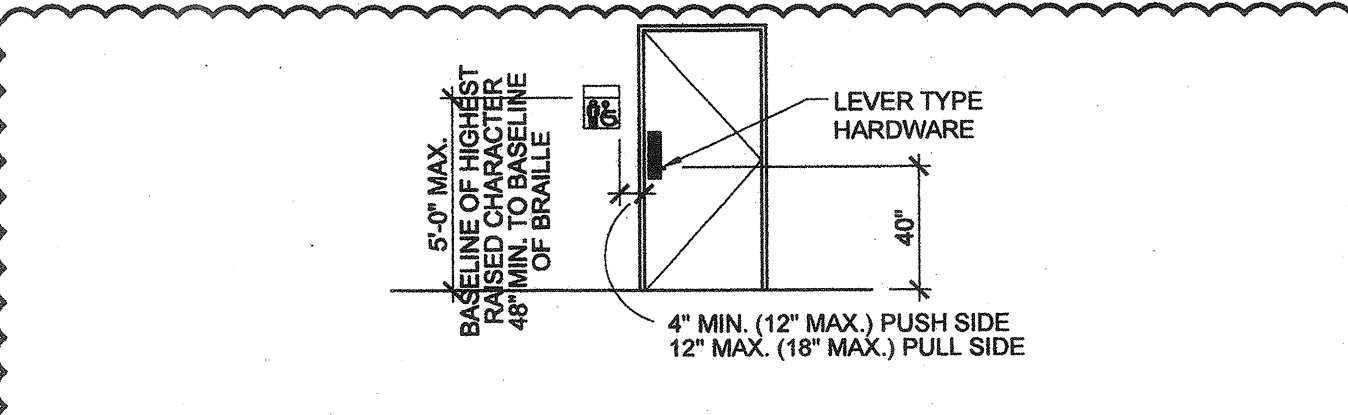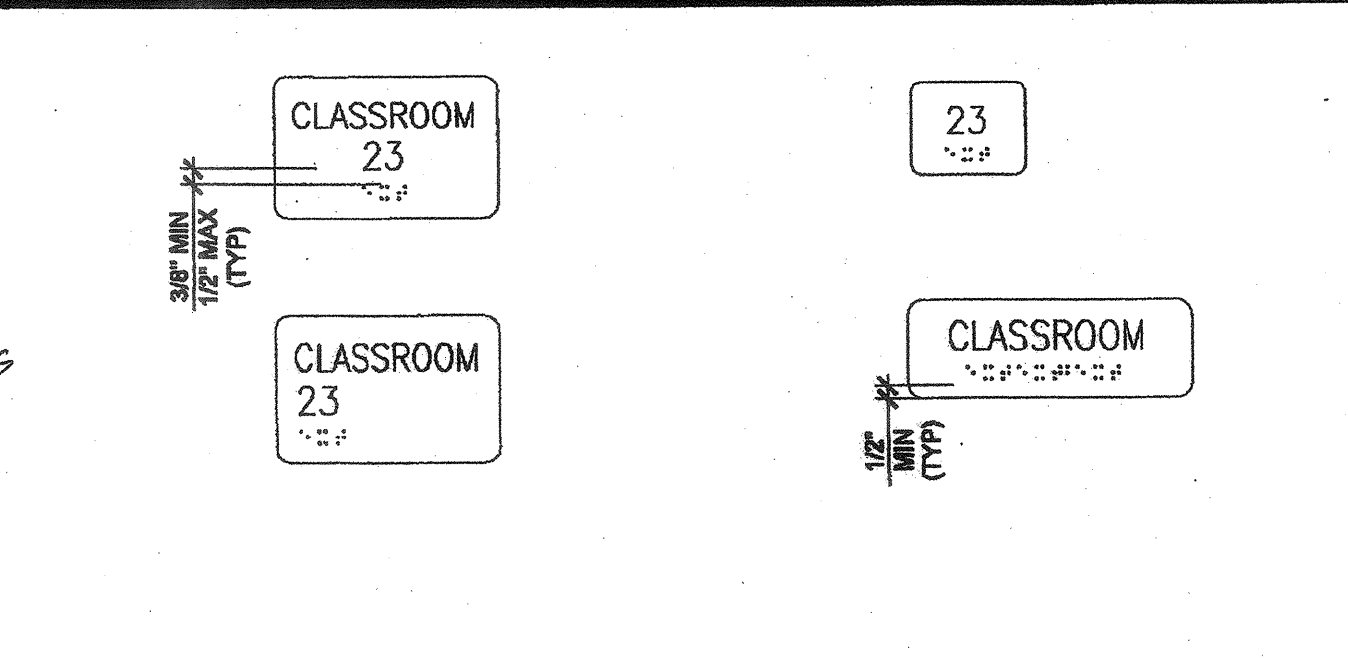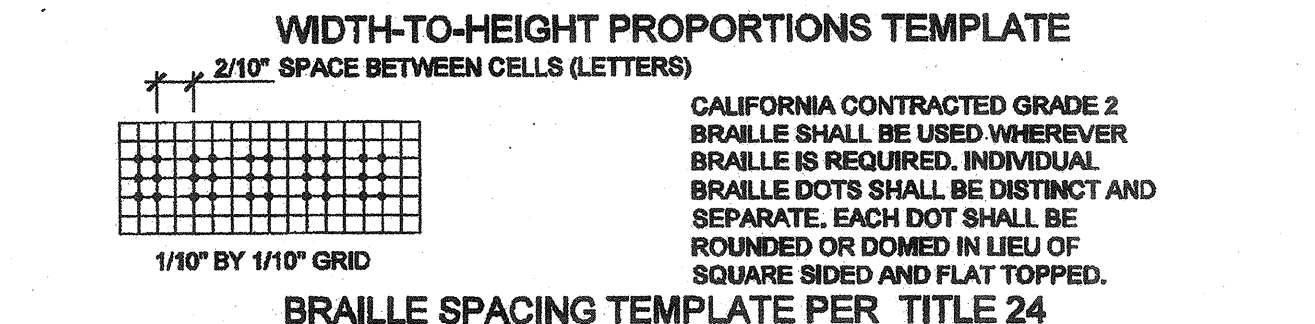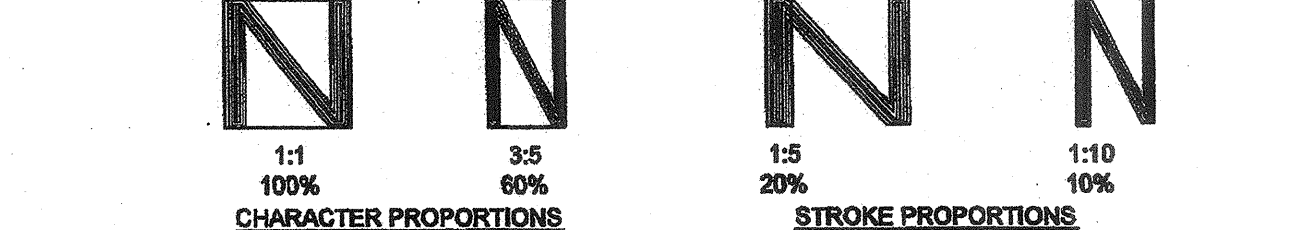

**ACCESSIBLE ROOM SIGNAGE (BY DISTRICT)**

FOR SITE SPECIFIC LOCATIONS ARCHITECT TO PROVIDE BUILDING / ROOM IDENTIFICATION SIGNS, DETAILS AND LOCATIONS OF SIGNAGE TO BE INDICATED. COORDINATE WITH NOTES 1 THROUGH 5 ON THIS SHEET.

**SYMBOLS LEGEND**

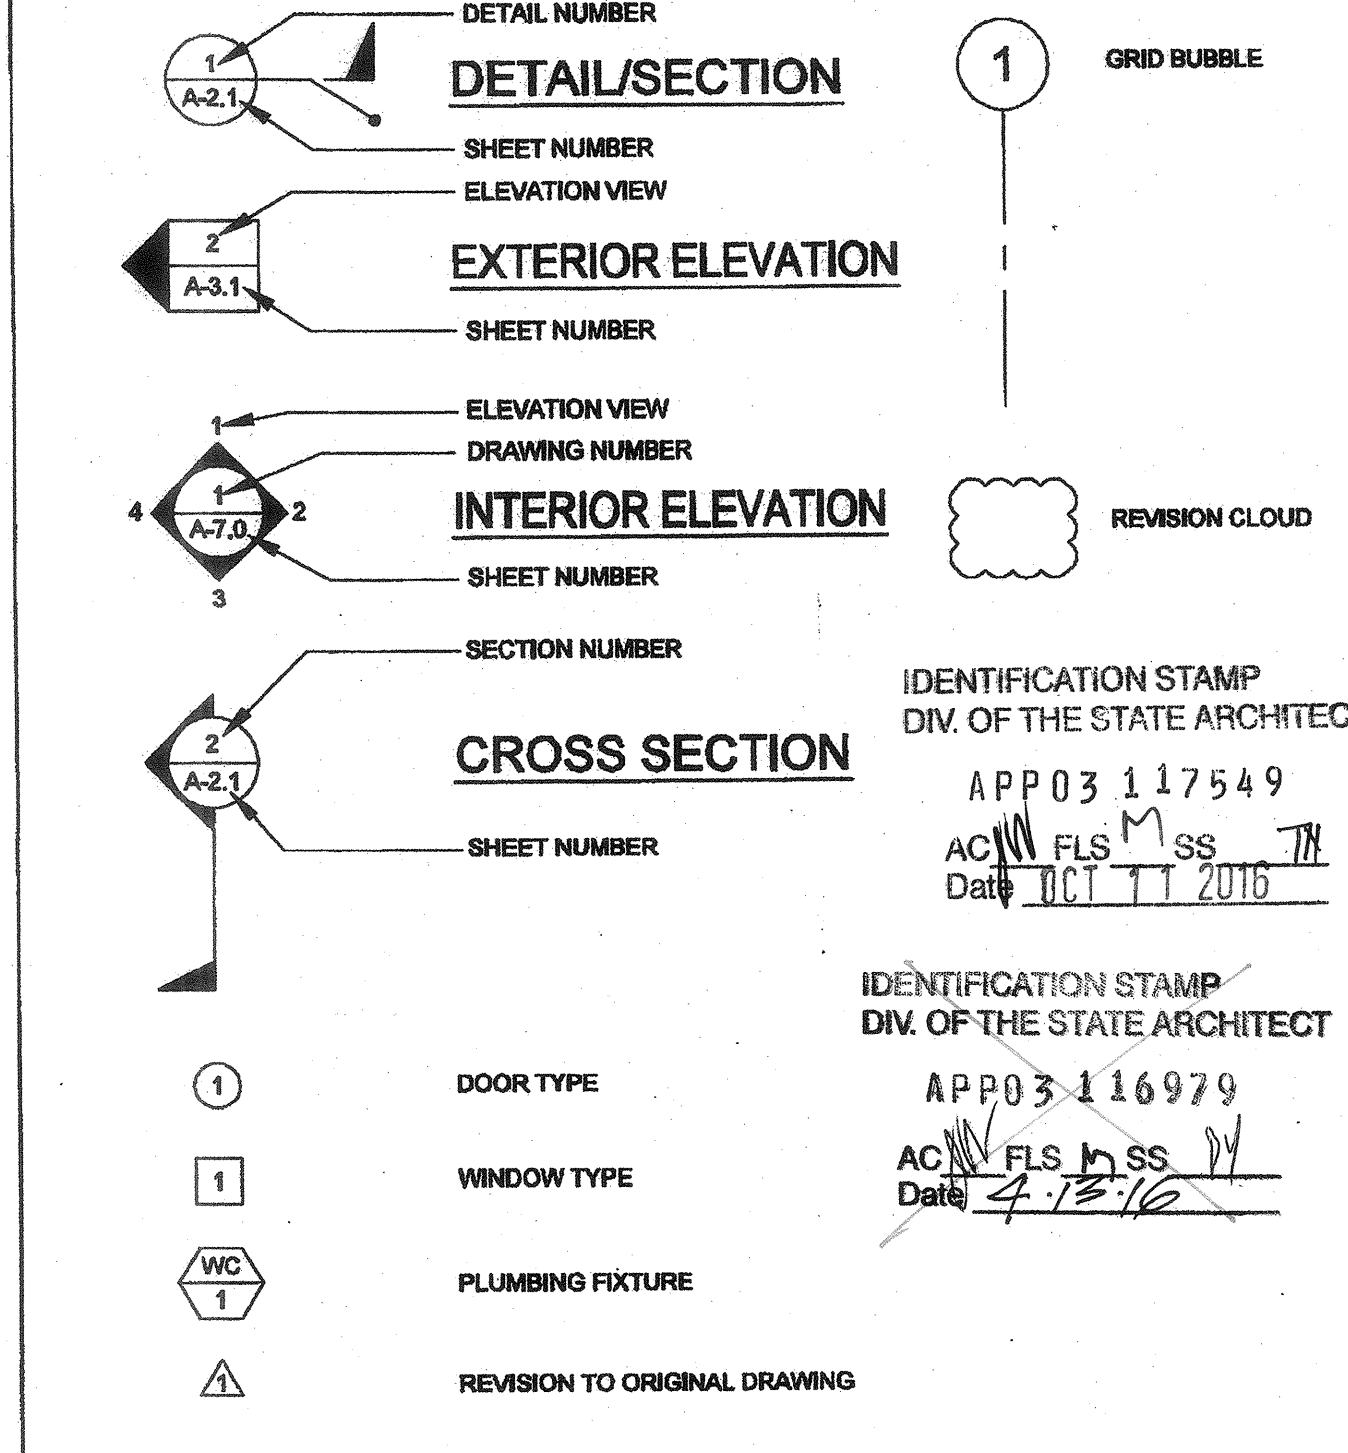

**ABBREVIATIONS**

AB ANCHOR BOLT	FA FIRE ALARM	PLATE
ABS ABSOLUTE	FCO FLOOR CLEAN OUT	PRE-CHECKED
ABV ABOVE ACCESS	FF FINISH FLOOR	PLASTER
ADDL ADDITIONAL	FG FINISH GRADE	PLYWOOD
ADJ ADJACENT	FIN FINISH	PANEL
AFF ABOVE FINISH FLOOR	FLR FLOOR	PNT POINT
AFG ABOVE FINISH GRADE	FN FIELD MAILING	POC POINT OF CONNECTION
AGC ALT ABOVE FINISH GRADE CONCRETE	FND FOUNDATION	PTH PATH OF TRAVEL
AIR ALTERNATE	FOC FACE OF CONCRETE	POT POUNDS PER SQUARE FOOT
AOR ARCHITECT OF RECORD	FOS FACE OF STUD	PSF POUNDS PER SQUARE INCH
APPROX APPROXIMATE	FTS FOOTING	PT PRESSURE TREATED
ARCH ARCHITECTURAL / ARCHITECT	FOF FACE OF FINISH	
BD BOARD	GA GAUGE	RAG RETURN AIR GRILLE
BGC BELOW GRADE CONCRETE	GALV GALVANIZED	RD ROOF DRAIN
BLDG BUILDING	GENL GENERAL CONTRACTOR	REF REGISTER
BLK BLOCK	GR GRADE	REINF REINFORCE
BLKG BLOCKING	GYP GYPSUM	REQD REQUIRED
BM BEAM	GYPB GYPSUM BOARD	REV REVISION
BOT BOTTOM		RF ROOF
BTWN BETWEEN		RM ROOM
BU BUILT UP		RO ROOF OPENING
		ROH ROOF OVERHANG
CAB CABINET	HB HOSE BIBB	SCHED SCHEDULE
CBC CALIFORNIA BUILDING CODE	HD HEAVY DUTY	SEC SECTION
CI CAST IRON	HDR HEADER	SHT SHEET
CJ CONTROL JOINT	HDW HARDWARE	SHTG SHEATHING
CJP COMPLETE JOINT PENETRATION	HT HORIZONTAL	SIM SIMILAR
	HWAC HEATING, VENTILATING, AND AIR CONDITIONING	SPEC SPECIFICATION
		SQ SQUARE
		SST STAINLESS STEEL
		STD STANDARD
		STFF STIFFENER
		STL STEEL
		STJ SELF-TAPPING SCREW
		STS STEEL TAPPING SHEET
		STSM METAL SCREW
		T&B TOP AND BOTTOM
		T&G TONGUE AND GROOVE
		TEL TELEPHONE
		THK THICK
		TOC TOP OF COLUMN
		TOS TOP OF STEEL
		TS TUBE STEEL
		TV TELEVISION
		TYP TYPICAL
		UBC UNIFORM BUILDING CODE
		UNO UNLESS OTHERWISE NOTED
		UR URINAL
		VERT VERTICAL
		VCT VINYL COMPOSITION TILE
		W WITH
		WC WATER CLOSET
		WCO WALL CLEAN OUT
		WD WOOD
		WH WATER HEATER
		WIC WOODWORK INSTITUTE OF CALIFORNIA
		WIND WINDOW
		W/O WITHOUT
		WP WATER PROOF

**SPECIFICATIONS**

- DIVISION 5 - METALS**  
06720 RAILINGS AND HANDRAILS:  
ALL WELDED JOINTS AND SURFACES SHALL BE GROUND SMOOTH, NO SHARP OR ABRASIVE CORNERS EDGES OR SURFACES. WALL SURFACES ADJACENT TO HANDRAIL SHALL BE SMOOTH.
- DIVISION 5 - DOORS**  
08710 DOOR HARDWARE:  
• IF THE DOOR HAS A CLOSER, THEN THE SWEEP PERIOD OF THE CLOSER SHALL BE ADJUSTED SO THAT FROM AN OPEN POSITION OF 70 DEGREES, THE DOOR WILL TAKE AT LEAST 3 SECONDS TO MOVE TO A POINT 3" FROM THE LATCH, MEASURED TO THE LANDING SIDE OF THE DOOR. 1138B.2.5.1.  
• ALL HARDWARE SHALL MEET THE REQUIREMENTS OF CBC SECTIONS 1138B.2.1, 1138B.2.2 AND 1008.1.9  
• THRESHOLDS SHALL COMPLY WITH CBC SECTIONS 1008.1 AND 1138B.2.4.7.  
• FLOOR STOPS SHALL NOT BE LOCATED IN THE PATH OF TRAVEL AND 4" MAXIMUM FROM WALLS POLICY 99-08
- 08712 EXIT DEVICES: (WHERE APPLICABLE)  
MAXIMUM EFFORT TO OPERATE DOORS SHALL NOT EXCEED 5 LB (22.2 N) FOR EXTERIOR AND INTERIOR DOORS. SUCH PULL OR PUSH EFFORT BEING APPLIED AT RIGHT ANGLES TO HINGED DOORS AND AT THE CENTER PLANE OF SLIDING OR FOLDING DOORS. COMPENSATING DEVICES OR AUTOMATIC DOOR OPERATORS MAY BE UTILIZED TO MEET THE ABOVE STANDARDS. WHEN FIRE DOORS ARE REQUIRED, 8LBS MAX OR THE MAXIMUM EFFORT TO OPERATE THE DOOR MAY BE INCREASED TO THE MAXIMUM ALLOWABLE BY THE APPROPRIATE ADMINISTRATIVE AUTHORITY, NOT TO EXCEED 15 LB (66.72 N) PER CBC SECTIONS 1008.1.9 AND 1138B.2.5 / ADAG 4.13.1  
HAND-ACTIVATED DOOR OPENING HARDWARE, HANDLES, PULLS, LATCHES, LOCKS, AND OTHER OPERATING DEVICES ON ACCESSIBLE DOORS SHALL HAVE A SHAPE THAT IS EASY TO GRASP WITH ONE HAND AND DOES NOT REQUIRE TIGHT GRASPING, TIGHT PINCHING, OR TWISTING OF THE WRIST TO OPERATE. MOUNTING HEIGHT OF LATCHING HARDWARE SHALL BE CENTERED BETWEEN 34 INCHES MIN AND 48 INCHES MAX ABOVE THE FLOOR PER CBC SECTION 1008.1.9.2. LATCHING AND LOCKING DEVICES THAT ARE HAND-ACTIVATED AND WHICH ARE IN A PATH OF TRAVEL SHALL BE OPERABLE WITH A SINGLE EFFORT BY LEVER-TYPE HARDWARE. PANIC BARS, PUSH-PULL ACTIVATING BARS OR OTHER HARDWARE DESIGNED TO PROVIDE PASSAGE. LOCKED EXIT DOOR SHALL OPERATE AS ABOVE IN OTHER DIRECTION PER CBC SECTION 1008.1.2
- PANIC HARDWARE SHALL NOT BE PROVIDED WITH "NIGHT LATCH" FUNCTION FOR ANY ACCESSIBLE DOORS OR GATES UNLESS THE FOLLOWING CONDITIONS ARE MET PER DSA INTERPRETATION 10-08 DSA/C. SUCH CONDITIONS MUST BE CLEARLY DEMONSTRATED AND INDICATED IN THE SPECIFICATIONS:  
• SUCH HARDWARE HAS A "DOGGING" FEATURE.  
• IT IS DOGGED DURING THE TIME THE FACILITY IS OPEN.  
• SUCH "DOGGING" OPERATION IS PERFORMED ONLY BY EMPLOYEES AS THEIR JOB FUNCTION (NON-PUBLIC USE).
- DIVISION 9 - FINISHES**  
09650 RESILIENT FLOORING:  
RESILIENT FLOORING DEMONSTRATING A COEFFICIENT OF FRICTION OF AT LEAST 0.6 PER ASTM D2047. WILL BE ACCEPTED AS MEETING THE INTENT OF SLIP RESISTANCE.
- 09880 CARPET:  
CARPET SHALL HAVE A LEVEL LOOP, TEXTURED LOOP, LEVEL-CUT, OR LEVEL-CUT/OUTLAIN PILE TEXTURE AND MAXIMUM PILE HEIGHT OF 1/2" PER CBC SECTION 1124B.3.  
CARPET EDGES SHALL COMPLY WITH CBC 1124B.2.
- DIVISION 10 - SPECIALTIES**  
10156 TOILET COMPARTMENTS: CBC SECTION 1115B.3.1.4.4 AND 1115B.3.1.4.5  
TOILET STALLS FOR DISABLED PERSONS SHALL HAVE SLIDE BOLT DOOR LATCH, U-SHAPE OR WIRE PULLS BOTH SIDES OF THE DOOR AND SELF-CLOSING HINGES. DOORS HARDWARE SHALL BE MOUNTED AT 34" MIN TO 48" MAX ABOVE FINISHED FLOOR. DOORS AT SIDE ENTRY STALLS SHALL HAVE 32" MINIMUM CLEAR WIDTH WHEN THE DOOR IS OPEN 90°. DOORS AT FRONT ENTRY STALLS SHALL HAVE 34" MINIMUM CLEAR WIDTH WHEN THE DOOR IS OPEN 90°.
- 10800 TOILET ACCESSORIES:  
TOILET ACCESSORIES REQUIRED TO BE ACCESSIBLE SHALL BE MOUNTED AT HEIGHTS ACCORDING TO CBC SECTION 1115B.4. THE GRAB BAR CAN NOT PROJECT MORE THAN 2" INTO THE 48" MINIMUM CLEAR SPACE IN FRONT OF THE WATER CLOSET 1115B.4.1.3. TOILET PAPER AND FEMININE NAPKIN DISPENSERS LOCATED ON THE GRAB BAR SIDE OF AN ACCESSIBLE TOILET ROOM OR STALL SHOULD NOT PROJECT MORE THAN THE GRAB BAR. THE ACCESSORY SHALL NOT BE LOCATED CLOSER THAN 1 1/2" CLEAR OF THE TANGENT POINT OF THE GRAB BAR. ACCESSORIES SURFACE MOUNTED ABOVE GRAB BAR WILL RESTRICT USABILITY.
- DIVISION 16 - MECHANICAL**  
16400 PLUMBING FIXTURES:  
ACCESSIBLE PLUMBING FIXTURES SHALL COMPLY WITH ALL OF THE REQUIREMENTS OF CBC SECTION 1115B. HEIGHTS AND LOCATION OF ALL FIXTURES SHALL BE ACCORDING TO CBC TABLE 1115B-1. FIXTURE CONTROLS SHALL COMPLY WITH CBC SECTION 1115B.






THESE DRAWINGS AND ALL MATERIAL CONTAINED HEREIN ARE THE PROPERTY OF SILVERCREEK INDUSTRIES, INC. (SCI INC) AND SHALL NOT BE REPRODUCED, COPIED OR OTHERWISE DISPOSED OF DIRECTLY OR INDIRECTLY AND SHALL NOT BE USED IN WHOLE OR IN PART TO ASSIST IN THE MAKING OF OR FOR THE PURPOSE OF FURNISHING ANY INFORMATION FOR THE MAKING OF DRAWINGS, PRINTS, APPARATUS OR PARTS THEREOF WITHOUT THE FULL KNOWLEDGE AND WRITTEN CONSENT OF SCI INC. ALL PATENTABLE MATERIAL CONTAINED HEREIN AND ORIGINATING WITH SCI INC SHALL BE THE PROPERTY OF SCI INC.



**CLASS LEASING CLASSROOMS BLDG'S**

PROJECT NAME:  
SHEET TITLE:

**SYMBOLS LEGEND, ABBREVIATIONS & ADA SIGNAGE**

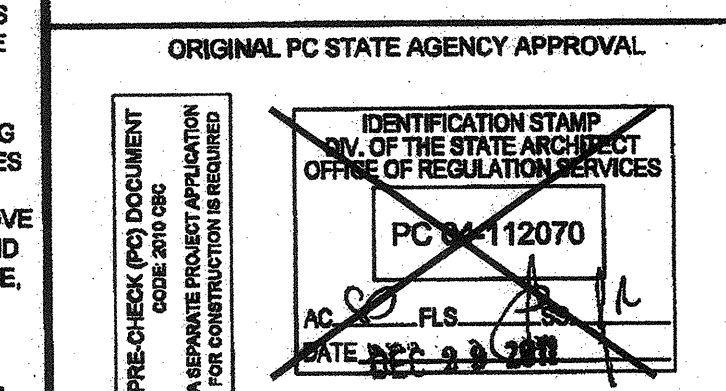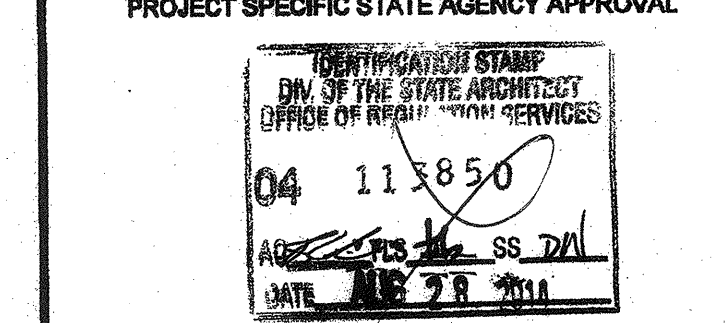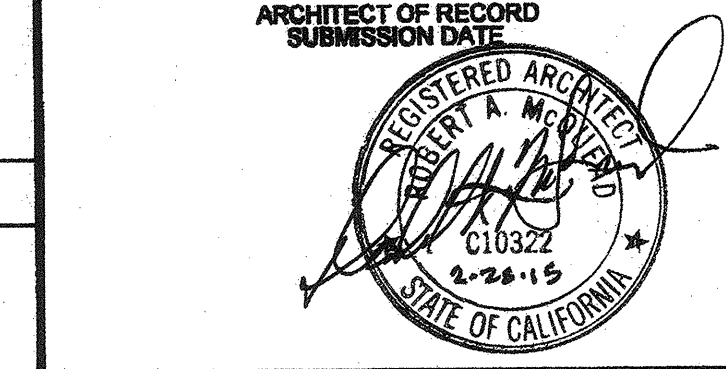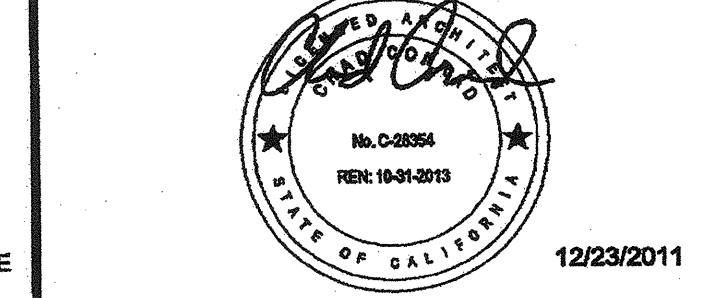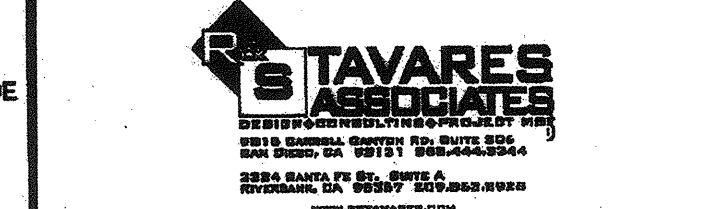

REVISIONS

NO.	DESCRIPTION	DATE
1	PER PROJECT SPECIFIC REQUIREMENTS - 03.13.2014 SIGNAGE	

SILVER CREEK INDUSTRIES  
30' x 32' PC

PROJECT NO:  
DRAWN BY:  
SCALE: AS NOTED  
DATE: 6-17-11  
P.C. SHEET NUMBER

**A-0.1**