


FIRE ALARM SITE PLAN NOTES

- 1 DEVICES SHOWN ON THIS PLAN ARE EXISTING, TYPICAL.
- 2 REFER TO SHEET E-2 FOR WORK IN THIS AREA.
- 3 CONTRACTOR SHALL DISCONNECT AND RECONNECT ALL ZONES ASSOCIATED WITH EXISTING BUILDINGS AND PROVIDE TESTING FOR POSITIVE REPORTING. PROVIDE FIRE WATCH DURING IMPAIRMENT OF SYSTEM PER NFPA AND CFC ARTICLE 87.
- 4 PREVIOUS MAIN FIRE ALARM PANEL WAS DESTROYED DUE TO A LIGHTNING STRIKE. THE PREVIOUS SYSTEM DID NOT HAVE A DSA APPLICATION NUMBER.

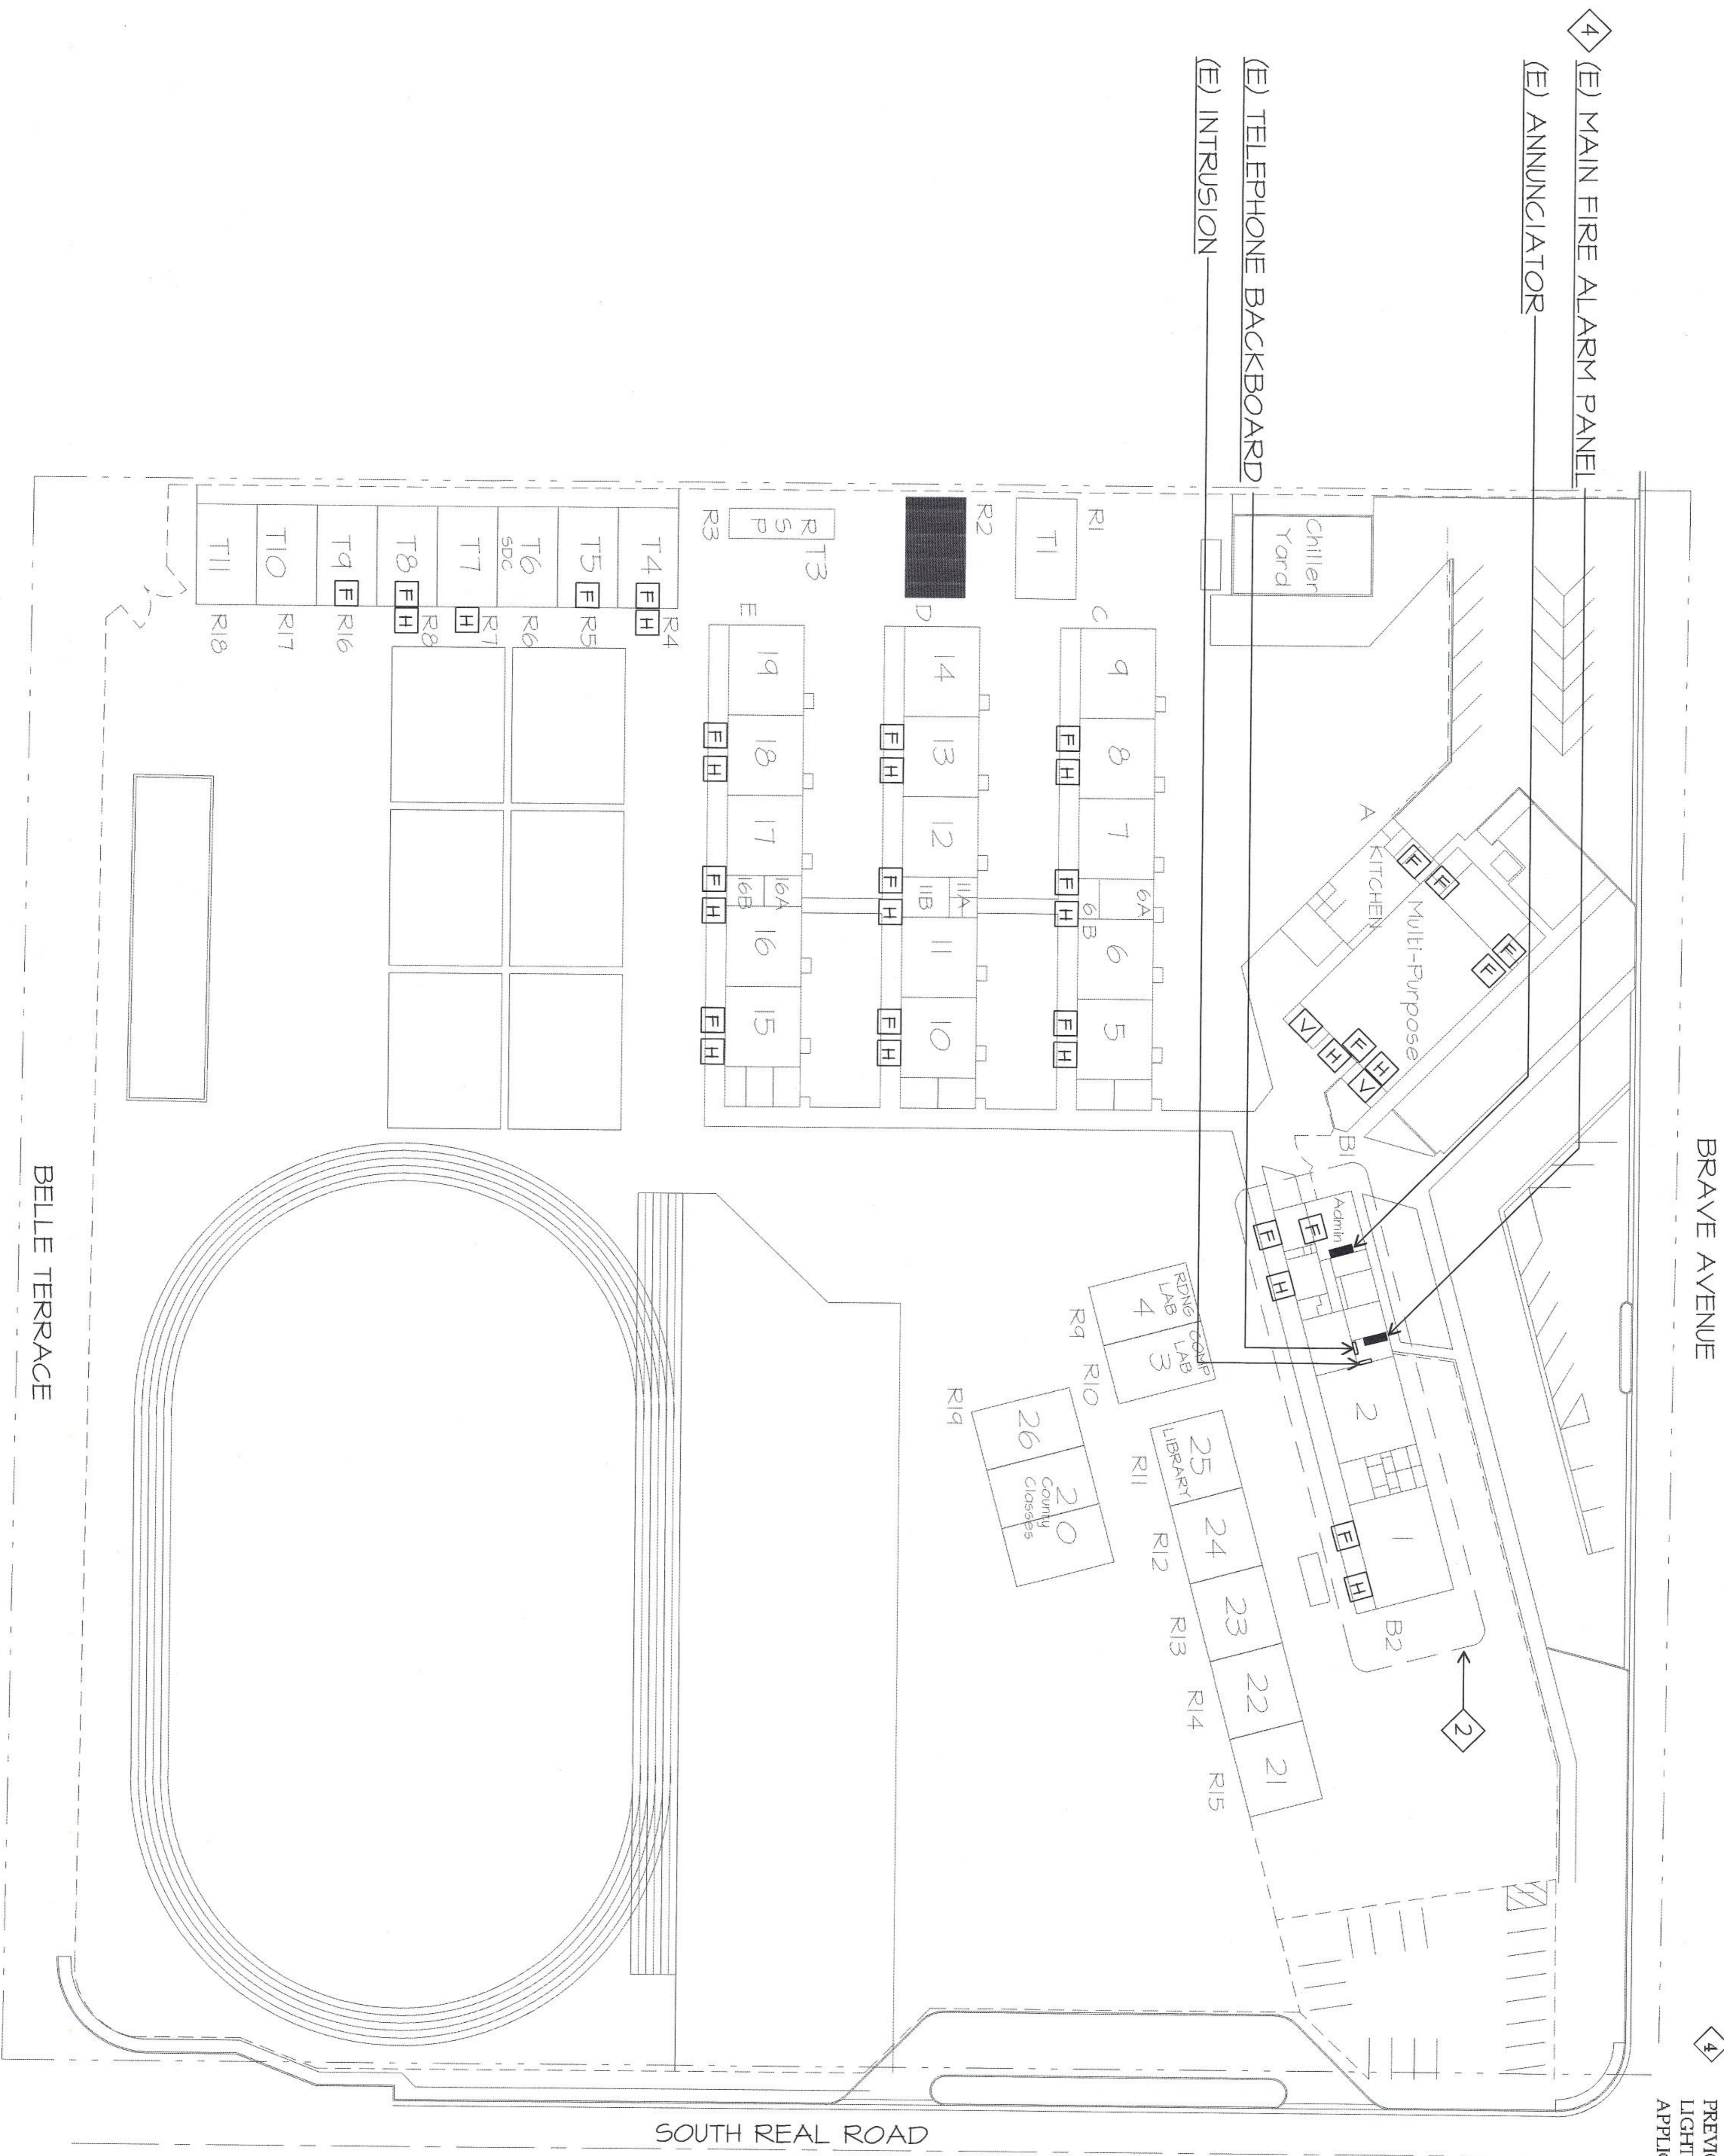


BELLE TERRACE

SOUTH REAL ROAD

BRAVE AVENUE

FIRE ALARM SITE PLAN 3

SCALE: 1"=30'-0"

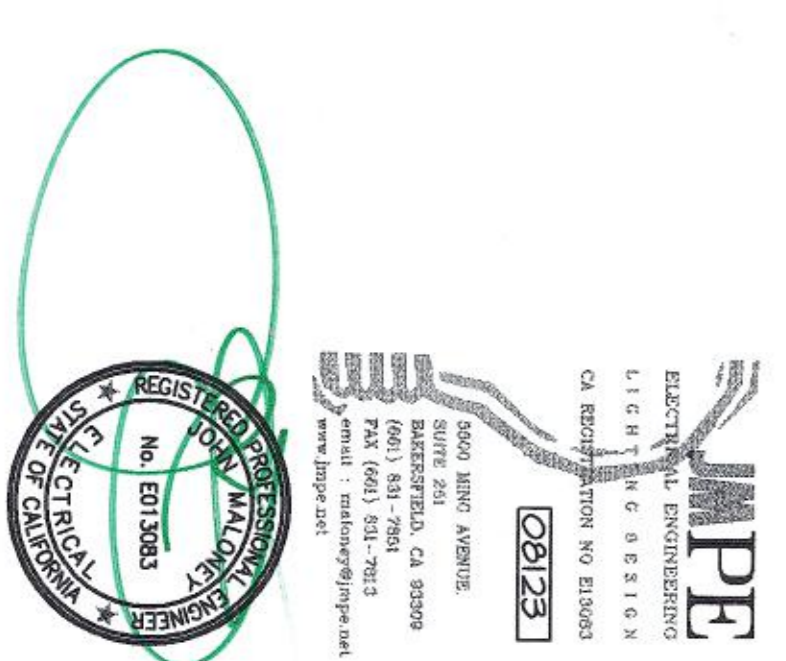

J. A. ROMO
 REGISTERED PROFESSIONAL ENGINEER
 LICENSE NO. 1140
 EXPIRES 12/31/2025
 STATE OF CALIFORNIA
 CIVIL ENGINEERING
 1140
 #P1141 F.A. Romo
 DRAWN BY:

CHECK AND VERIFY ALL DIMENSIONS BEFORE REPORTING TO THE CONTRACTOR.
 THE DRAWINGS, TITLES, AND DESIGNS ARE THE PROPERTY OF THE ARCHITECT AND SHALL NOT BE REPRODUCED OR TRANSMITTED IN ANY FORM OR BY ANY MEANS, ELECTRONIC OR MECHANICAL, INCLUDING PHOTOCOPYING, RECORDING, OR BY ANY INFORMATION STORAGE AND RETRIEVAL SYSTEM, WITHOUT THE WRITTEN PERMISSION OF THE ARCHITECT.

FIRE ALARM SITE PLAN
 SHEET IDENTIFICATION NUMBER
E-1
 SHEET #4/NO. OF

ORDIZ MELBY ARCHITECTS, INC.
 5500 KING AVENUE SUITE 200
 BAKERSFIELD, CALIFORNIA 93309
 TELEPHONE (805) 332-4226
 FACSIMILE (805) 332-4291

IDENTIFICATION STAMP
 DIVISION OF STATE ARCHITECT
 OFFICE OF REGULATION SERVICES
 APRIL 03, 2025
 FILE # 156
 DATE APR 14 2025

LEGEND ARCHITECT
 No. C-11728
 Exp. 12/31/2025
 STATE OF CALIFORNIA

DANK E. ORDOZ
 DAN E. ORDOZ, AIA
 ARCHITECT C14,728
 WILLIAM J. MELBY, AIA
 ARCHITECT C-16,835

FIRE ALARM MAIN PANEL REPLACEMENT AT MUNSEY ELEMENTARY FOR: BAKERSFIELD CITY SCHOOL DISTRICT
 1300 BAKER STREET, BAKERSFIELD, CALIFORNIA 93305

MARK	DATE	DESCRIPTION
△		
△		
△		