



**BUILDING FIRE ALARM PLAN NOTES**

- 1 FIRE ALARM PANEL CONNECTED TO DEDICATED CIRCUIT K-11.

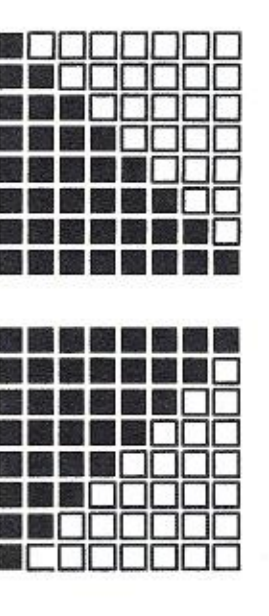

ORDIZ  
MELBY  
ARCHITECTS, INC.  
5500 KING AVENUE, SUITE 200  
BAKERSFIELD, CALIFORNIA 93309  
TELEPHONE (805) 832-5258  
FACSIMILE (805) 832-4291

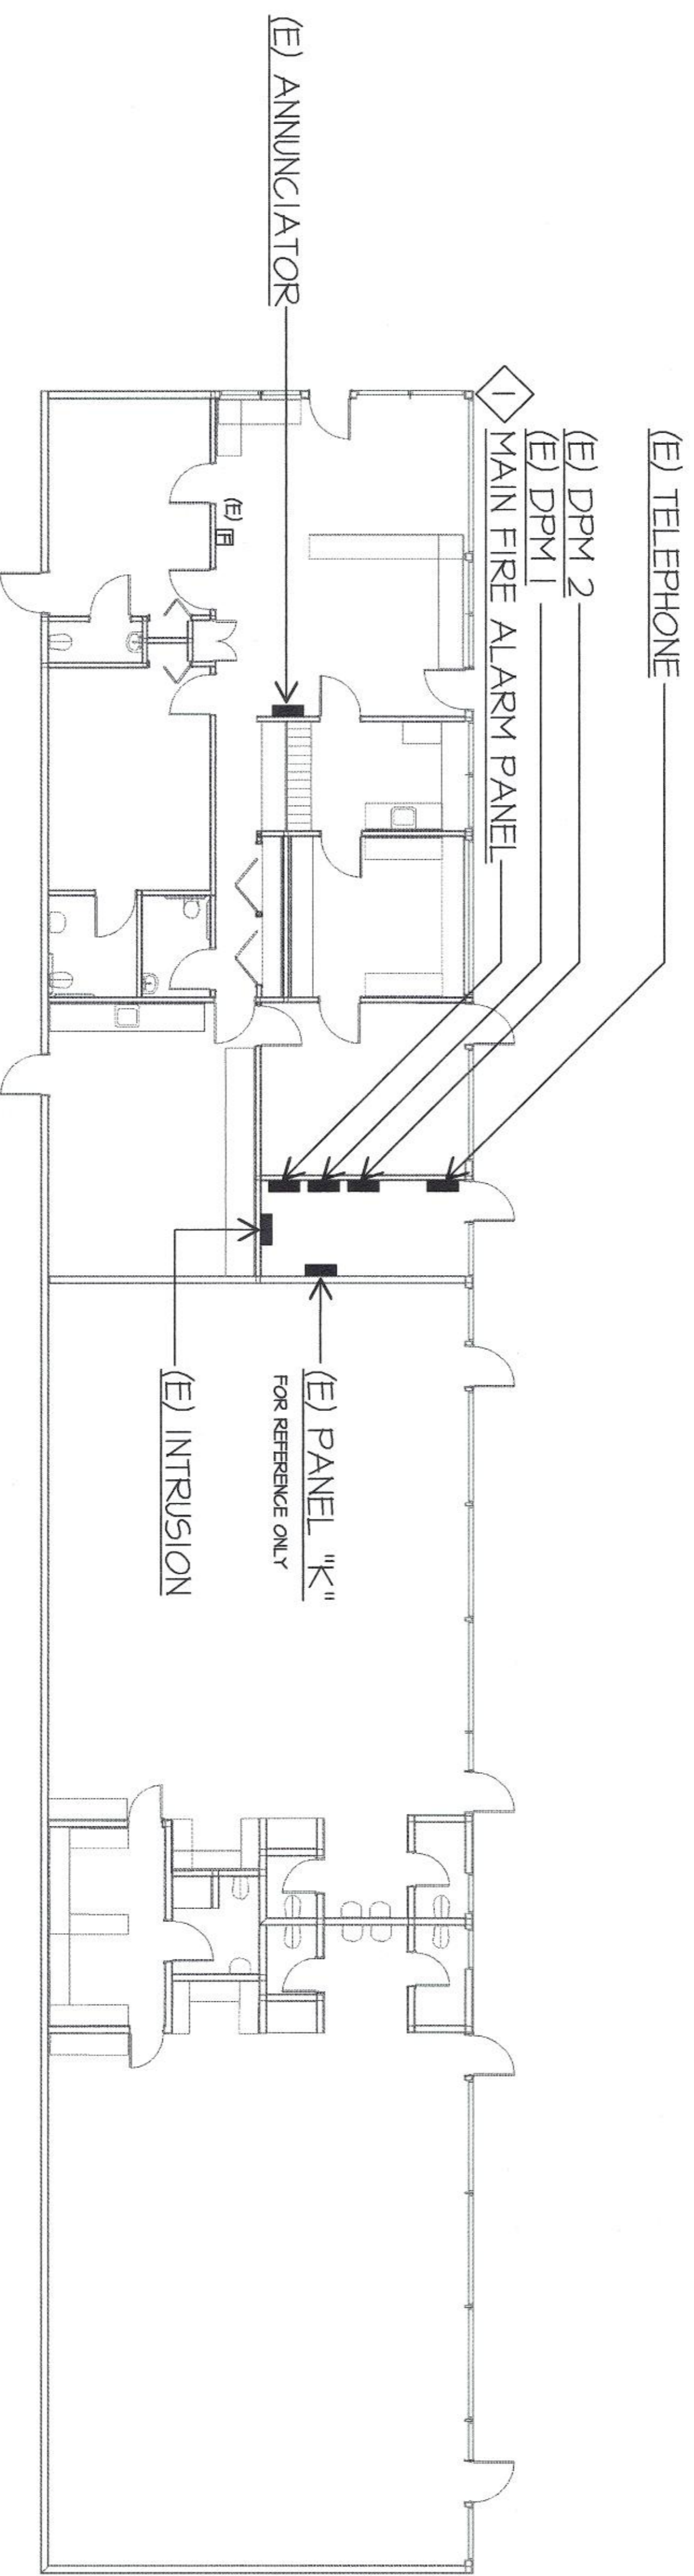

WILLIAM J. MELBY, AIA  
ARCHITECT C-14,728  
ARCHITECT C-16,835



**FIRE ALARM  
MAIN PANEL REPLACEMENT  
AT MUNSEY ELEMENTARY  
ELEMENTARY**  
FOR:  
**BAKERSFIELD  
CITY  
SCHOOL  
DISTRICT**

1300 BAKER STREET  
BAKERSFIELD,  
CALIFORNIA  
93305

MARK	DATE	DESCRIPTION
△		
△		
△		
△		
△		



CAD DRAWING FILE  
1140  
#P1140 F.A. Replacement.pln  
DRAWN BY

CHECKED BY:  
CHECK AND VERIFY ALL DIMENSIONS BEFORE  
REPORT DIMENSIONS TO THE ARCHITECT.  
THE DRAWING, SEAL AND SIGNATURE  
ARE THE PROPERTY OF THE ARCHITECT.  
ORDIZ MELBY ARCHITECTS, INC. 2008

SHEET TITLE  
**ADMINISTRATION  
BUILDING  
FIRE ALARM  
PLAN**  
SHEET IDENTIFICATION NUMBER  
**E-2**  
SHEET #1400 OF

**ADMINISTRATION BUILDING FIRE ALARM PLAN**

SCALE: 1/8" = 1'-0"

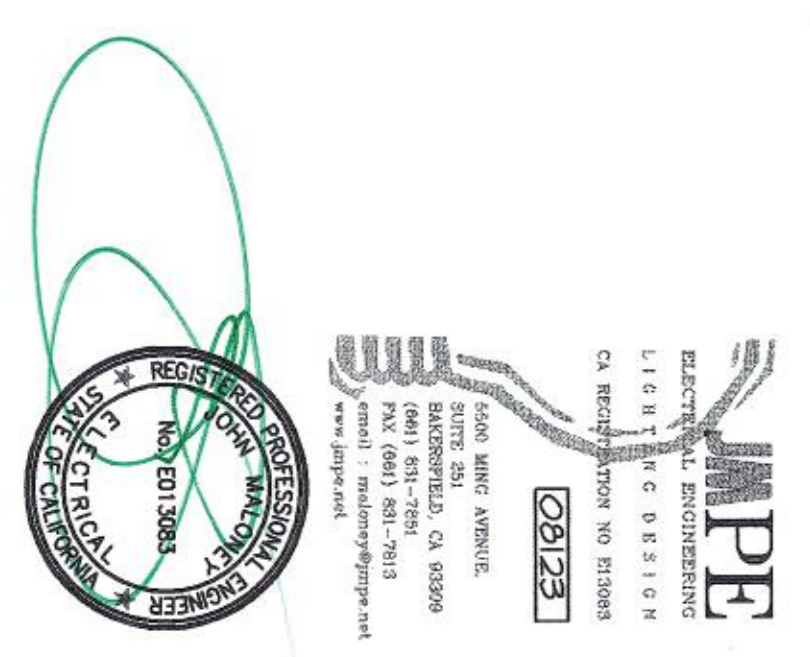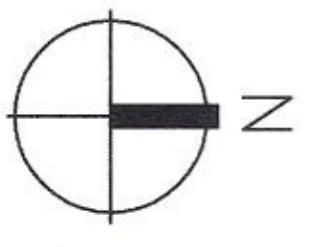

WILLIAM J. MELBY, AIA  
ARCHITECT C-14,728  
ARCHITECT C-16,835