




UNIT A

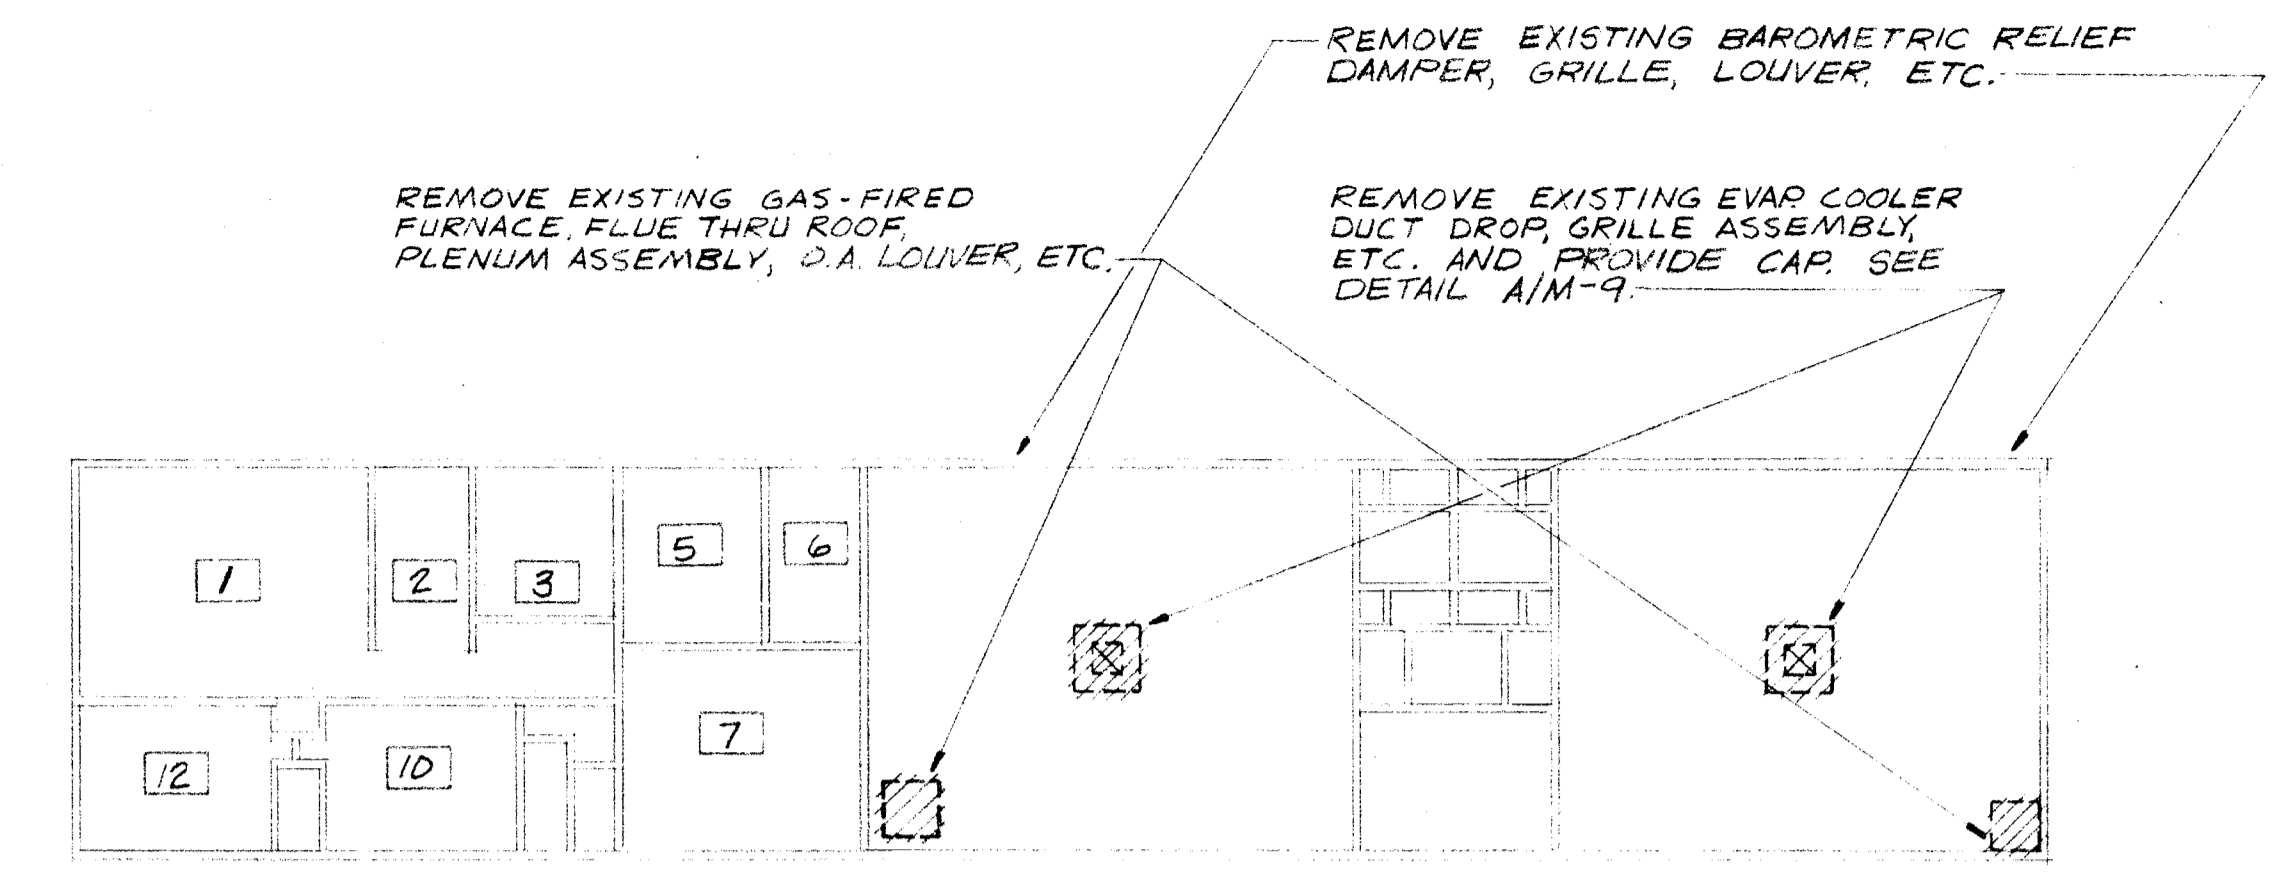


UNIT B

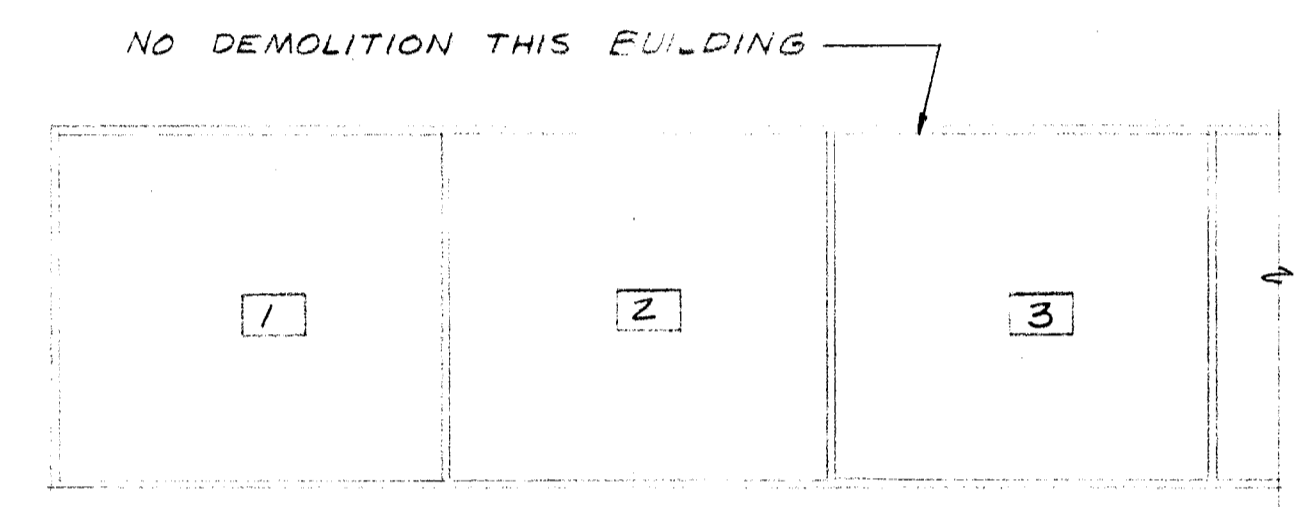


UNIT R5

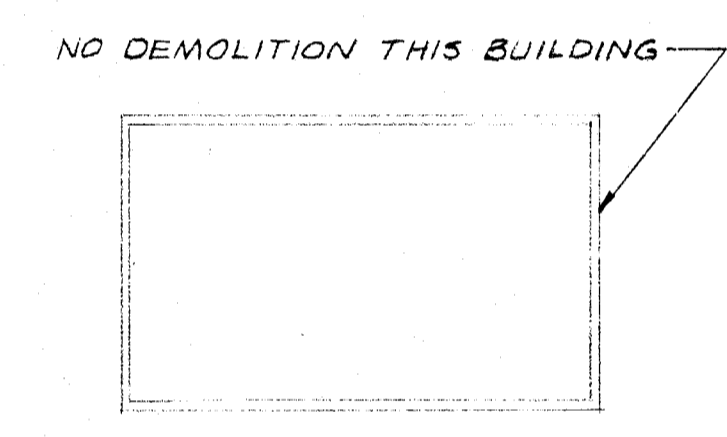


UNIT R1

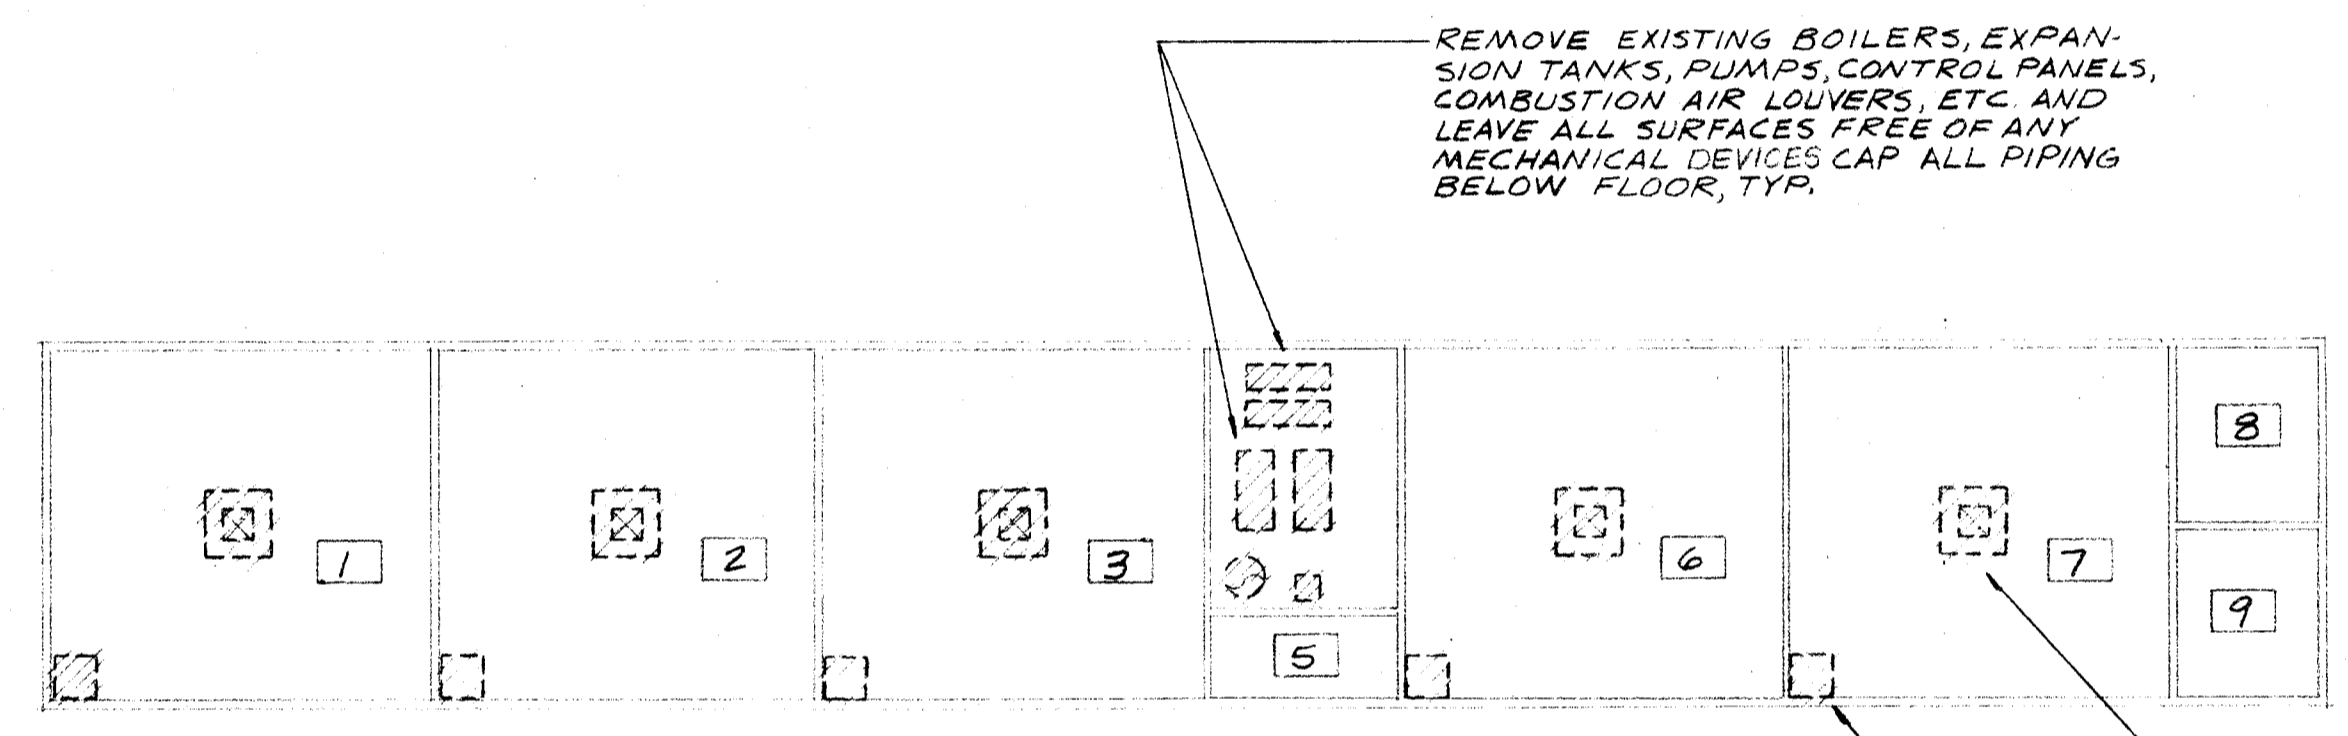


UNIT C

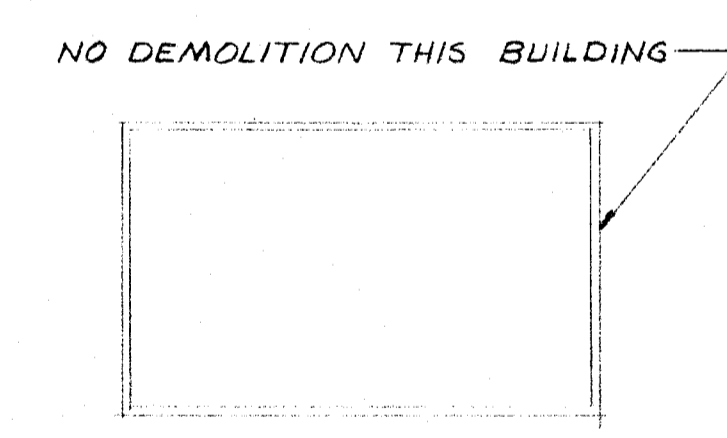

UNIT R2

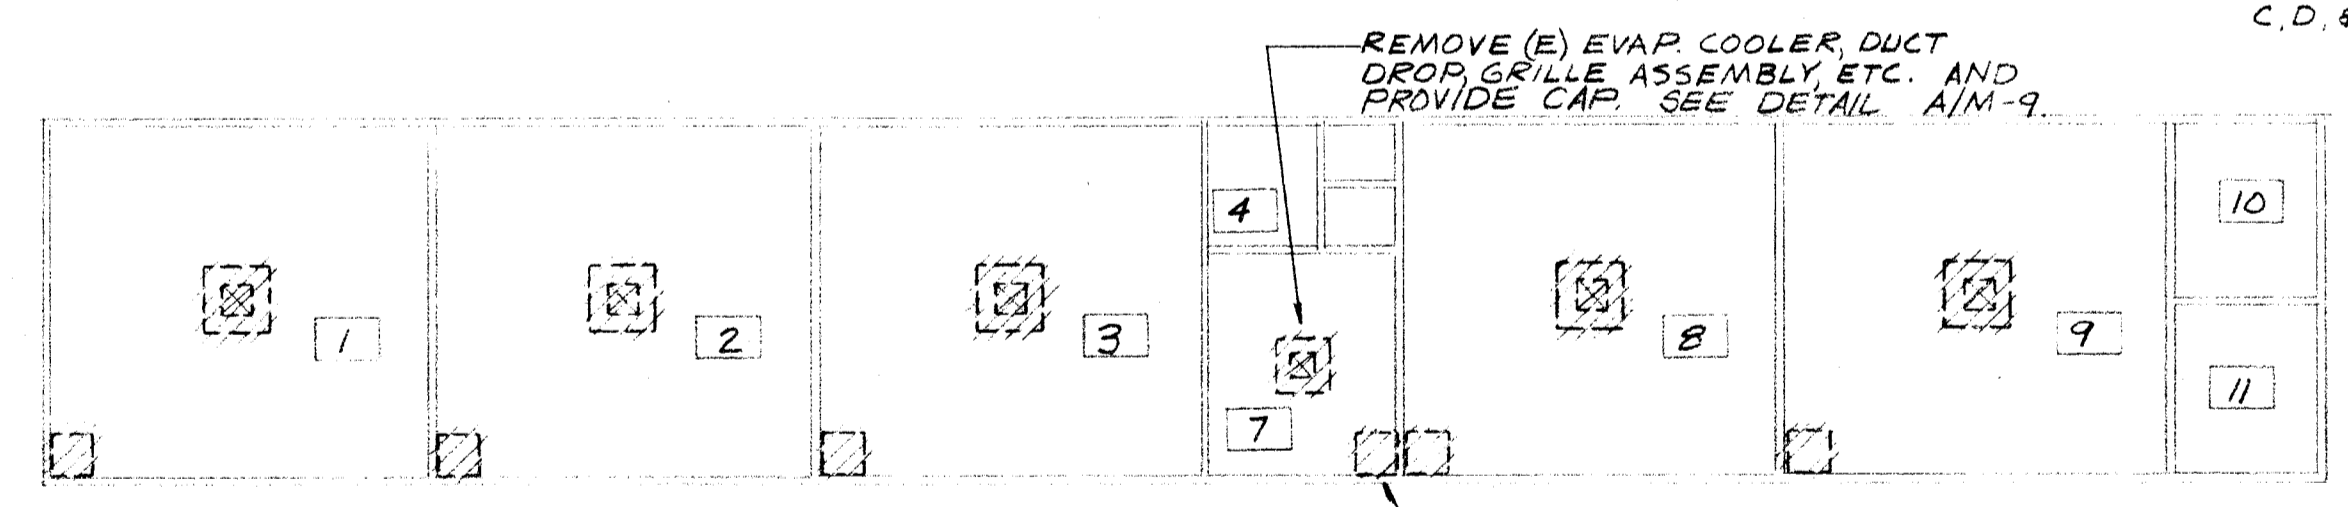


UNIT D

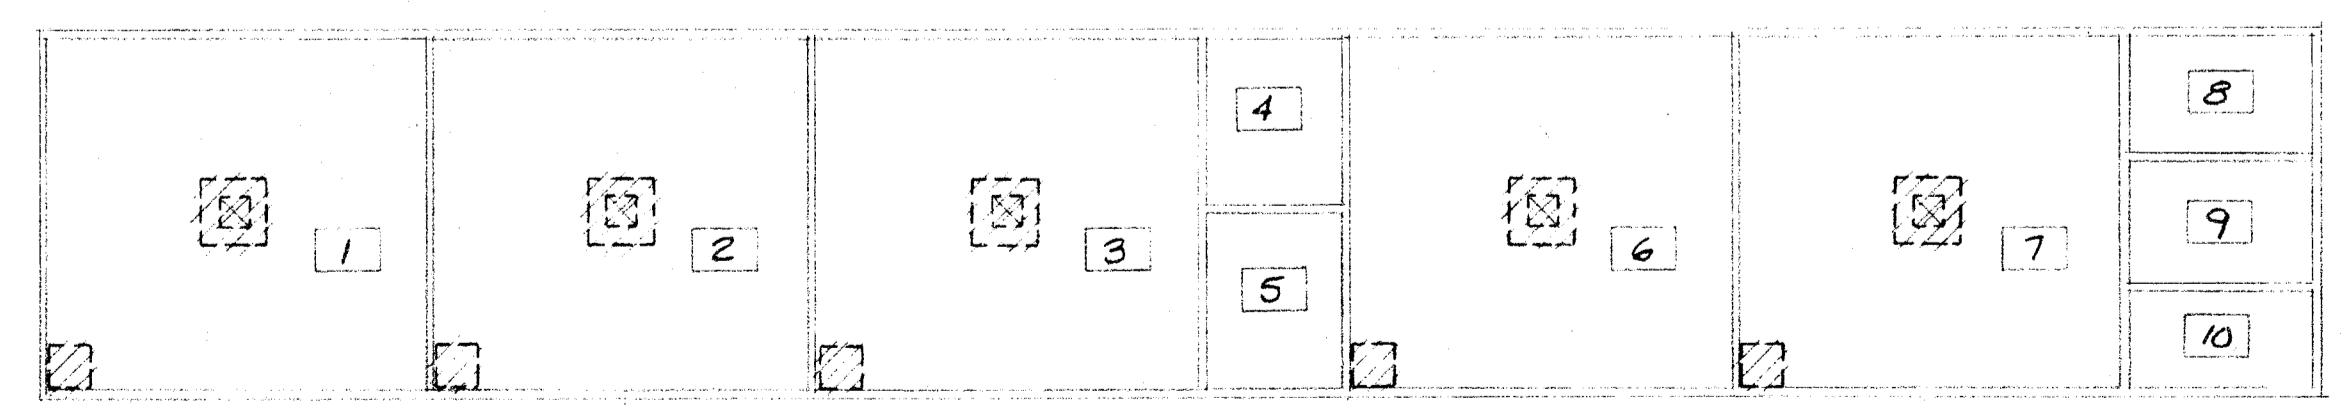

UNIT E

- DEMOLITION NOTES:**
- DEMOLITION OF ANY HVAC CONTROL DEVICES BY SPECIFICATION SECTION 15800.
 - DEMOLITION OF GAS AND DOMESTIC WATER PIPING BY SPECIFICATION SECTION 15400. SEE PLUMBING DRAWINGS.
 - SEE AIR CONDITIONING FLOOR PLANS FOR ANY ADDITIONAL NOTES ON DEMOLITION OF EXISTING MECHANICAL ITEMS.

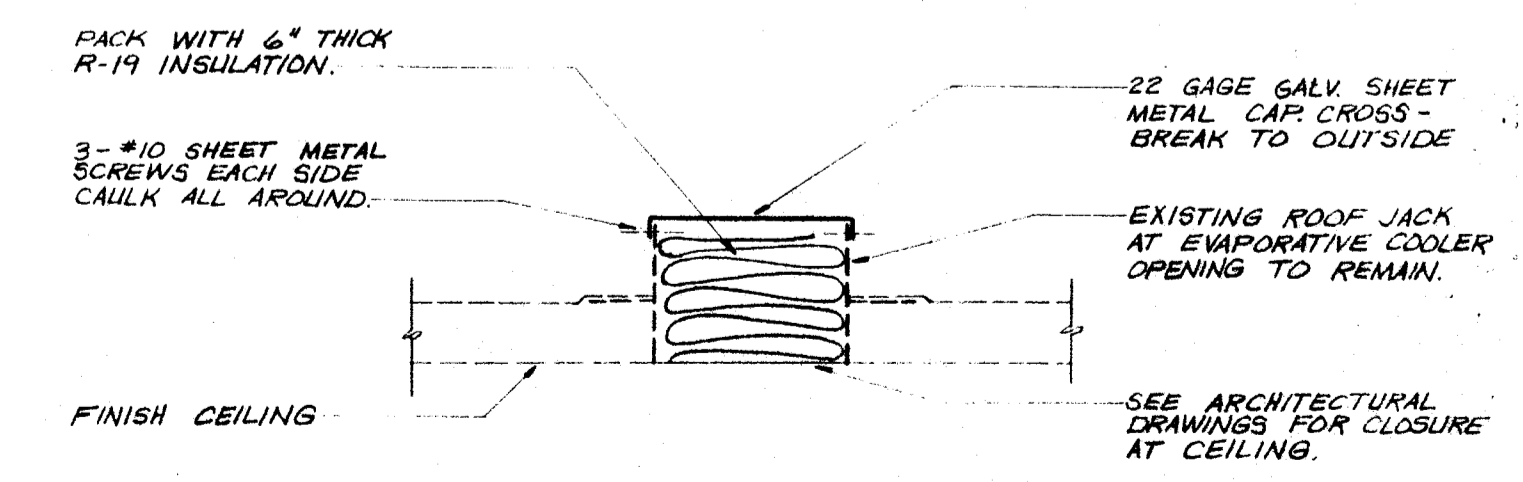

DETAIL
NO SCALE

DEMOLITION PLANS
SCALE: 1/16" = 1' - 0"

A
M-9