
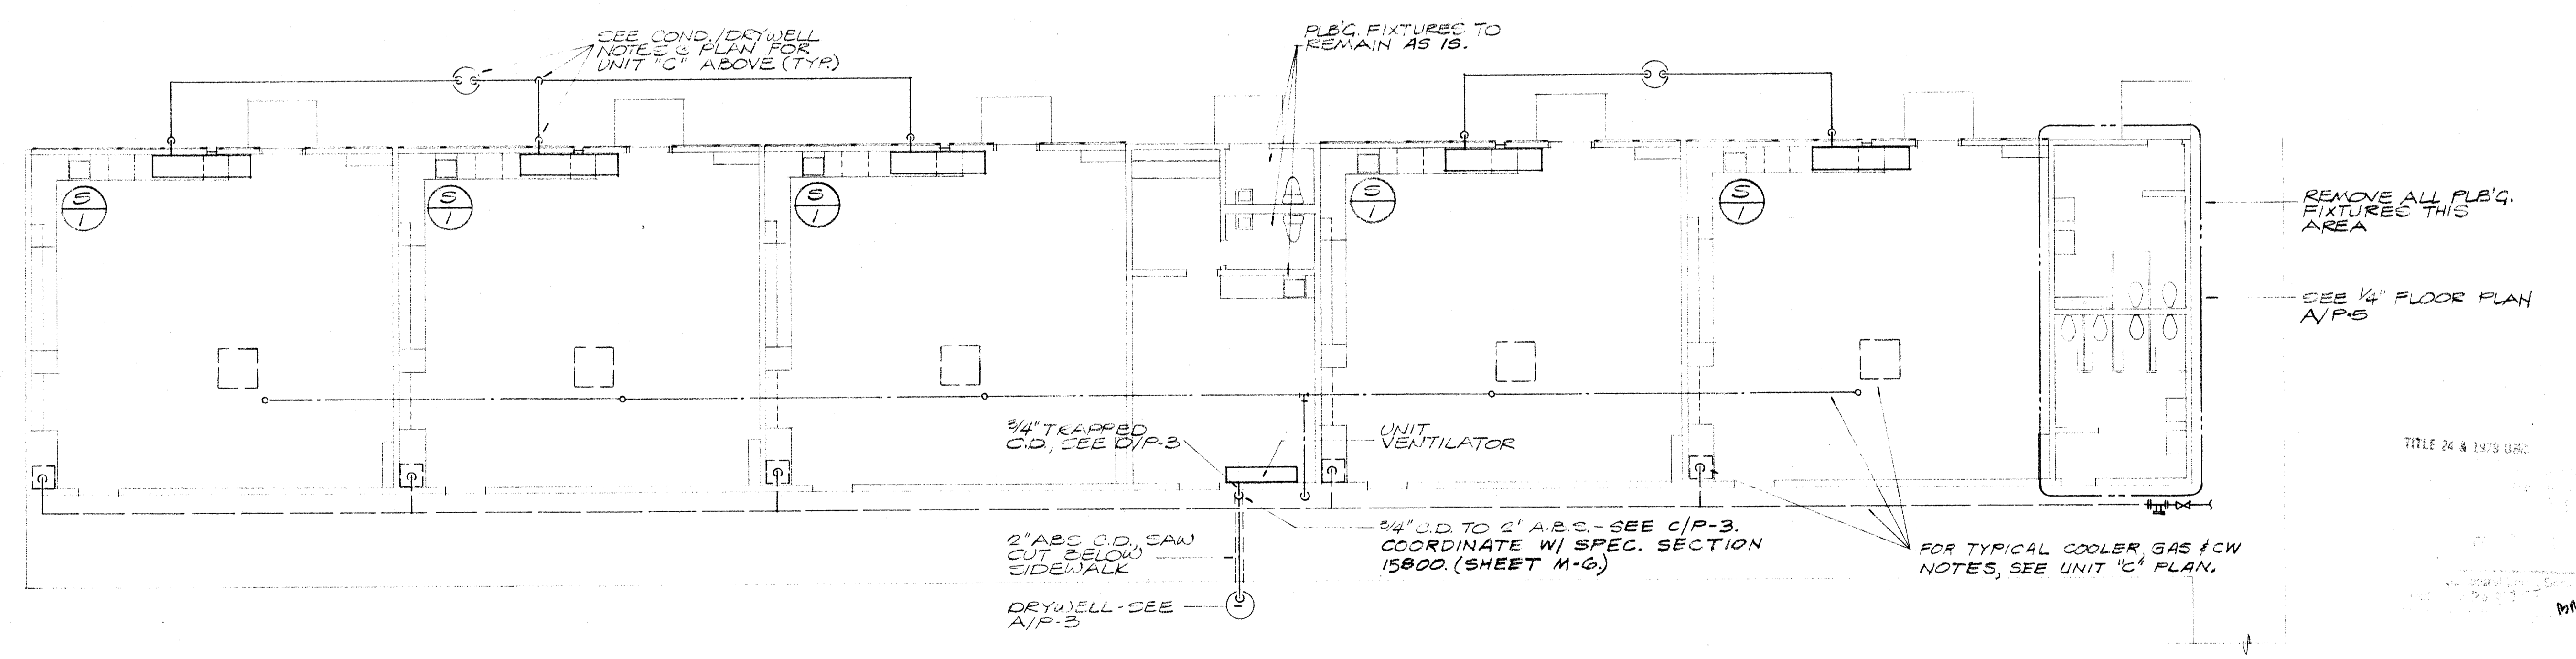



PLUMBING FLOOR PLAN UNIT C 
SCALE: 1/8" = 1'-0"



PLUMBING FLOOR PLAN UNIT D 
SCALE: 1/8" = 1'-0"

MUNSEY SCHOOL MODERNIZATION
BAKERSFIELD CITY SCHOOL DISTRICT
BAKERSFIELD, CALIFORNIA

APPROVED
Department of General Services
Office of the Chief Architect
FEB 27 1990
Structural Safety Section
Clerk of the Board

FRANK MITCHELL 412810 Expires 9/1/90
JOHN FRANK MITCHELL, INC.
CONSULTING MECHANICAL ENGINEERS
444 WEST BAKER, SUITE 107
FRESNO, CALIFORNIA 93718
PHONE 875-3398

Kendrick Design Group
architects • planners

2115 19th Street, Bakersfield, CA 93301 • (805) 322-1863

job number
8712

sheet number
P-4
OF 6