




TABLE & SINK  
1/4" = 1'-0"

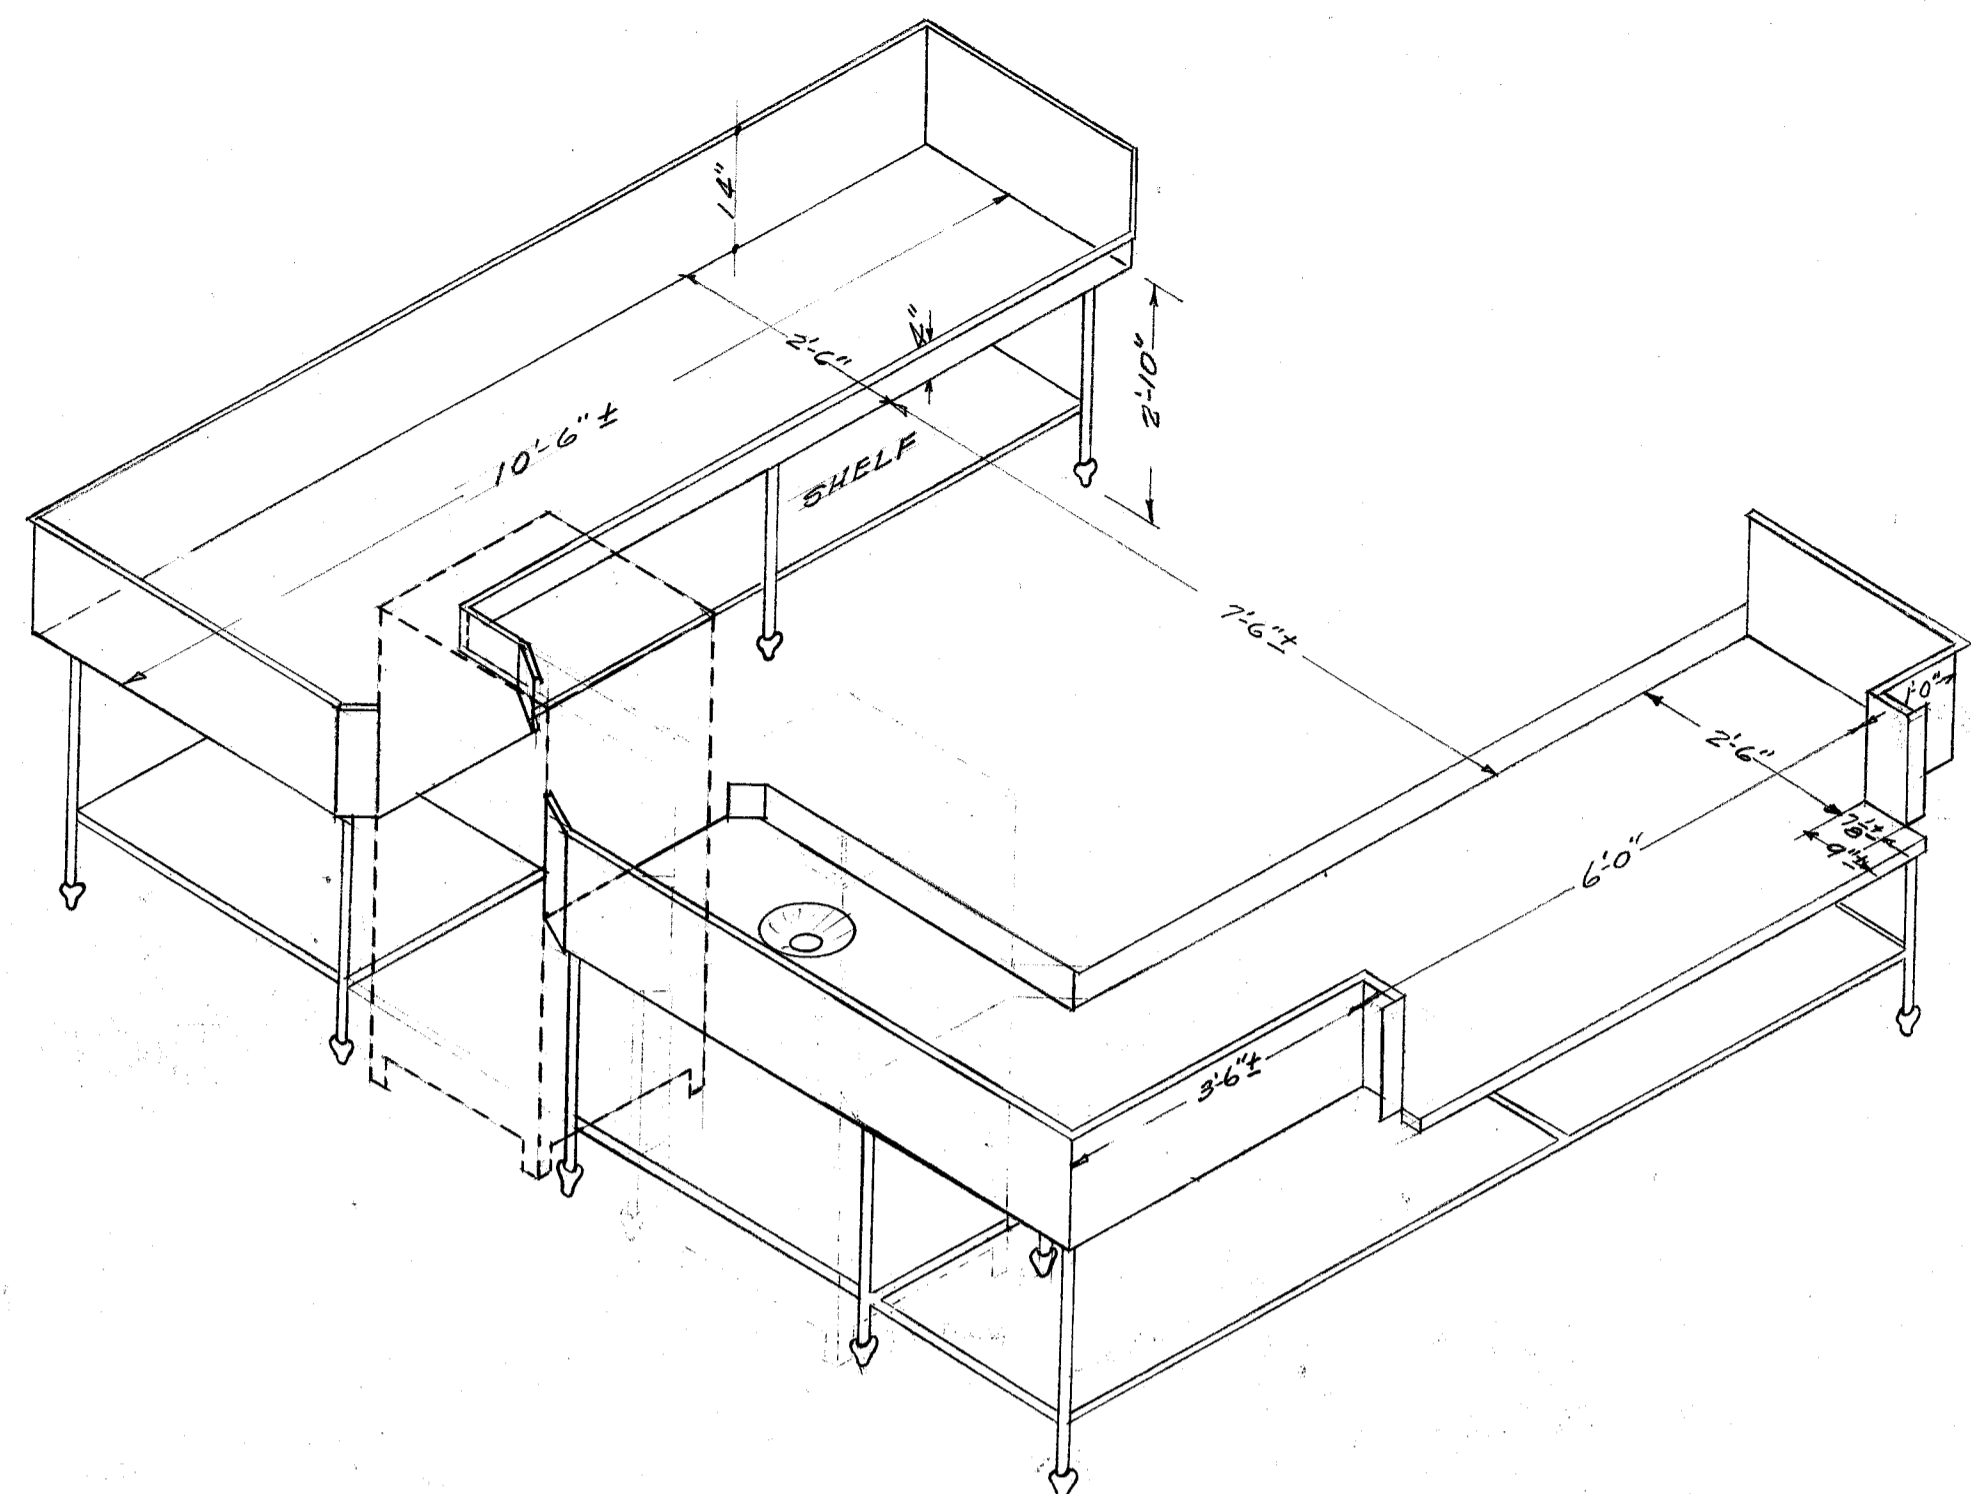

DISH TABLES  
1/4" = 1'-0"

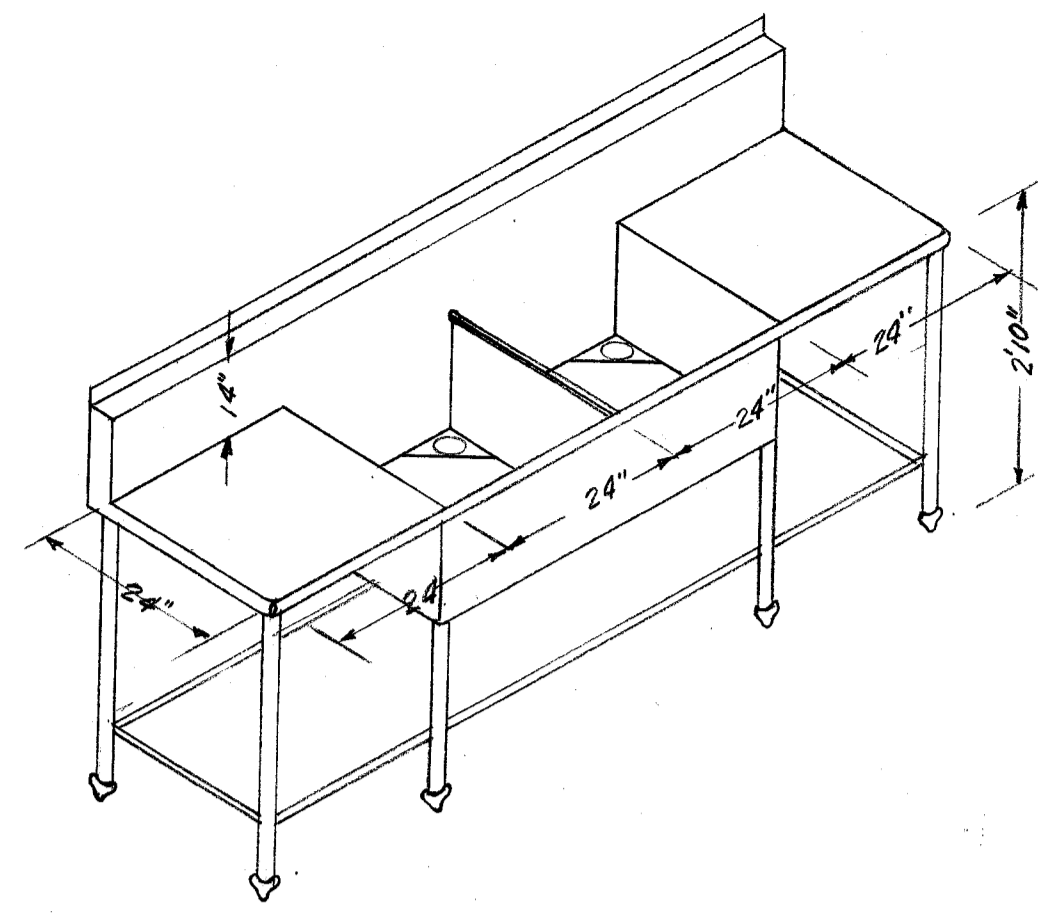


KITCHEN SINK  
1/4" = 1'-0"

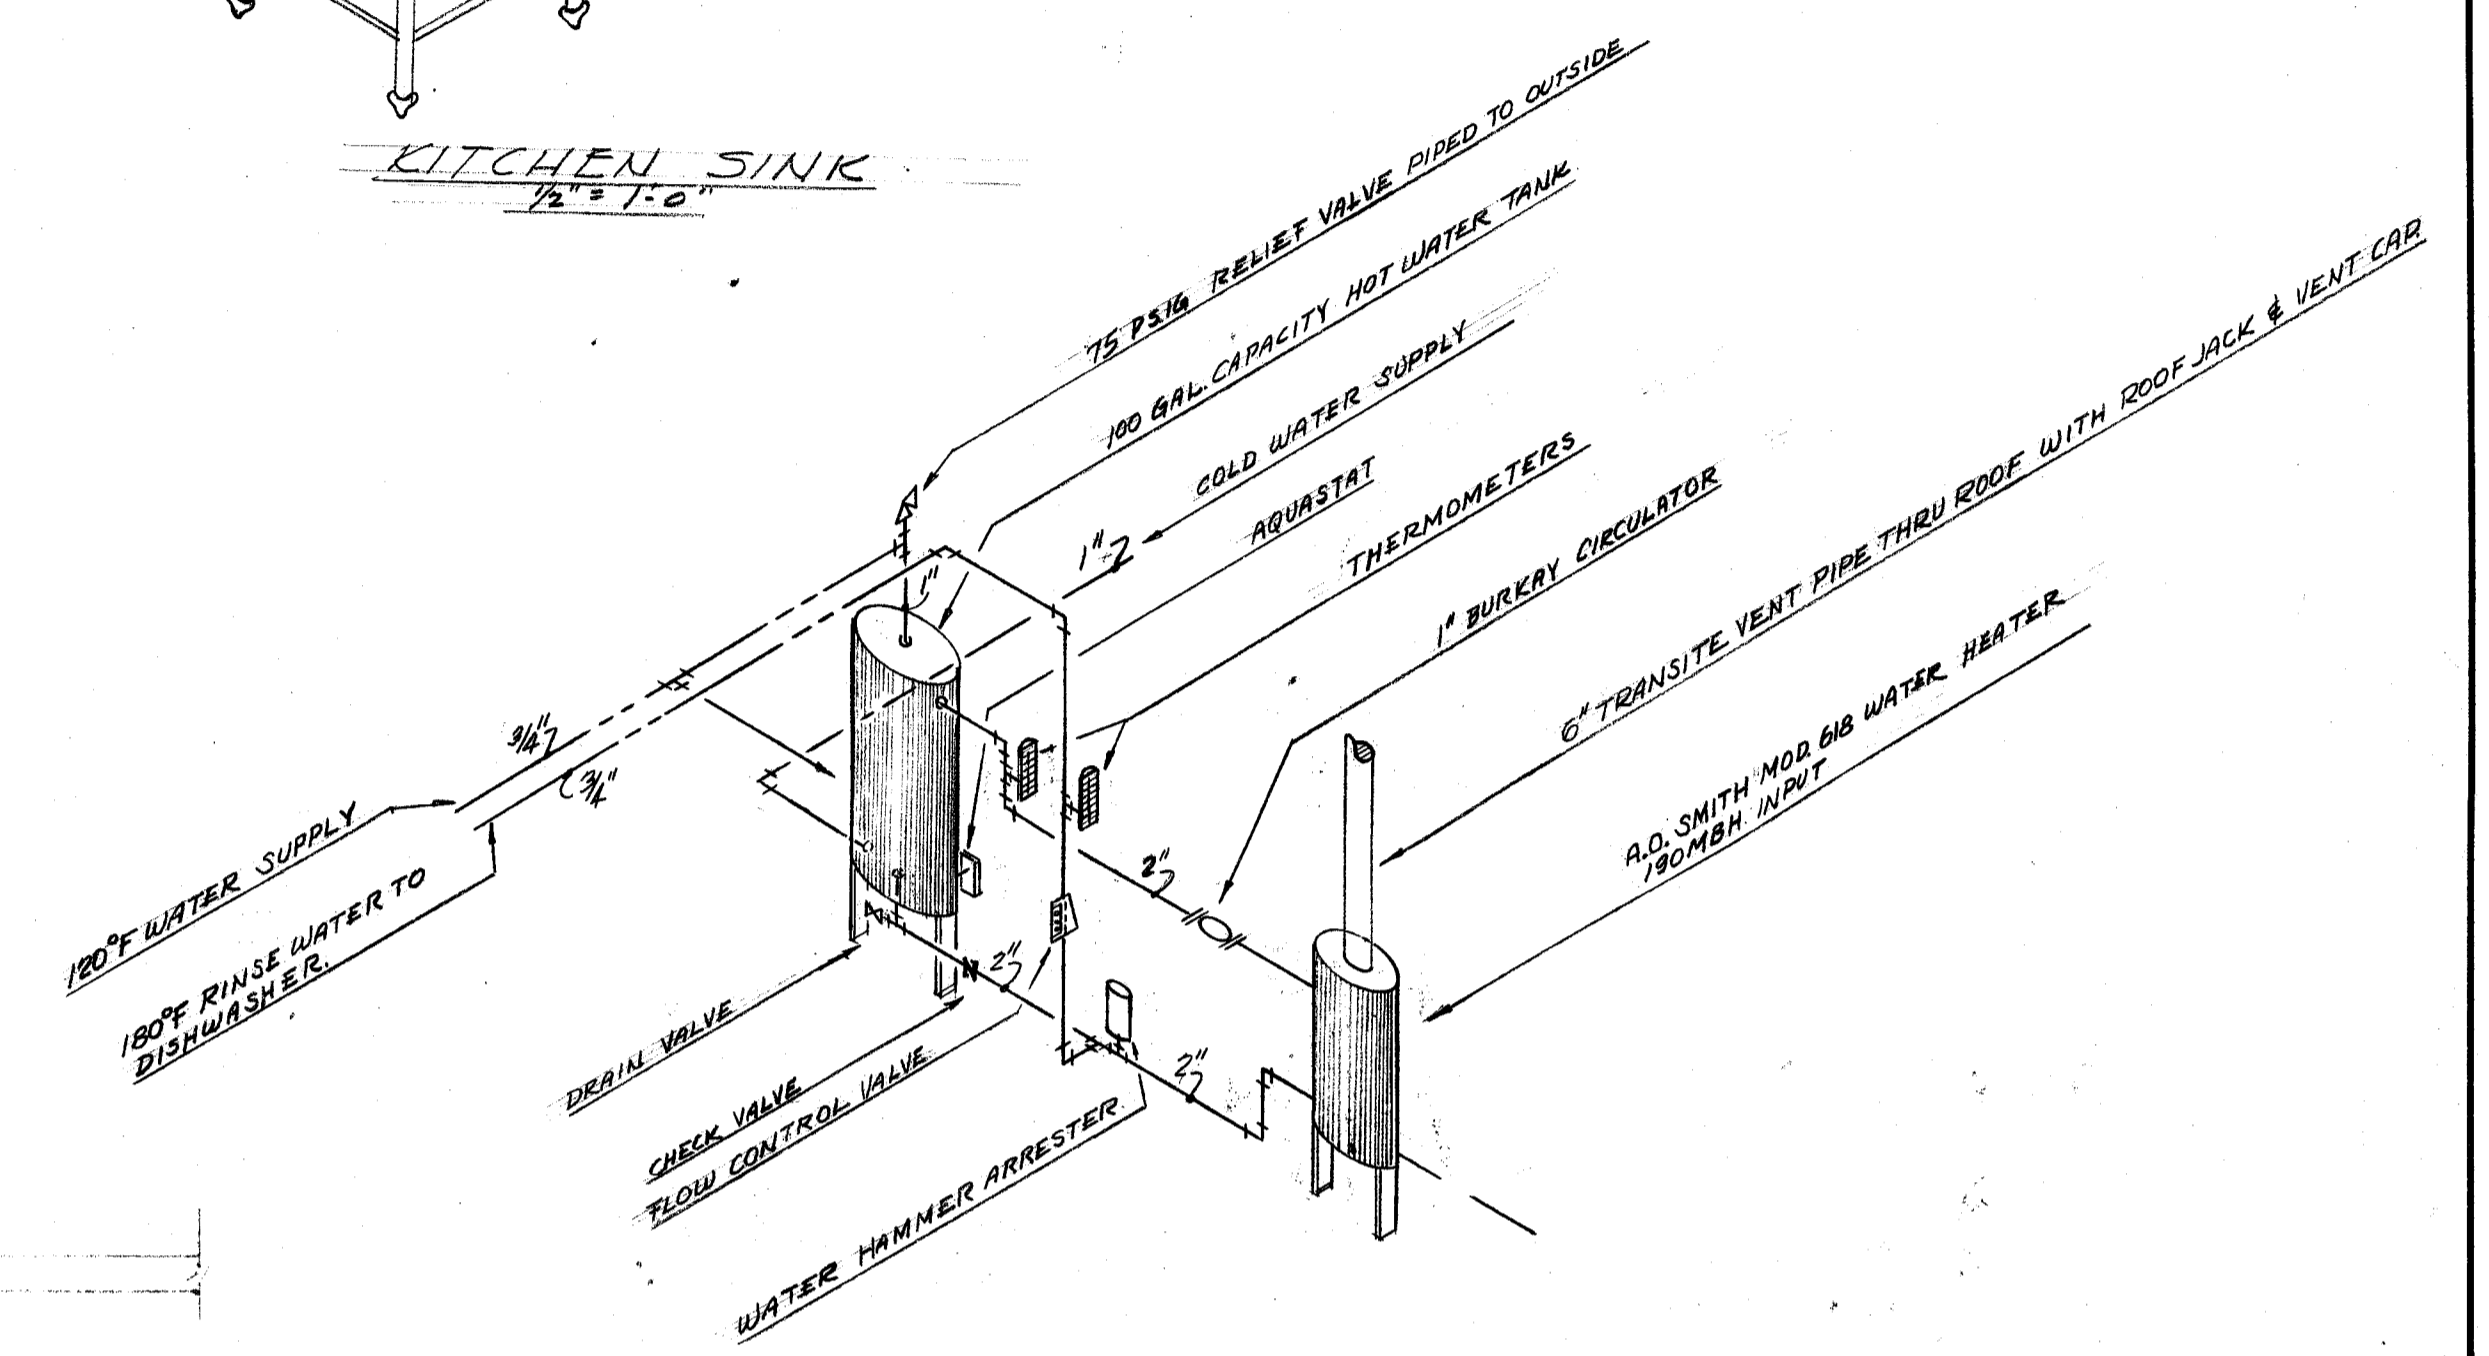

SCHEMATIC PIPING LAYOUT OF A.O. SMITH TWO TEMPERATURE WATER HEATING SYSTEM.  
NOT TO SCALE

FOR CONTINUATION REFER SHEET NO. M-1

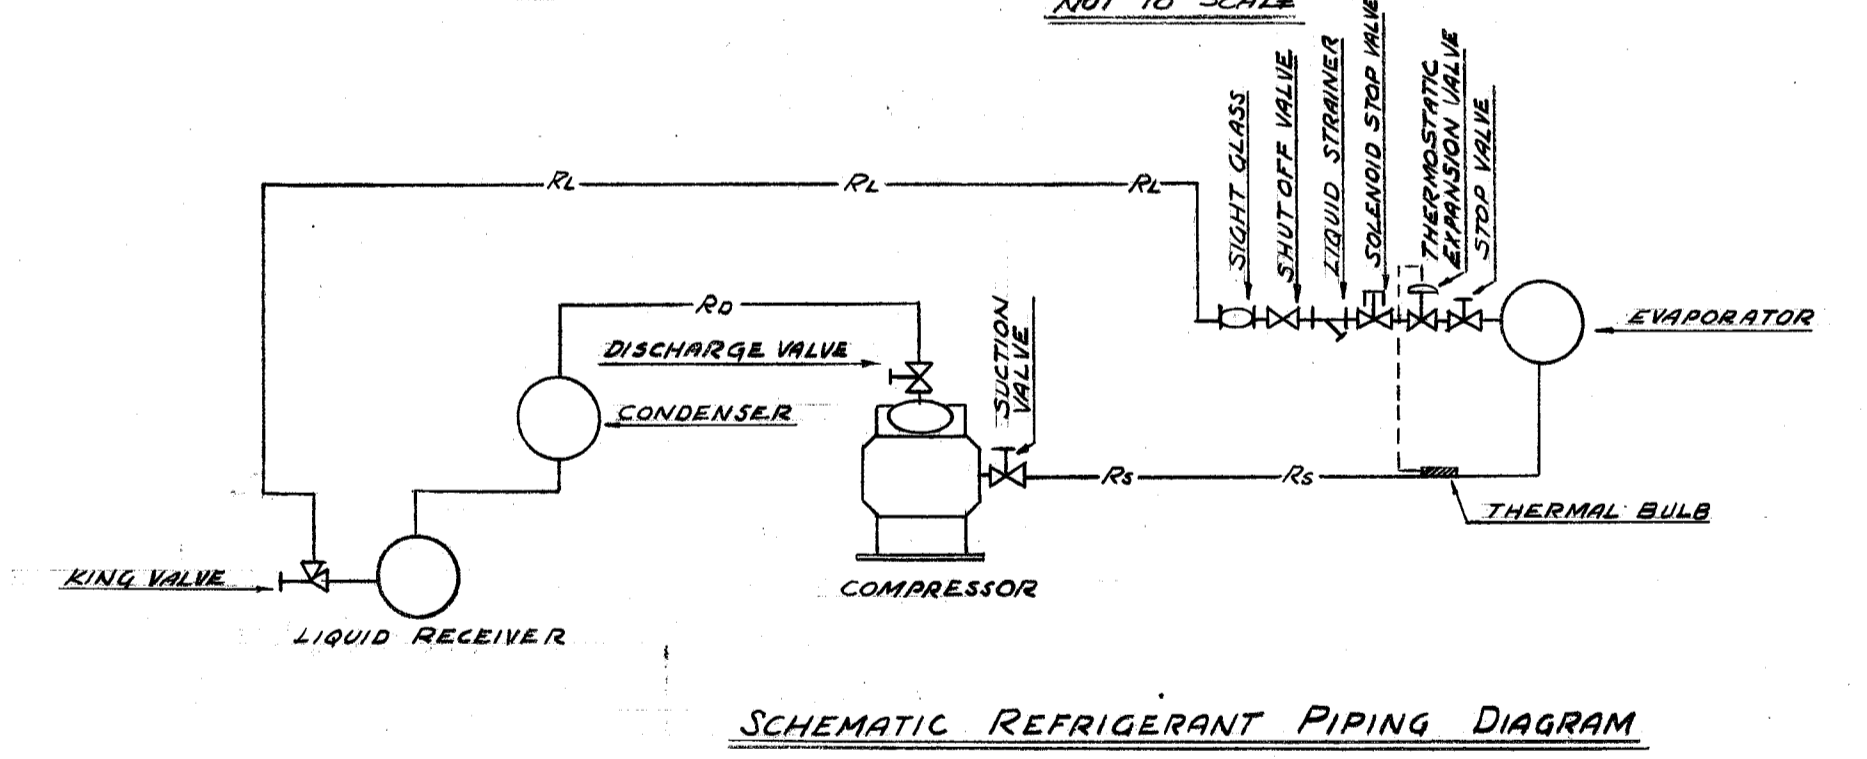


SCHEMATIC REFRIGERANT PIPING DIAGRAM


PIPING LEGEND

COLD WATER	—————
HOT WATER	—————
WASTE & SOIL	—————
VENT	—————

FOR CONTINUATION REFER SHEET NO. M-1

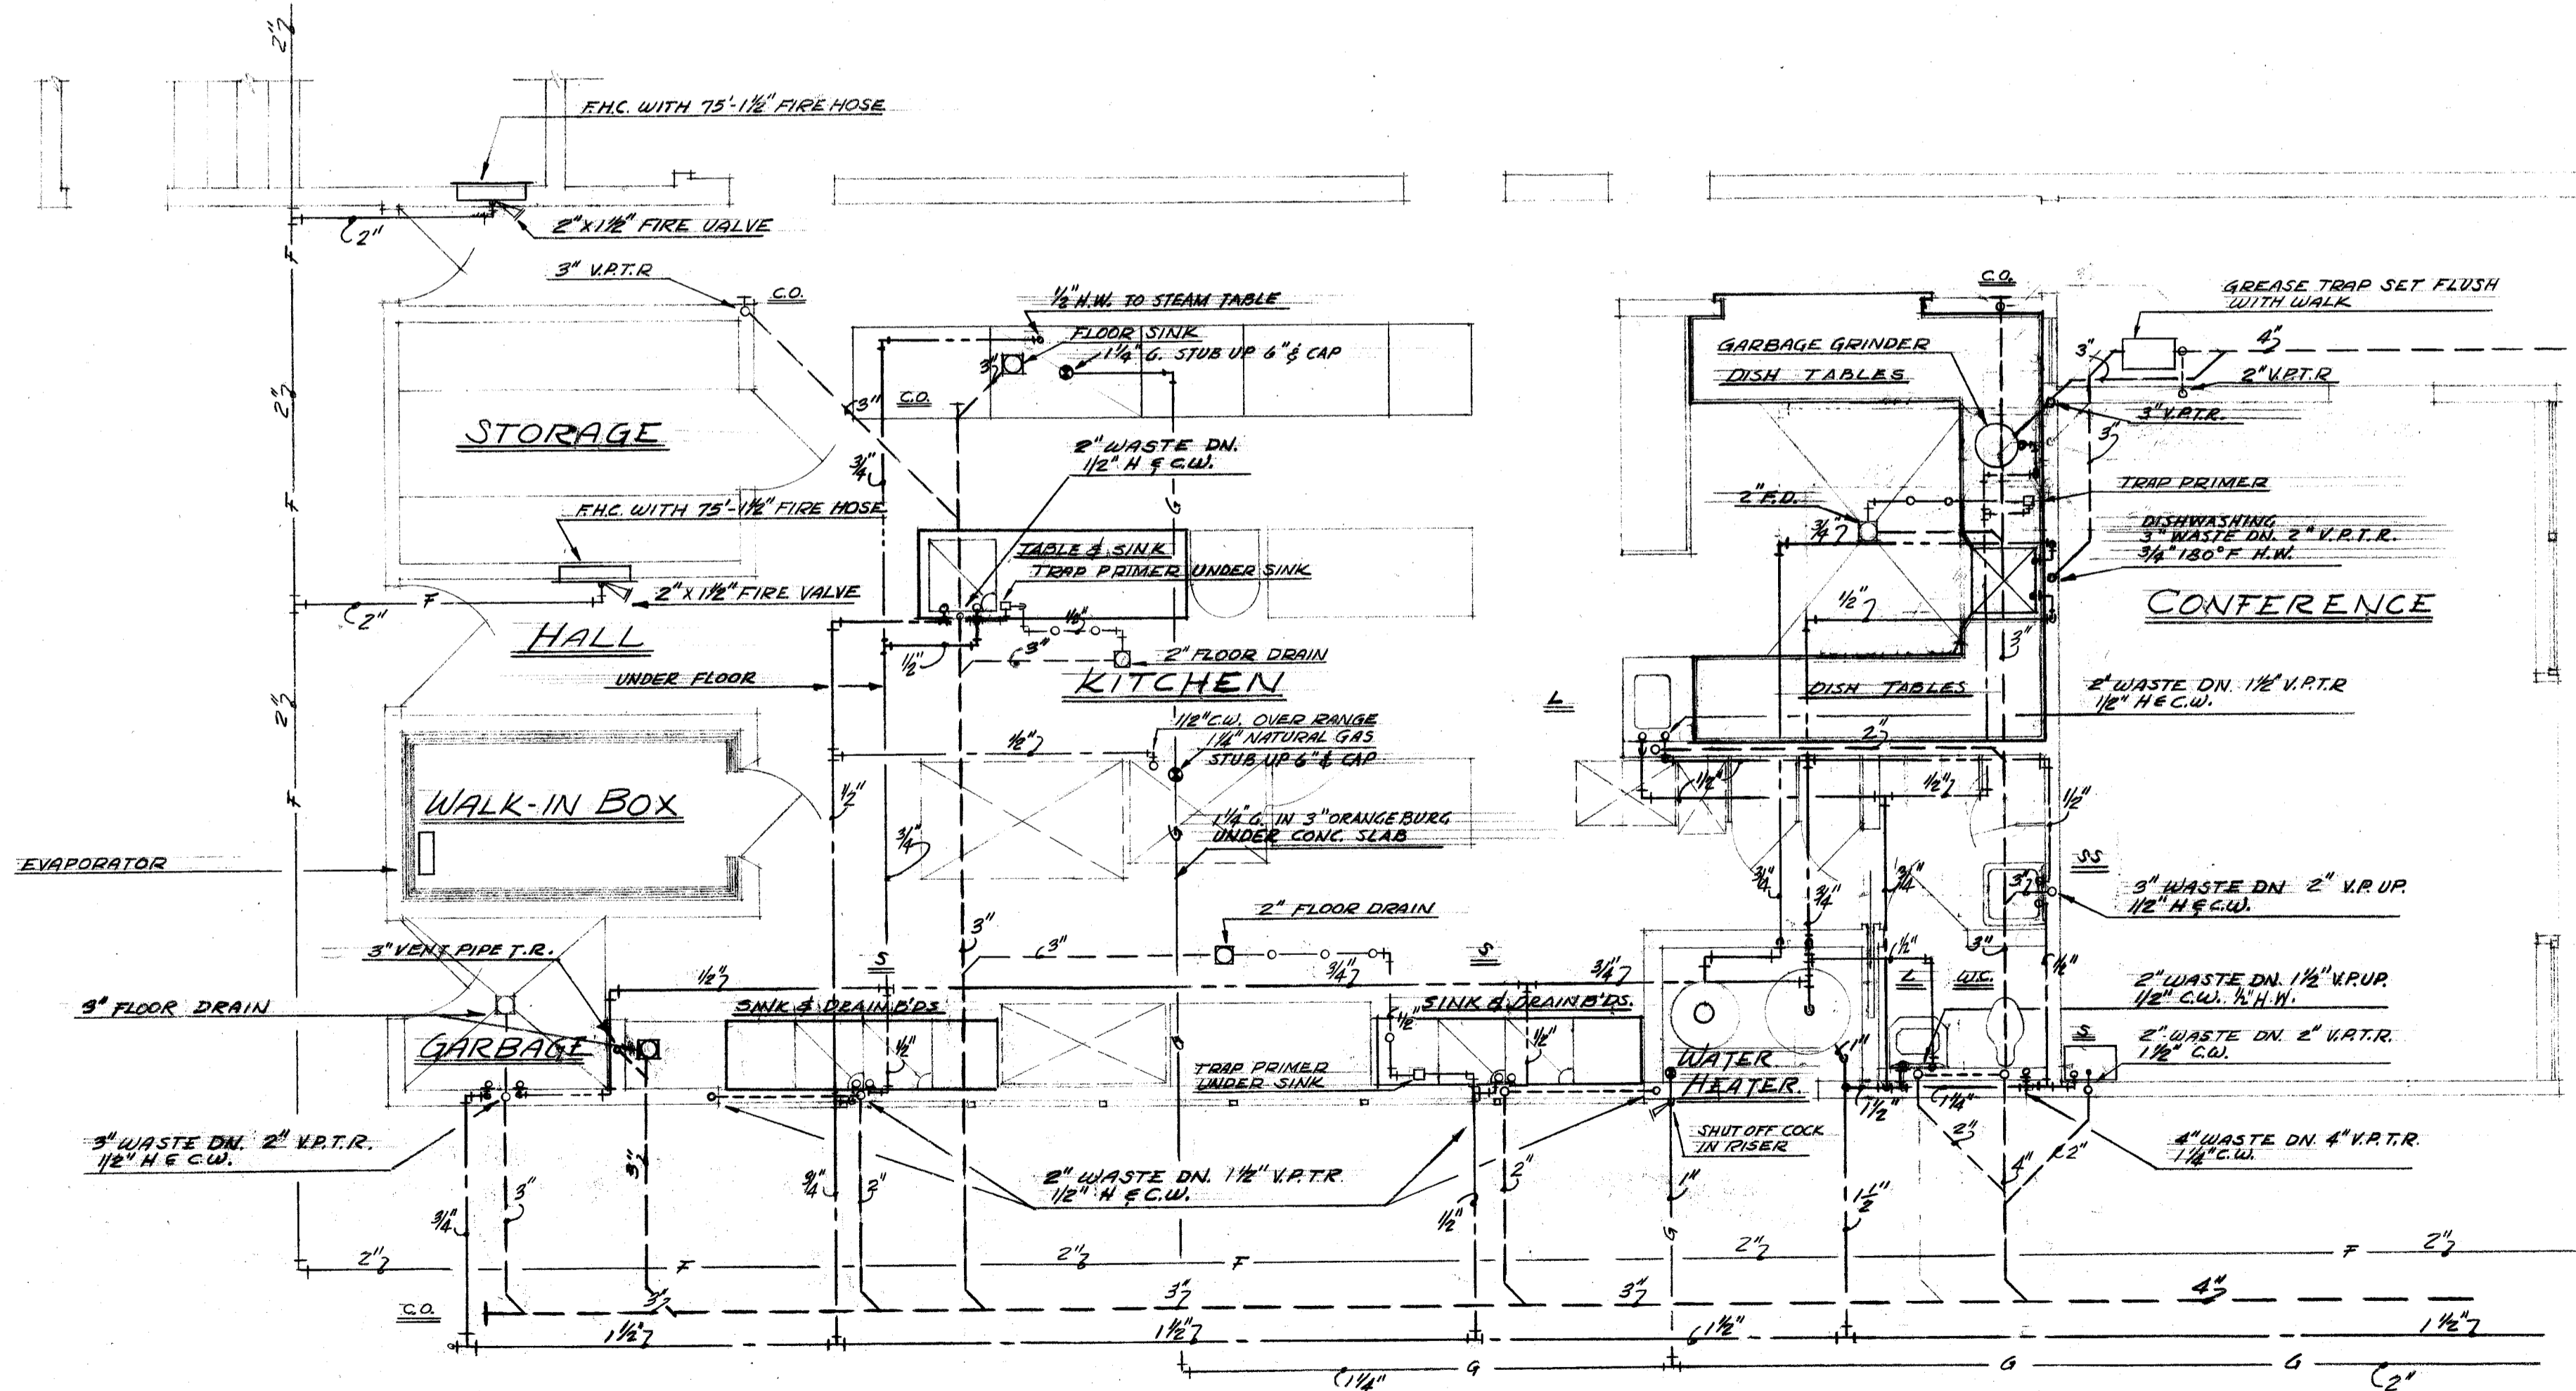

FLOOR PLAN KITCHEN - UNIT-1  
SCALE 1/4" = 1'-0"

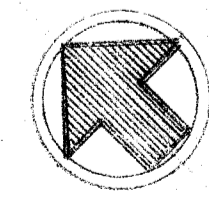

DIVISION OF ARCHITECTURE  
STATE OF CALIFORNIA - DEPARTMENT OF PUBLIC WORKS  
DIVISION OF ARCHITECTURE  
11805 APPROVED OCT - 7 1953  
Whitney Biggar

W. A. STAINS  
CONSULTING ENGINEER  
1603 CALIFORNIA AVENUE  
BAKERSFIELD, CALIFORNIA  
MECHANICAL 5305 ELECTRICAL 4205

BOARD OF EDUCATION  
PRES.  
Virginia C. Bellinger SEC.

PLUMBING  
FLOOR PLAN - KITCHEN  
UNIT ONE  
REAL ROAD SCHOOL  
BAKERSFIELD CALIFORNIA

Whitney Biggar  
WHITNEY BIGGAR ARCHITECT  
MEMBER AMERICAN INSTITUTE OF ARCHITECTS  
3601 STOCKDALE HIGHWAY  
BAKERSFIELD, CALIFORNIA  
29285 REGISTRATION C-1128

PROJECT NO. 6-53  
DRAWN BY:  
CHECKED BY:  
DATE: 9/4/53  
SHEET M-3  
OF 55