




UNITS-3 & 4
SCALE 1/4" = 1'-0"

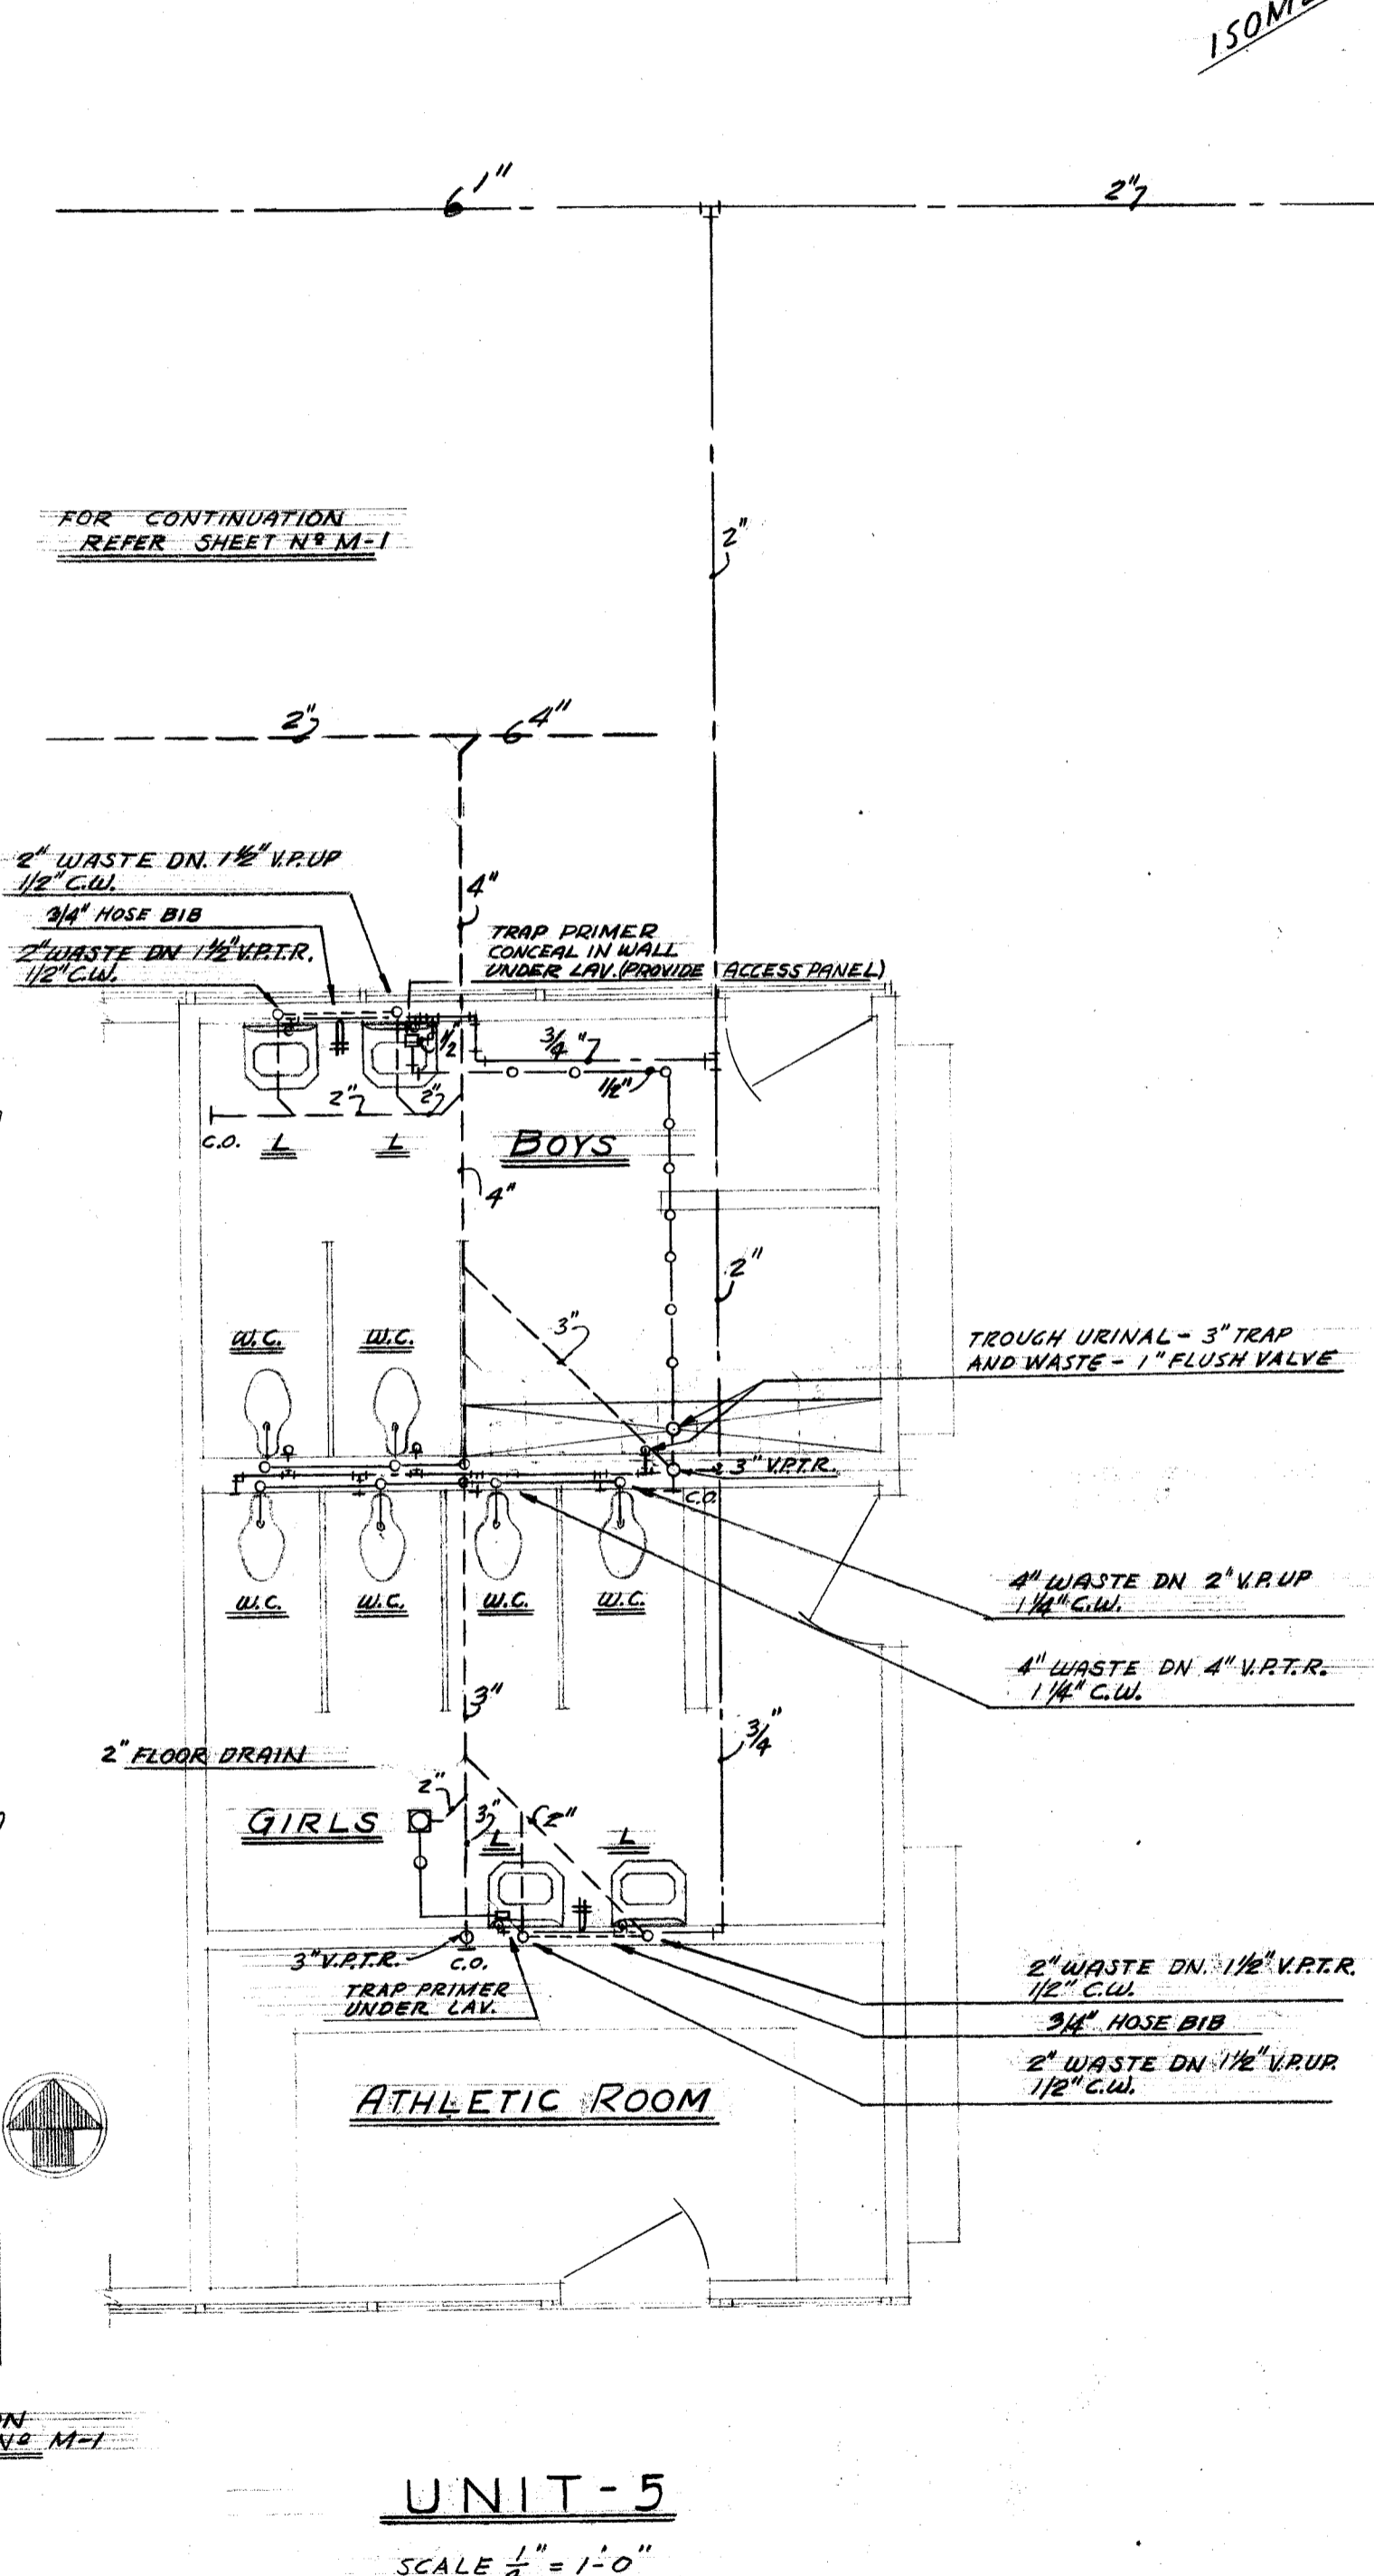


UNIT-5
SCALE 1/4" = 1'-0"

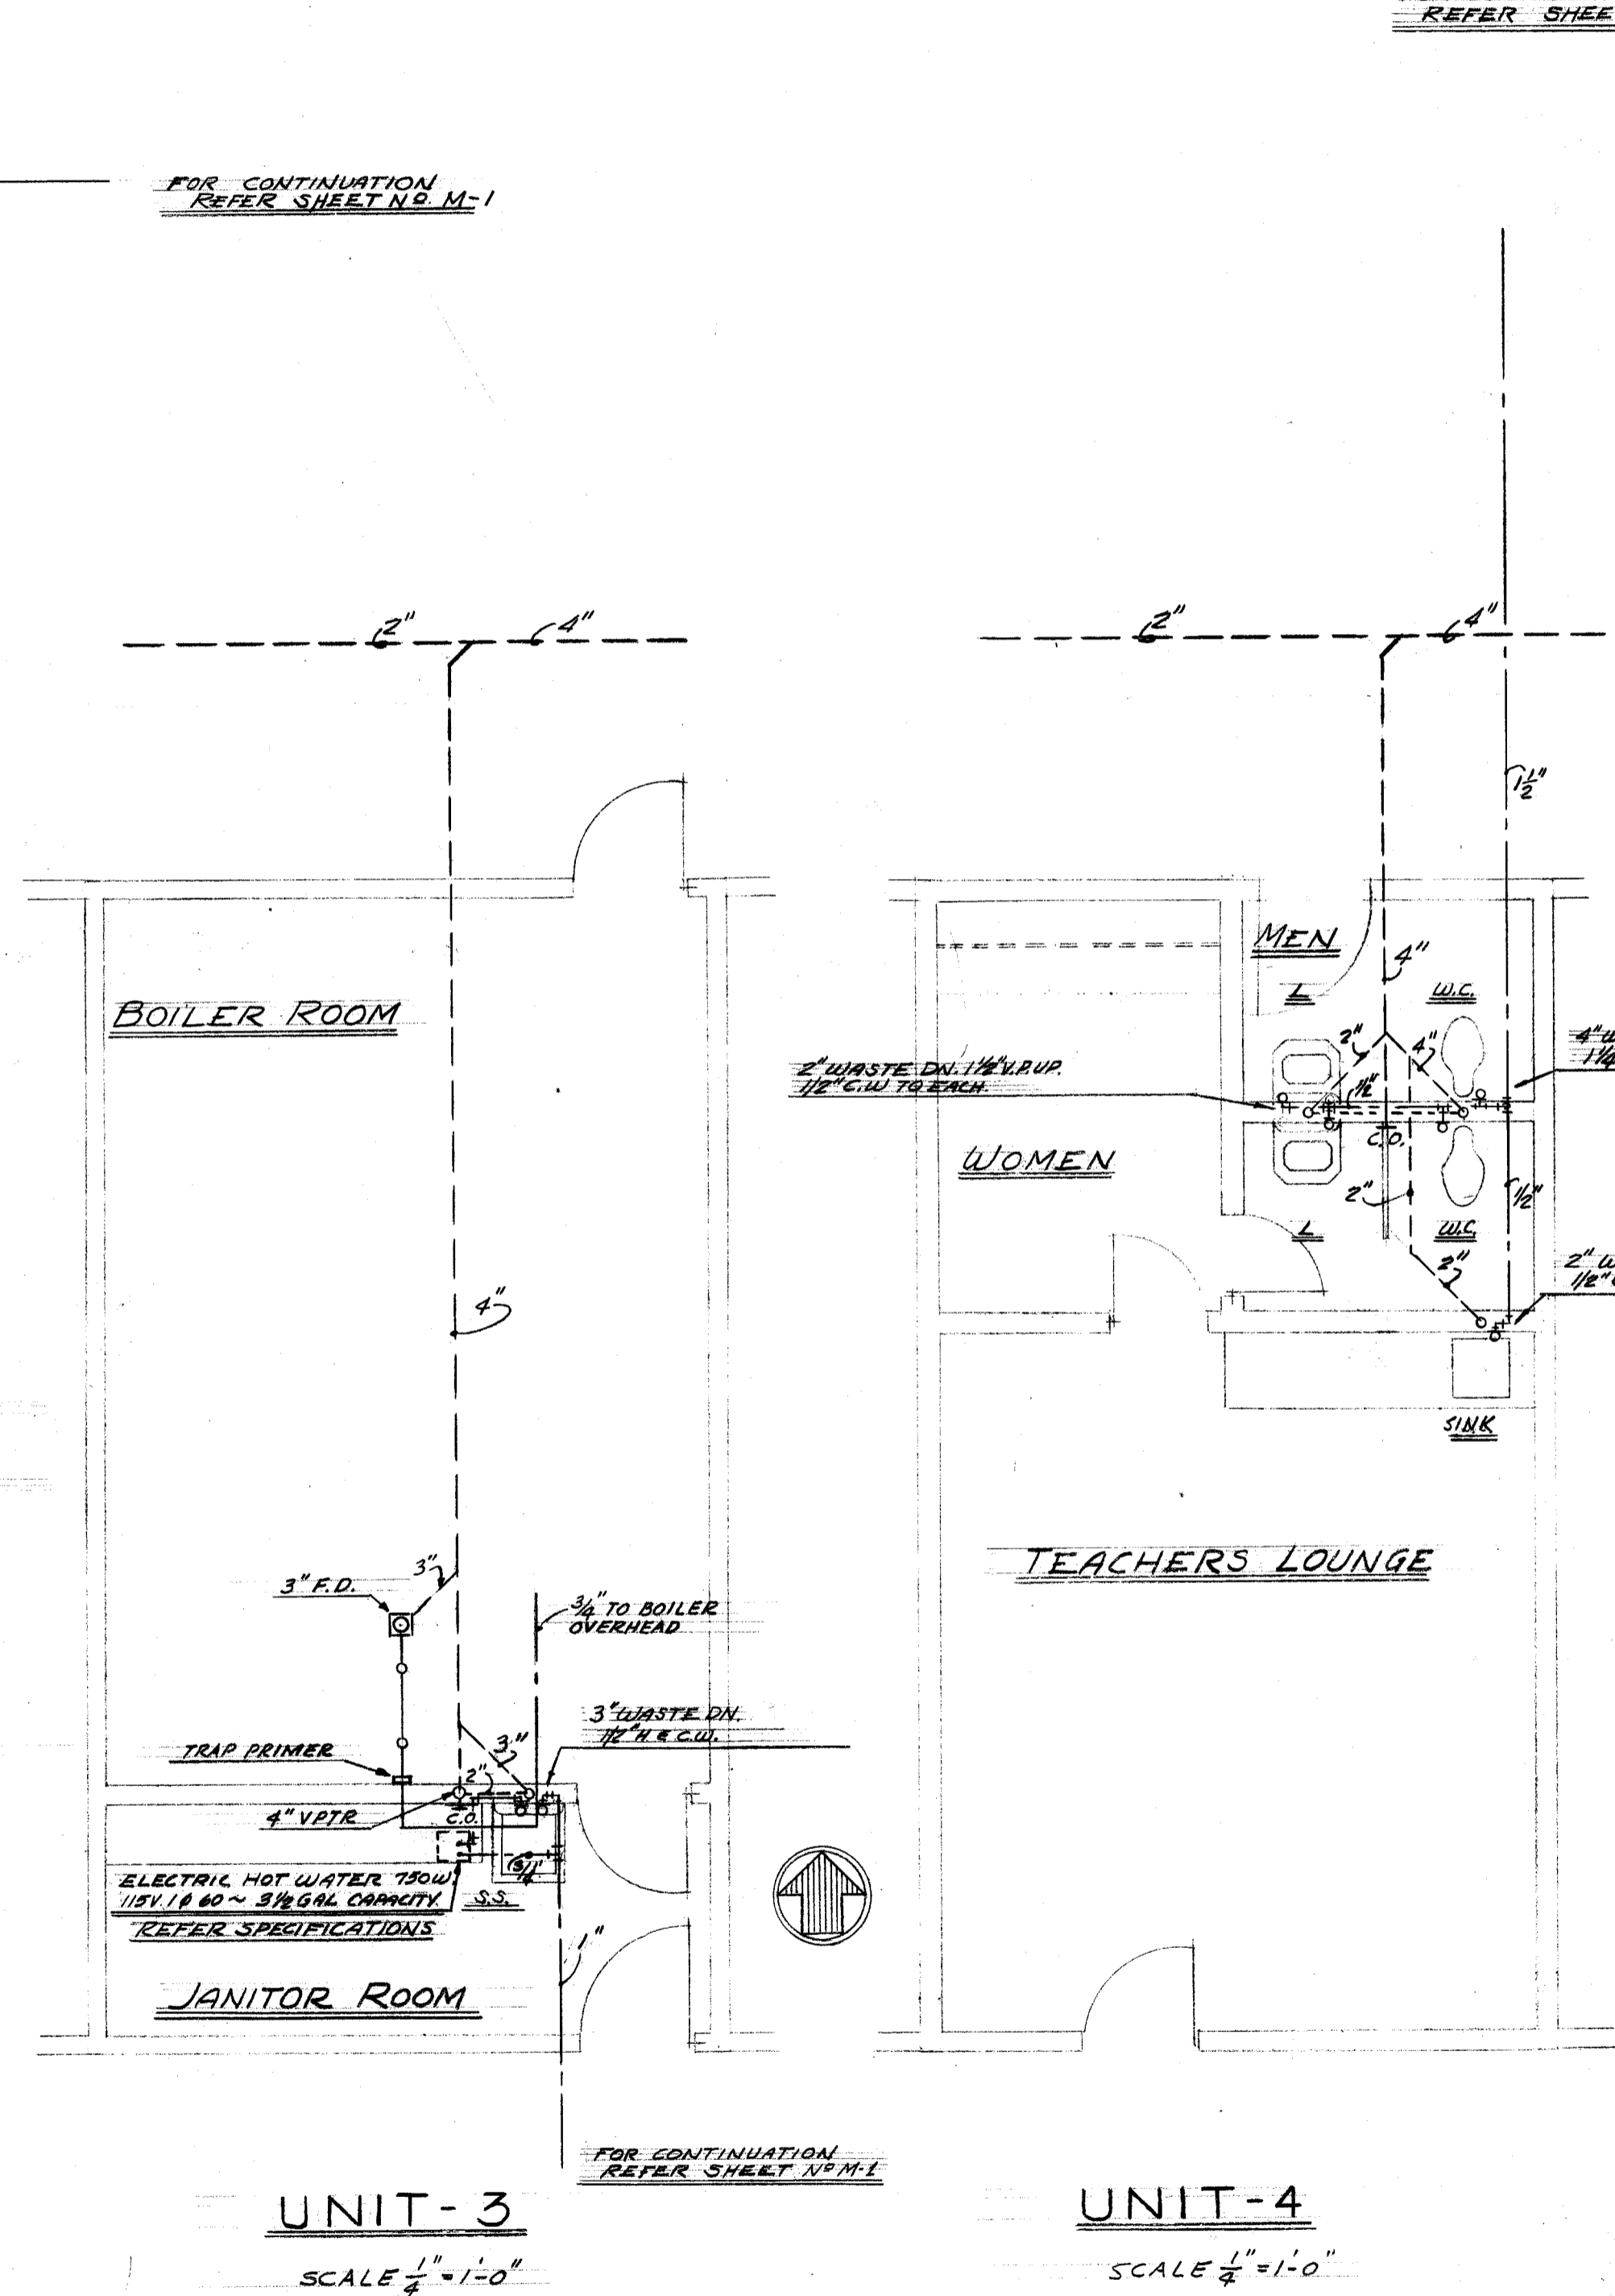

UNIT-3
SCALE 1/4" = 1'-0"

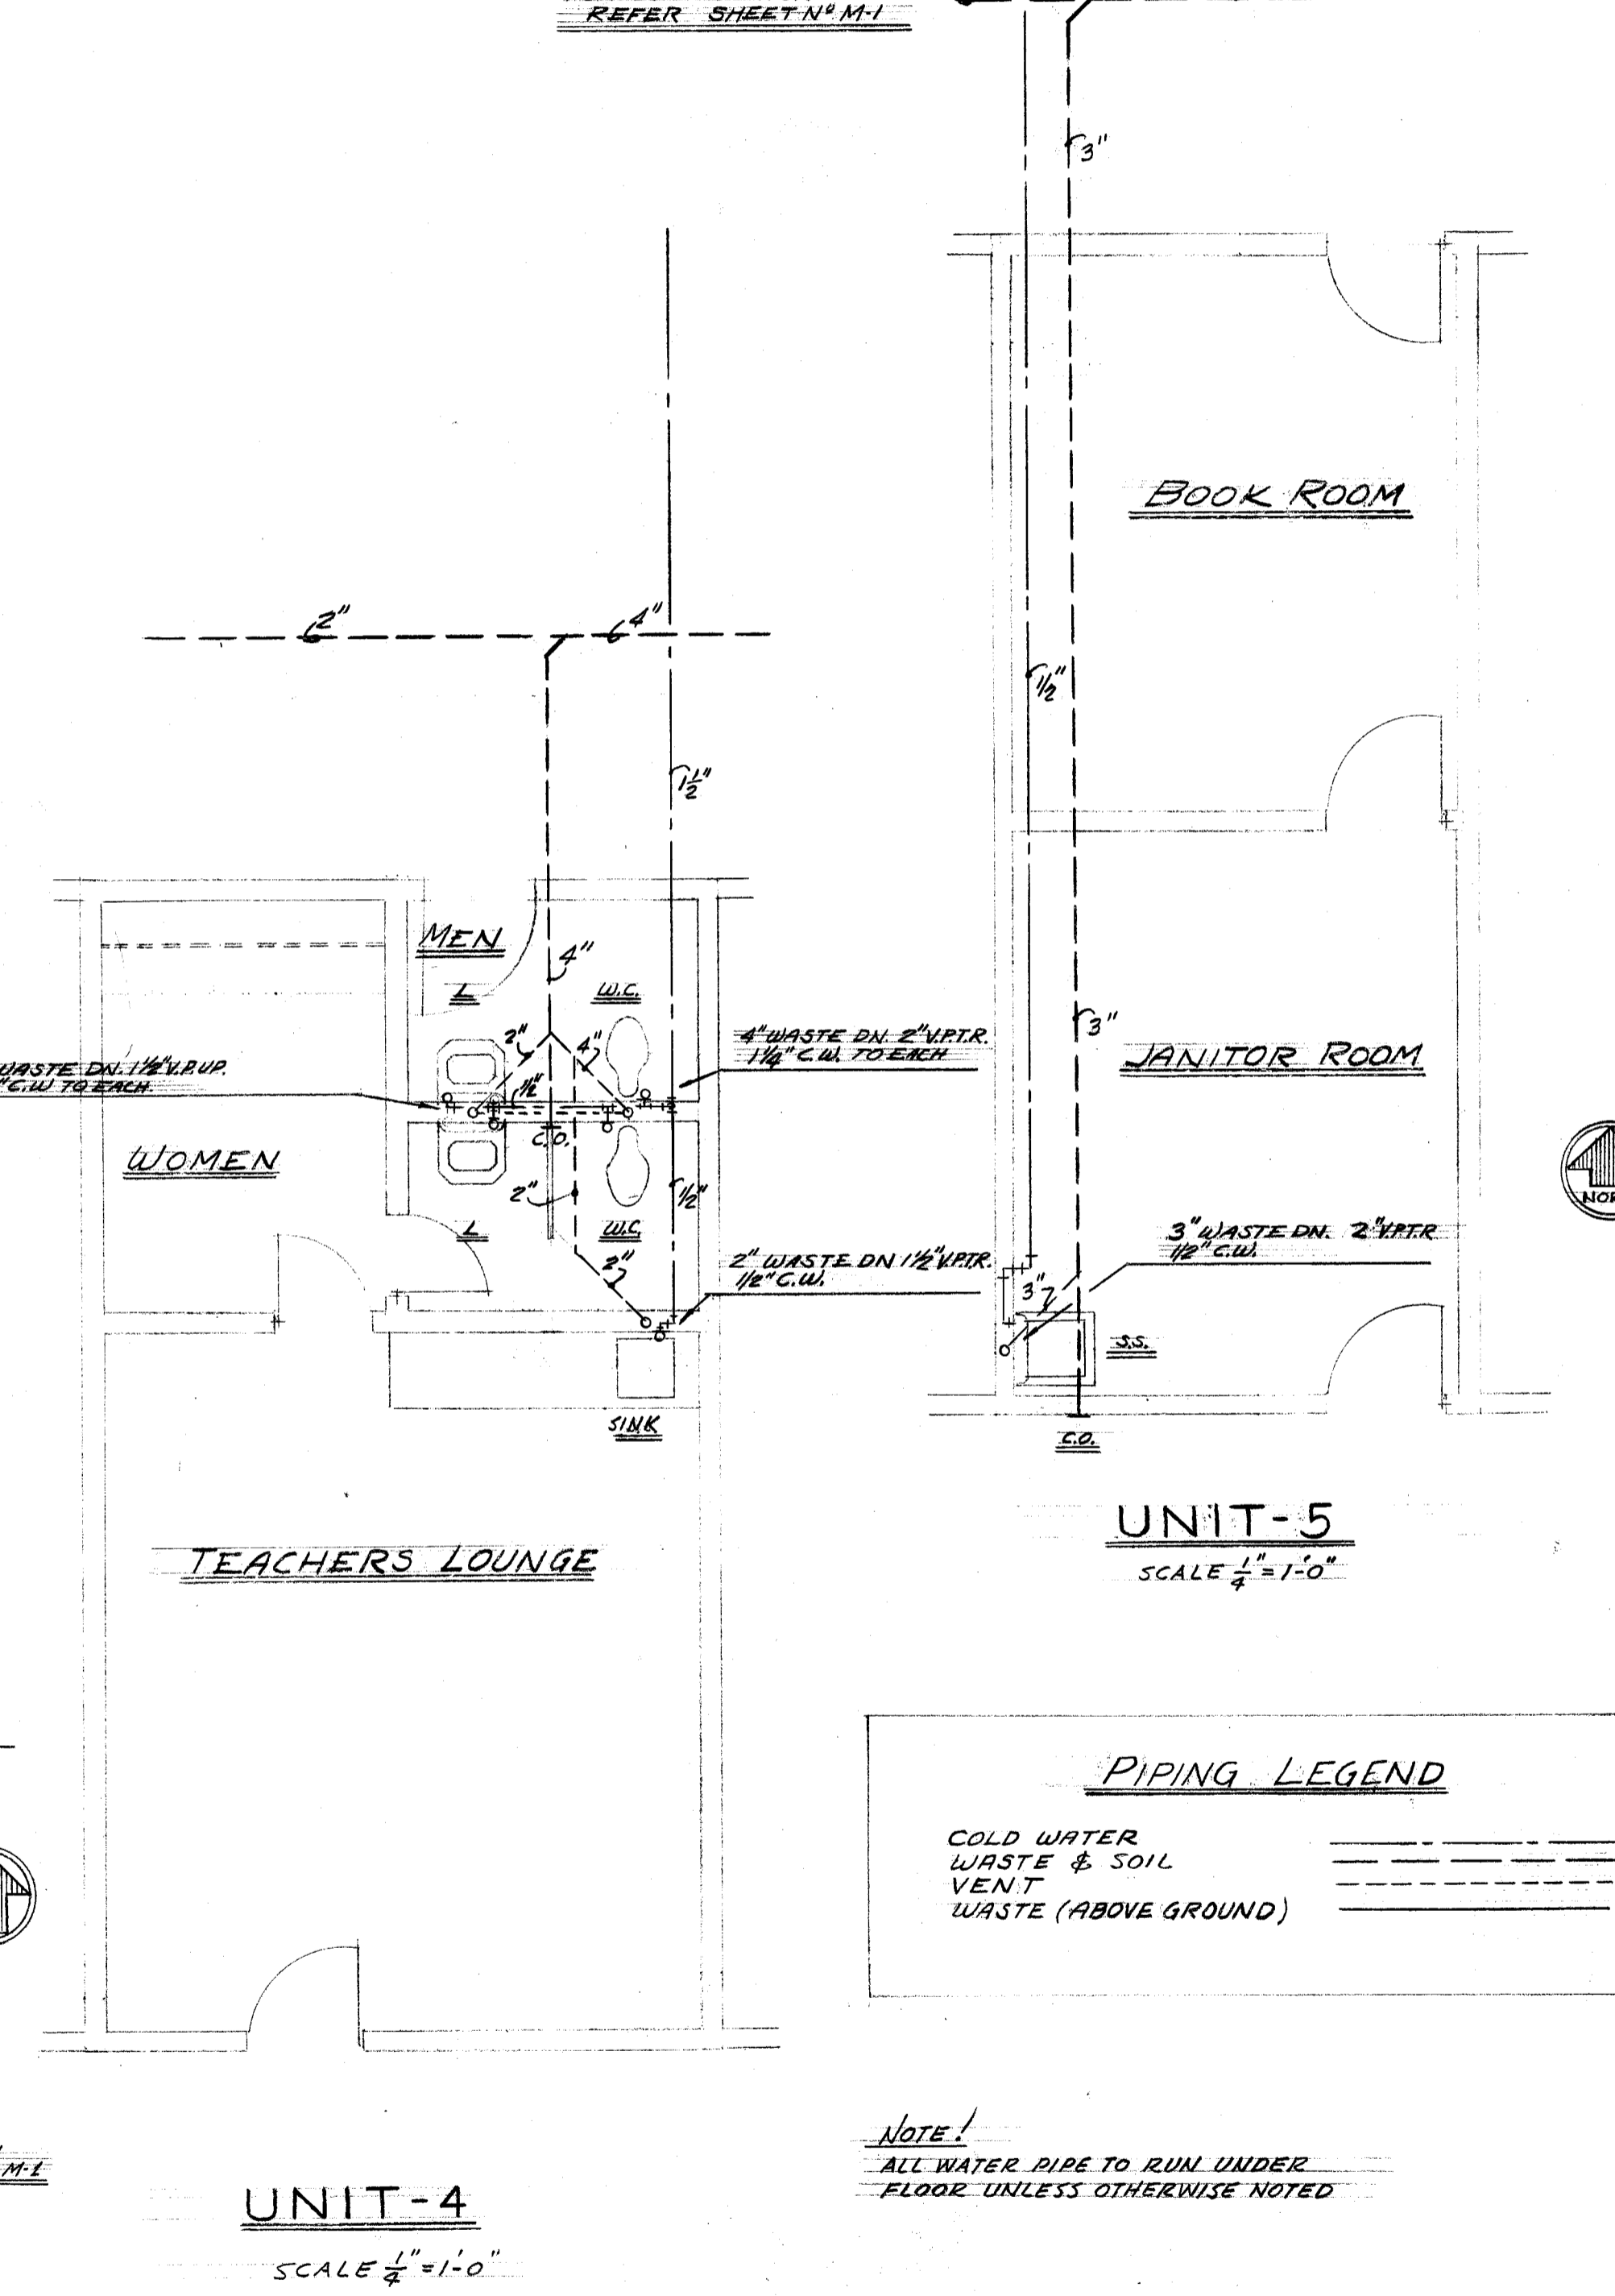

UNIT-4
SCALE 1/4" = 1'-0"

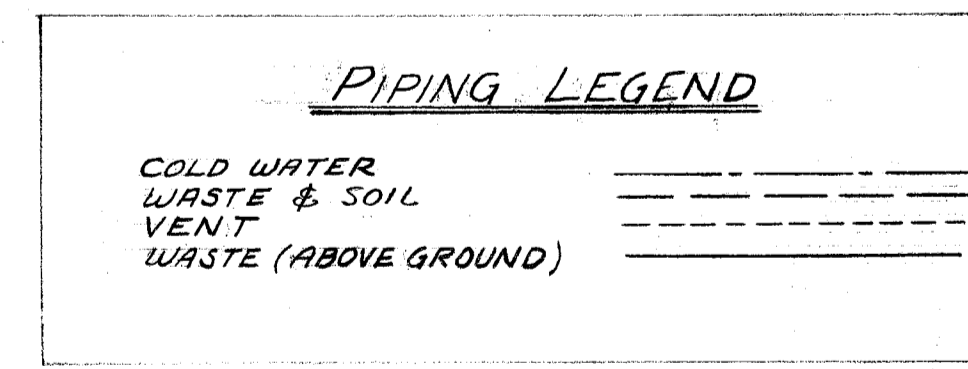

NOTE!
ALL WATER PIPE TO RUN UNDER FLOOR UNLESS OTHERWISE NOTED

DIVISION OF ARCHITECTURE
STATE OF CALIFORNIA - DEPARTMENT OF PUBLIC WORKS
DIVISION OF ARCHITECTURE
11305 APPROVED OCT 7 1953
W. A. STAINS

W. A. STAINS
CONSULTING ENGINEER
1603 CALIFORNIA AVENUE
BAKERSFIELD, CALIFORNIA
MECHANICAL 5305 ELECTRICAL 4205

BOARD OF EDUCATION
Virginia C. Bellinger SEC.
PRES.

PLUMBING
FLOOR PLAN - TOILET ROOMS
UNITS-THREE, FOUR & FIVE
REAL ROAD SCHOOL
BAKERSFIELD CALIFORNIA

Whitney Biggar
WHITNEY BIGGAR ARCHITECT
MEMBER AMERICAN INSTITUTE OF ARCHITECTS
3601 STOCKDALE HIGHWAY
BAKERSFIELD, CALIFORNIA
29285 REGISTRATION C-1128

PROJECT NO. 6-53
DRAWN BY:
CHECKED BY:
DATE: 9/4/53
SHEET M-7
OF 56