




ISOMETRIC SHOWING PIPE CONNECTIONS @ UNIT HEATER  
NO SCALE

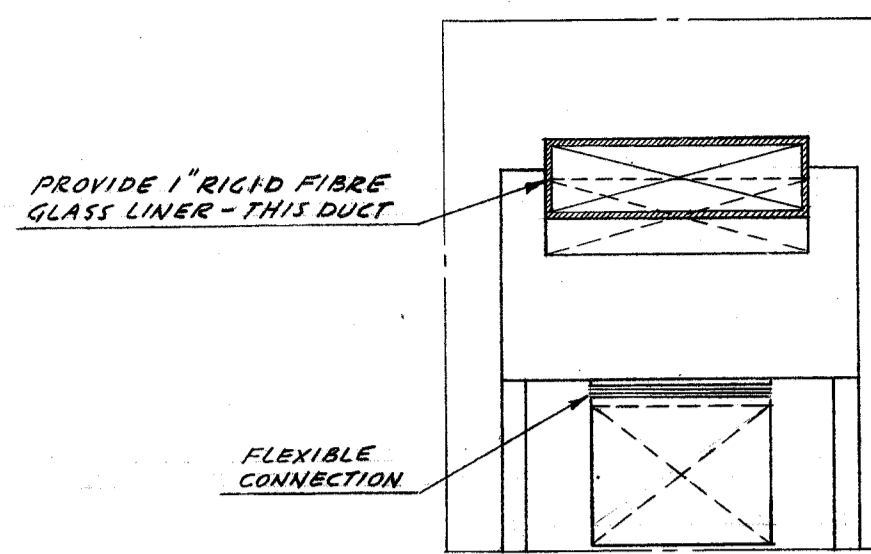



SECTION - J - J  
SCALE 3/8" = 1'-0"

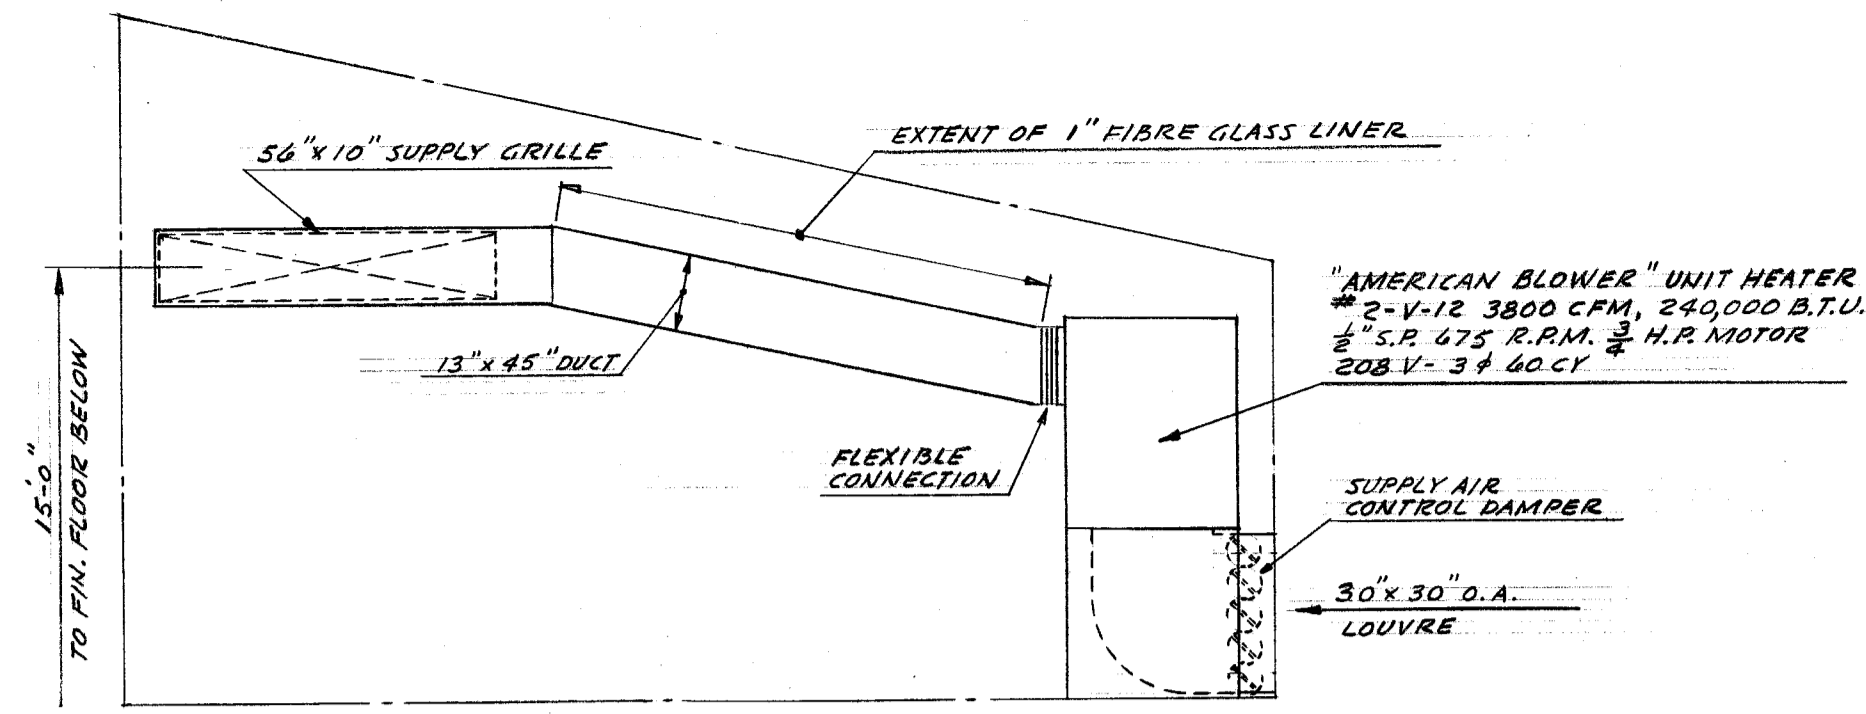


SECTION - I - I  
SCALE 3/8" = 1'-0"

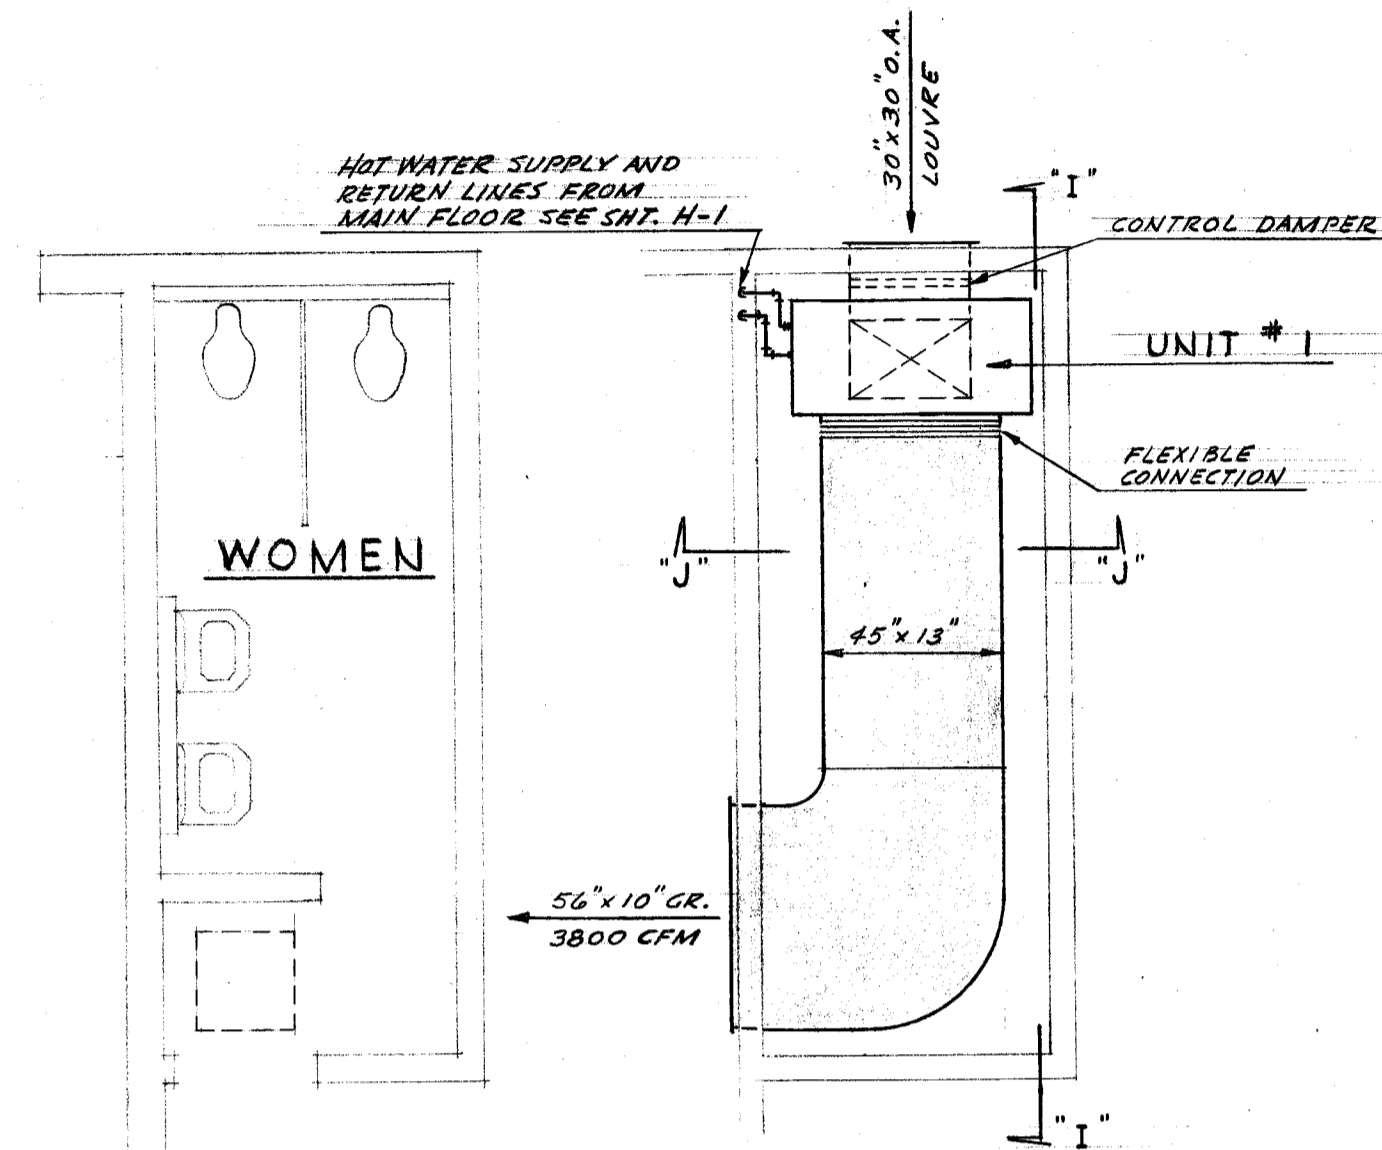

PLAN OF HEATER ROOM ABOVE TOILET ROOM  
SCALE 1/4" = 1'-0"

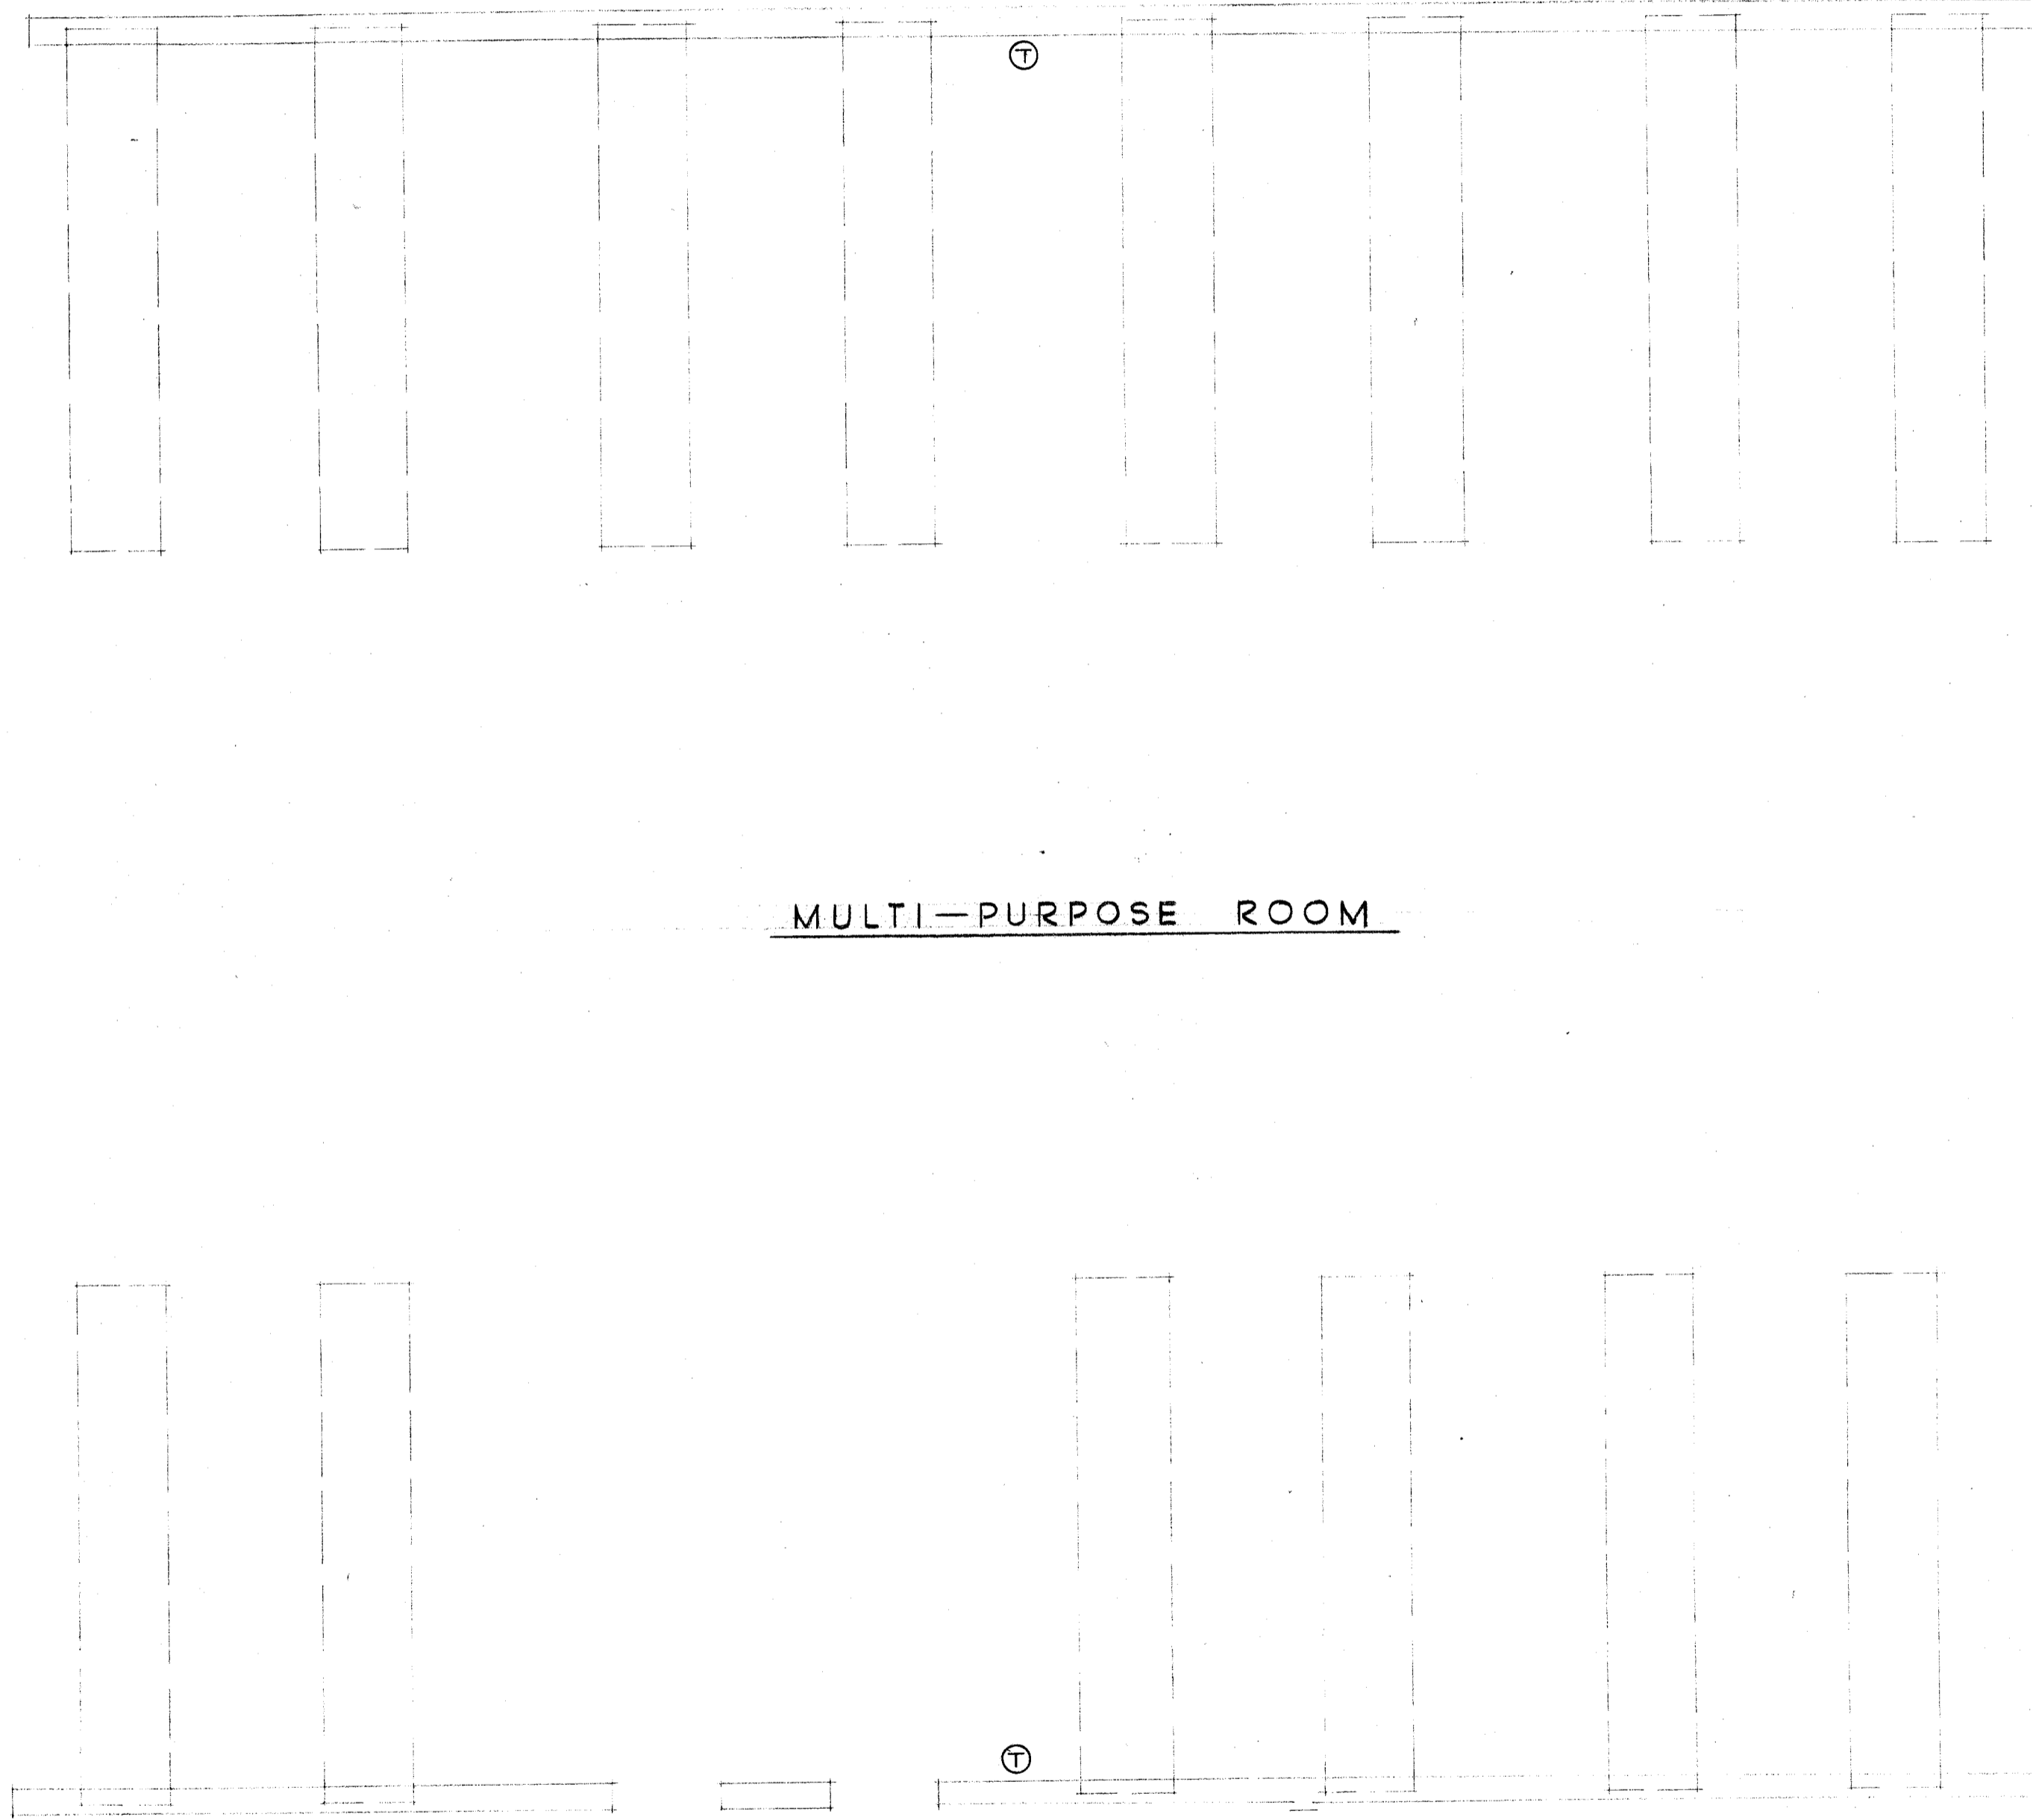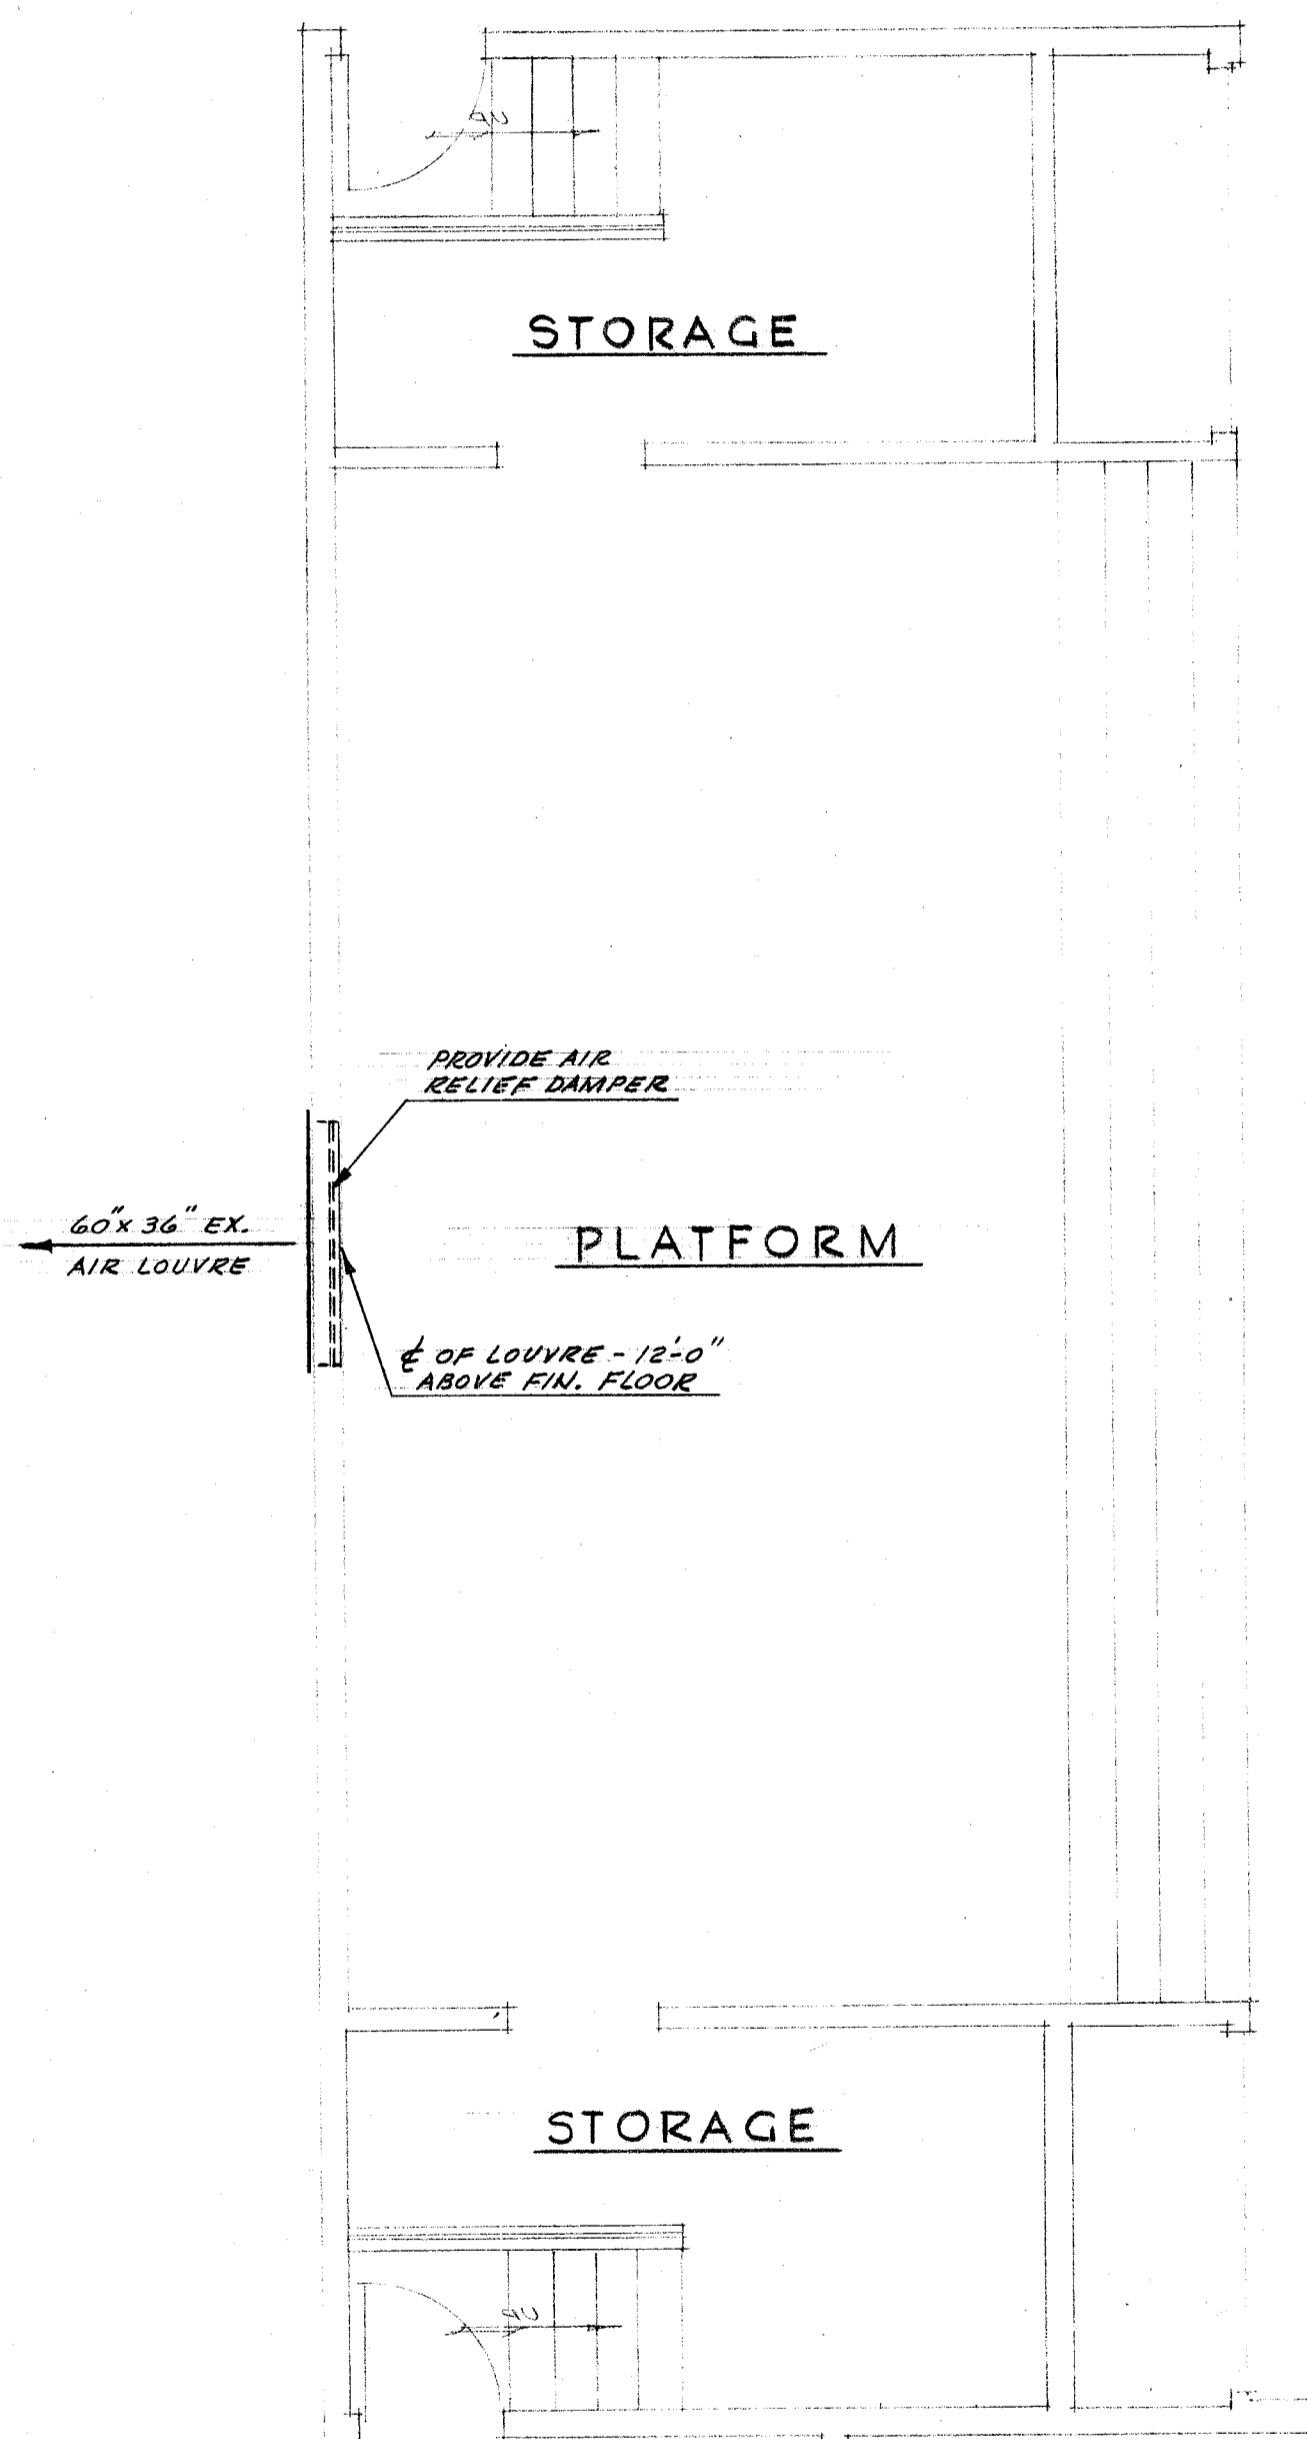

SCALE 1/4" = 1'-0"

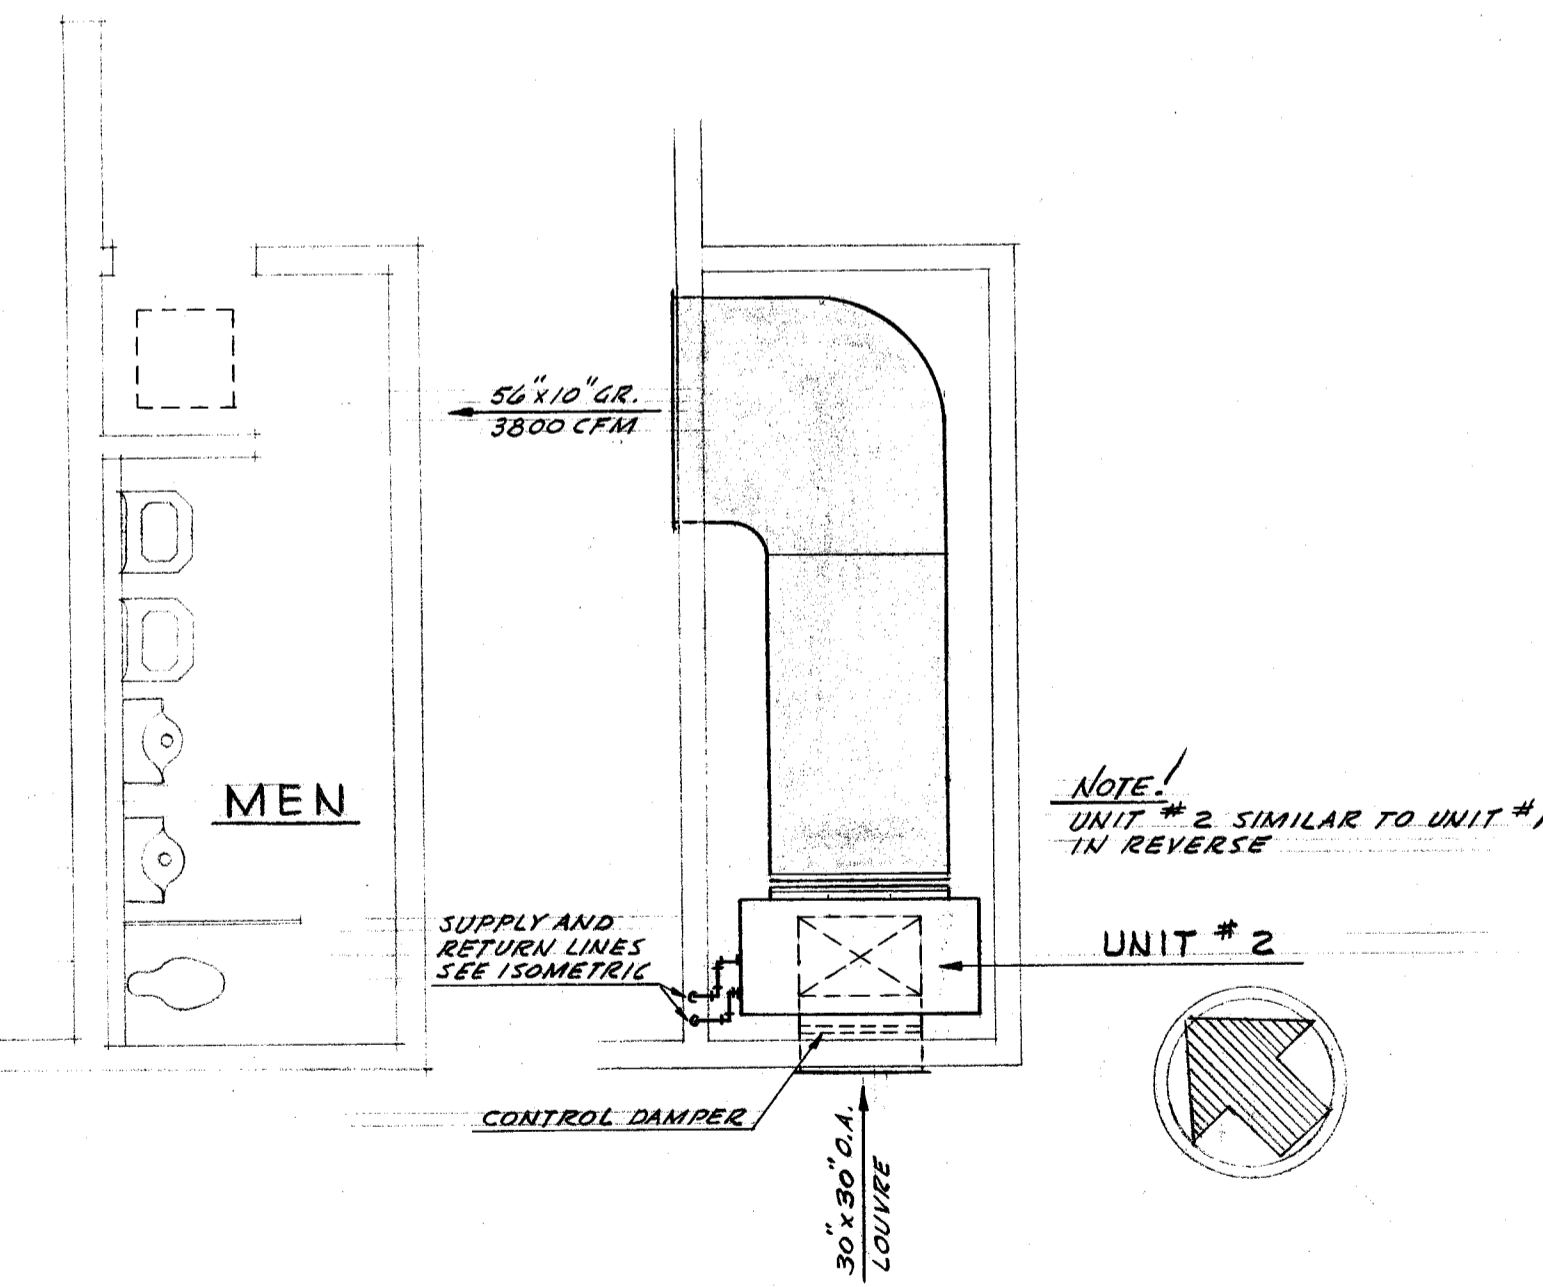

PLAN OF HEATER ROOM ABOVE TOILET ROOM  
SCALE 1/4" = 1'-0"

DIVISION OF ARCHITECTURE

STATE OF CALIFORNIA DEPARTMENT OF PUBLIC WORKS  
DIVISION OF ARCHITECTURE  
11303 APPROVED OCT - 7 1953  
C. W. ...  
PRINCIPAL REGISTERED ARCHITECT

W. A. STAINS  
CONSULTING ENGINEER  
1603 CALIFORNIA AVENUE  
BAKERSFIELD, CALIFORNIA  
MECHANICAL 5305 ELECTRICAL 4205

BOARD OF EDUCATION  
PRES.  
Virginia C. Bellinger SEC.

HEATING & VENTILATING  
FLOOR PLAN - MULTI-PURPOSE ROOM  
UNIT ONE  
REAL ROAD SCHOOL  
BAKERSFIELD CALIFORNIA

Whitney Biggar  
WHITNEY BIGGAR ARCHITECT  
MEMBER AMERICAN INSTITUTE OF ARCHITECTS  
3601 STOCKDALE HIGHWAY  
BAKERSFIELD, CALIFORNIA  
29285 REGISTRATION C-1128

PROJECT NO. 6-53  
DRAWN BY:  
CHECKED BY:  
DATE: 9/4/53  
SHEET M-8  
OF 56