




CONTROL DIAGRAM

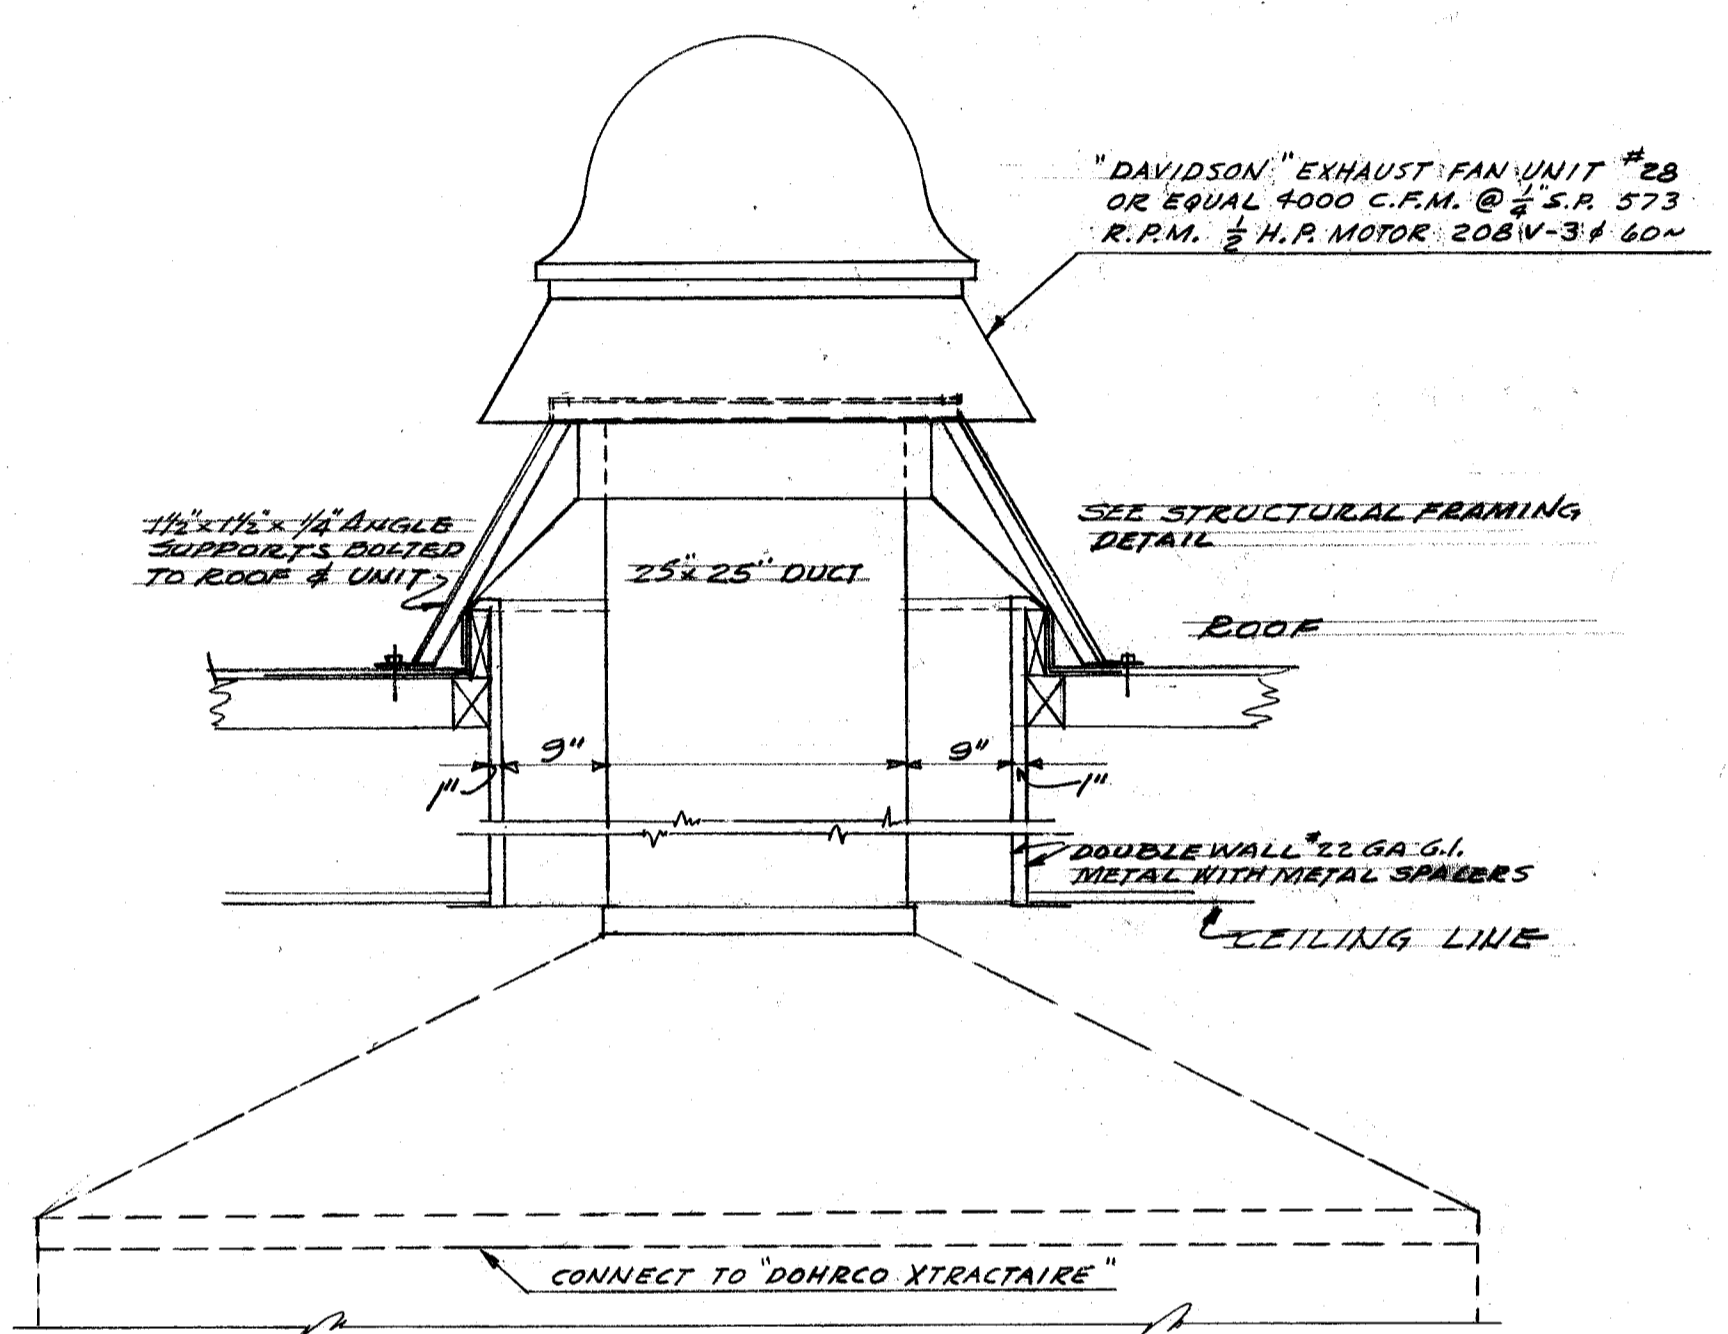


SECTION - Q - Q
SCALE 3/8" = 1'-0"

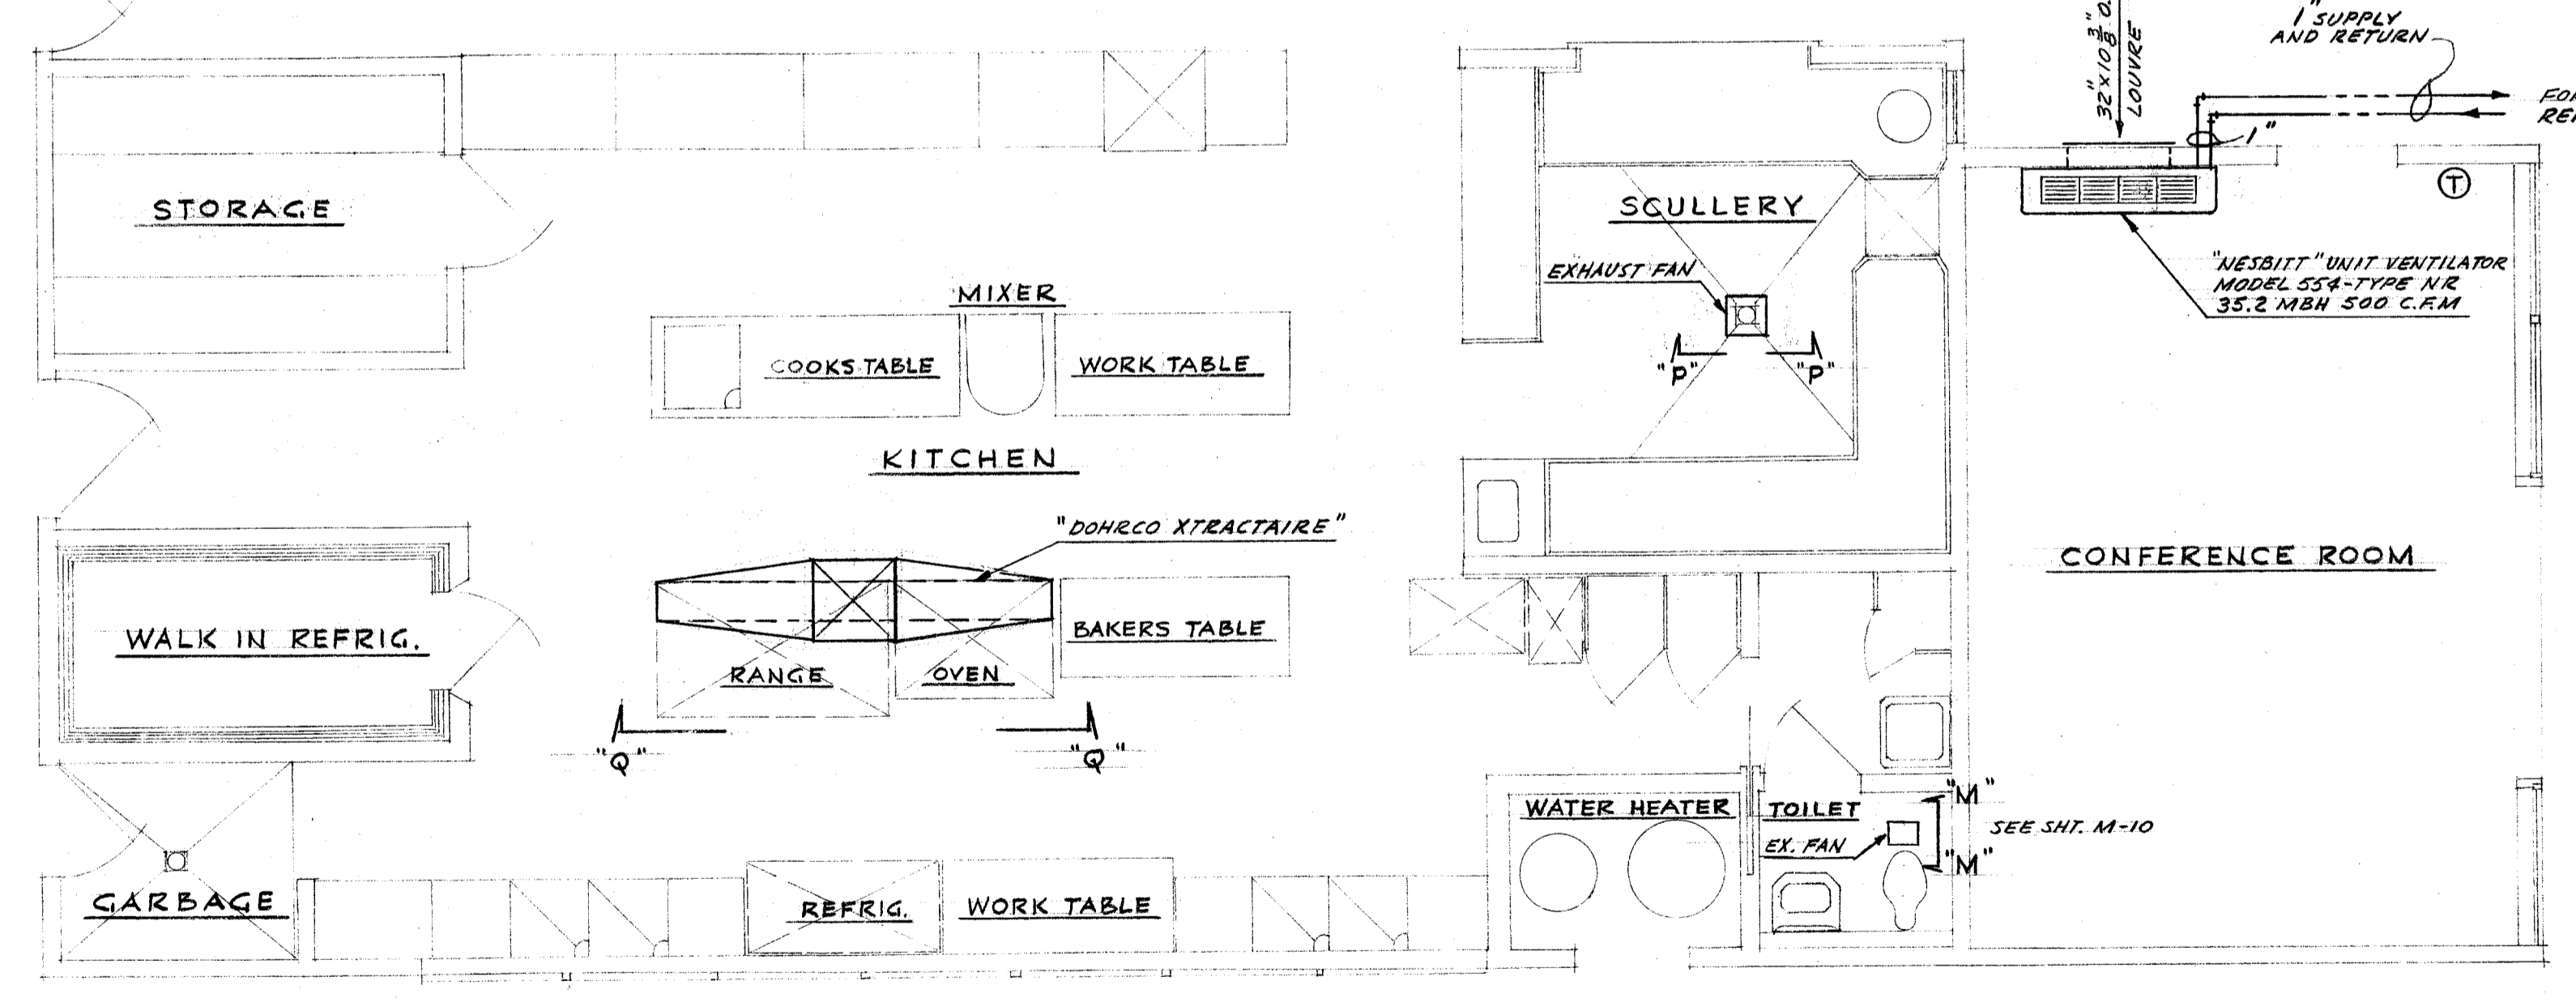


SCALE 1/4" = 1'-0"

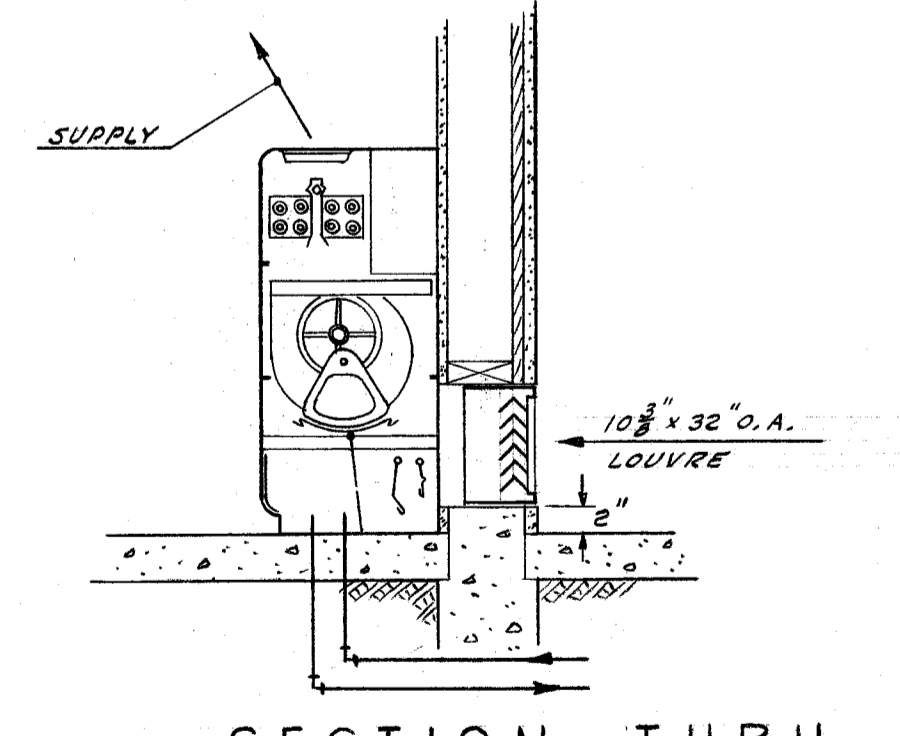

SECTION THRU UNIT VENTILATOR
SCALE 3/8" = 1'-0"

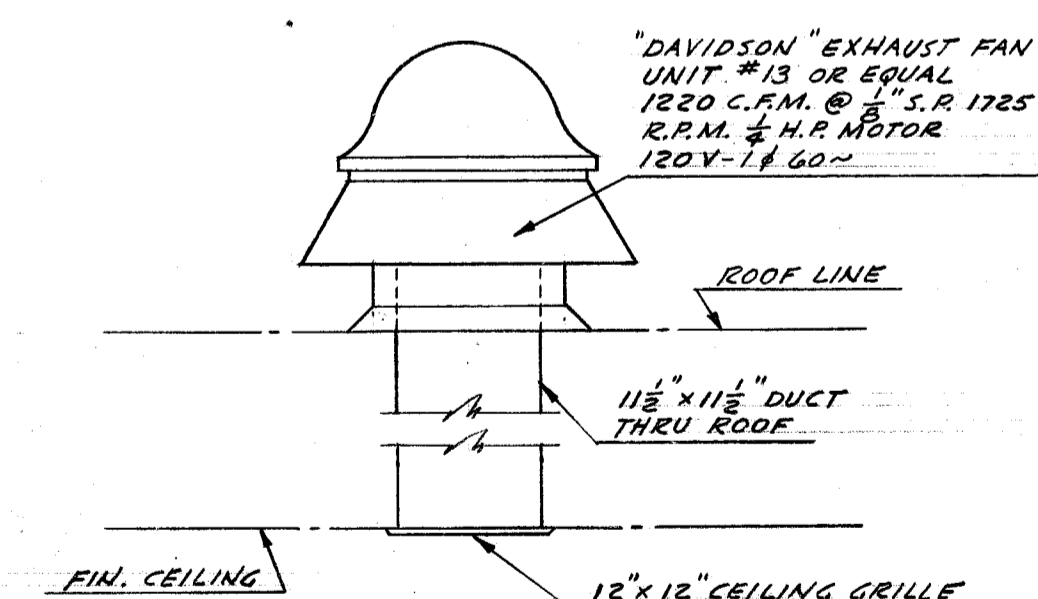

SECTION - P - P
SCALE 3/8" = 1'-0"

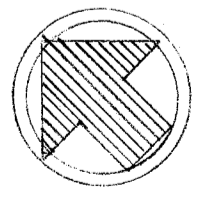

DIVISION OF ARCHITECTURE
STATE OF CALIFORNIA - DEPARTMENT OF PUBLIC WORKS
DIVISION OF ARCHITECTURE
11305 APPROVED OCT 7 1953
D. W. H. [Signature]

W. A. STAINS
CONSULTING ENGINEER
1603 CALIFORNIA AVENUE
BAKERSFIELD, CALIFORNIA
MECHANICAL 5305 ELECTRICAL 4205

BOARD OF EDUCATION
J. L. [Signature] PRES.
Virginia C. Bellinger SEC.

HEATING & VENTILATING
FLOOR PLAN - KITCHEN
UNIT ONE
REAL ROAD SCHOOL
BAKERSFIELD CALIFORNIA

Whitney Biggar
WHITNEY BIGGAR ARCHITECT
MEMBER AMERICAN INSTITUTE OF ARCHITECTS
3601 STOCKDALE HIGHWAY
BAKERSFIELD, CALIFORNIA
29285 REGISTRATION C-1128

PROJECT NO. 6-53
DRAWN BY:
CHECKED BY:
DATE: 9/4/53
SHEET M-9
OF 56