


**SITE FIRE ALARM PLAN NOTES**

- 1 PULL NEW CABLES IN EXISTING CONDUIT. PULL PAST EXISTING CABLES.
- 2 SAWCUT AND REPAIR TO MATCH EXISTING. BORING IS AN ACCEPTABLE METHOD OF CONDUIT INSTALLATION. PROVIDE METHOD OF PROCEDURE FOR BORING TO ENGINEER FOR REVIEW AND APPROVAL. DETAIL BORING PROCEDURE. IDENTIFY TYPE OF CONDUIT TO BE USED IN BORE.

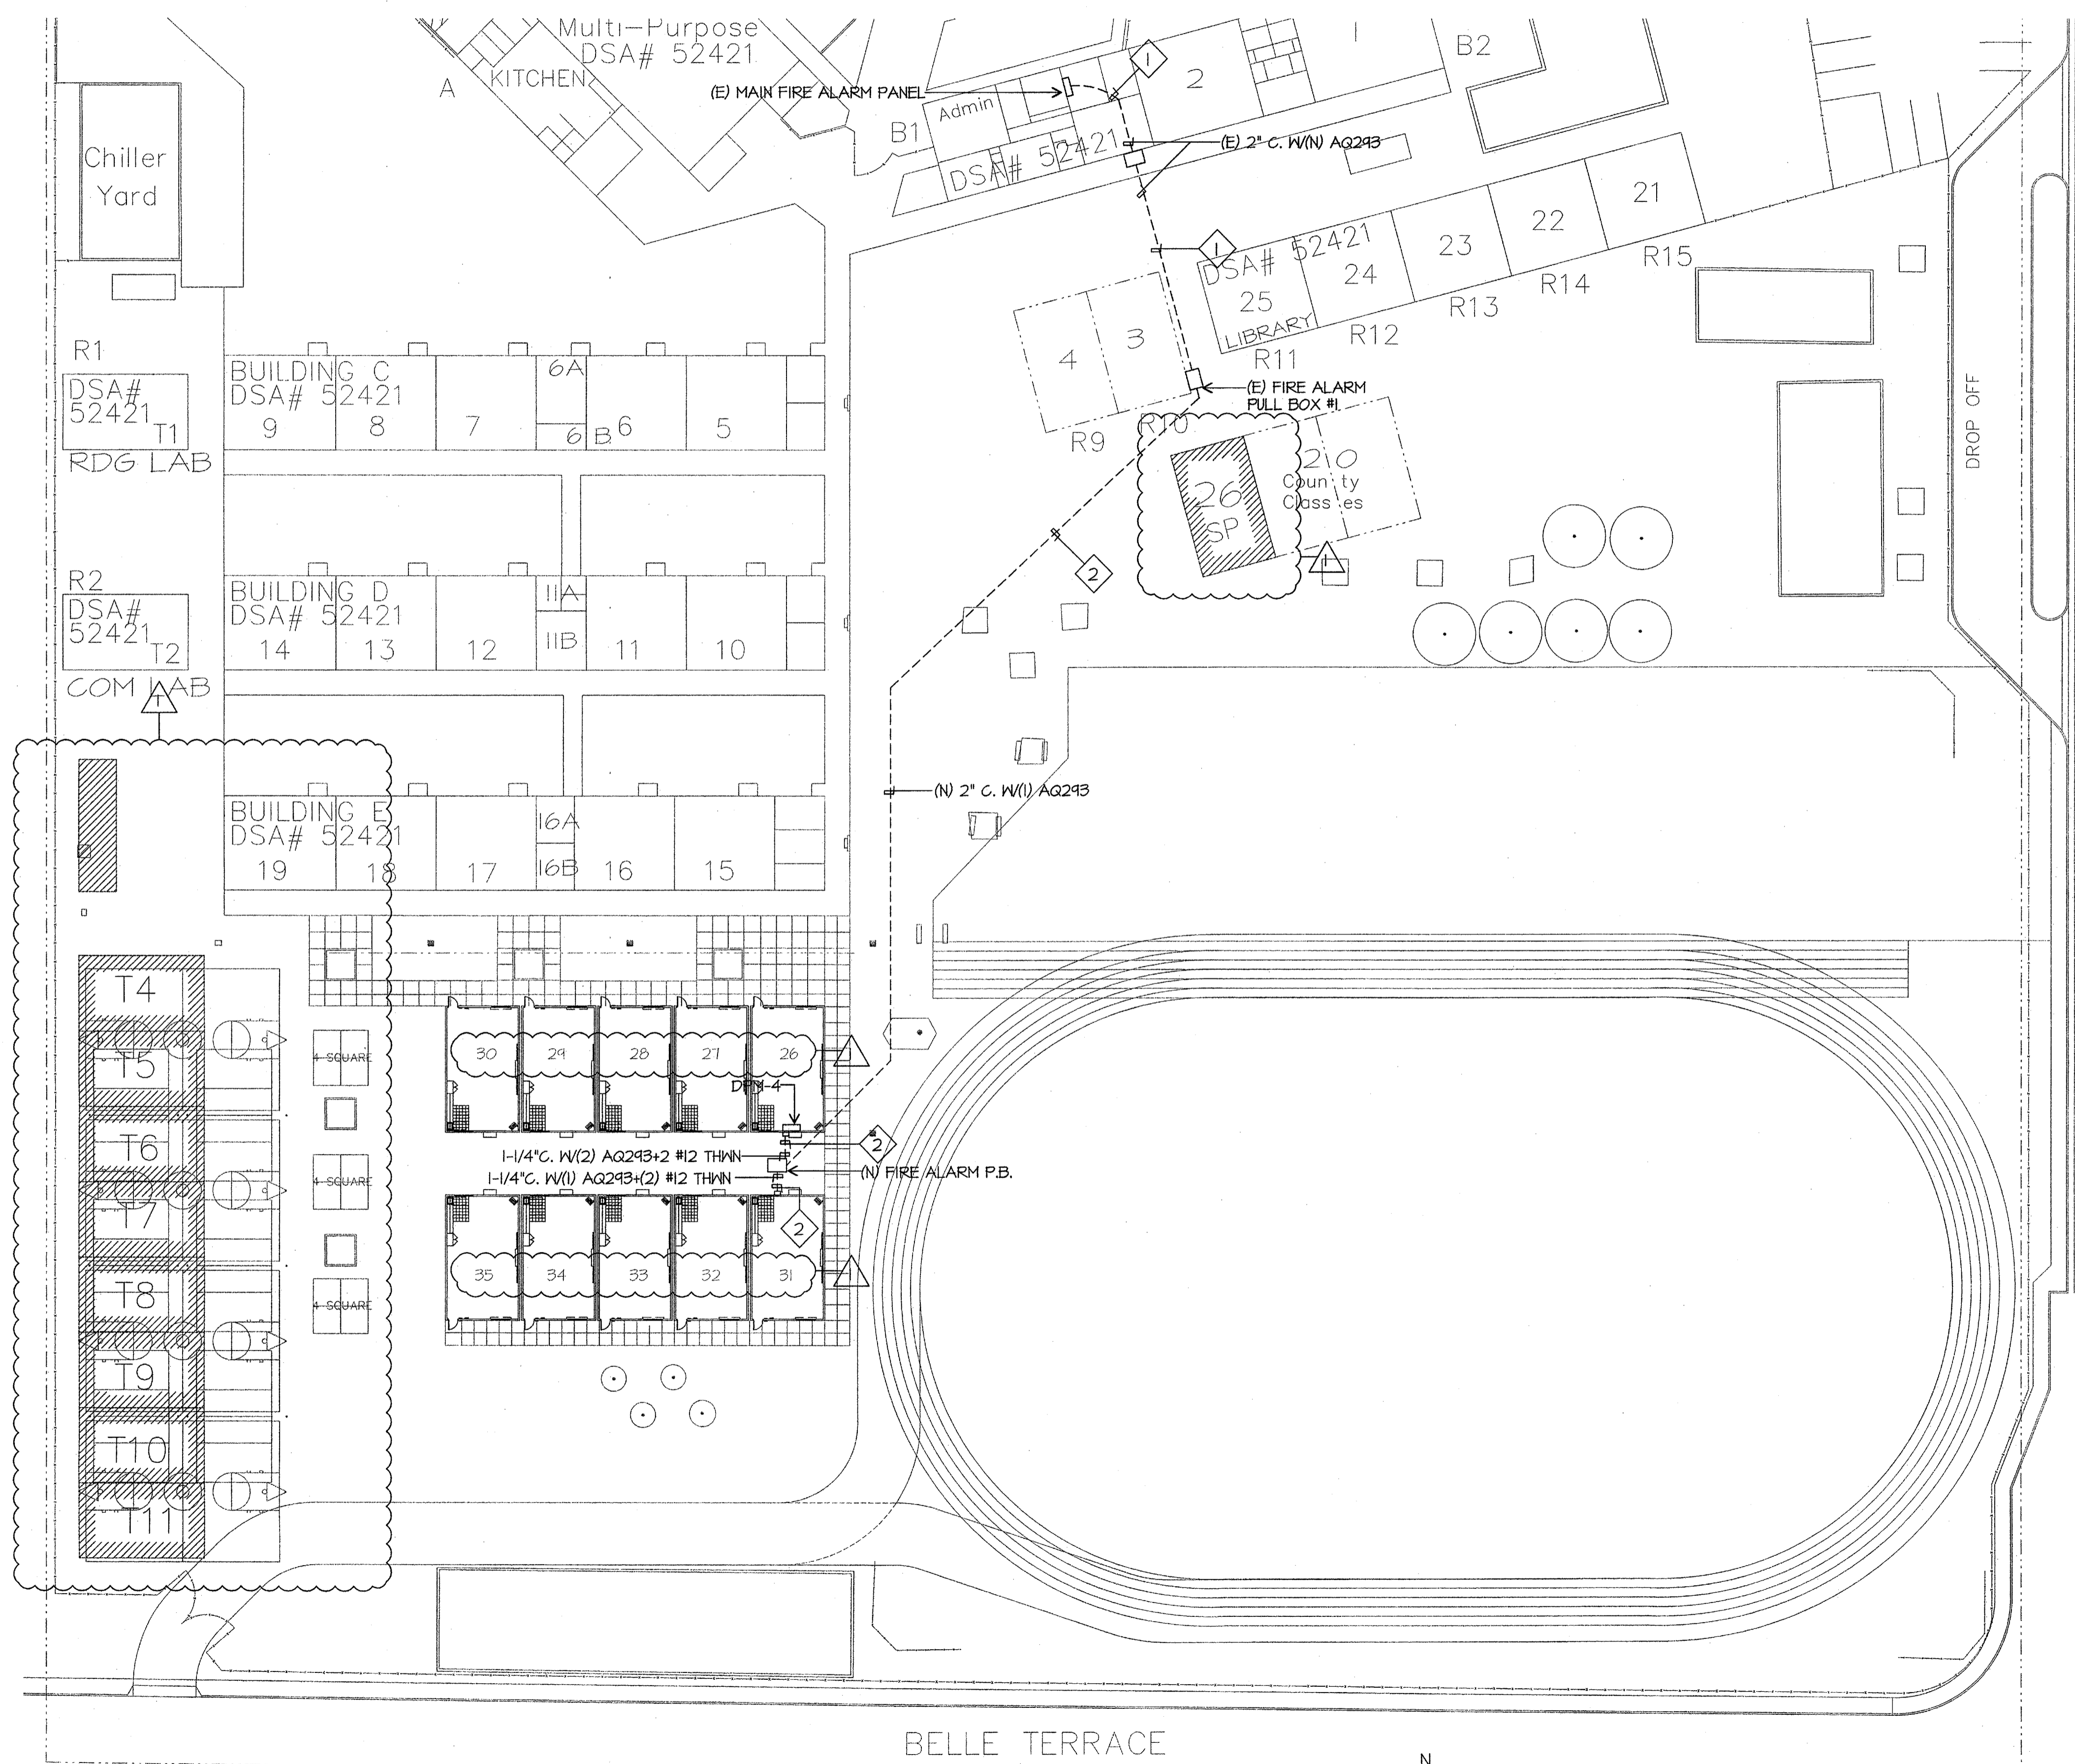

SITE FIRE ALARM PLAN

SCALE: 1"=30'-0"

**integrated designs** by SOMAM, Inc.  
 ARCHITECTURE • INTERIOR DESIGN • CONSTRUCTION MANAGEMENT  
 8011 N. Fresno, Suite 130 - Fresno, California 93710  
 Phone (559) 336-0881 Fax (559) 336-0887 E-Mail: design@somam.com  
 www.integrateddesigns.com

Revision Description:	ADDENDUM 1
Revision:	10/16/09
Rev. Date:	

**SITE FIRE ALARM PLAN**

**MUNSEY ELEMENTARY SCHOOL**  
**10 NEW PORTABLE CLASSROOMS**  
 BAKERSFIELD CITY SCHOOL DISTRICT  
 3801 BRAVE AVE. BAKERSFIELD, CA 93309

Issue Date: 05/02/06  
 Designer: DESIGNER  
 Drafter: DRAFTER  
 P.C.: CJM

DSA Identification Stamp:

Stamp(s):

Job No.: **3832**

Sheet No.: **E-3**

Released: **ADDENDUM 1**  
 CURTIS MCNALLY



**JMPE**  
 ELECTRICAL ENGINEERING  
 LIGHTING DESIGN  
 CA REGISTRATION NO. 813043  
 6500 MIRO AVENUE, SUITE 201, BAKERSFIELD, CA 93309  
 (805) 833-7844 FAX (805) 833-7843  
 www.jmpe.net